


16.207212

**CORRIB**  
natural gas

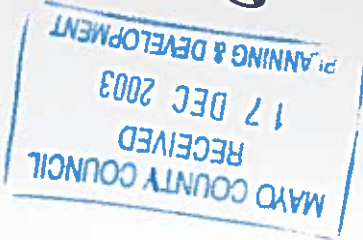

For inspection purposes only.  
Consent of copyright owner required for any other use.

## Corrib Gas Field Development

TIME 31 Dec 2003

LTR. DATED Sub Mar

PL

### Planning Application

In respect of proposed Bellanaboy  
Bridge Gas Terminal, Bellanaboy Bridge,  
Bellagelly South, Co. Mayo and  
associated Srahmore Peat Deposition  
Site, Bangor Erris, Co. Mayo

| Company | Drawing Title                                   | Scale (1: ) | Size | Shell Drawing No. | Vol |
|---------|-------------------------------------------------|-------------|------|-------------------|-----|
|         | <b>Sales Gas Compressor Building</b>            |             |      |                   |     |
| AMEC    | SALES GAS COMPRESSOR BUILDING - FLOOR PLAN      | 100         | A1   | COR-AM-BU-015     | 6   |
| AMEC    | SALES GAS COMPRESSOR BUILDING - ROOF PLAN       | 100         | A1   | COR-AM-BU-016     | 6   |
| AMEC    | SALES GAS COMPRESSOR BUILDING ELEVATION - NORTH | 100         | A1   | COR-AM-BU-017     | 6   |
| AMEC    | SALES GAS COMPRESSOR BUILDING ELEVATION - EAST  | 100         | A1   | COR-AM-BU-018     | 6   |
| AMEC    | SALES GAS COMPRESSOR BUILDING ELEVATION - SOUTH | 100         | A1   | COR-AM-BU-019     | 6   |
| AMEC    | SALES GAS COMPRESSOR BUILDING ELEVATION - WEST  | 100         | A1   | COR-AM-BU-020     | 6   |
| AMEC    | SALES GAS COMPRESSOR BUILDING - SECTIONS        | 100         | A1   | COR-AM-BU-021     | 6   |
| AMEC    | SALES GAS COMPRESSOR BUILDING - SECTIONS        | 100         | A1   | COR-AM-BU-022     | 6   |
|         | <b>Waste Water Treatment Building</b>           |             |      |                   |     |
| AMEC    | WASTE WATER TREATMENT BUILDING - ROOF PLAN      | 100         | A1   | COR-AM-BU-023     | 6   |
| AMEC    | WASTE WATER TREATMENT BUILDING - ELEVATIONS     | 100         | A1   | COR-AM-BU-024     | 6   |
| AMEC    | WASTE WATER TREATMENT BUILDING - ELEVATIONS     | 100         | A1   | COR-AM-BU-025     | 6   |
| AMEC    | WASTE WATER TREATMENT BUILDING - SECTIONS       | 100         | A1   | COR-AM-BU-026     | 6   |
| AMEC    | WASTE WATER TREATMENT BUILDING - FLOOR PLANS    | 100         | A1   | COR-AM-BU-027     | 6   |

Consent for inspection purposes only.  
 Copyright owner required for any other use.

17 DEC 2003  
 PLANNING & DEVELOPMENT  
 703/3343

AN LA  
 TIME 31 March 2004  
 LTR. DATE PL FROM

1 Sales Gas Compressor Building

2 Waste Water Treatment Building

For inspection purposes only.  
Consent of copyright owner required for any other use.

703/3343

|            |             |
|------------|-------------|
| AN BC      | ALA         |
| TIME       | 31 MAY 2004 |
| LTR.-DATED | 5-0304      |
| PL         |             |

Art.No.: 6251




4 021627 062512

Made in Germany


On the original these are centimetre dimensions

FLOOR PLAN

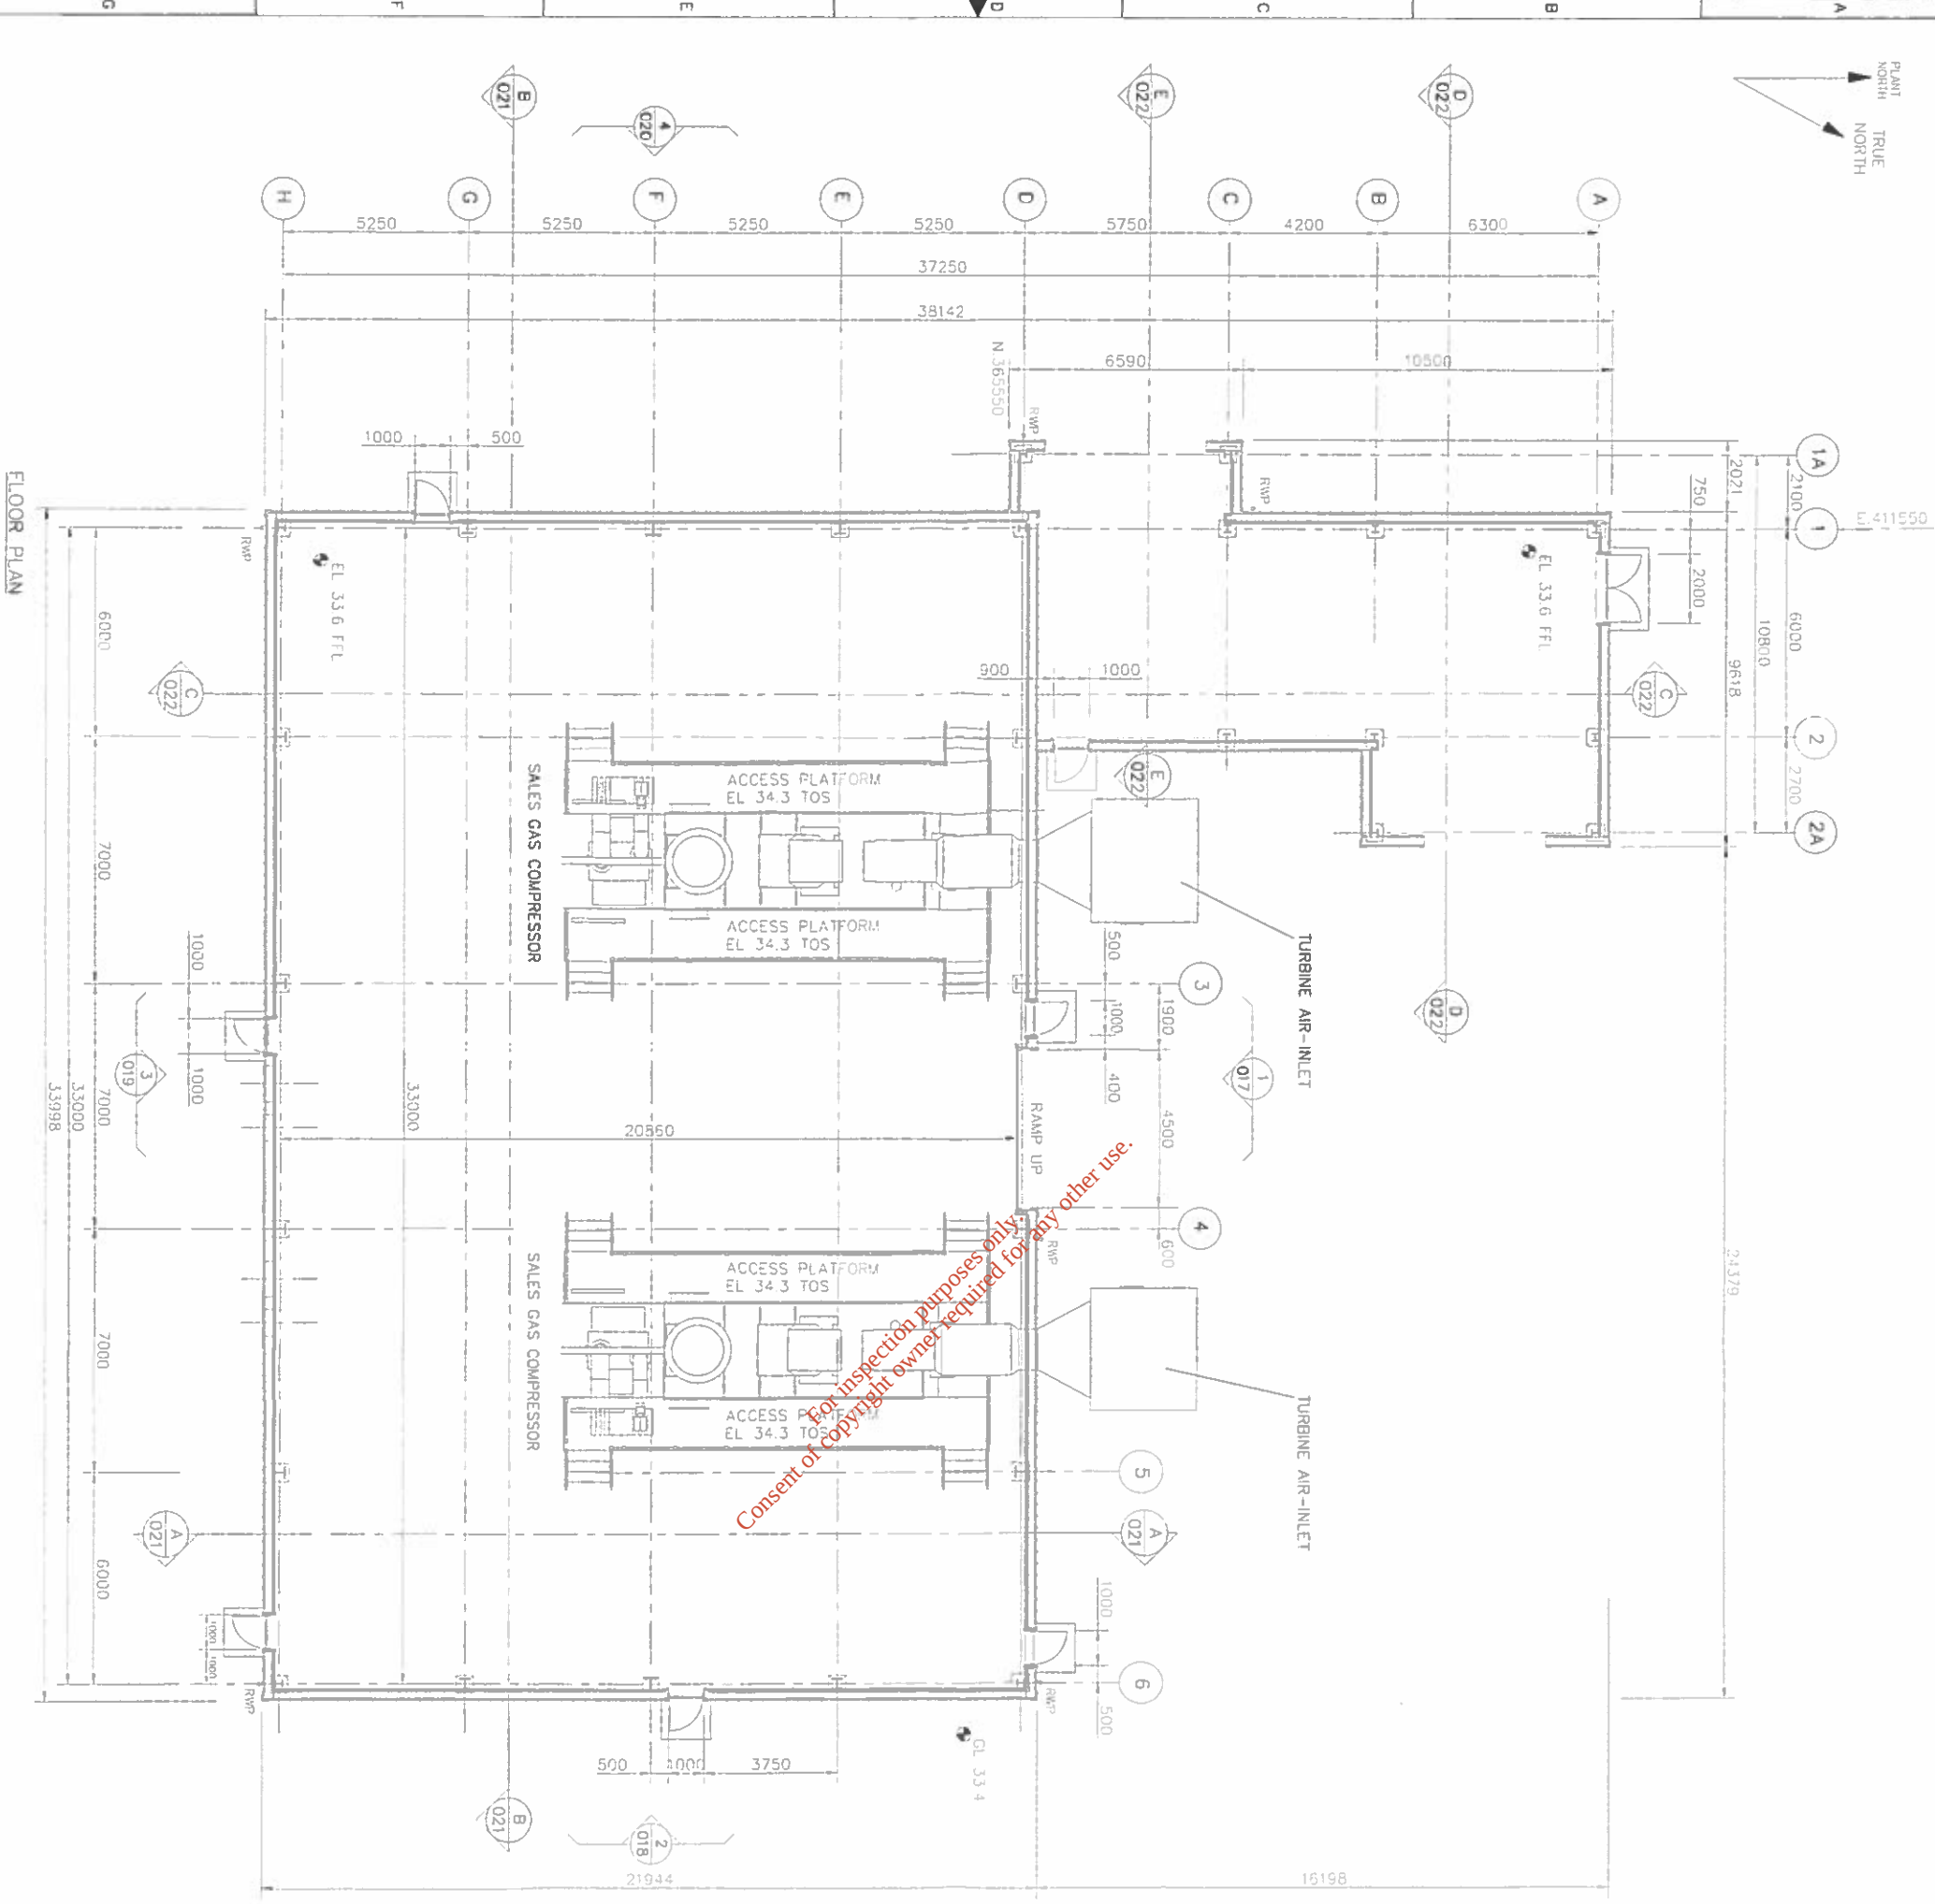

NOTES

1. SITE DATUM E100000, N1000000  
EQUALS ORDINANCE DATUM (MALIN)  
E86525475 4332799575
  2. ALL DIMENSIONS ARE IN METRES AND  
ALL ELEVATIONS ARE IN METRES AOD
- SECTION  
OR ELEVATION  
DWG. No. 017 ON SHELL DRG No COR-AM-BU-017  
(TYP.)
3. DO NOT SCALE
  4. USE GIVEN DIMENSIONS ONLY
- KEY:  
RWP - RAINWATER PIPE

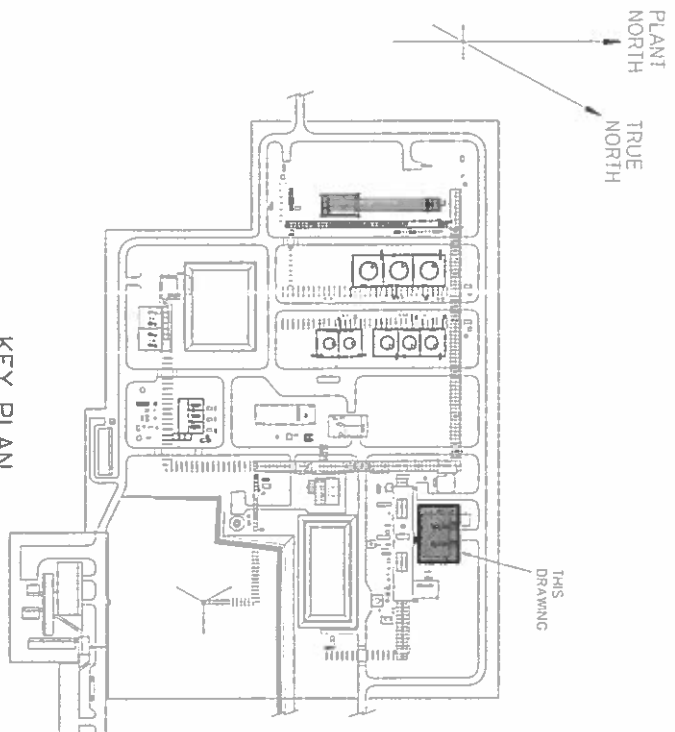

KEY PLAN

1000000  
1100000  
E86525475  
4332799575  
R055343

Corrib Field Development

Bellanboy Bridge Gas Terminal





Corrib  
natural gas

amec  
11 The Bellanboy, Caskey,  
Bellanboy, Co. Wick, Ireland  
Tel: +353 (0)753 51755 Fax: +353 (0)753 3400

SALES GAS COMPRESSOR BUILDING  
FLOOR PLAN

|                          |                    |               |          |
|--------------------------|--------------------|---------------|----------|
| Contract No.             | L3882-030 110 0290 | Sheet No.     | 001      |
| Size                     | A1                 | Drawn by      | R. Smart |
| Checked                  | D. Rotray          | Date          | Nov. 03  |
| For Planning Application |                    | COR-AM-BU-015 |          |

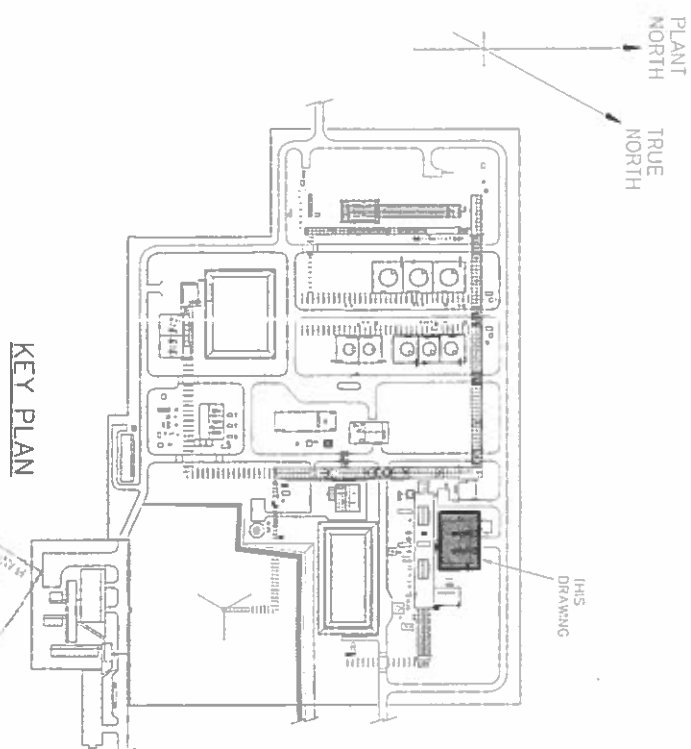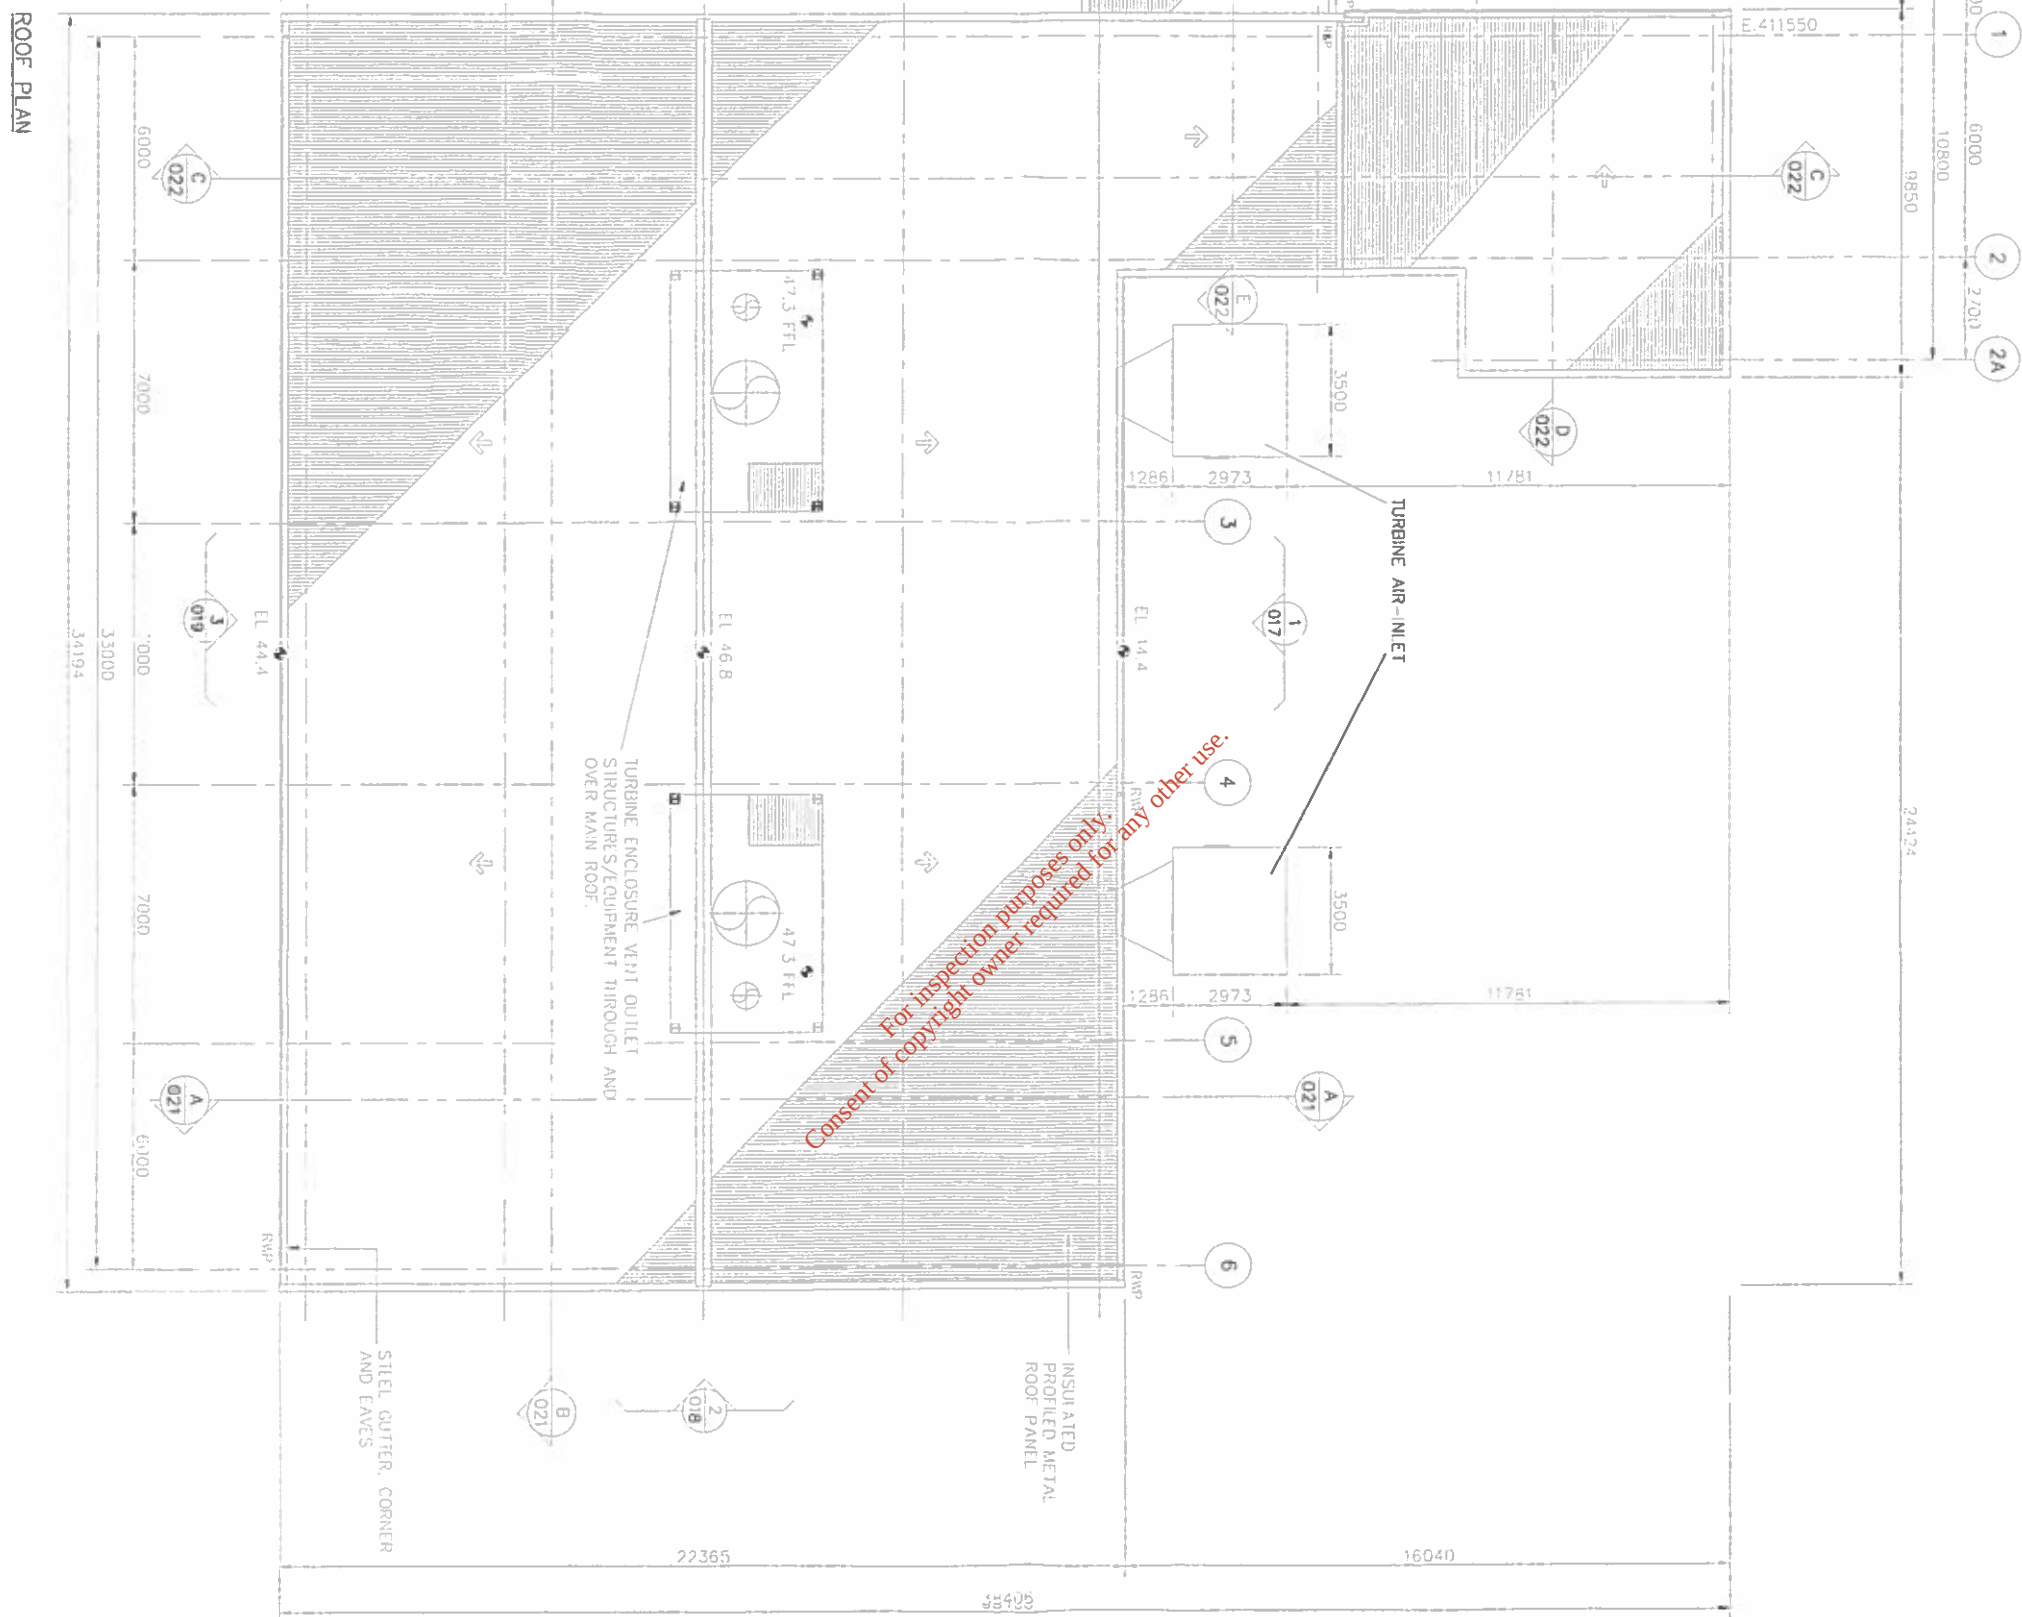

- NOTES**
1. SITE DATUM E100000 N100000  
EQUALS ORDINANCE DATUM (MALIN)  
E863525475 N332799575
  2. ALL DIMENSIONS ARE IN MILLIMETRES  
ALL LEVELS ARE IN METRES AND
- SECTION
- 3 OR ELEVATION
- DWG. No. ---  ON SHELL DRG. No. COR-AM-BU-003  
(TYP.)
4. DO NOT SCALE
- USE GIVEN DIMENSIONS ONLY

KEY:  
RWP - RAINWATER PIPE  
↑ DIRECTION OF SLOPE OF ROOF

|                                                                                                                          |                                      |                                                                                                              |  |
|--------------------------------------------------------------------------------------------------------------------------|--------------------------------------|--------------------------------------------------------------------------------------------------------------|--|
|  <b>Shell E&amp;P Ireland Limited</b> |                                      |                           |  |
| <b>Corrib</b><br>natural gas                                                                                             |                                      | 11 The Boulevard, Clonsilla,<br>West Sussex, RH10 1UX, UK<br>Tel: +44 (0)1293 584001 Fax: +44 (0)1293 584011 |  |
| Drawing Title<br><b>SALES GAS COMPRESSOR BUILDING<br/>         ROOF PLAN</b>                                             |                                      | Sheet No.<br><b>001</b>                                                                                      |  |
| Contractor Drawing No.<br><b>L3882-O30-110-0291</b>                                                                      |                                      | Drawn by<br><b>R. Smart</b>                                                                                  |  |
| Size<br><b>A1</b>                                                                                                        | Scale (on full size)<br><b>1-100</b> | Date<br><b>Nov. 03</b>                                                                                       |  |
| Checked<br><b>D. Rattray</b>                                                                                             | Approved<br><b>S. Cass</b>           | Issue<br><b>Nov. 03</b>                                                                                      |  |
| Issue<br><b>For Planning Application</b>                                                                                 |                                      | Shell Drawing No.<br><b>COR-AM-BU-016</b>                                                                    |  |



## NOTES

**Corib**  
natural gas



**amec**  
11 The Boulevard, Crawley,  
West Sussex, RH10 1UX UK  
Tel: 01293 419700 Fax: 01293 419799



Shell E&P Ireland Limited


Corrib Field Development  
Bellanaboy Bridge Gas Terminal

|                          |                       |         |                  |     |
|--------------------------|-----------------------|---------|------------------|-----|
| Contract - Drawing No.   | L3882-030-110-0292.   |         | Sheet No.        | 001 |
| Size                     | S-size (at full size) |         | Drawn by         |     |
| A1                       | 1-100                 |         | R. Smart         |     |
| Checked by               | Approved              | Date    |                  |     |
| D. Rattray               | S. Cass               | Nov. 03 |                  |     |
| Issue                    |                       |         | Sheet Drawing No |     |
| For Planning Application | COR-AM-BU-017         |         |                  |     |
|                          | 10                    |         |                  |     |

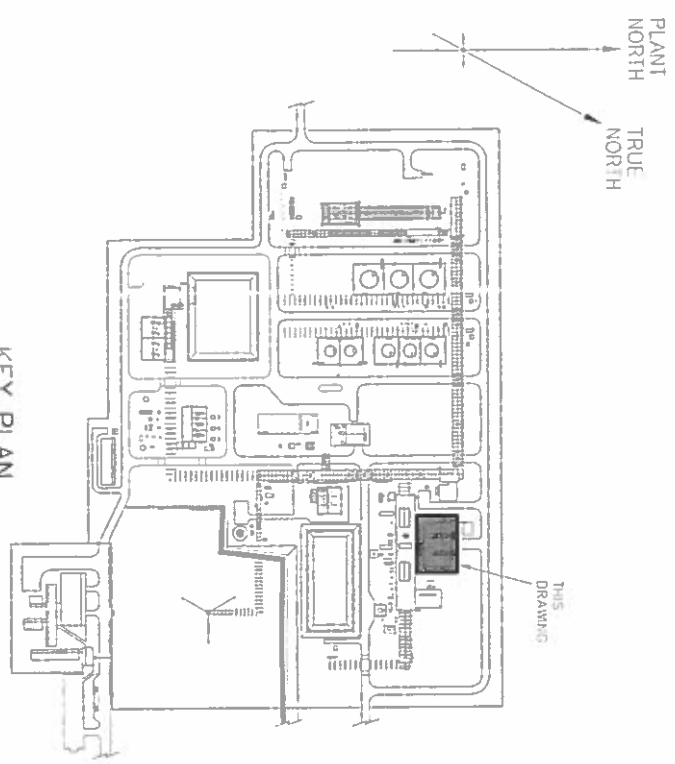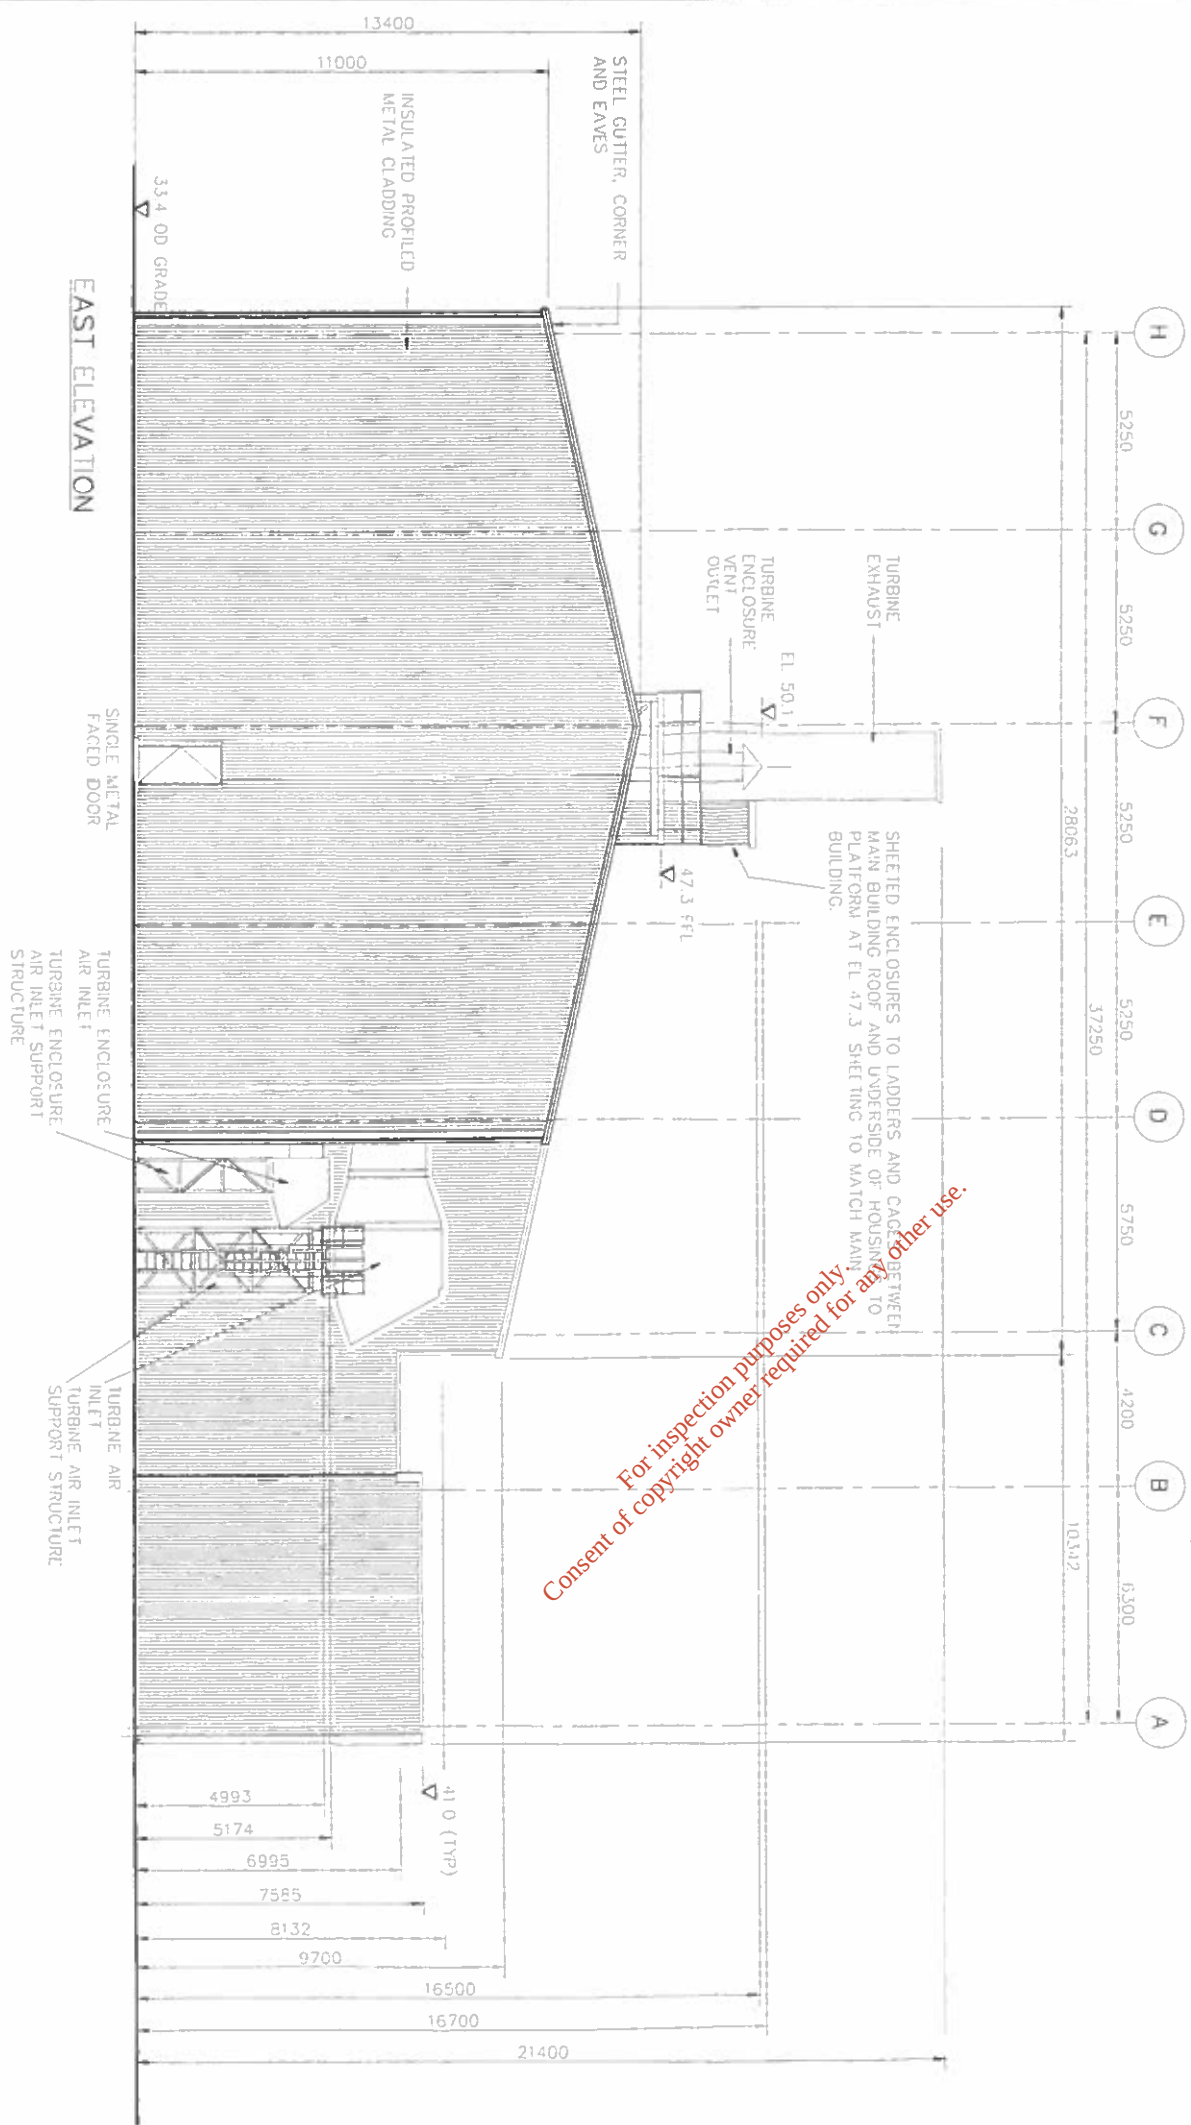


- NOTES**
1. SITE DATUM EL100000, N1000000  
EODALS ORDNANCE DATUM (MALIN)  
E86125475 N332799575
  2. ALL DIMENSIONS ARE IN MILLIMETRES.  
ALL ELEVATIONS ARE IN METRES AOD
  3. DO NOT SCALE  
USE GIVEN DIMENSIONS ONLY

|                                                                            |                             |                                                                                                                           |                                           |
|----------------------------------------------------------------------------|-----------------------------|---------------------------------------------------------------------------------------------------------------------------|-------------------------------------------|
| <b>Corrib Field Development</b>                                            |                             |                                                                                                                           |                                           |
| <b>Bellanaboy Bridge Gas Terminal</b>                                      |                             |                                                                                                                           |                                           |
|                                                                            |                             |                                                                                                                           |                                           |
| <b>Corrib</b><br>natural gas                                               |                             | <b>amco</b><br>11 The Boulevard, Crawley,<br>West Sussex, RH11 1UX, UK<br>Tel: +44 (0)1293 329255 Fax: +44 (0)1293 346001 |                                           |
| Drawing Title<br><b>SALES GAS COMPRESSOR BUILDING<br/>ELEVATION - EAST</b> |                             |                                                                                                                           |                                           |
| Contractor Drawing No.<br><b>L3882-030-110-0292</b>                        | Sheet No.<br><b>002</b>     |                                                                                                                           |                                           |
| Site<br>Scale (at full size)<br><b>A1 1-100</b>                            | Drawn by<br><b>R. Smart</b> |                                                                                                                           |                                           |
| Checked by<br><b>D. Rottroy</b>                                            | Approved<br><b>S. Cass</b>  | Date<br><b>Nov. 03</b>                                                                                                    | Sheet Drawing No.<br><b>COR-AM-BU-018</b> |
| For Planning Application                                                   |                             |                                                                                                                           |                                           |

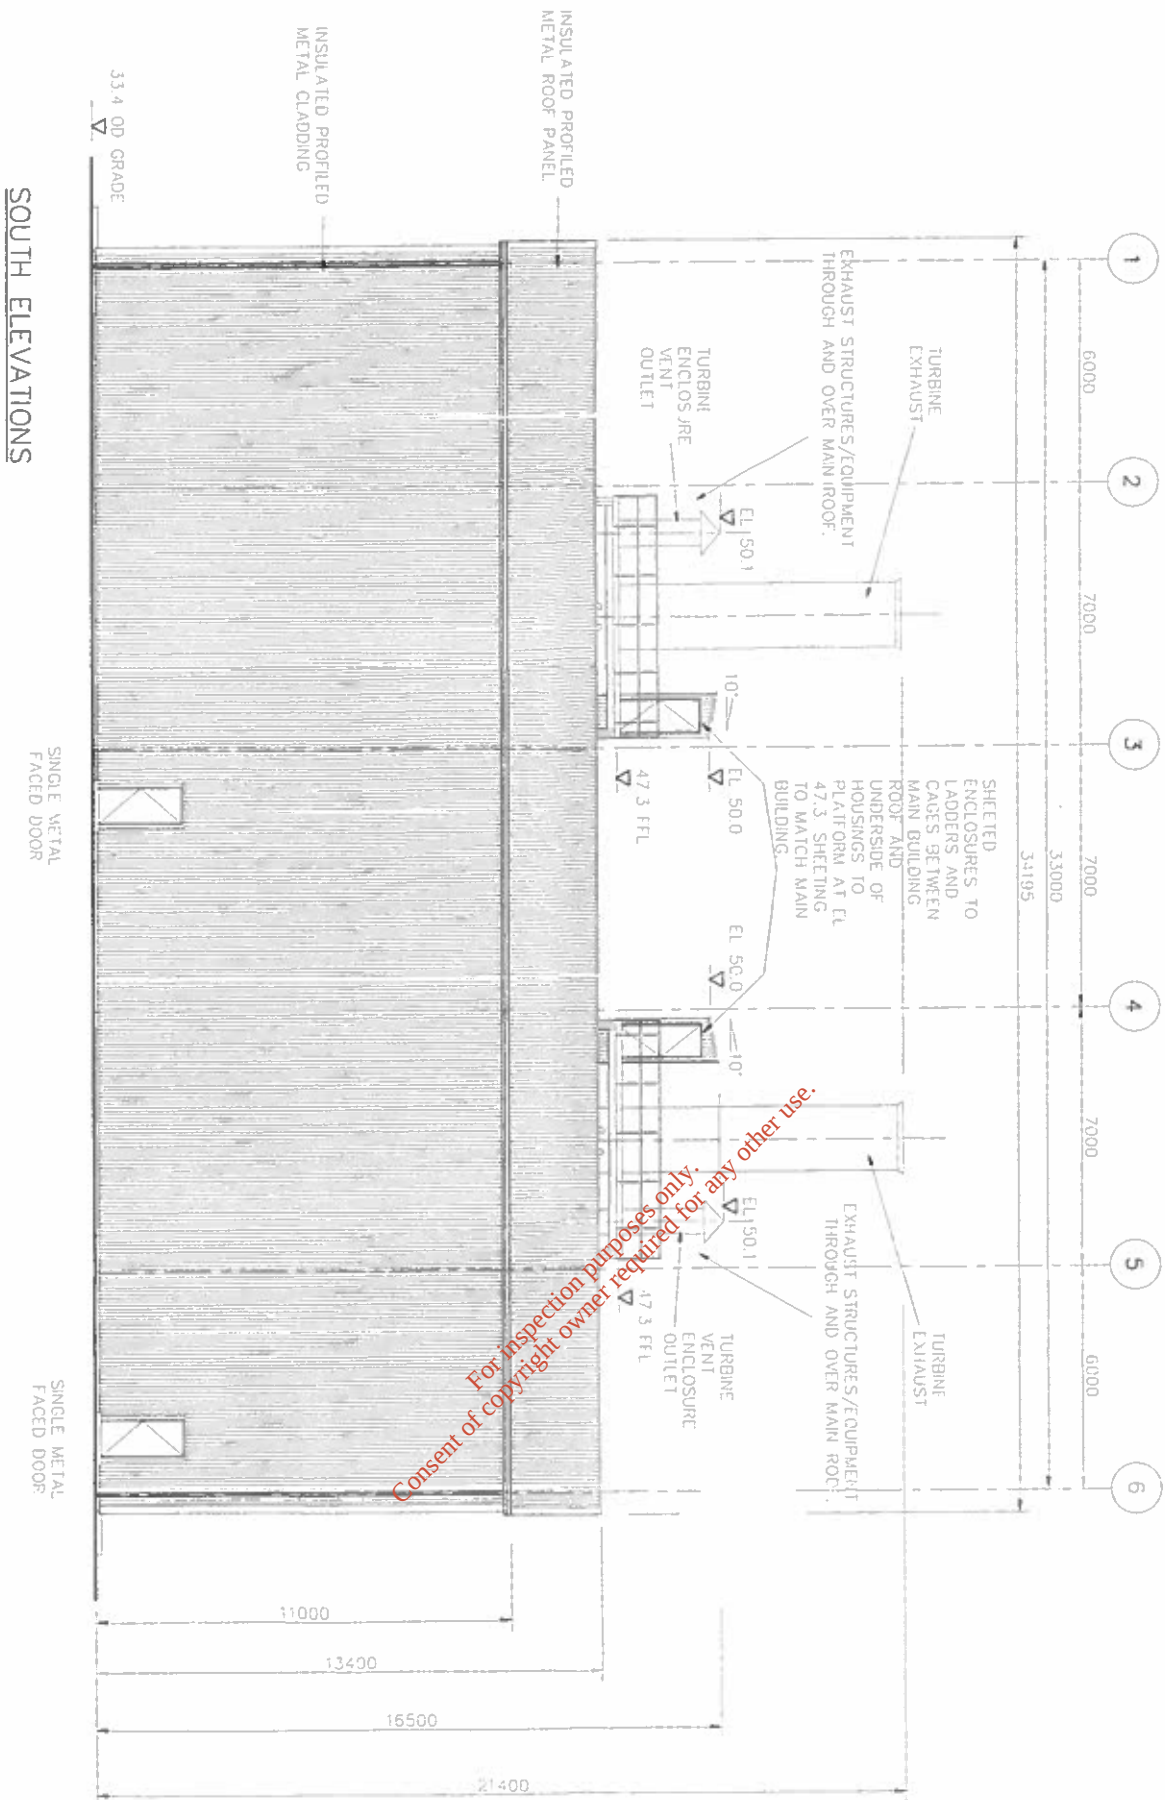

- NOTES**
1. SITE DATUM E100000 N100000  
EQUALS ORDNANCE DATUM (MALIN)  
E86325475 N332799575
  2. ALL DIMENSIONS ARE IN MILLIMETRES  
ALL ELEVATIONS ARE IN METRES AOD
  3. DO NOT SCALE  
USE GIVEN DIMENSIONS ONLY

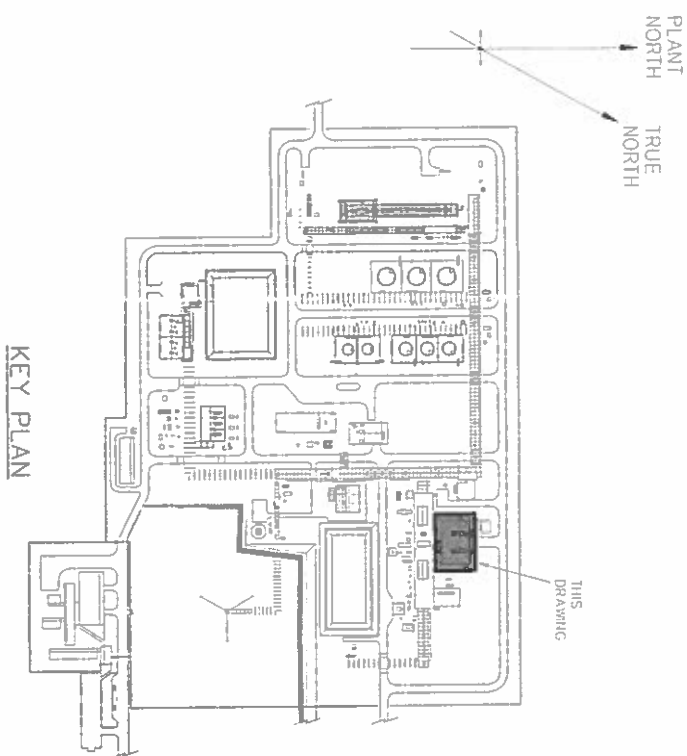

|                                                                                                                          |                      |           |  |
|--------------------------------------------------------------------------------------------------------------------------|----------------------|-----------|--|
|  <b>Shell E&amp;P Ireland Limited</b> |                      |           |  |
| Corrib Field Development                                                                                                 |                      |           |  |
| Bellanaboy Bridge Gas Terminal                                                                                           |                      |           |  |
| Contractor Drawing No                                                                                                    |                      | Sheet No. |  |
| L3882-030-110-0293                                                                                                       |                      | 001       |  |
| Size                                                                                                                     | Scale (at full size) | Drawn by  |  |
| A1                                                                                                                       | 1-100                | R. Smart  |  |
| Check id                                                                                                                 | Approved             | Date      |  |
| D. Rattray                                                                                                               | S.Cass               | Nov. 03   |  |
| Issue                                                                                                                    |                      |           |  |
| Shell Drawing No. COR-AM-BU-019                                                                                          |                      |           |  |
| For Planning Application                                                                                                 |                      |           |  |

Corrib


natural gas

11 The Boulevard, Glenageary, West Sussex, RH10 1UR, UK  
Tel: +44 (0)1293 282001 Fax: +44 (0)1293 282001

amco


Drawing Title

SALES GAS COMPRESSOR BUILDING ELEVATION - SOUTH

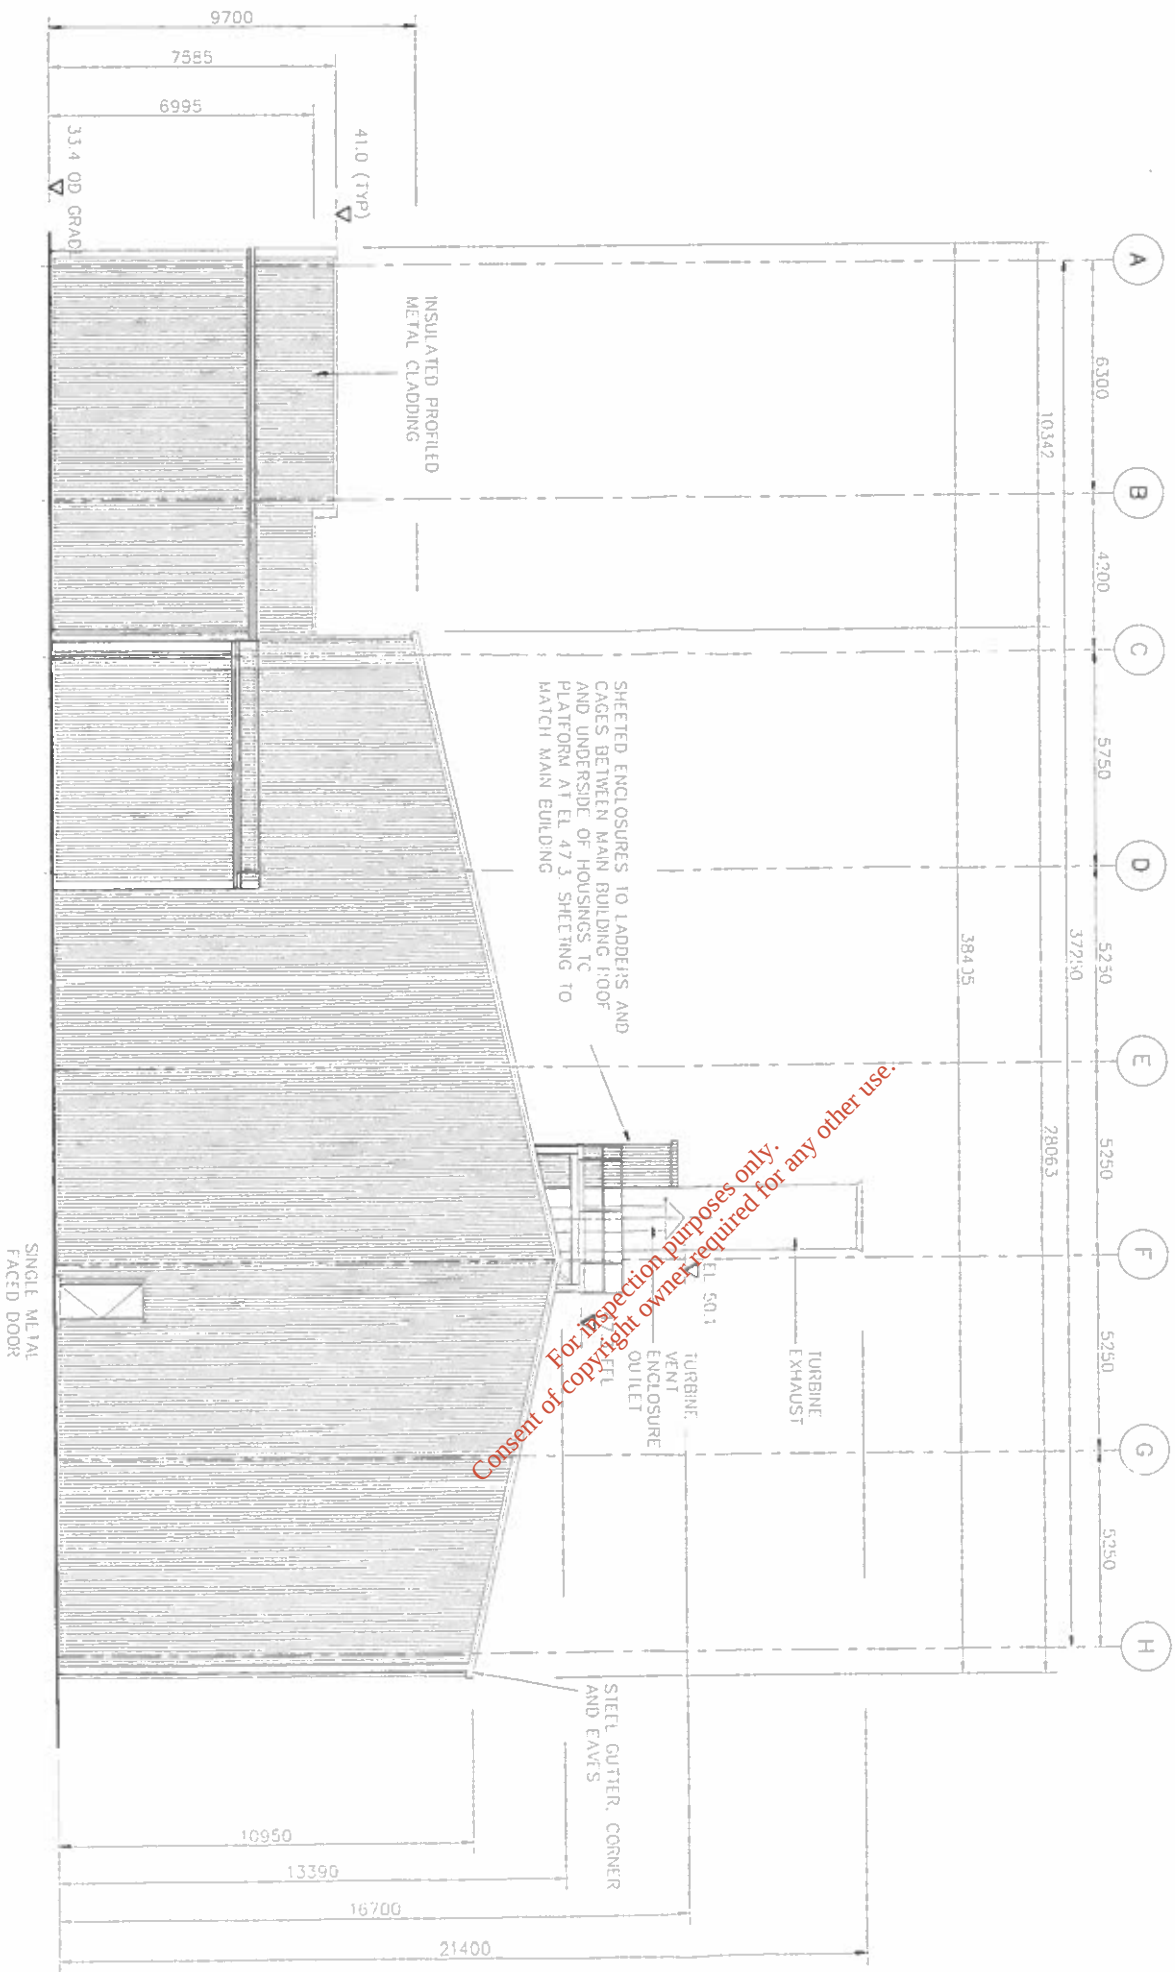


WEST ELEVATION

- NOTES**
1. SITE DATUM E100000 N100000  
EQUALS ORDNANCE DATUM (MALIN)  
E86325475 N332799575
  2. ALL DIMENSIONS ARE IN MILLIMETRES  
ALL ELEVATIONS ARE IN METRES AOD  
DO NOT SCALE  
USE GIVEN DIMENSIONS ONLY

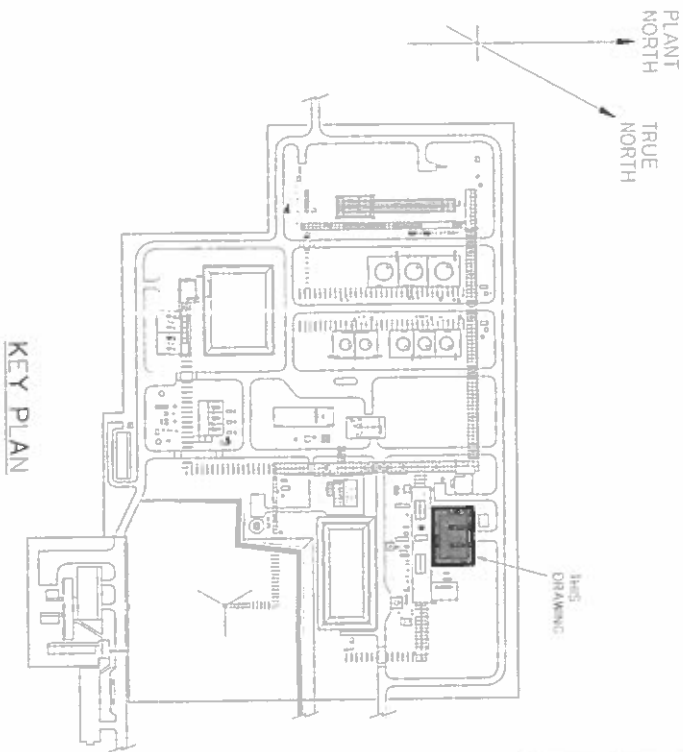


KEY PLAN

|                                                                                                    |                      |                      |         |
|----------------------------------------------------------------------------------------------------|----------------------|----------------------|---------|
| <b>Corrib Field Development</b>                                                                    |                      |                      |         |
| <b>Bellanaboy Bridge Gas Terminal</b>                                                              |                      |                      |         |
| <b>Shell E&amp;P Ireland Limited</b>                                                               |                      |                      |         |
| <b>Corrib natural gas</b>                                                                          |                      | <b>amec</b>          |         |
| 11 The Boulevard, Clonsilla, Dublin 15, Ireland<br>Tel: +353 (0)1 234 2870 Fax: +353 (0)1 234 2871 |                      |                      |         |
| Drawing Title: <b>SALES GAS COMPRESSOR BUILDING ELEVATION - WEST</b>                               |                      |                      |         |
| Contractor Drawing No. <b>L3882-030-110-0293</b>                                                   |                      | Sheet No. <b>002</b> |         |
| Site                                                                                               | Scale (at full size) | Drawn by             | Date    |
| A1                                                                                                 | 1-100                | R. Smart             | Nov. 03 |
| Checked                                                                                            |                      | Approved             |         |
| D. Rattray                                                                                         |                      | S. Cass              |         |
| For Planning Application                                                                           |                      | COR-AM-BU-020        |         |

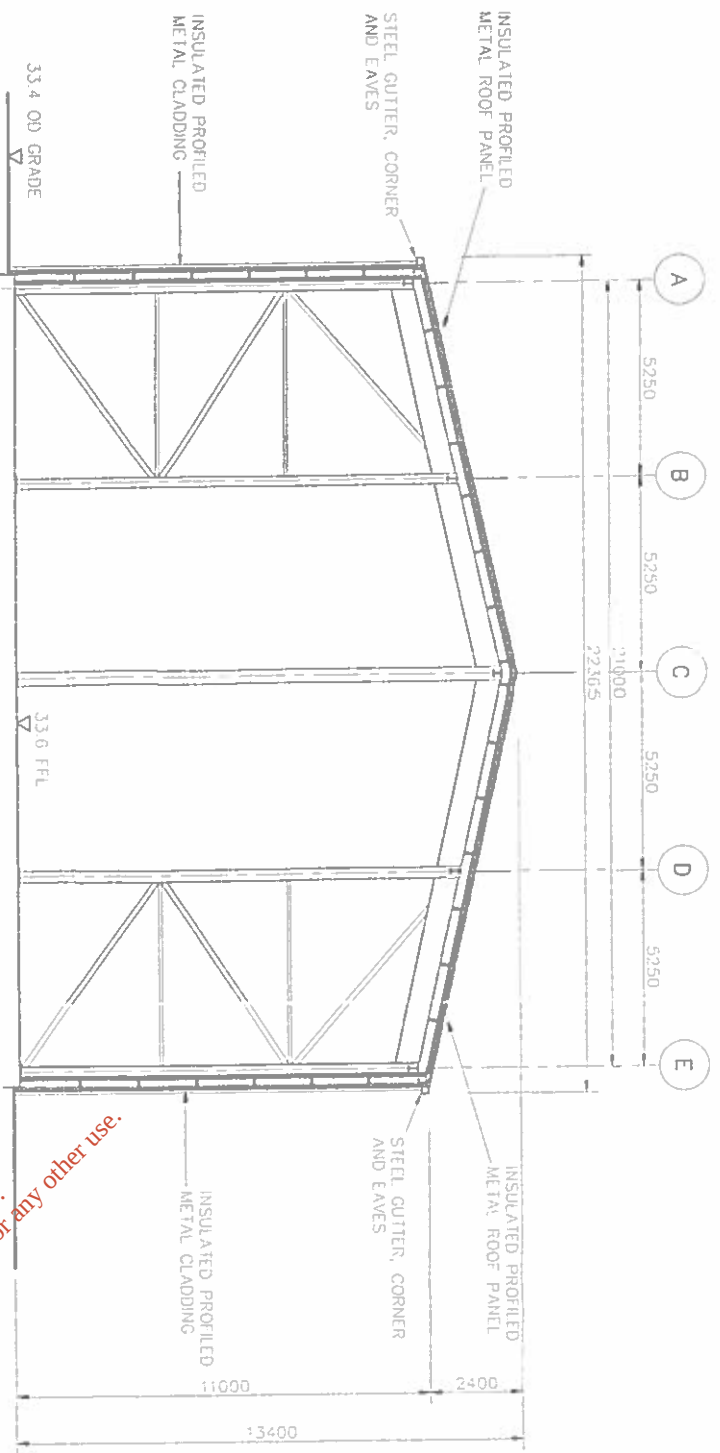


SECTION A-A (LOOKING EAST)

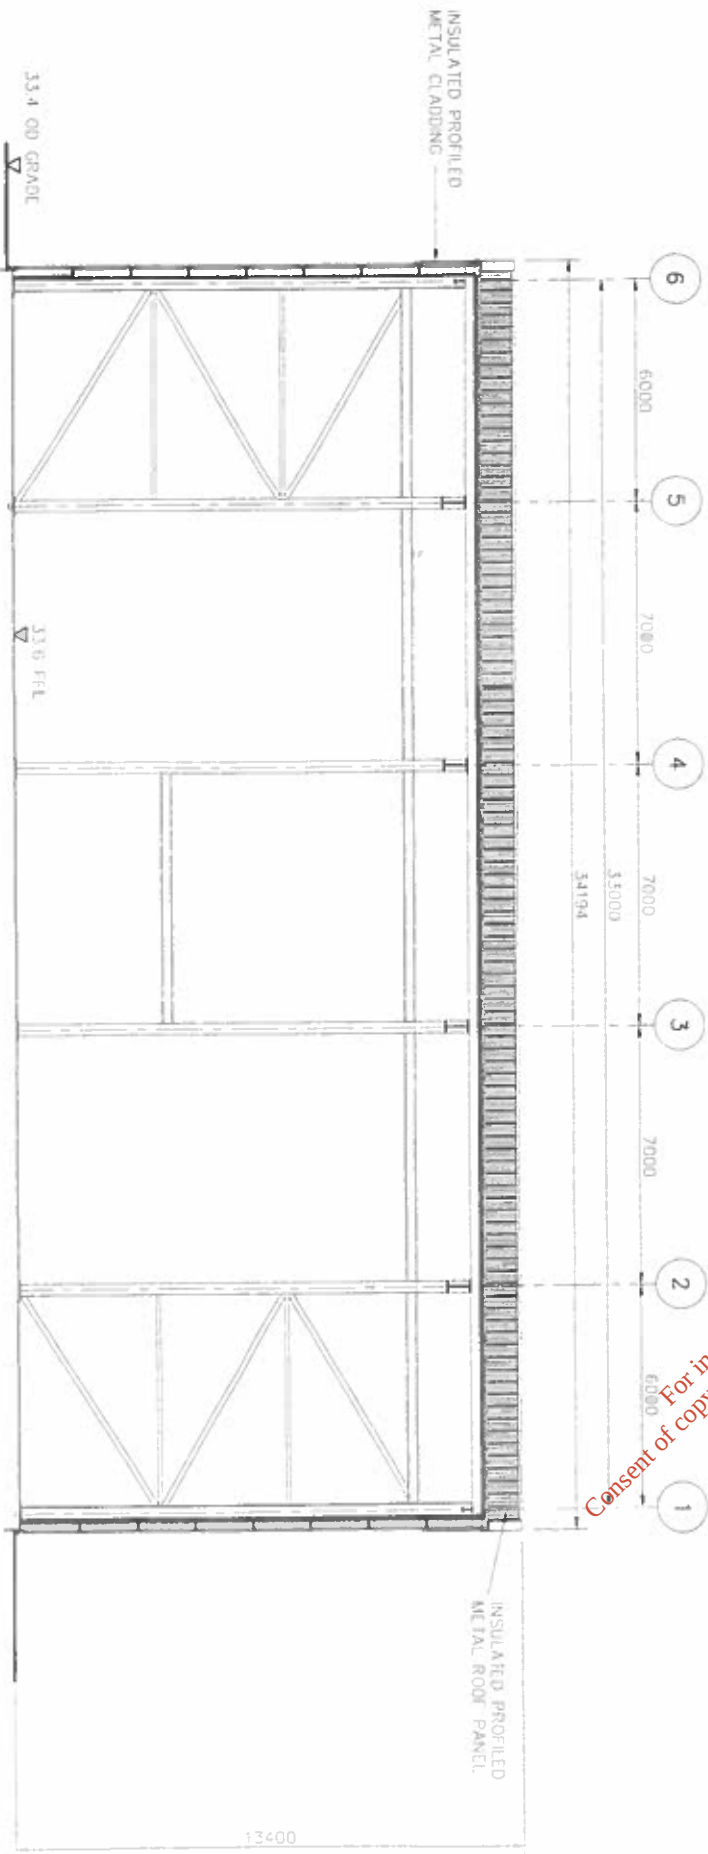

SECTION B-B (LOOKING SOUTH)

For inspection purposes only.  
Consent of copyright owner required for any other use.

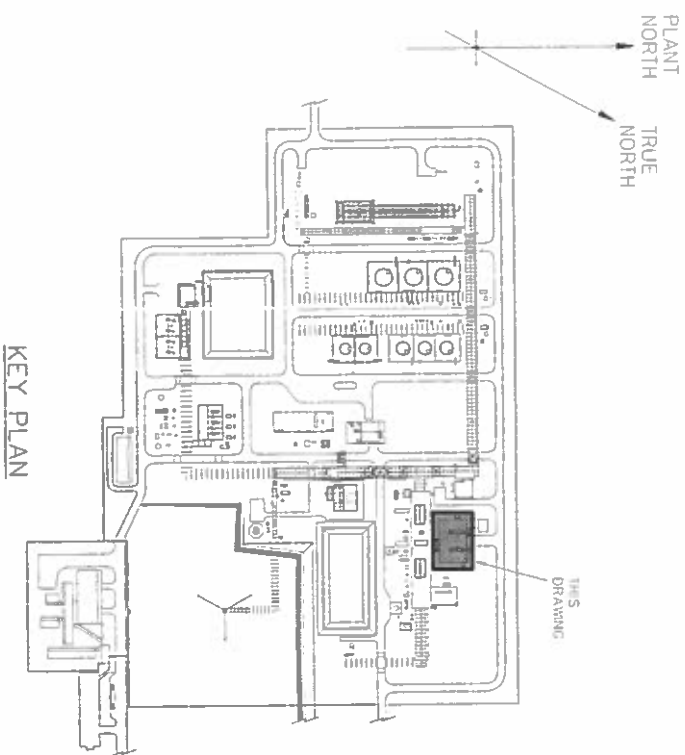

- NOTES
- SITE DATUM E100000 N100000  
EQUALS ORDNANCE DATUM (MALIN)  
E86325475 N332799575
  - ALL DIMENSIONS ARE IN MILLIMETRES.  
ALL ELEVATIONS ARE IN METRES AOD
  - DO NOT SCALE  
USE GIVEN DIMENSIONS ONLY

Corrib Field Development

Bellanaboy Bridge Gas Terminal

Shell E&P Ireland Limited

Corrib natural gas

amec

11 The Boulevard, County Wick  
Newry, Co. Wick, Ireland  
Tel: +353 (0)203 228755 Fax: +353 (0)203 228761

Drawing title

SALES GAS COMPRESSOR BUILDING SECTIONS

Contractor Drawing No.  
L3882-030-110-0294

Sheet No.  
1 of 2

Size  
A1

Scale (at full size)  
1-100

Drawn by  
R. Smart

Checked  
D. Rattray




Approved  
S. Cass

Date  
Nov. 03

Issue


For Planning Application

Issue No.  
COR-AM-BU-021

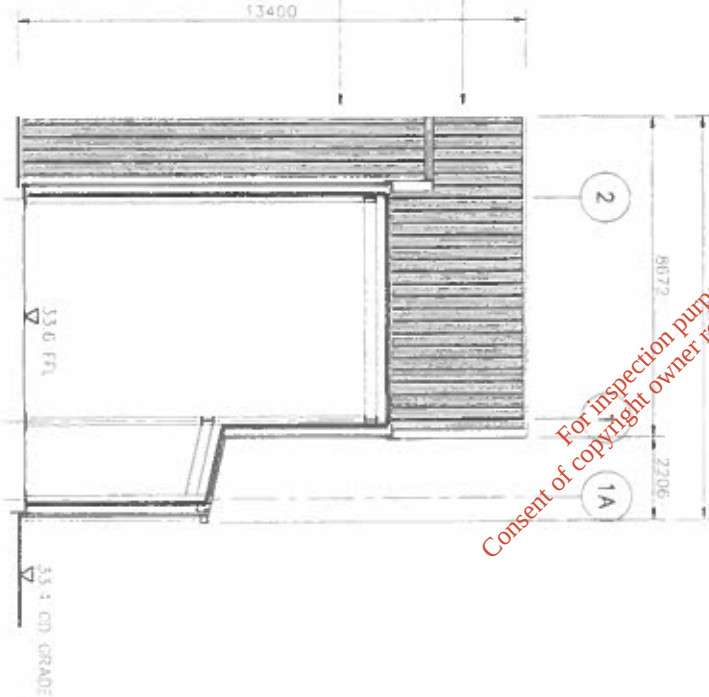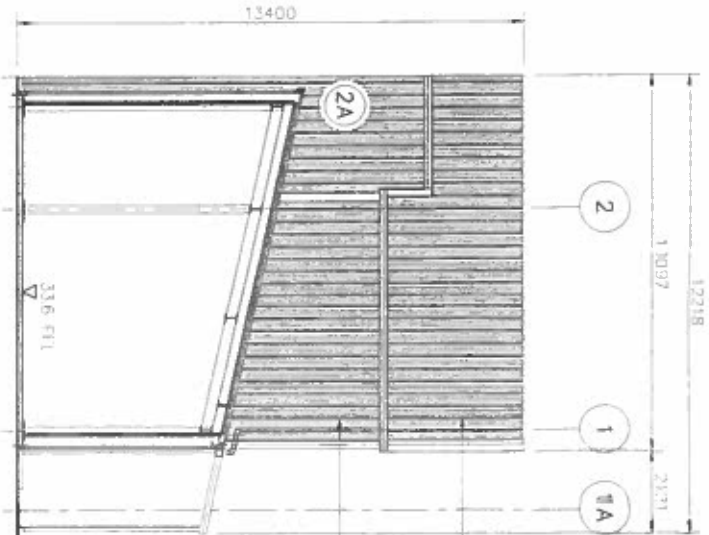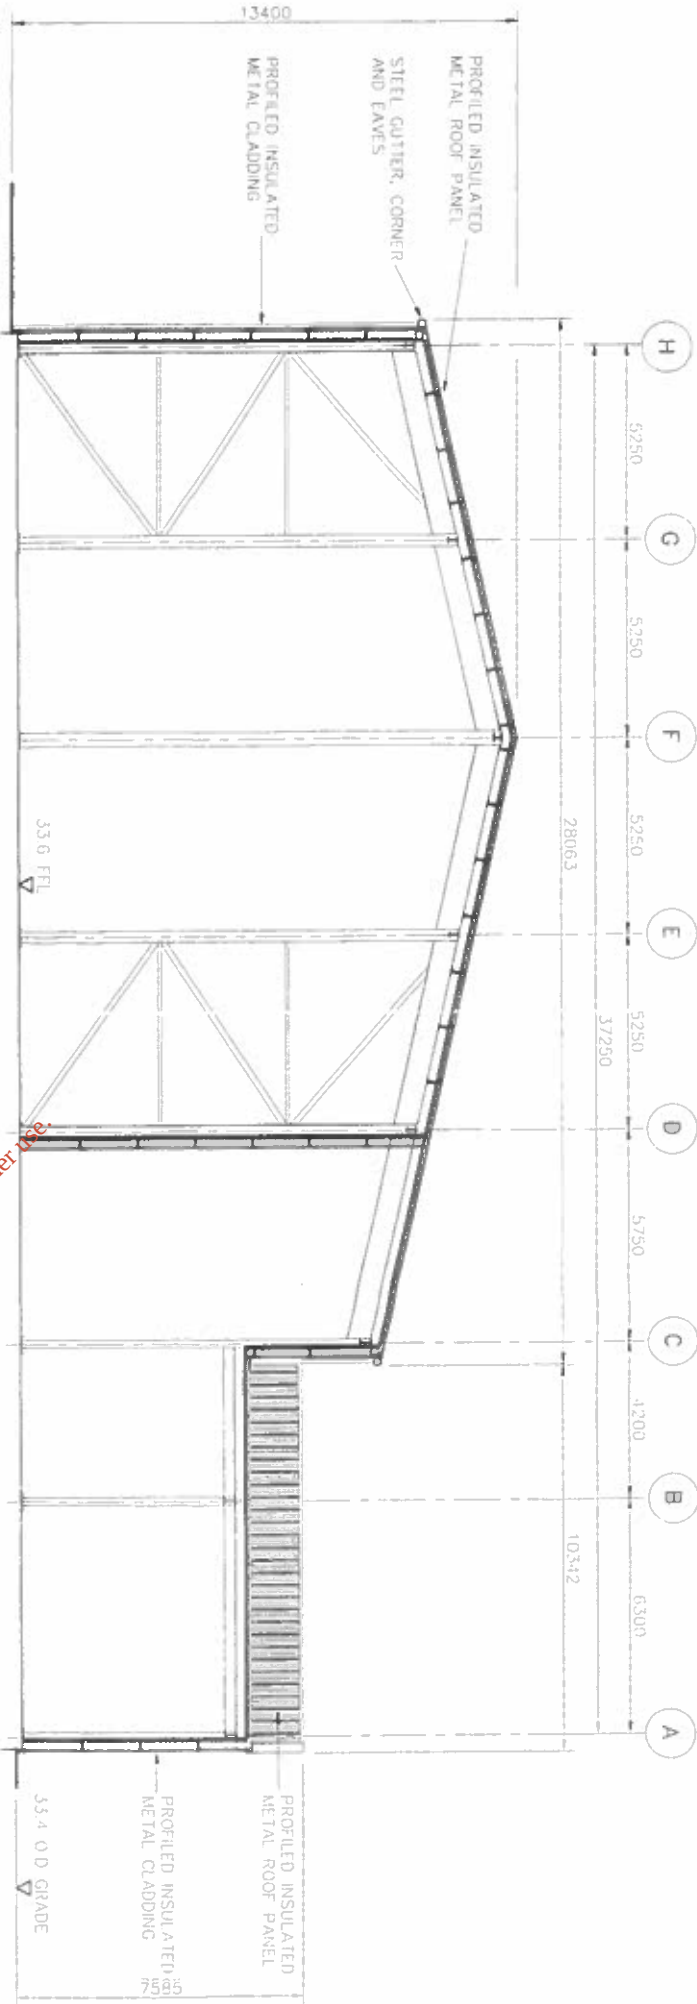

For inspection purposes only.  
Consent of copyright owner required for any other use.

KEY PLAN

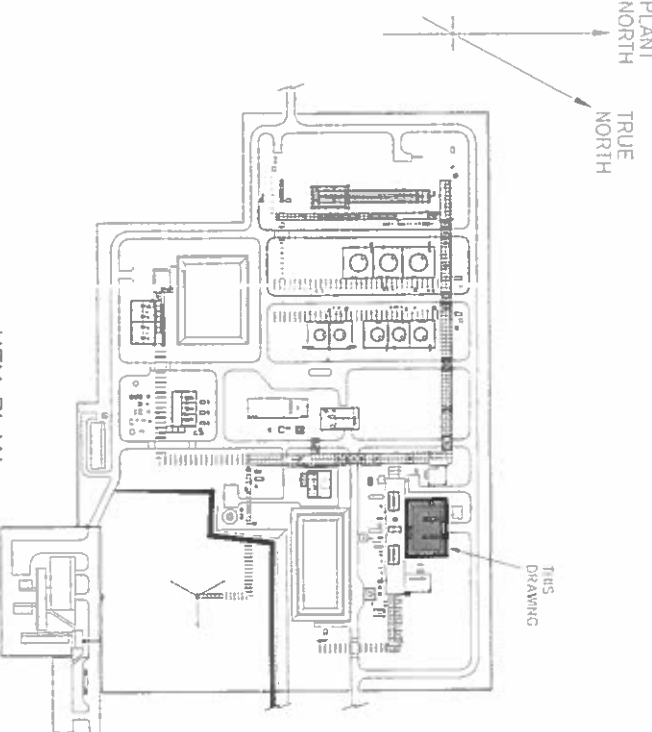



- NOTES
1. SITE DATUM E100000 N100000  
EQUALS ORDNANCE DATUM (MALIN)  
E86 325475 N332799575
  2. ALL DIMENSIONS ARE IN MILLIMETRES.  
ALL ELEVATIONS ARE IN METRES AOD
  3. DO NOT SCALE  
USE GIVEN DIMENSIONS ONLY

|                                |           |
|--------------------------------|-----------|
| Corrib Field Development       |           |
| Bellanaboy Bridge Gas Terminal |           |
| Shell E&P Ireland Limited      |           |
| Contractor Drawing No.         | Sheet No. |
| L3882-030-110-0294             | 2 of 2    |
| Scale (at full size)           | Drawn by  |
| A1                             | R. Smart  |
| Checked                        | Approved  |
| D. Roltroy                     | S. Cass   |
| Date                           | Date      |
| Issue                          | Nov. 03   |
| For Planning Application       |           |
| COR-AM-BU-022                  |           |

Corrib natural gas

amec

11 The Bellanaboy Centre  
West Quay, R110 1UX, UK  
Tel: +44 (0)1753 25755 Fax: +44 (0)1753 26401

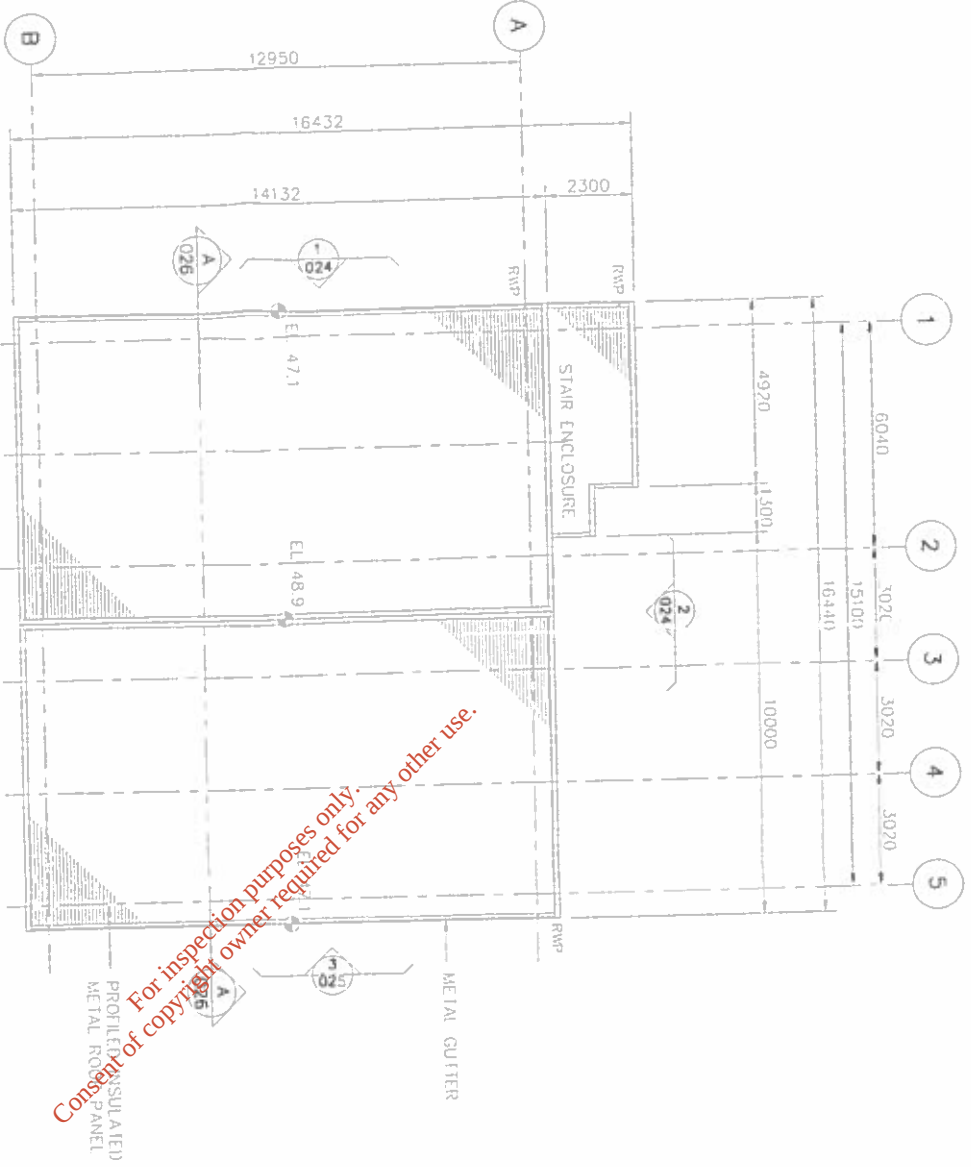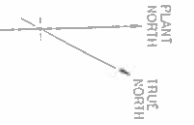


ROOF PLAN

NOTES

1. SITE DATUM E103000 N100000  
EQUALS ORDNANCE DATUM (MALIN)  
E86325475 N532799575
2. ALL DIMENSIONS ARE IN MILLIMETRES.  
ALL ELEVATIONS ARE IN METRES AOD
3. OR ELEVATION  
DWG. No. 1024 ON SHELL DRG No COR-AM-BU-024 (TYP.)
4. DO NOT SCALE  
USE GIVEN DIMENSIONS ONLY

KEY :-  
RWP = RAINWATER PIPE

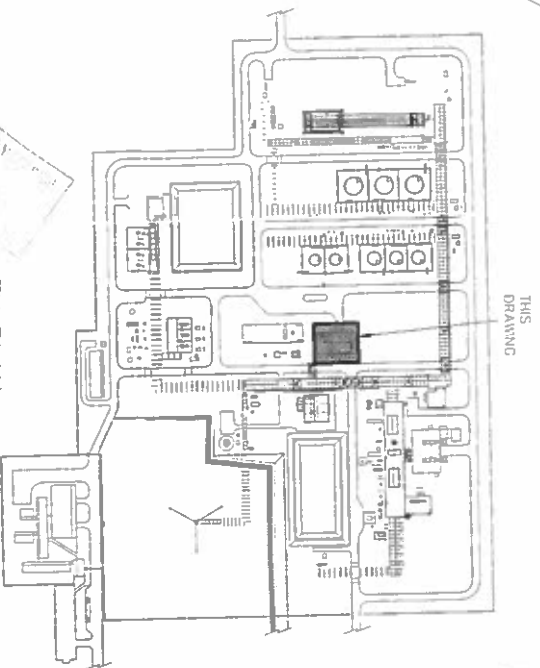

KEY PLAN

Corrib Field Development

Bellanaboy Bridge Gas Terminal




Corrib  
natural gas

amec  
11 The Boulevard, Corrib,  
West Sussex, PO10 1DZ, UK  
Tel: +44 (0)1903 528725 Fax: +44 (0)1903 528601

WASTE WATER TREATMENT BUILDING  
ROOF PLAN

|                       |                          |                      |               |
|-----------------------|--------------------------|----------------------|---------------|
| Contractor Drawing No | L3882-030-110-0385       | Sheet No             | 1 of 2        |
| Size                  | A1                       | Scale (at full size) | 1-100         |
| Checked               | D. Rattray               | Approved             | S. Cass       |
| Issue                 | For Planning Application | Issue                | COR-AM-BU-023 |
| Drawn by              | R. Smart                 | Date                 | Nov. 03       |

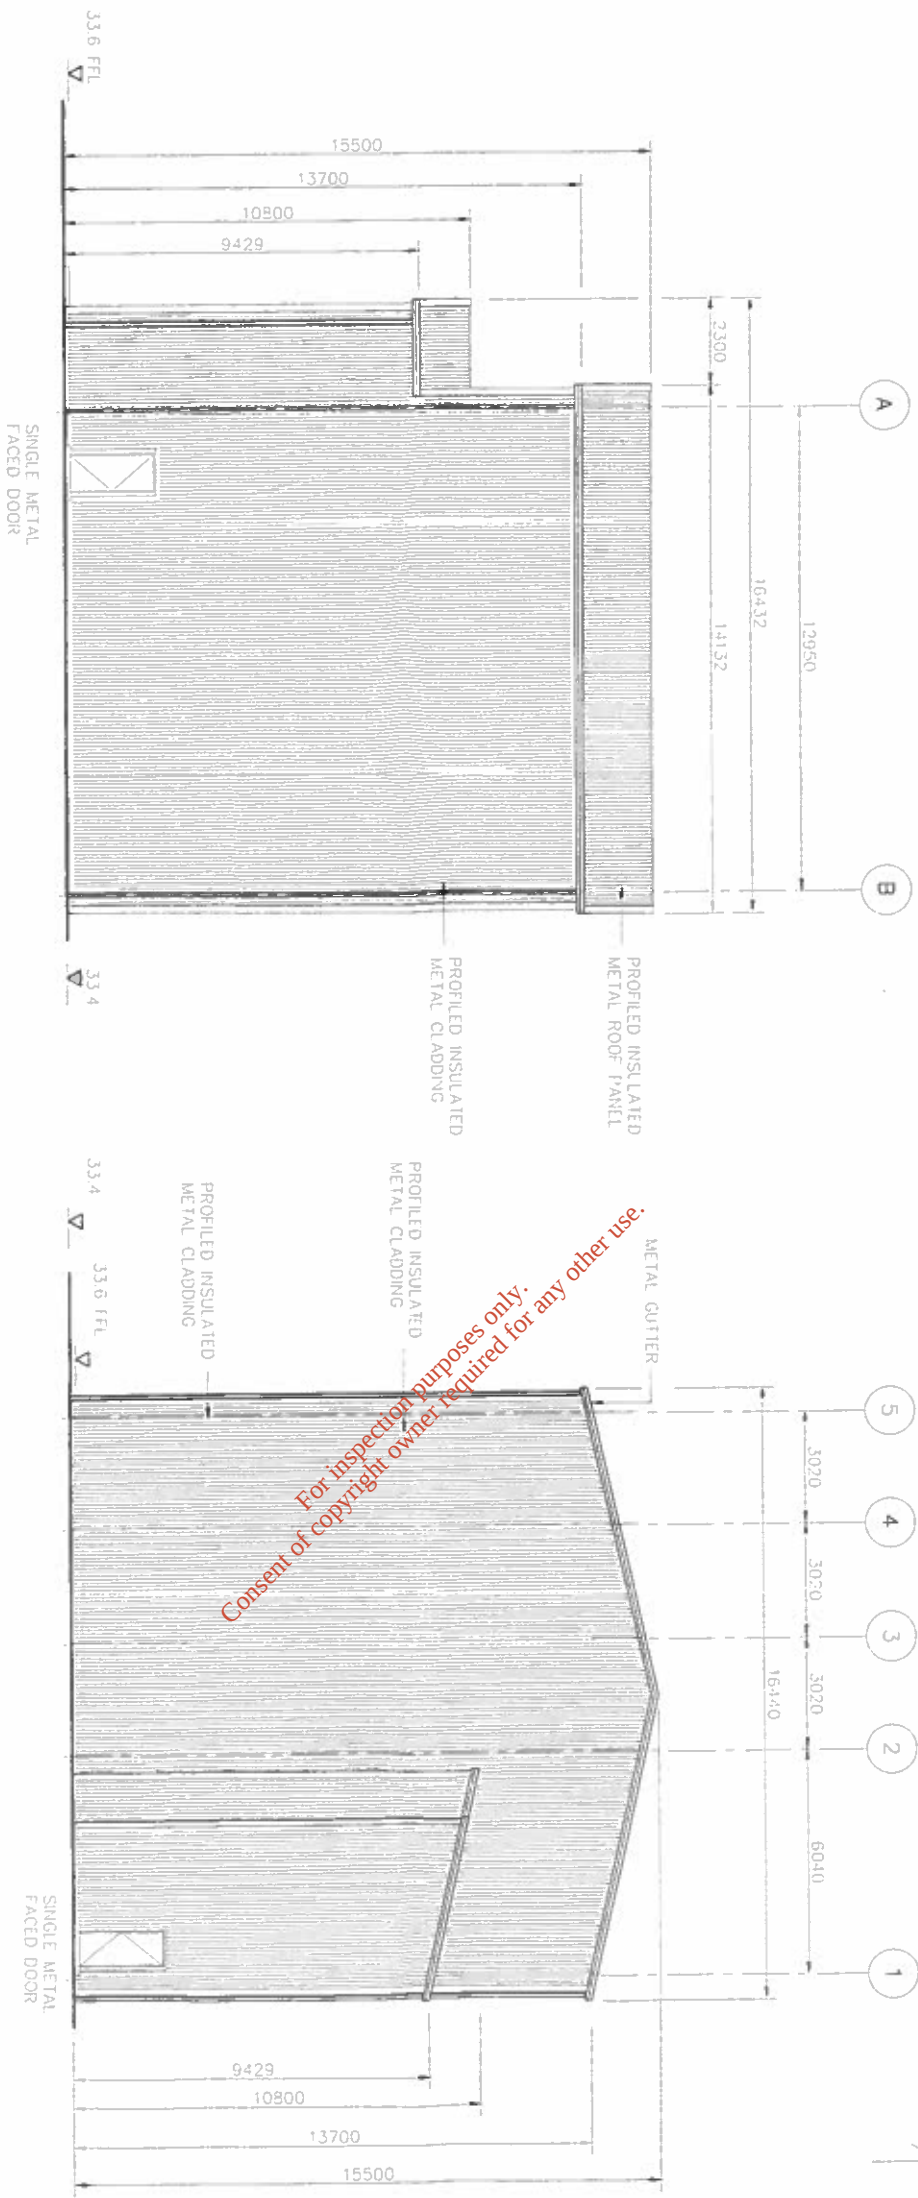

- NOTES**
1. SITE DATUM E100000 N100000  
EQUALS ORDNANCE DATUM (MALIN)  
E86325475 N532799575
  2. ALL DIMENSIONS ARE IN MILLIMETRES.  
ALL ELEVATIONS ARE IN METRES AOD
  3. DO NOT SCALE  
USE GIVEN DIMENSIONS ONLY

**Corrib Field Development**

**Bellanaboy Bridge Gas Terminal**

**Shell E&P Ireland Limited**



**Corrib natural gas**

**amec**


11, The Boulevard, Clonsilla,  
West Sussex, BN12 5NF  
Tel: +44 (0)1293 267755 Fax: +44 (0)1293 268011

**WASTE WATER TREATMENT BUILDING ELEVATIONS**

| Contract & Drawing No    |                      | Sheet No       |
|--------------------------|----------------------|----------------|
| L3882-030-110-0386       |                      | 1 of 3         |
| Size                     | 1:100 (at full size) | Drawn by       |
| A1                       | 1-100                | R. Smart       |
| Checked                  |                      | Date           |
| D. Rattray               | S. Cass              | Nov. 03        |
| For Planning Application |                      | Shell Draw No. |
| COR-AM-BU-024            |                      |                |

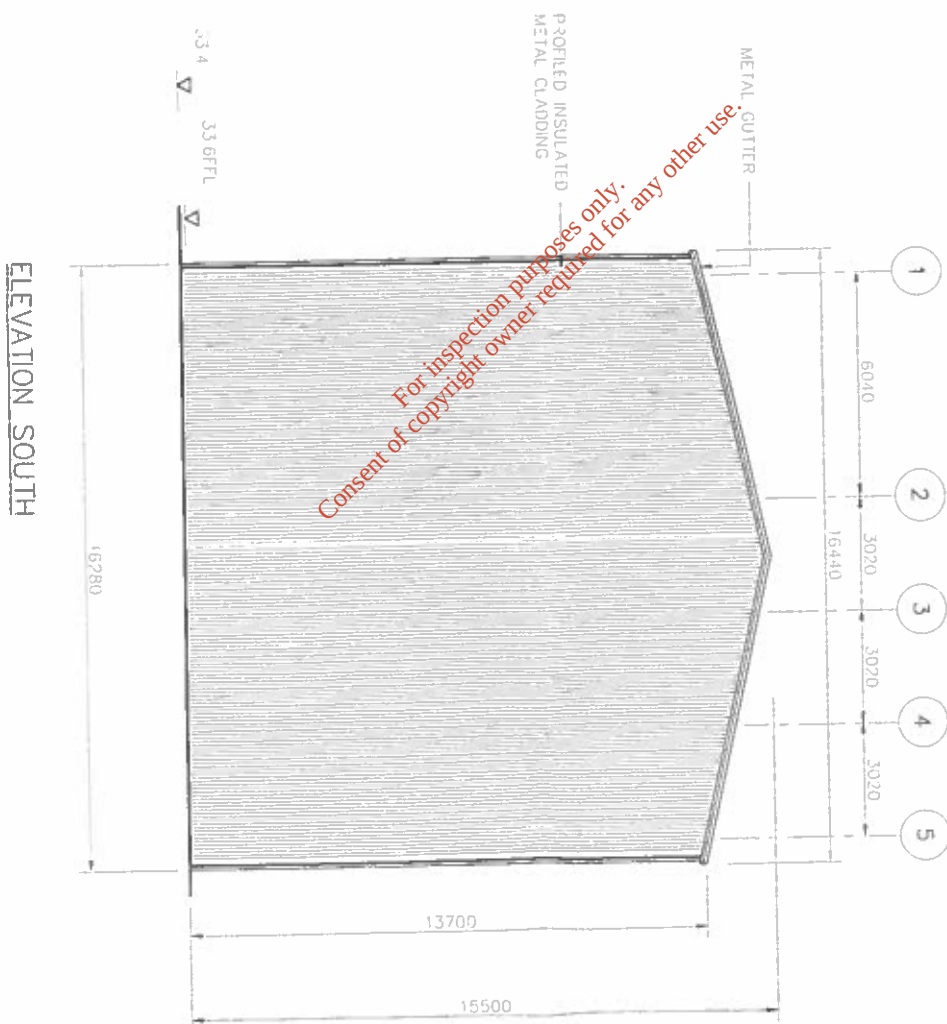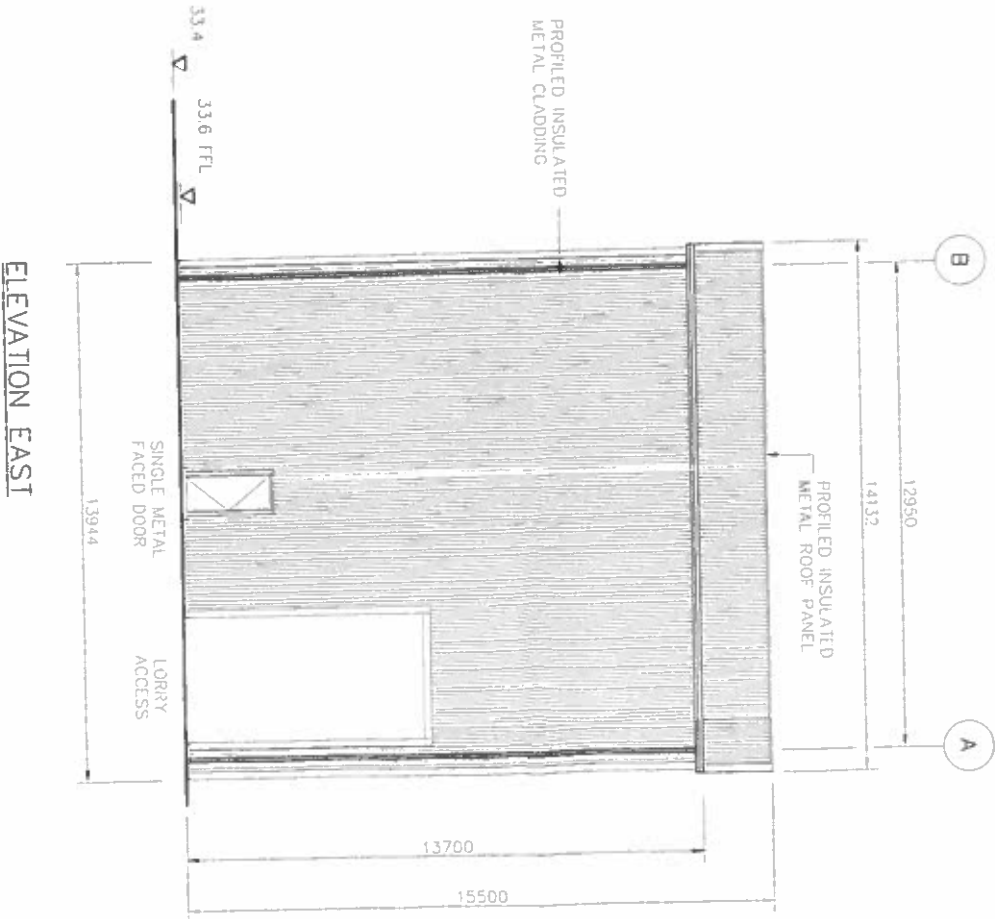


For inspection purposes only.  
Consent of copyright owner required for any other use.

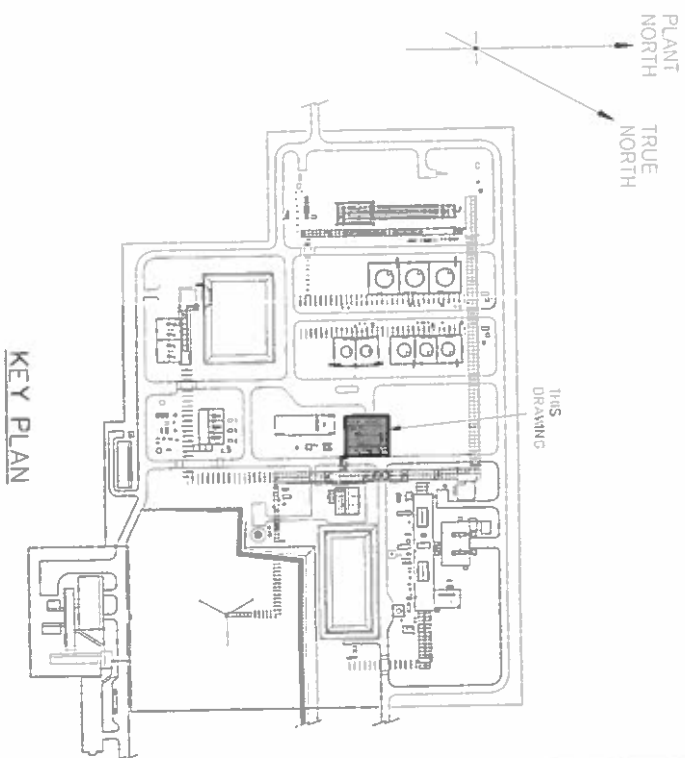


- NOTES
1. SITE DATUM E100000 N100000  
EQUILS ORNANCE DATUM (MALIN)  
EB6325475 N332799575
  2. ALL DIMENSIONS ARE IN MILLIMETRES  
ALL ELEVATIONS ARE IN METRES AOD
  3. DO NOT SCALE  
USE GIVEN DIMENSIONS ONLY

|                                                               |  |                                                                            |  |
|---------------------------------------------------------------|--|----------------------------------------------------------------------------|--|
| Corrib Field Development                                      |  |                                                                            |  |
| Bellanaboy Bridge Gas Terminal                                |  |                                                                            |  |
| Shell E&P Ireland Limited                                     |  |                                                                            |  |
| Corrib<br>natural gas                                         |  | amec<br>11 The Boulevard, Crawley,<br>West Sussex, RH11 9AA (01323 344011) |  |
| Drawing Title<br>WASTE WATER TREATMENT BUILDING<br>ELEVATIONS |  |                                                                            |  |
| Contract Drawing No.<br>L3882-030-110-0386                    |  | Sheet No.<br>2 of 3                                                        |  |
| Scale<br>A1 1-100                                             |  | Drawn by<br>R. Smart                                                       |  |
| Checked<br>D. Roltroy                                         |  | Approved<br>S. Cass                                                        |  |
| Issue<br>For Planning Application                             |  | Date<br>Nov. 03                                                            |  |
| Sheet Drawing No.<br>COR-AM-BU-025                            |  |                                                                            |  |

SECTION A-A

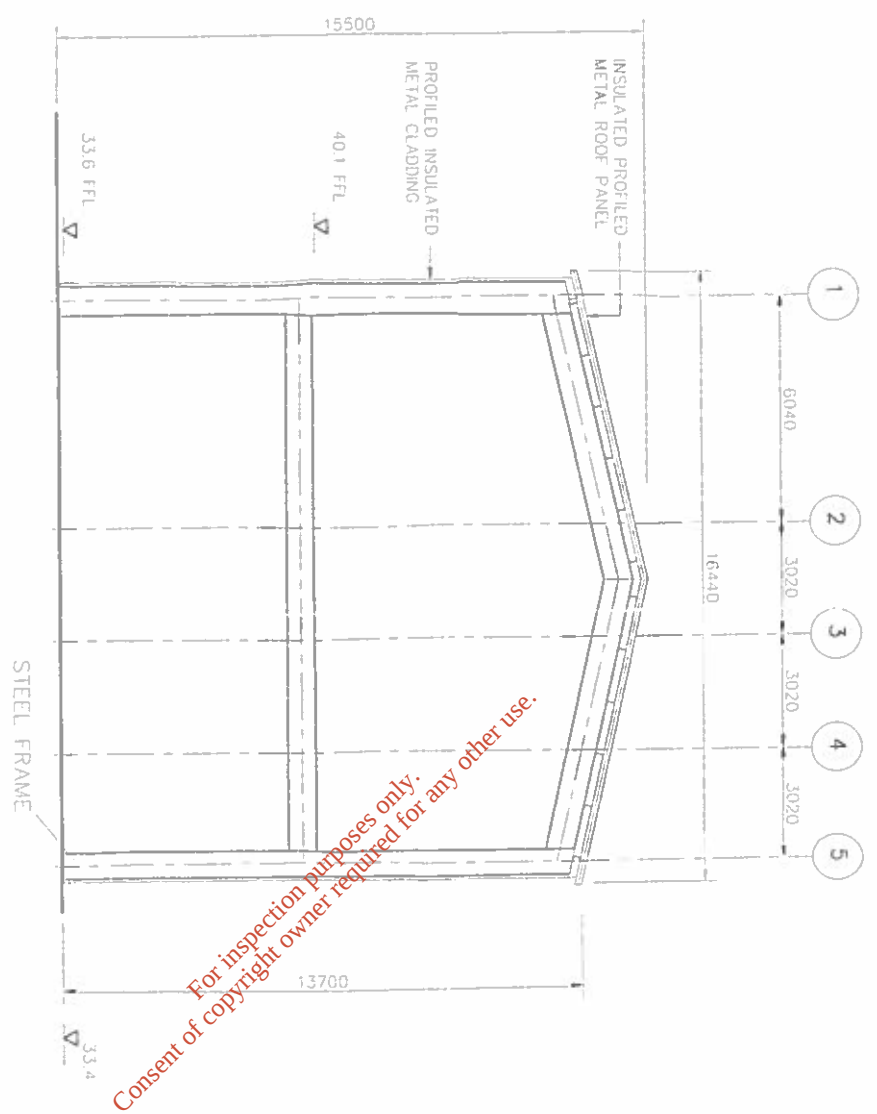

- NOTES**
1. SITE DATUM E100000 N100000  
EQUALS ORDNANCE DATUM (MALIN)  
E86325175 N332799575
  2. ALL DIMENSIONS ARE IN MILLIMETRES  
ALL ELEVATIONS ARE IN METRES AOD
  3. DO NOT SCALE  
USE GIVEN DIMENSIONS ONLY

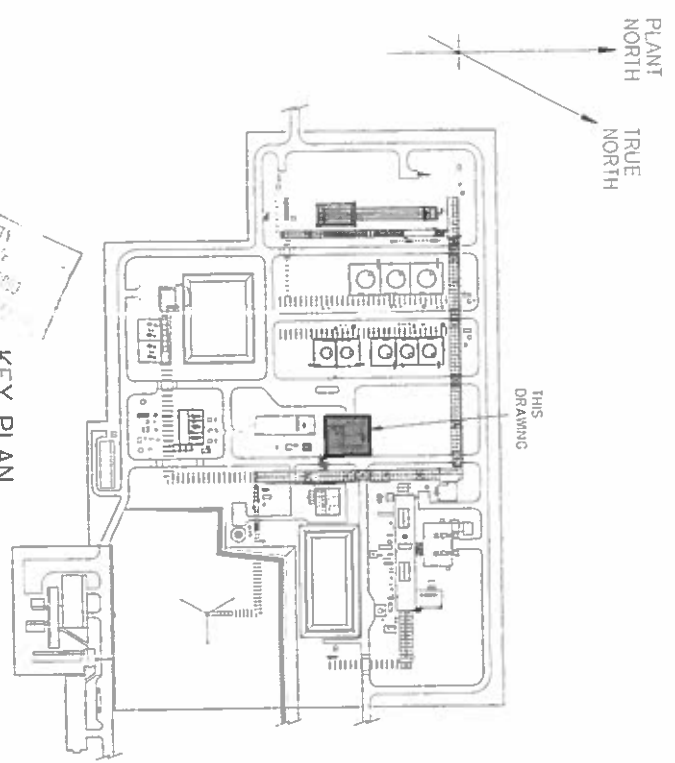

KEY PLAN

Corrib Field Development

Bellanaboy Bridge Gas Terminal

 Shell E&P Ireland Limited



Corrib  
natural gas



amec

11 The Boulevard, Greely,  
West Sussex, PO10 1UX, UK  
Tel: +44 (0)1293 399125 Fax: +44 (0)1293 394001

WASTE WATER TREATMENT BUILDING  
SECTIONS

|                                             |                          |                      |      |
|---------------------------------------------|--------------------------|----------------------|------|
| Contract / Drawing No<br>L3882-030-110-0386 |                          | Sheet 110<br>3 of 3  |      |
| Size<br>A1                                  | Scale (A1 size)<br>1-100 | Drawn by<br>R. Smart | Date |
| Check id<br>D. Rattray                      | Approved<br>S. Cass      | Nov. 03              |      |
| For Planning Application                    |                          | COR-AM-BU-026        |      |

For inspection purposes only.  
Consent of copyright owner required for any other use.