

ATTACHMENT D

SITE BOUNDARY (OS MAP)

*For inspection purposes only.
Consent of copyright owner required for any other use.*

Placeholder

This page has been inserted to indicate that content has been extracted from this location in the document and has been stored in a separate file. (This is due to file size issues.)

The extracted content can be found in the following electronic pdf file:

EIS-Additional Information -
Drawing-1


Licence: W0167-01

For inspection purposes only.
Consent of copyright owner required for any other use.

ATTACHMENT E

AERIAL PHOTOGRAPH

*For inspection purposes only.
Consent of copyright owner required for any other use.*

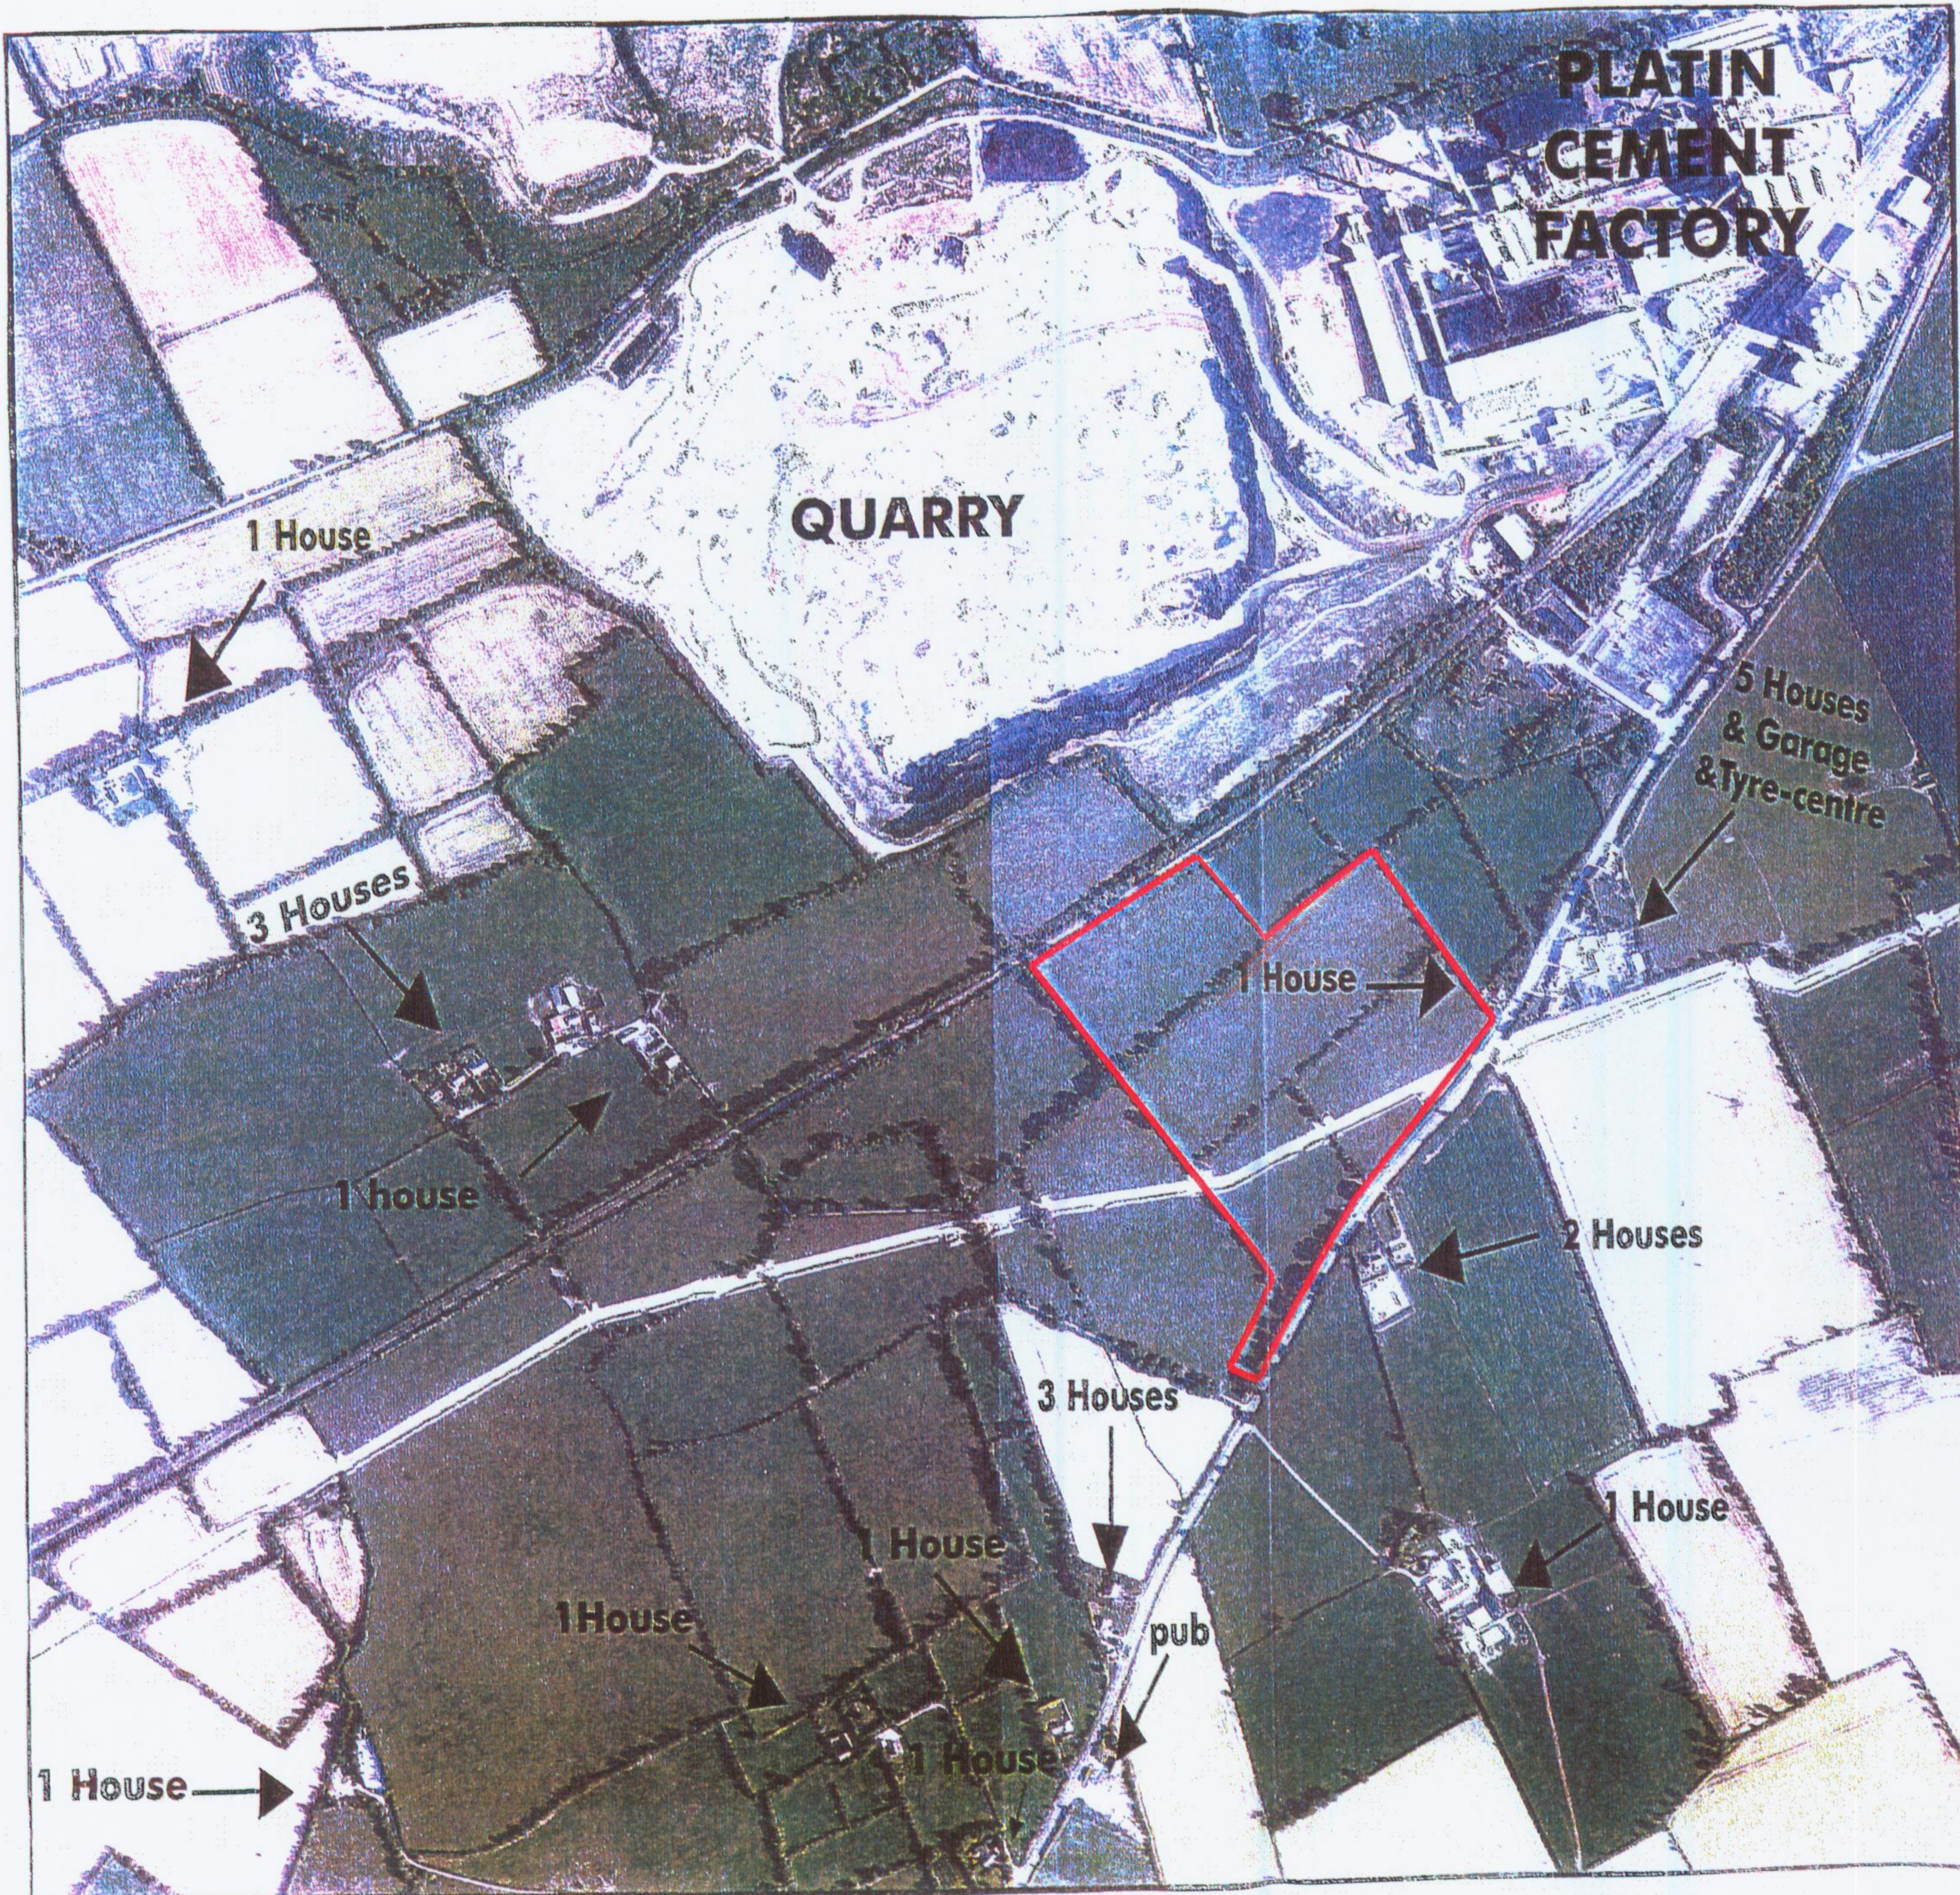

Indaver Ireland Ltd



Project Management Group
Waste Management Facility,
Carranstown


Adjacent Land Uses

ATTACHMENT F


JUNCTION LAYOUT DRAWINGS

- 2666-48-DR-004 Site Entrance Details
- 2666-49-DR-005 Site Entrance Details with Power Plant Entrance shown
- 2666-49-DR-006 Sight Line Details


*For inspection purposes only.
Consent of copyright owner required for any other use.*

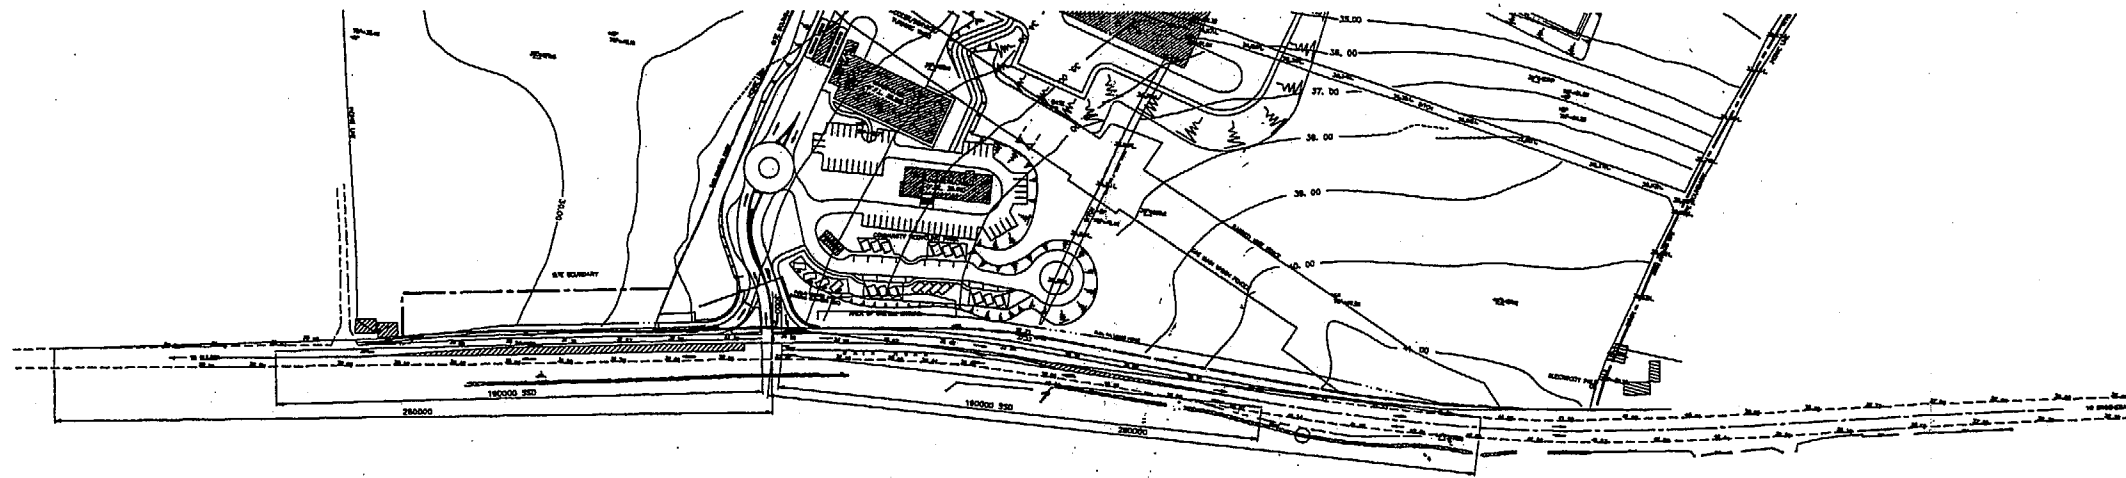

PLAN
SCALE 1:1000

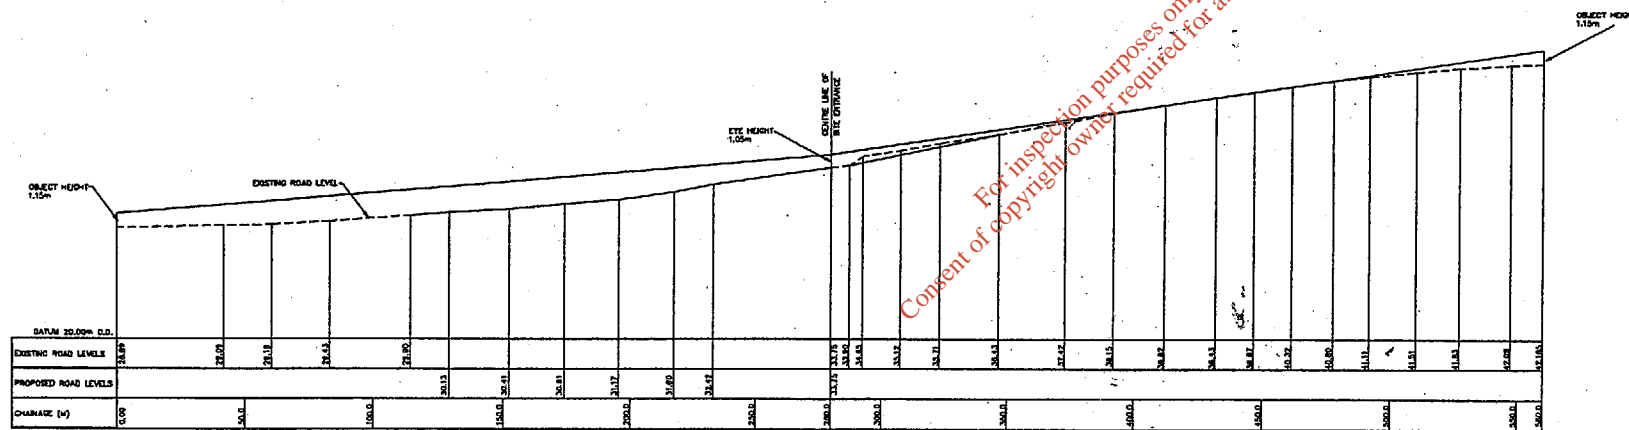

LONGITUDINAL SECTION ALONG PROPOSED SIGHTLINES
SCALE: HORIZ 1:1000, VERT 1:200

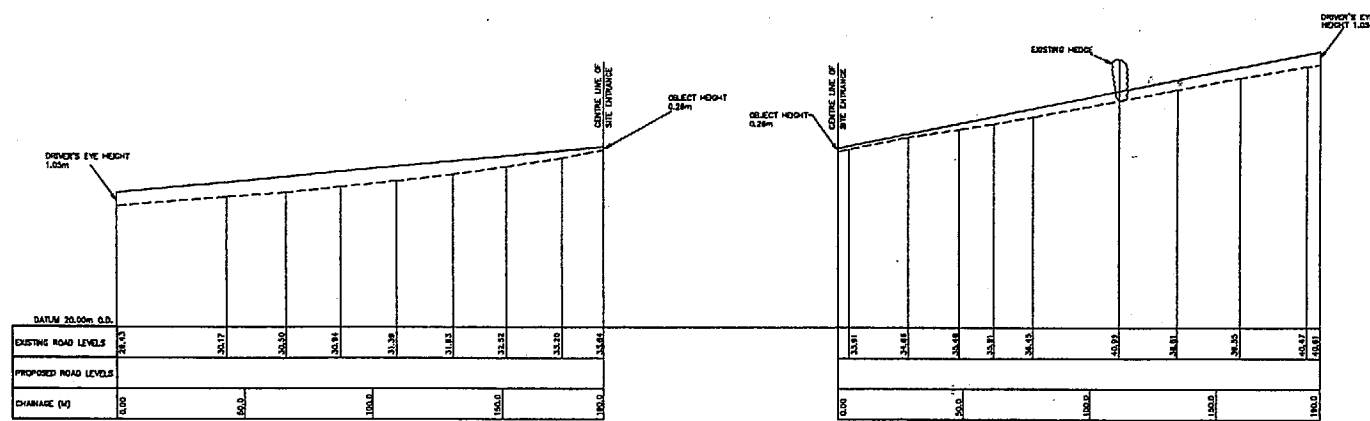

LONGITUDINAL SECTION ALONG PROPOSED STOPPING SIGHTLINES
SCALE: HORIZ 1:1000, VERT 1:200

- NOTES
1. THIS DRAWING TO BE READ IN CONJUNCTION WITH ALL RELEVANT ARCHITECTS AND ENGINEERS DRAWINGS AND SPECIFICATIONS.
 2. DO NOT SCALE - USE DIMENSIONED DIMENSIONS ONLY.
 3. LEVELS ARE GIVEN IN METRES AND RELATE TO O.S. DATUM (MAMM HEAD).
 4. ALL DIMENSIONS ARE GIVEN IN METRES.
 5. REFER TO 2666-49-04-006 FOR FURTHER DETAILS OF STOP SIGHT LINES.



REVISION	DESCRIPTION	DATE
B	FOR PLANNING - ADDITIONAL INFORMATION	12/06/07
A	FOR PLANNING	11/09/07


INDAVIR
INDAVIR IRELAND
4 HADDINGTON TCE
DUN LAOGHAIRE
CO. DUBLIN
TEL: +353 1 216420
FAX: +353 1 2807963

AM Project Management Group
WILKINS ASSOCIATES


PROJECT: WASTE MGMT FACILITY - CARRANSTOWN

TITLE: SITE ENTRANCE DETAILS


CLIENT REF.	CLIENT DSG NO.
PROJECT NO.	CONTR DSG NO.
SCALE	2666-49-DR-004

 


THIS DRAWING WAS CREATED USING AUTOCAD R14

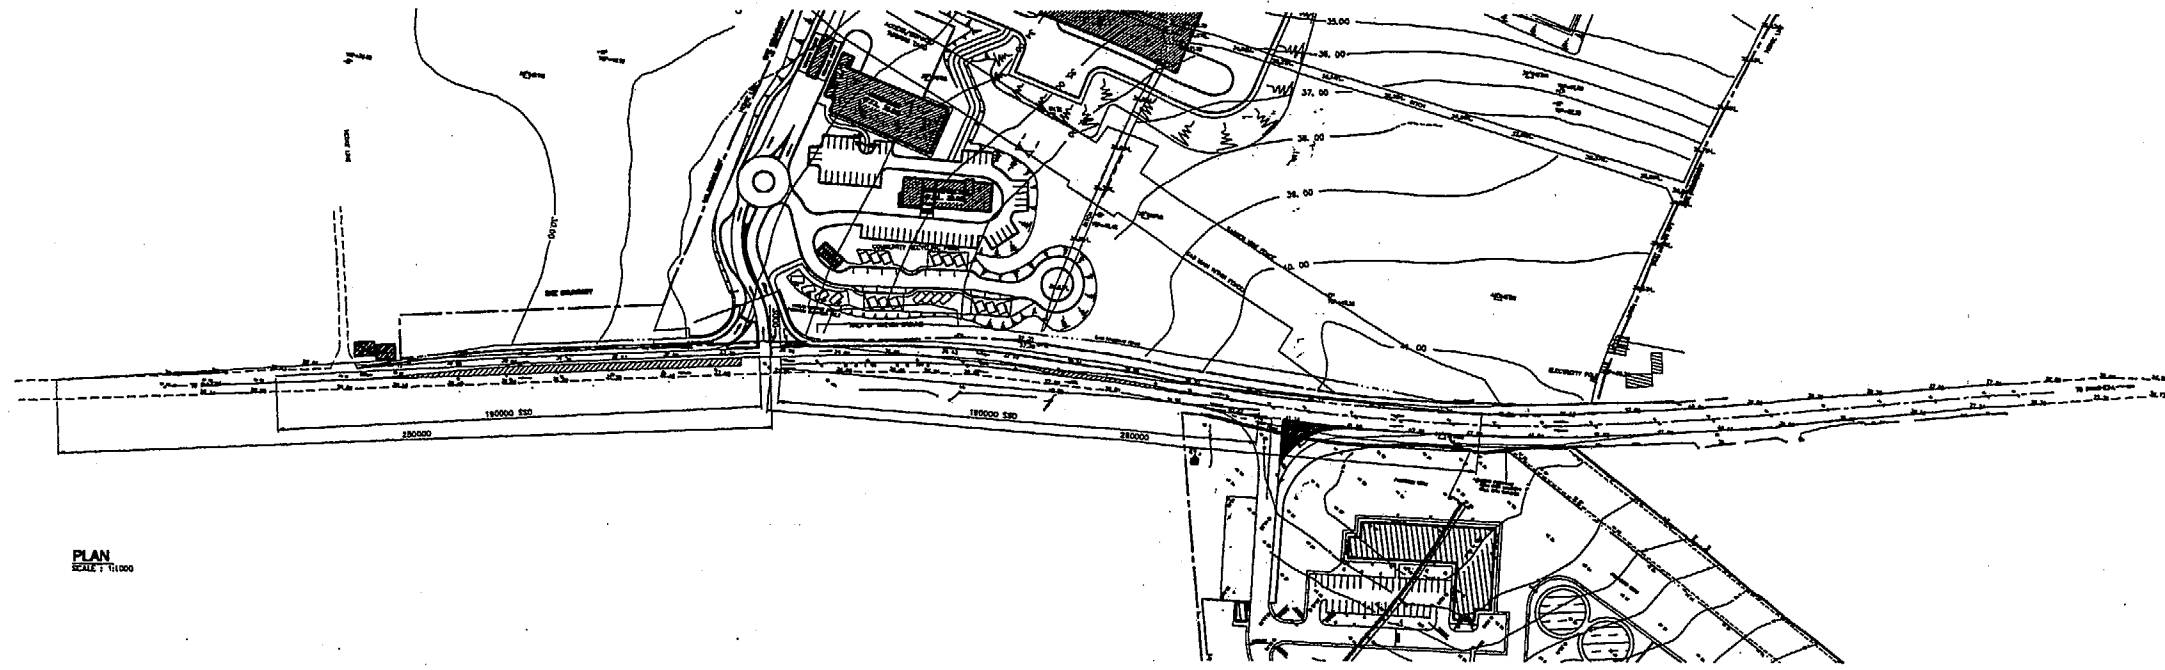

PLAN
SCALE 1:1000

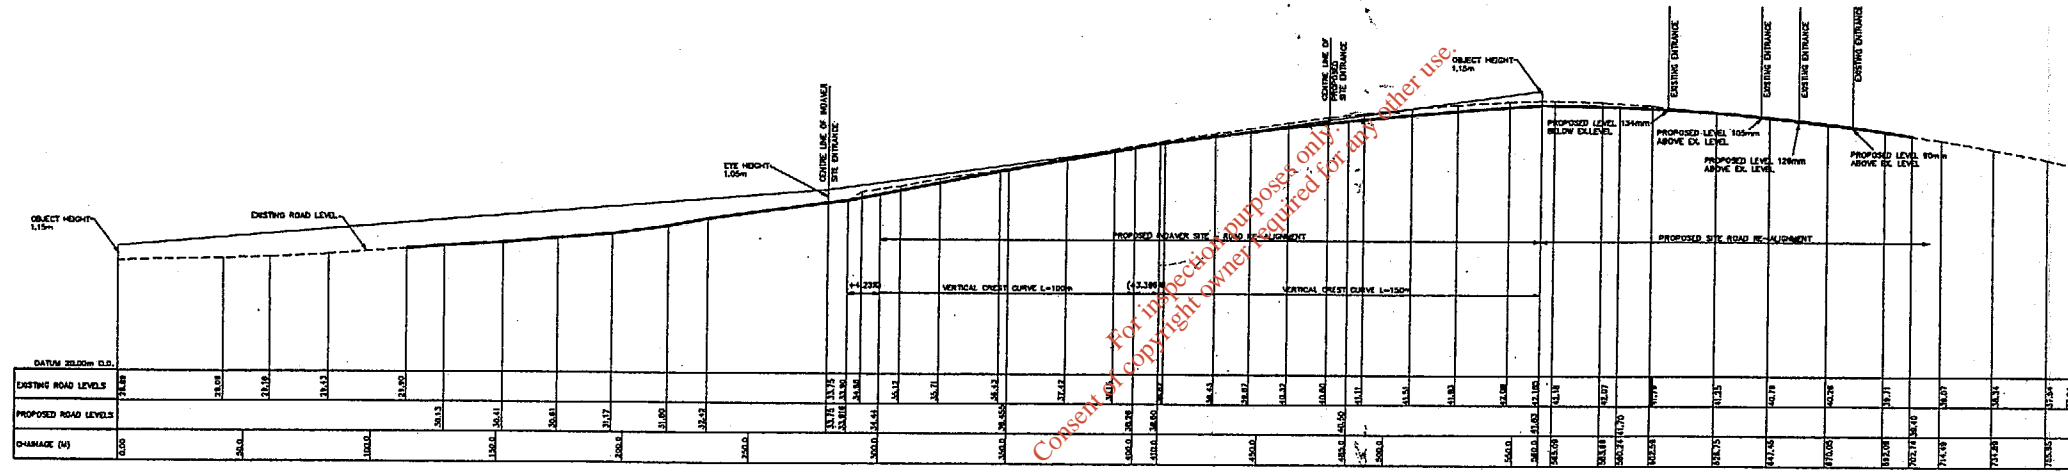

LONGITUDINAL SECTION ALONG PROPOSED SITELINES INCORPORATING OTHER PROPOSED SITE ROAD ALIGNMENT
SCALE 1: HORIZ 1:1000; VERT 1:200

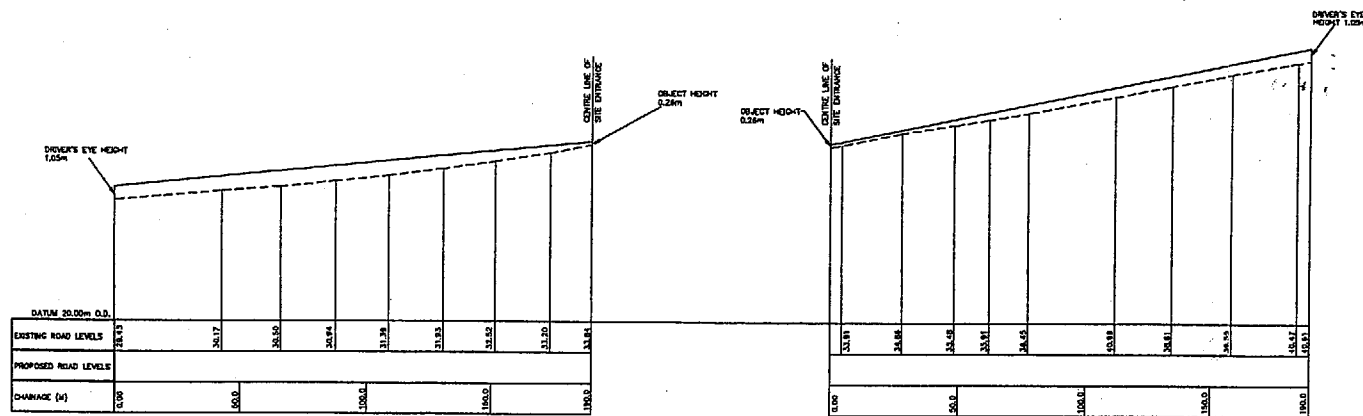

LONGITUDINAL SECTION ALONG PROPOSED STOPPING SIGHTLINES
SCALE 1: HORIZ 1:1000; VERT 1:200

- NOTES**
1. THIS DRAWING TO BE READ IN CONJUNCTION WITH ALL RELEVANT ARCHITECTS AND ENGINEERS DRAWINGS AND SPECIFICATIONS.
 2. DO NOT SCALE: USE PRINTED DIMENSIONS ONLY.
 3. ALL DIMENSIONS ARE IN METRES.
 4. ALL LEVELS ARE IN METRES AND RELATE TO ORDNANCE DATUM 1: MAIN HEAD.


For inspection purposes only.
 Consent copyright owner required for any other use.





B	FOR PLANNING - ADDITIONAL INFORMATION					11/19/11
A	FOR PLANNING	ER	ER	JC		11/19/11
DATE	DESCRIPTION	DRN	CHK	APP	DATE	

INDAVER
 Project Management Group
 Unit: D448

PROJECT	WASTE MGMT FACILITY - CARRANSTOWN
TITLE	SITE ENTRANCE DETAILS WITH POWER PLANT ENTRANCE SHOWN
CLIENT REF.	CLIENT Dwg No.
PROJECT No.	2888
SCALE	AS SHOWN
CONTR Dwg No.	2866-48-DR-005

 

THIS DRAWING WAS CREATED USING AUTOCAD R14

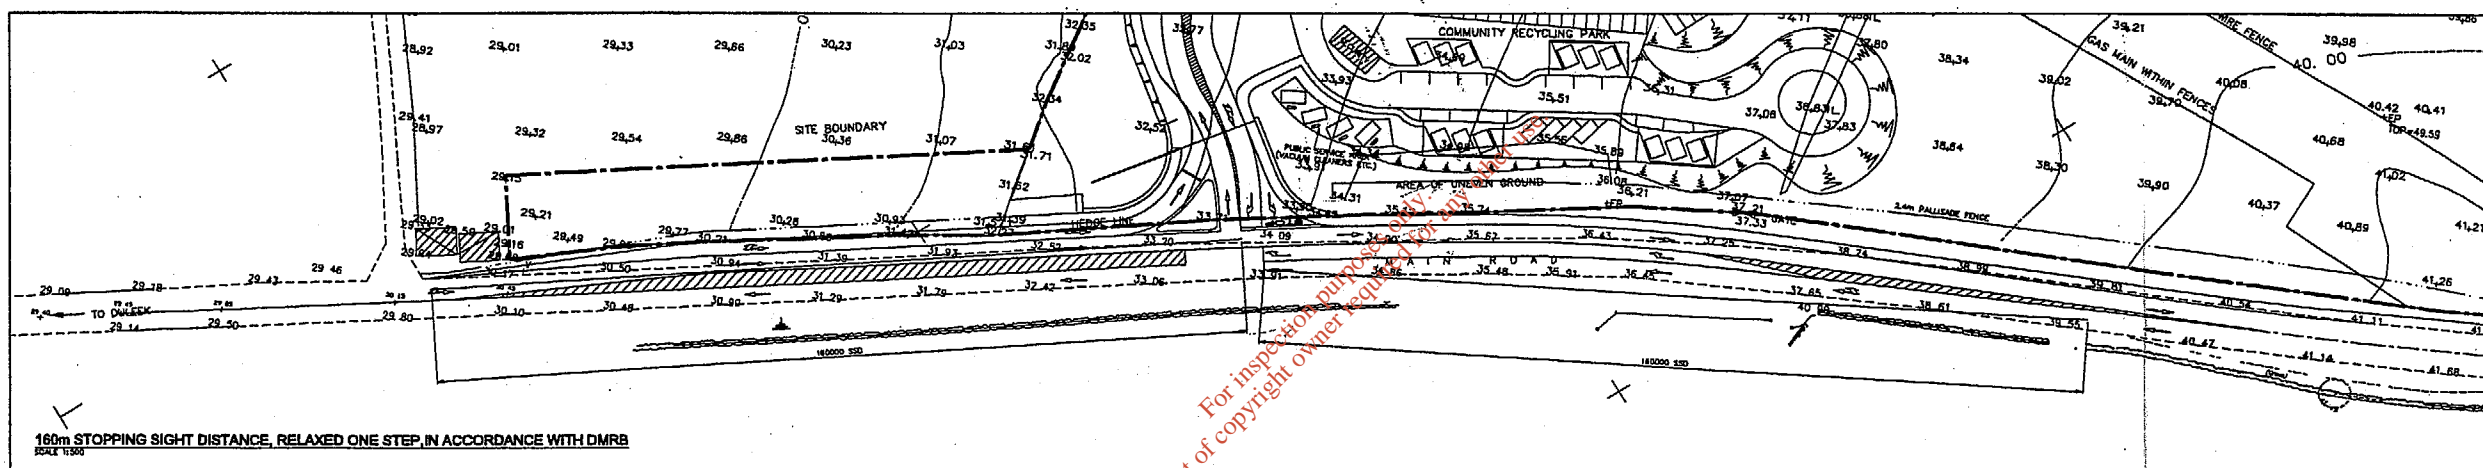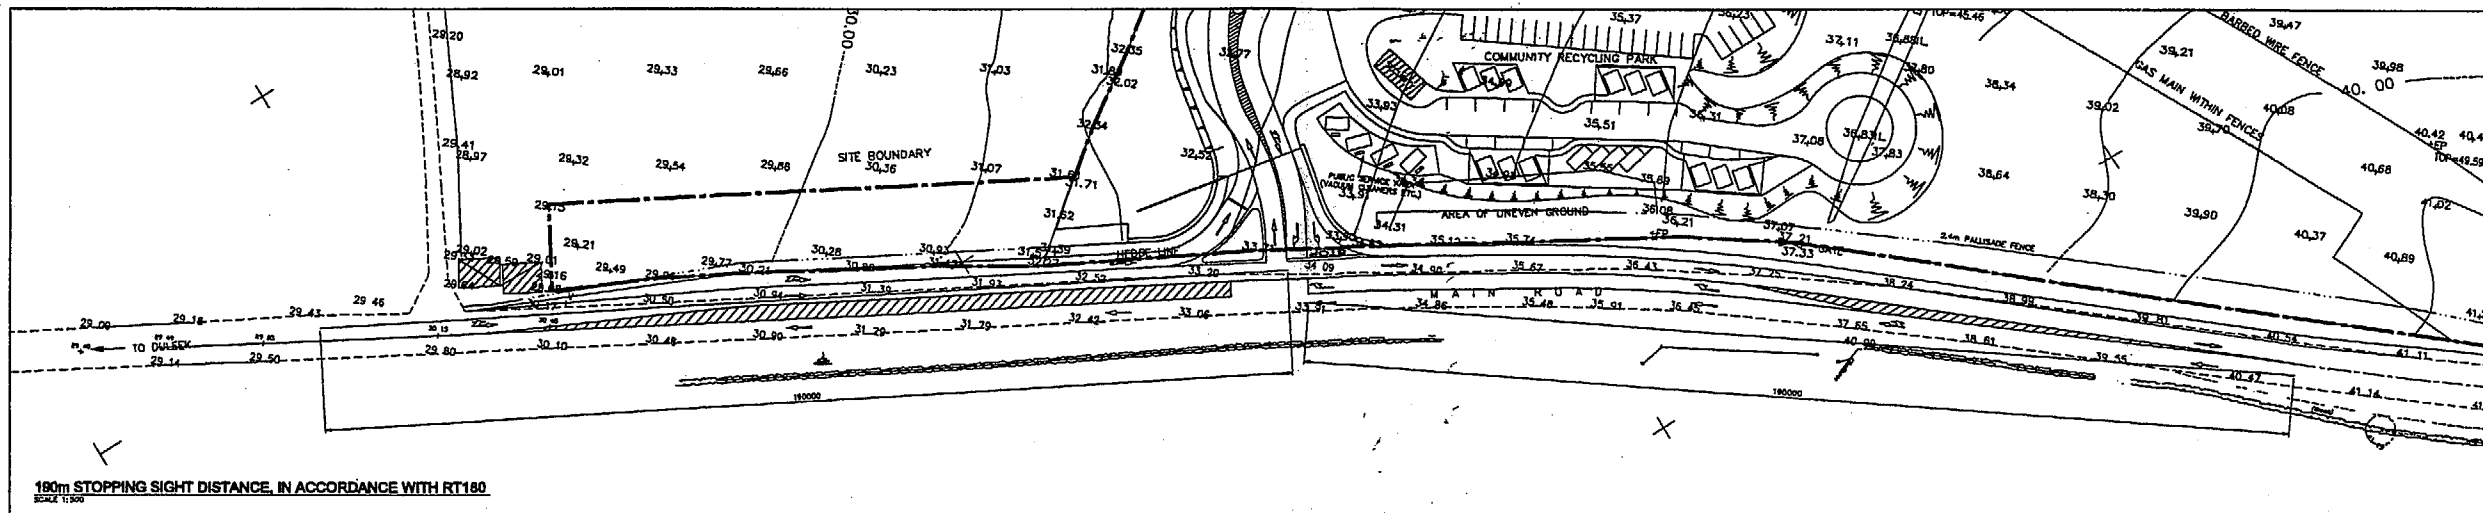

For inspection purposes only
Consent of copyright owner required for reuse

NOTES

1. THIS DRAWING TO BE READ IN CONJUNCTION WITH ALL RELEVANT ARCHITECTS AND ENGINEERS DRAWINGS AND SPECIFICATIONS.
2. DO NOT SCALE - USE DIMENSIONS ONLY.
3. LEVELS ARE GIVEN IN METRES AND RELATE TO D.E. DATUM (MATHS HEAD).
4. ALL DIMENSIONS ARE GIVEN IN MILLIMETRES.
5. ALL DIMENSIONS TO BE CHECKED ON SITE.



REV	DESCRIPTION	DATE	APP	DATE
A	FOR PLANNING - ADDITIONAL INFORMATION			15/11/01

INDAVIR
Project Management Group
Civil Design

INDAVIR IRELAND
4 HADDINGTON TICE
DUN LAGHARE
CO. DUBLIN
TEL: +353 1 2145830
FAX: +353 1 2807963

PROJECT: WASTE MGMT FACILITY - CARRANSTOWN
TITLE: SIGHT LINE DETAILS

CLIENT REF.	CLIENT DISE NO.
PROJECT NO. 2898	
SCALE 1:500	DWG NO. 2898-49-DR-008



THIS DRAWING WAS CREATED USING AUTOCAD R14