



FLOOR PLAN - TRANSFER STATION (KEY PLAN) SCALE: 1:200

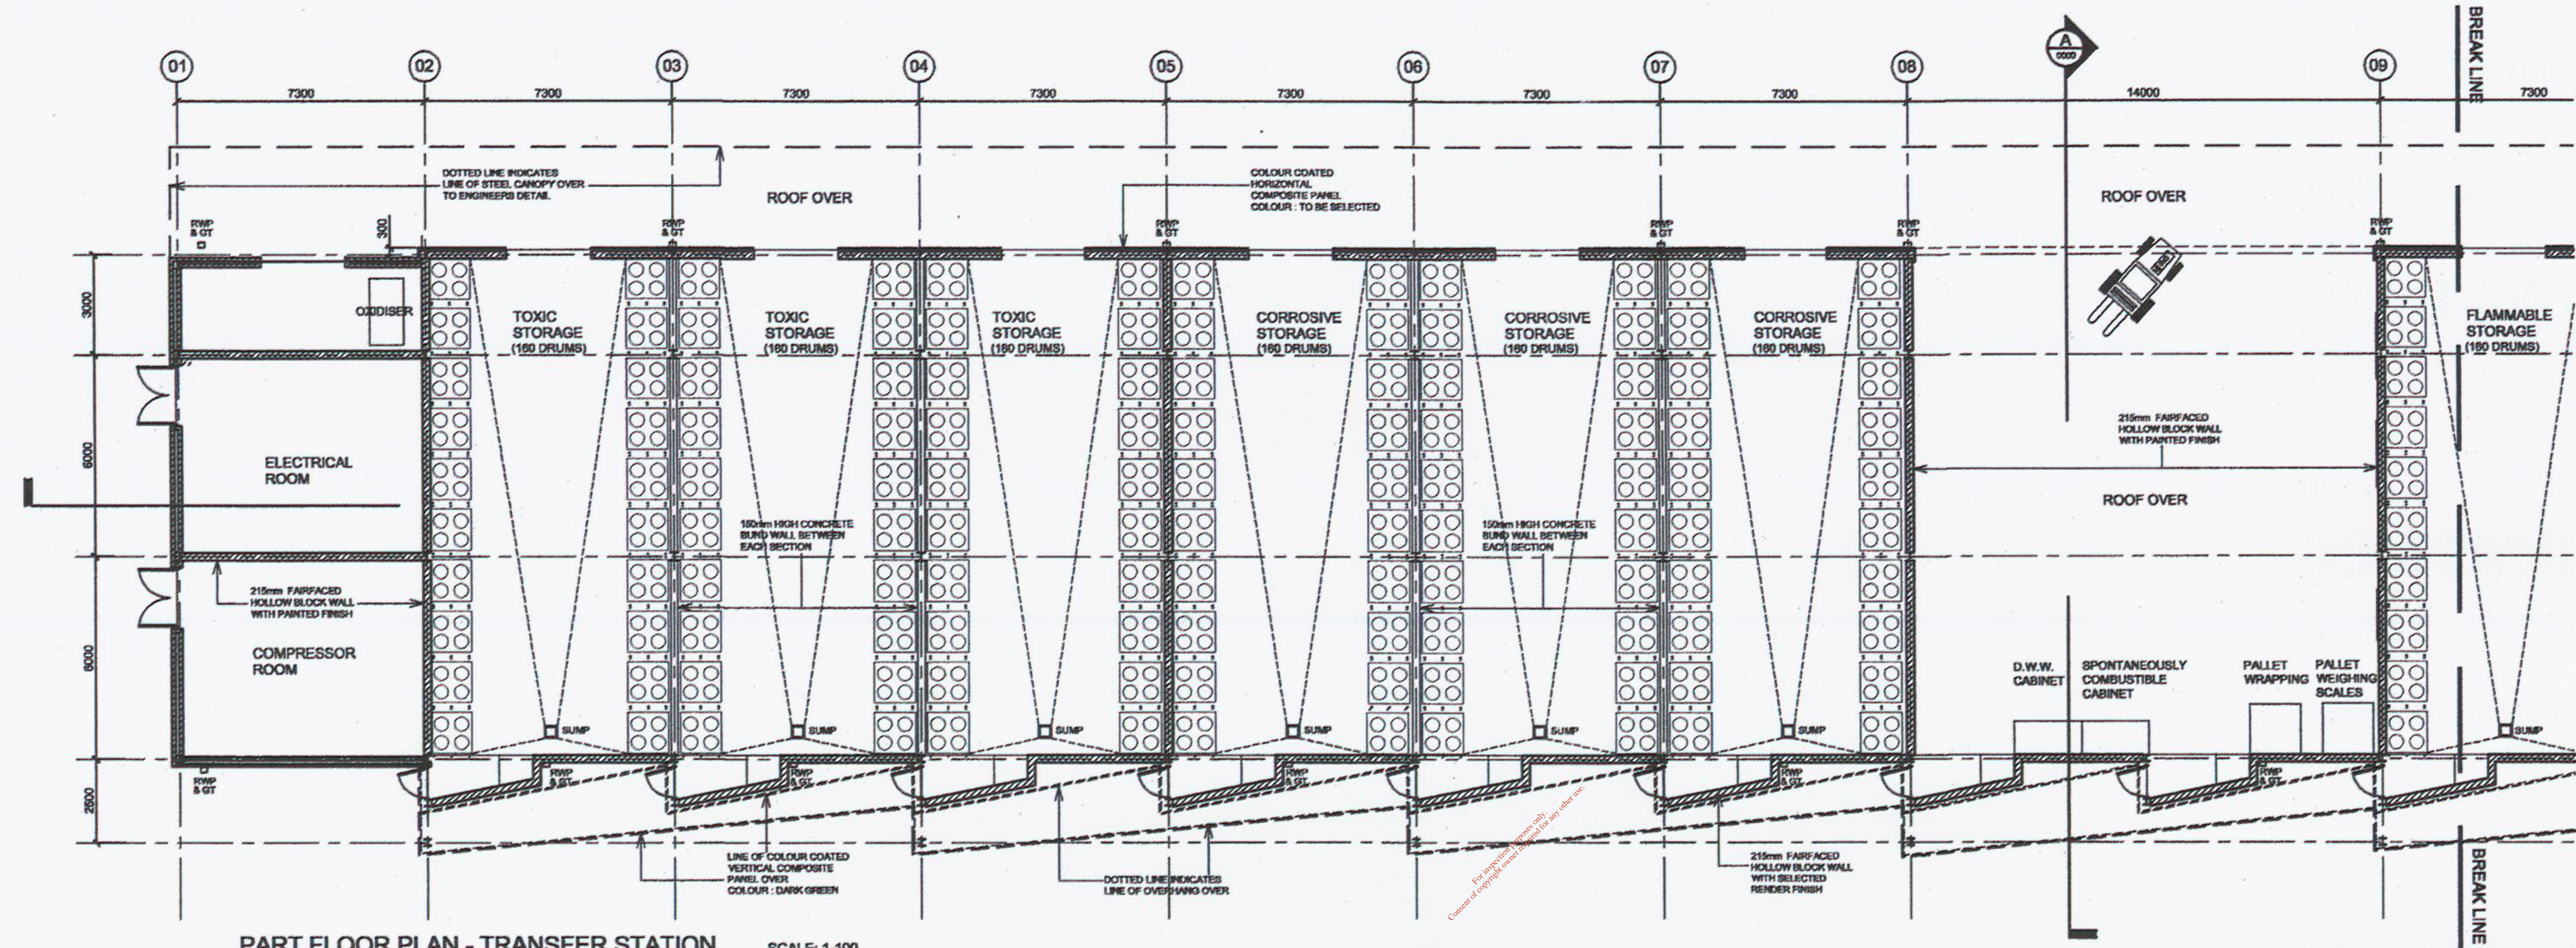

PART FLOOR PLAN - TRANSFER STATION SCALE: 1:100

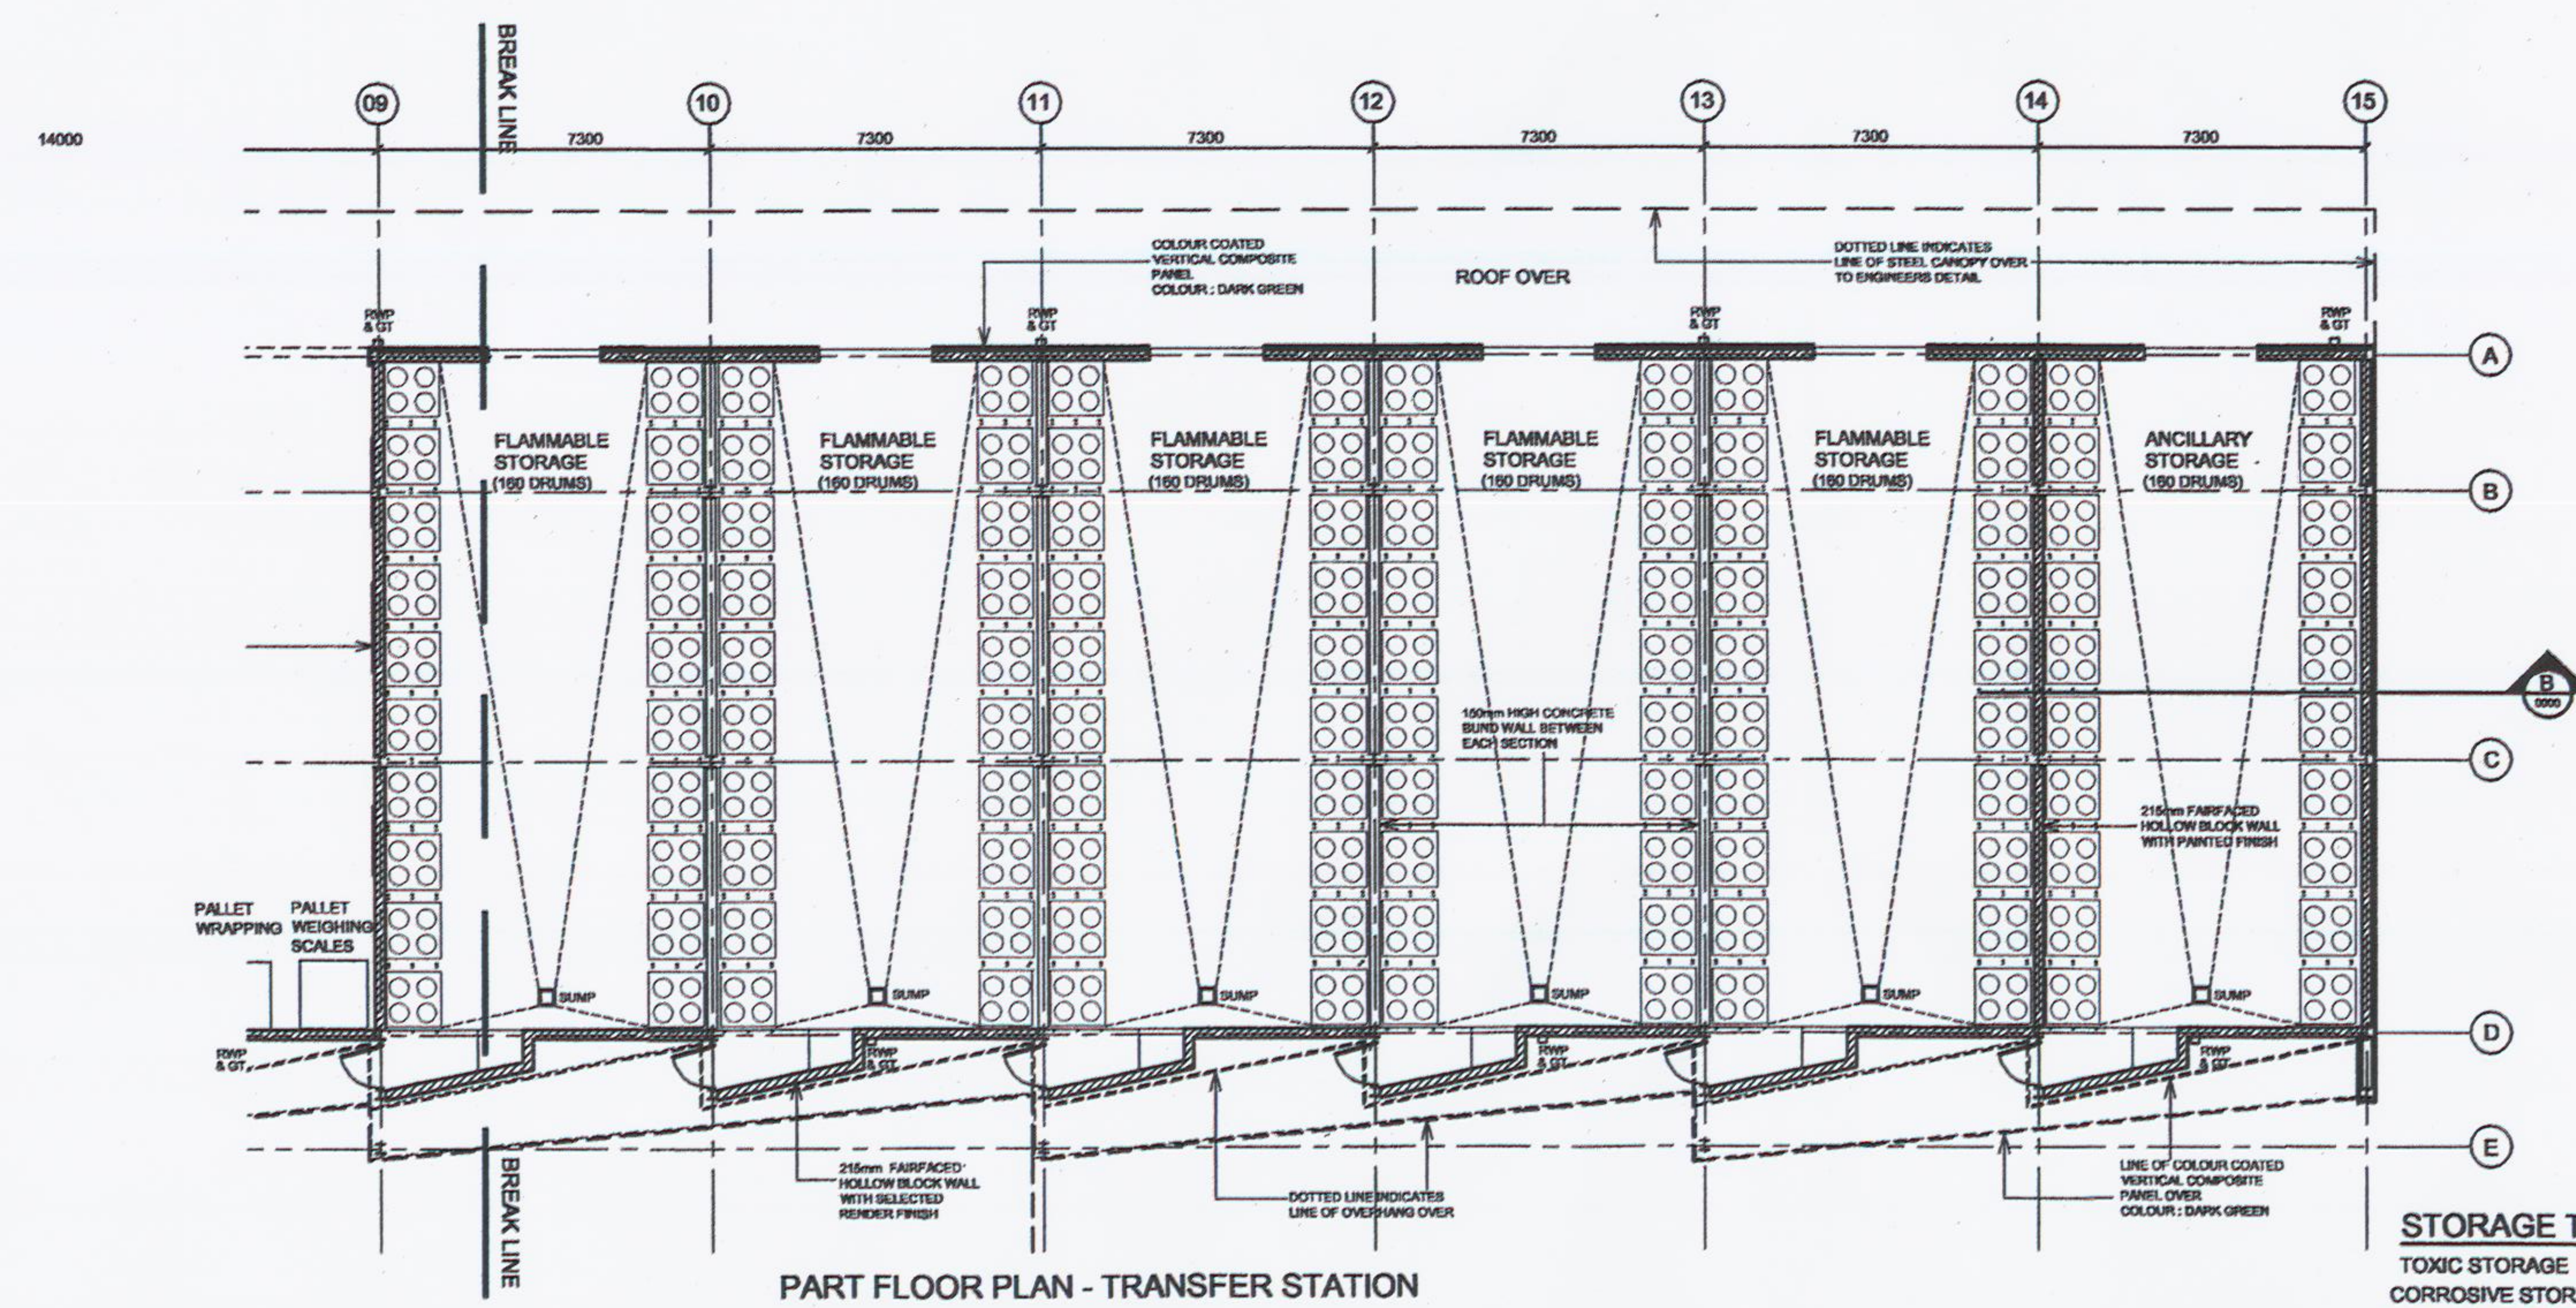


PART FLOOR PLAN - TRANSFER STATION

STORAGE TOTALS

TOXIC STORAGE	= 480 DRUMS
CORROSIVE STORAGE	= 480 DRUMS
FLAMMABLE STORAGE	= 800 DRUMS

NOTES

1. THIS DRAWING TO BE READ IN CONJUNCTION WITH ALL RELEVANT ARCHITECTS AND ENGINEERS DRAWINGS AND SPECIFICATIONS.
2. DO NOT SCALE - USE FIGURED DIMENSIONS ONLY.
3. LEVELS ARE GIVEN IN METRES AND RELATE TO O.S. DATUM (MAIN HEAD) 0.00.
4. ALL DIMENSIONS ARE GIVEN IN MILLIMETRES.
5. ALL DIMENSIONS TO BE CHECKED ON SITE.

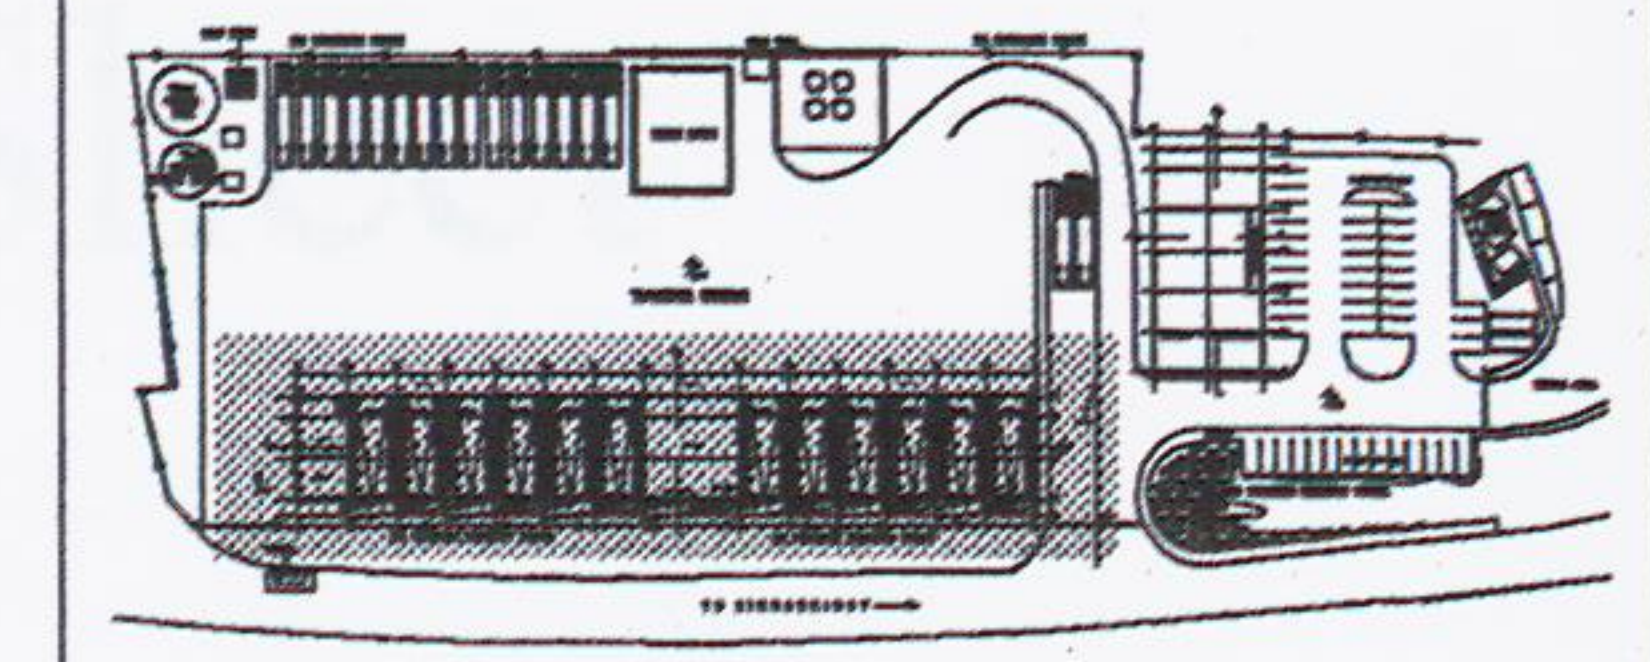

KEY PLAN

SCALE - 1:100

0	ISSUED FOR PLANNING	DC	FCM	LD	12/11/16
ISSUE	DESCRIPTION	DRN	CHK	APP	DATE
		INDAVER IRELAND			
		4 HADDINGTON TICE DUN LAGHARE CO. DUBLIN TEL: +353 1 2148800 FAX: +353 1 250785			
PROJECT: WASTE MANAGEMENT FACILITY- RINGASKIDDY					
TITLE: TRANSFER STATION FLOOR PLAN					
CLIENT REF:	CLIENT DRG No:				
PROJECT No:	CONTR. DRG No:				
SCALE: 1:200 & 1:100	COS/APP/82/700				