



ROOF PLAN - TRANSFER STATION KEY PLAN SCALE: 1:200

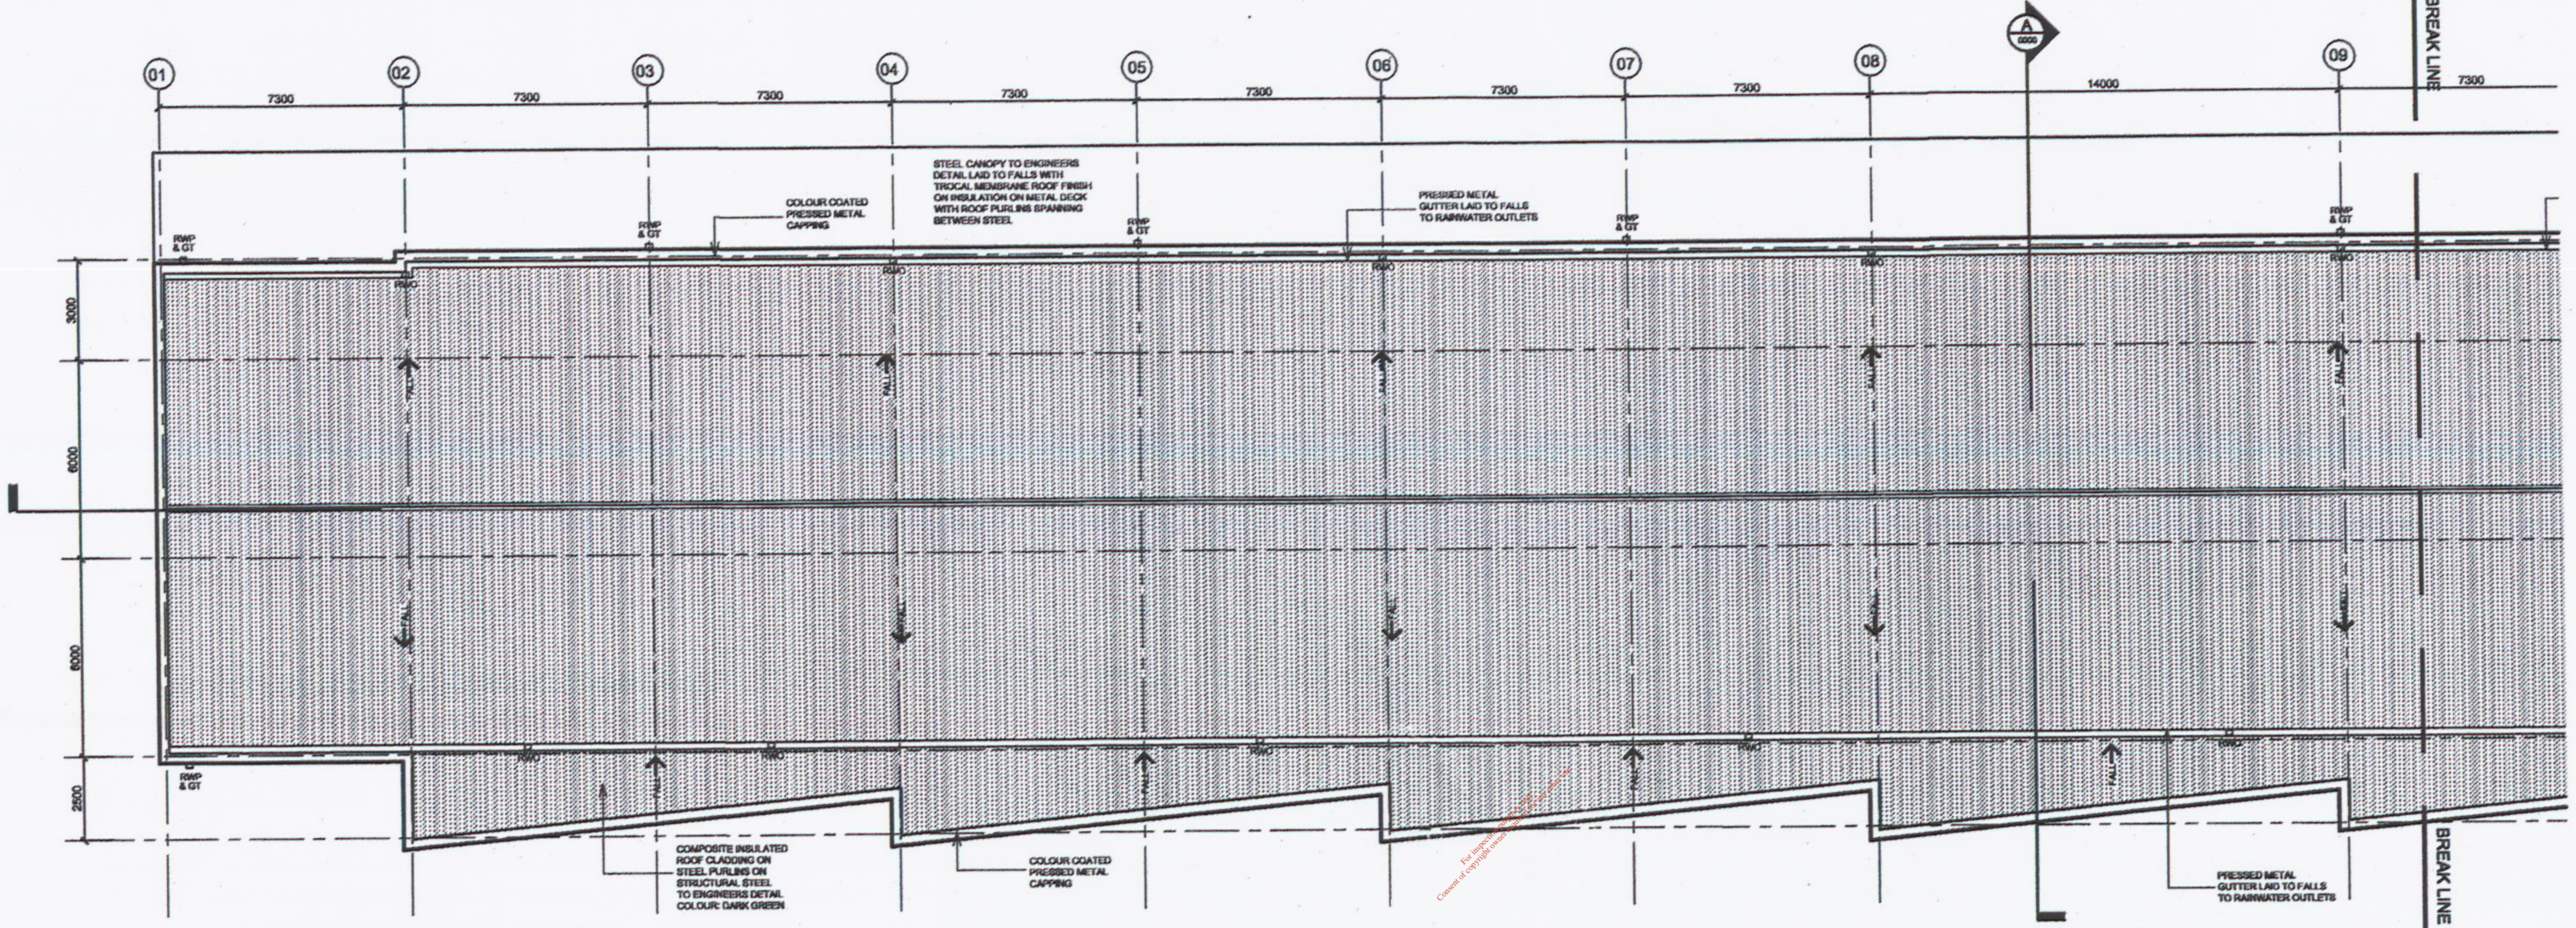


ROOF PLAN - TRANSFER STATION SCALE: 1:100

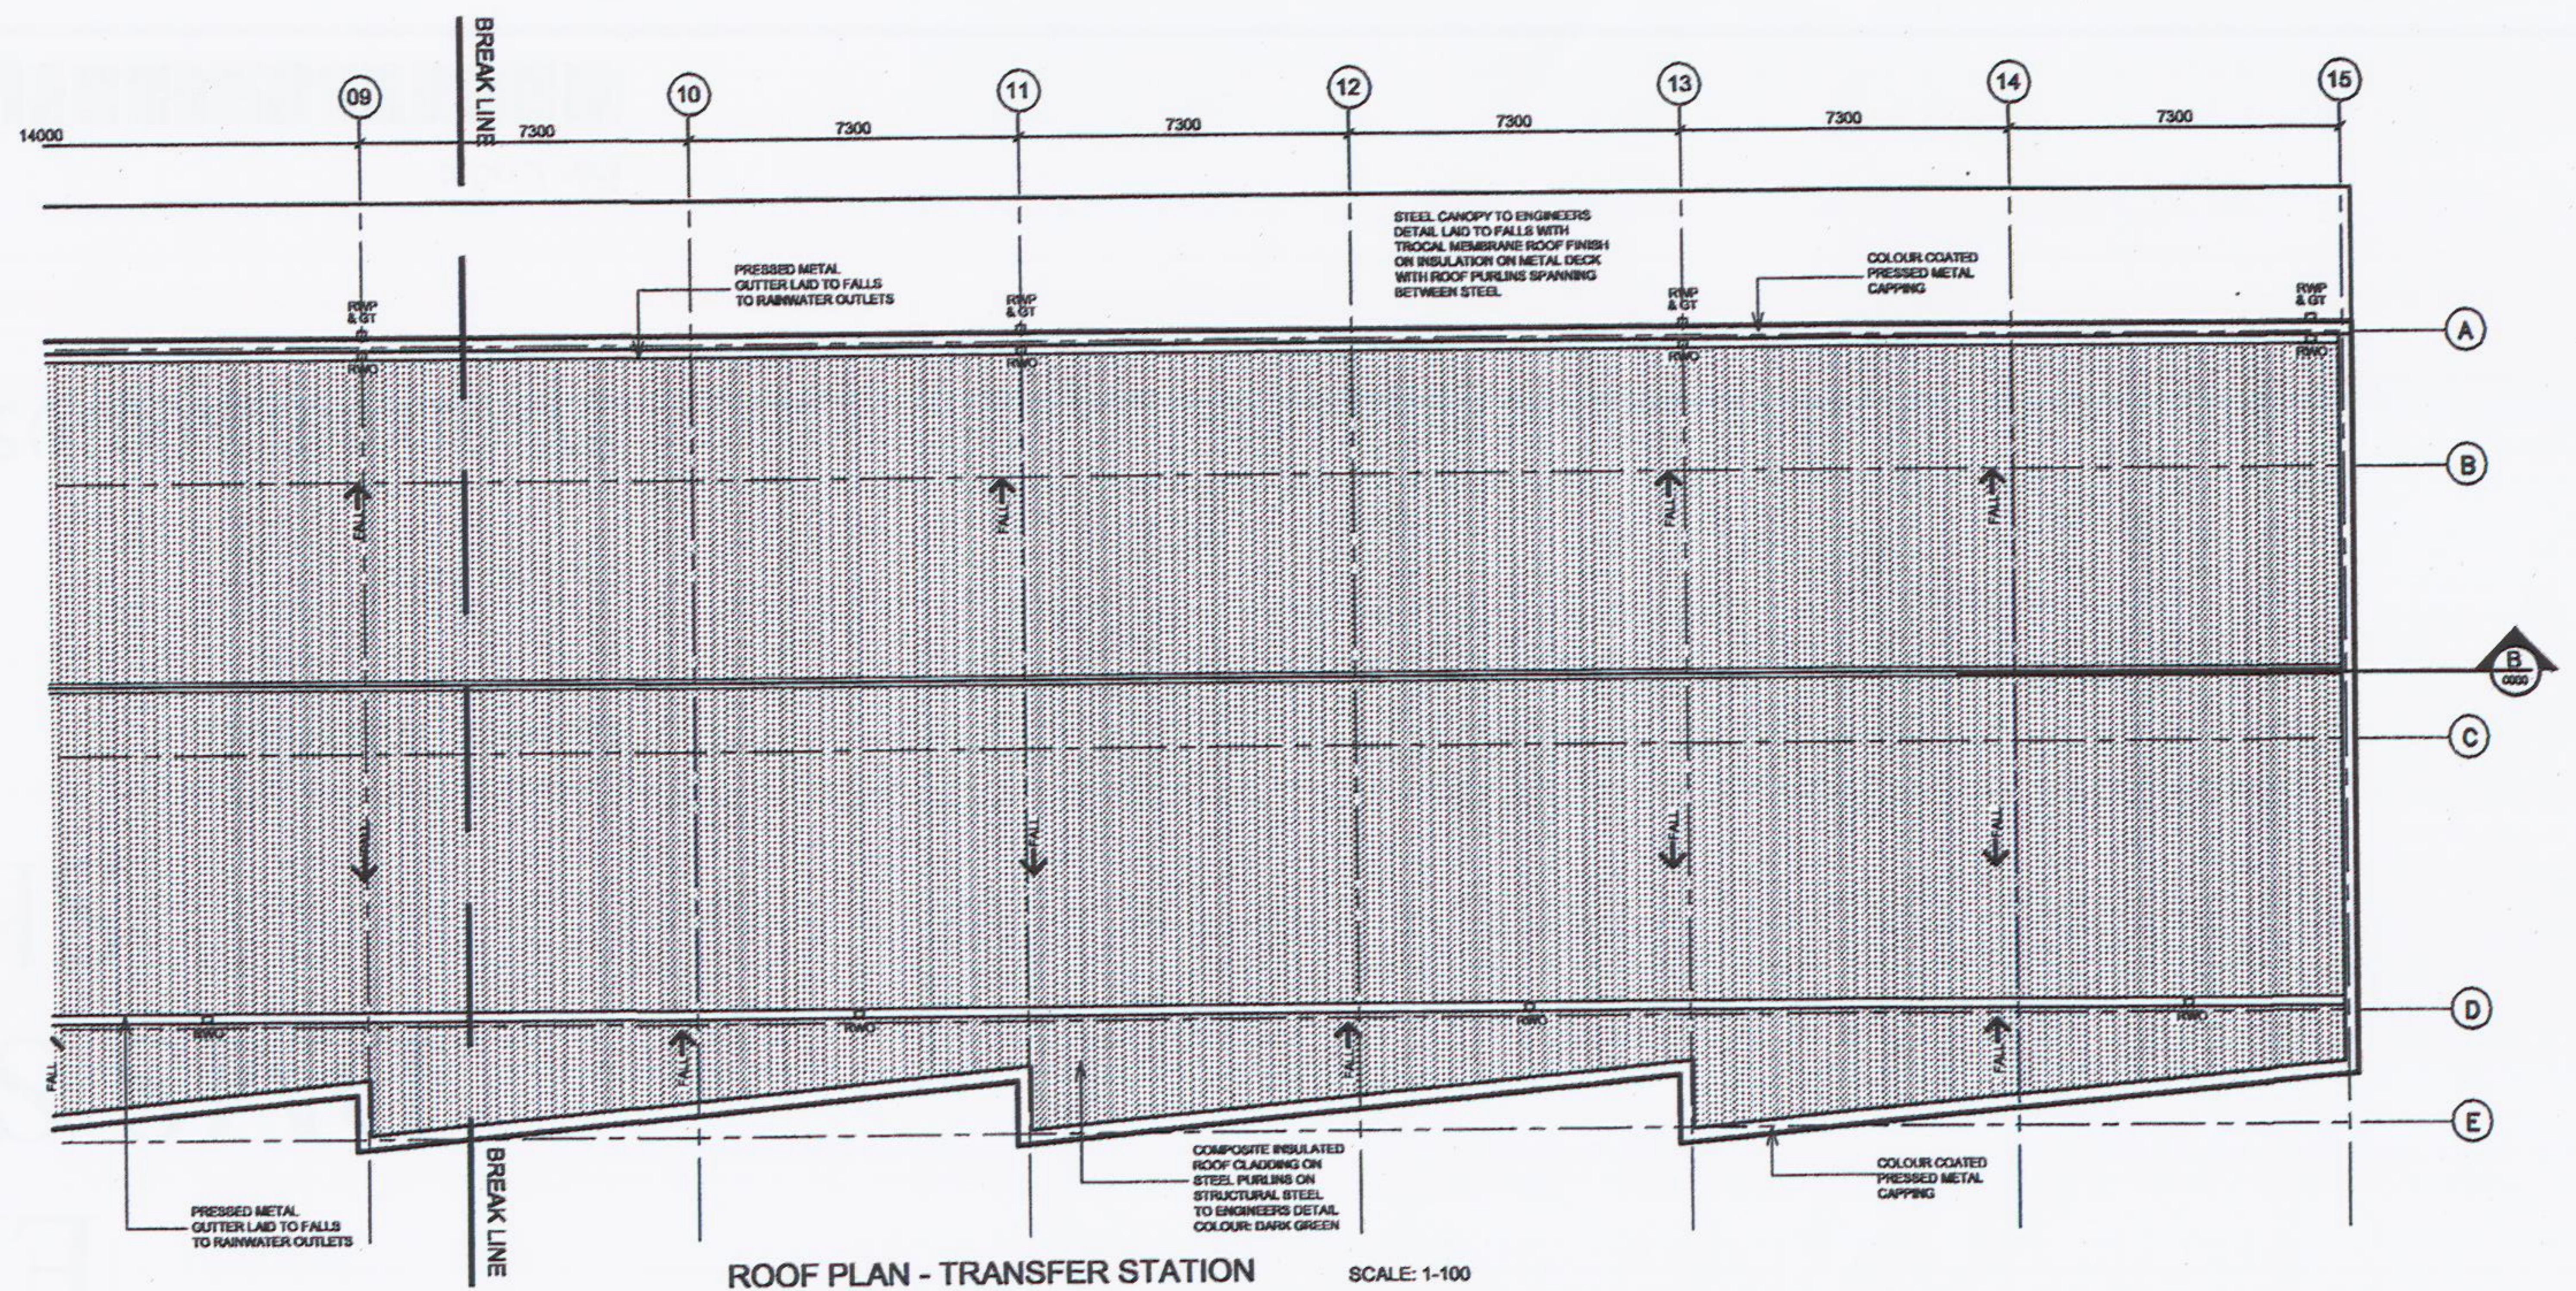


ROOF PLAN - TRANSFER STATION SCALE: 1:100

NOTES

1. THIS DRAWING TO BE READ IN CONJUNCTION WITH ALL RELEVANT ARCHITECTS AND ENGINEERS DRAWINGS AND SPECIFICATIONS.
2. DO NOT SCALE - USE FIGURED DIMENSIONS ONLY.
3. LEVELS ARE GIVEN IN METRES AND RELATE TO O.S. DATUM (RAIN HEAD) 0.00
4. ALL DIMENSIONS ARE GIVEN IN MILLIMETRES.
5. ALL DIMENSIONS TO BE CHECKED ON SITE.

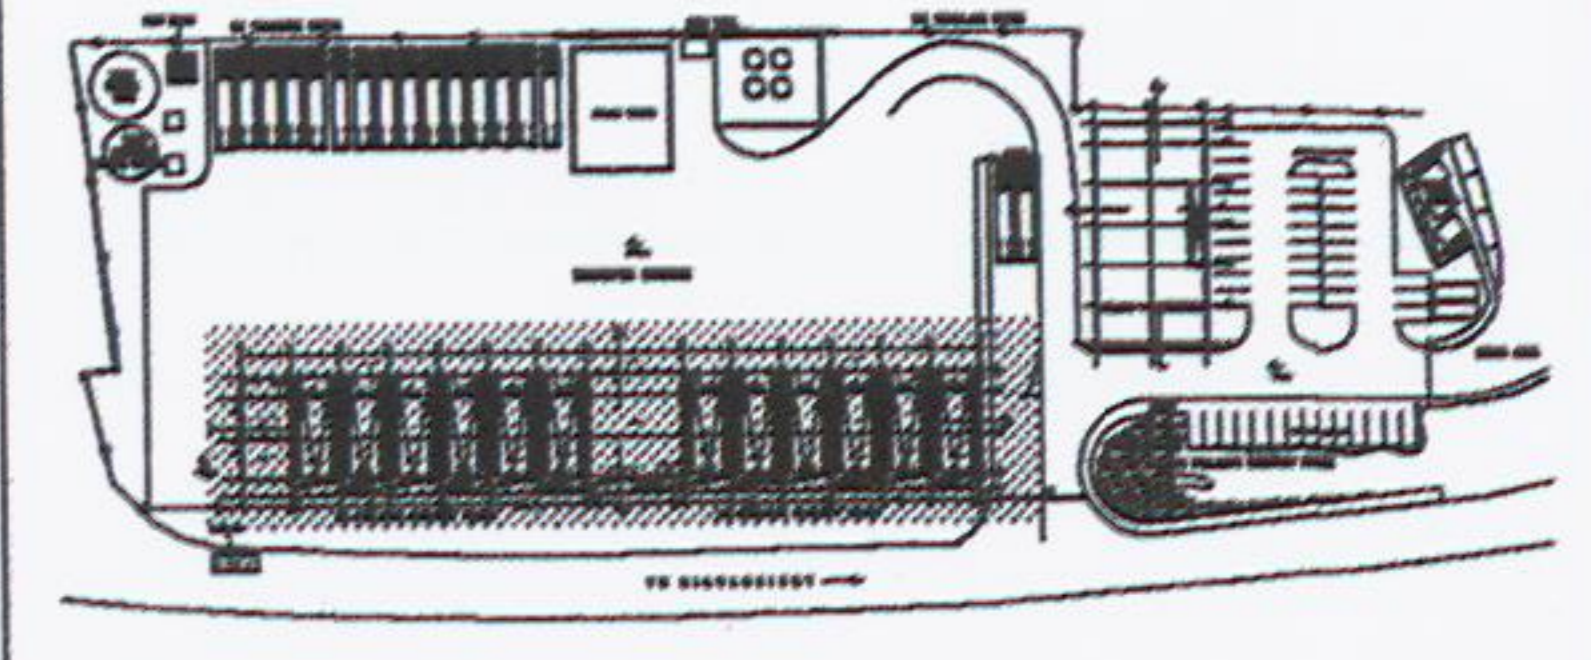

KEY PLAN

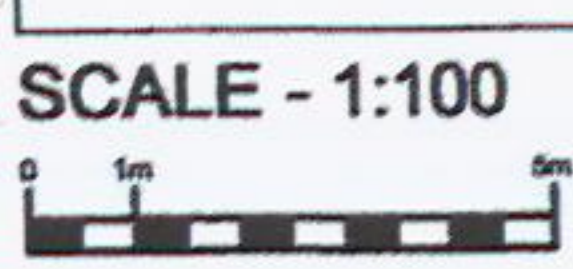

SCALE - 1:100

0	ISSUED FOR PLANNING	DC	FCM	LB	10/1/01
1	DESCRIPTION	CHK	CHK	APP	DATE
		INDAVER IRELAND 4 HANOVER STREET DUN LAOGHAIRE, CO. DUBLIN TEL: +353 1 244850 FAX: +353 1 280355			
PROJECT: WASTE MANAGEMENT FACILITY- RINGASKIDDY					
TITLE: TRANSFER STATION ROOF PLAN					
CLIENT REF.		CLIENT DWG NO.			
PROJECT NO.		CONTR. DWG NO.			
AO	SCALE: 1/200 & 1/100	C05/APP/82/701			