



NOTES

1. THIS DRAWING TO BE READ IN CONJUNCTION WITH ALL RELEVANT ARCHITECTS AND ENGINEERS DRAWINGS AND SPECIFICATIONS.
2. DO NOT SCALE - USE FIGURED DIMENSIONS ONLY.
3. LEVELS ARE GIVEN IN METRES AND RELATE TO O.S. DRAIN GULLY HEAD, G.O.
4. ALL DIMENSIONS ARE GIVEN IN METRES.
5. ALL DIMENSIONS TO BE CHECKED ON SITE.

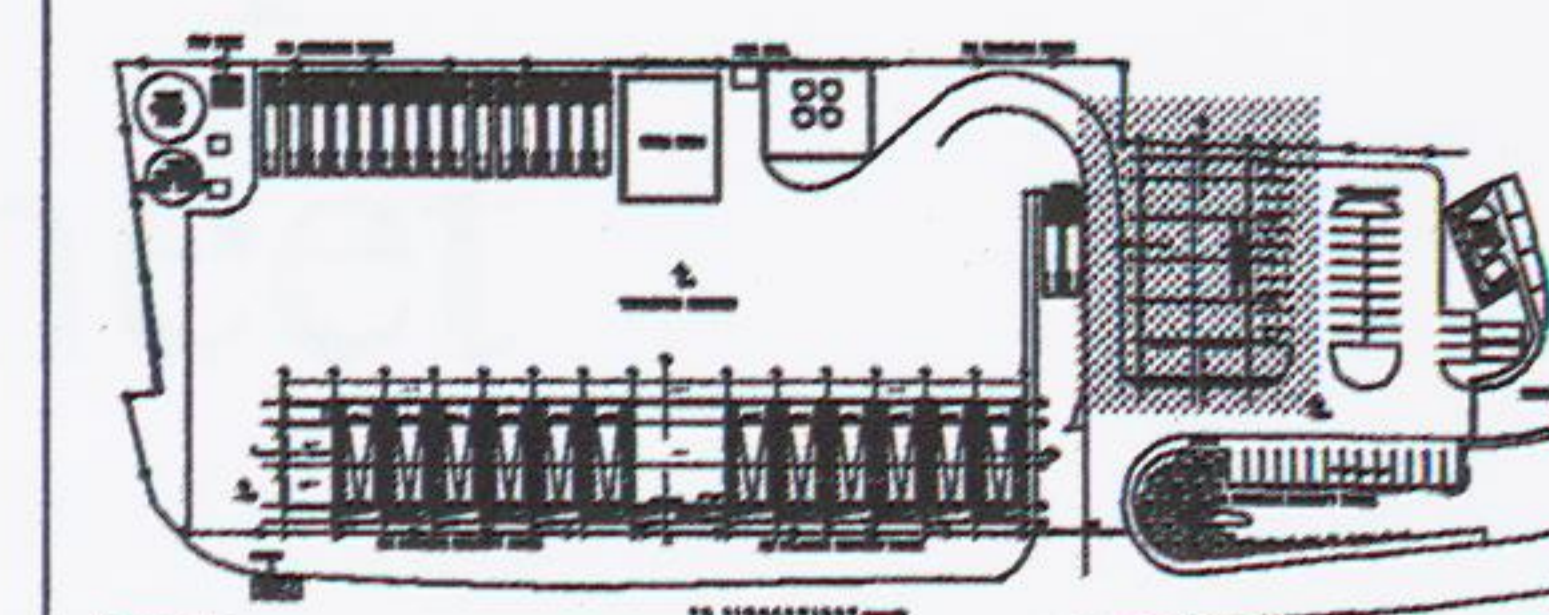

KEY PLAN

SCALE - 1:100

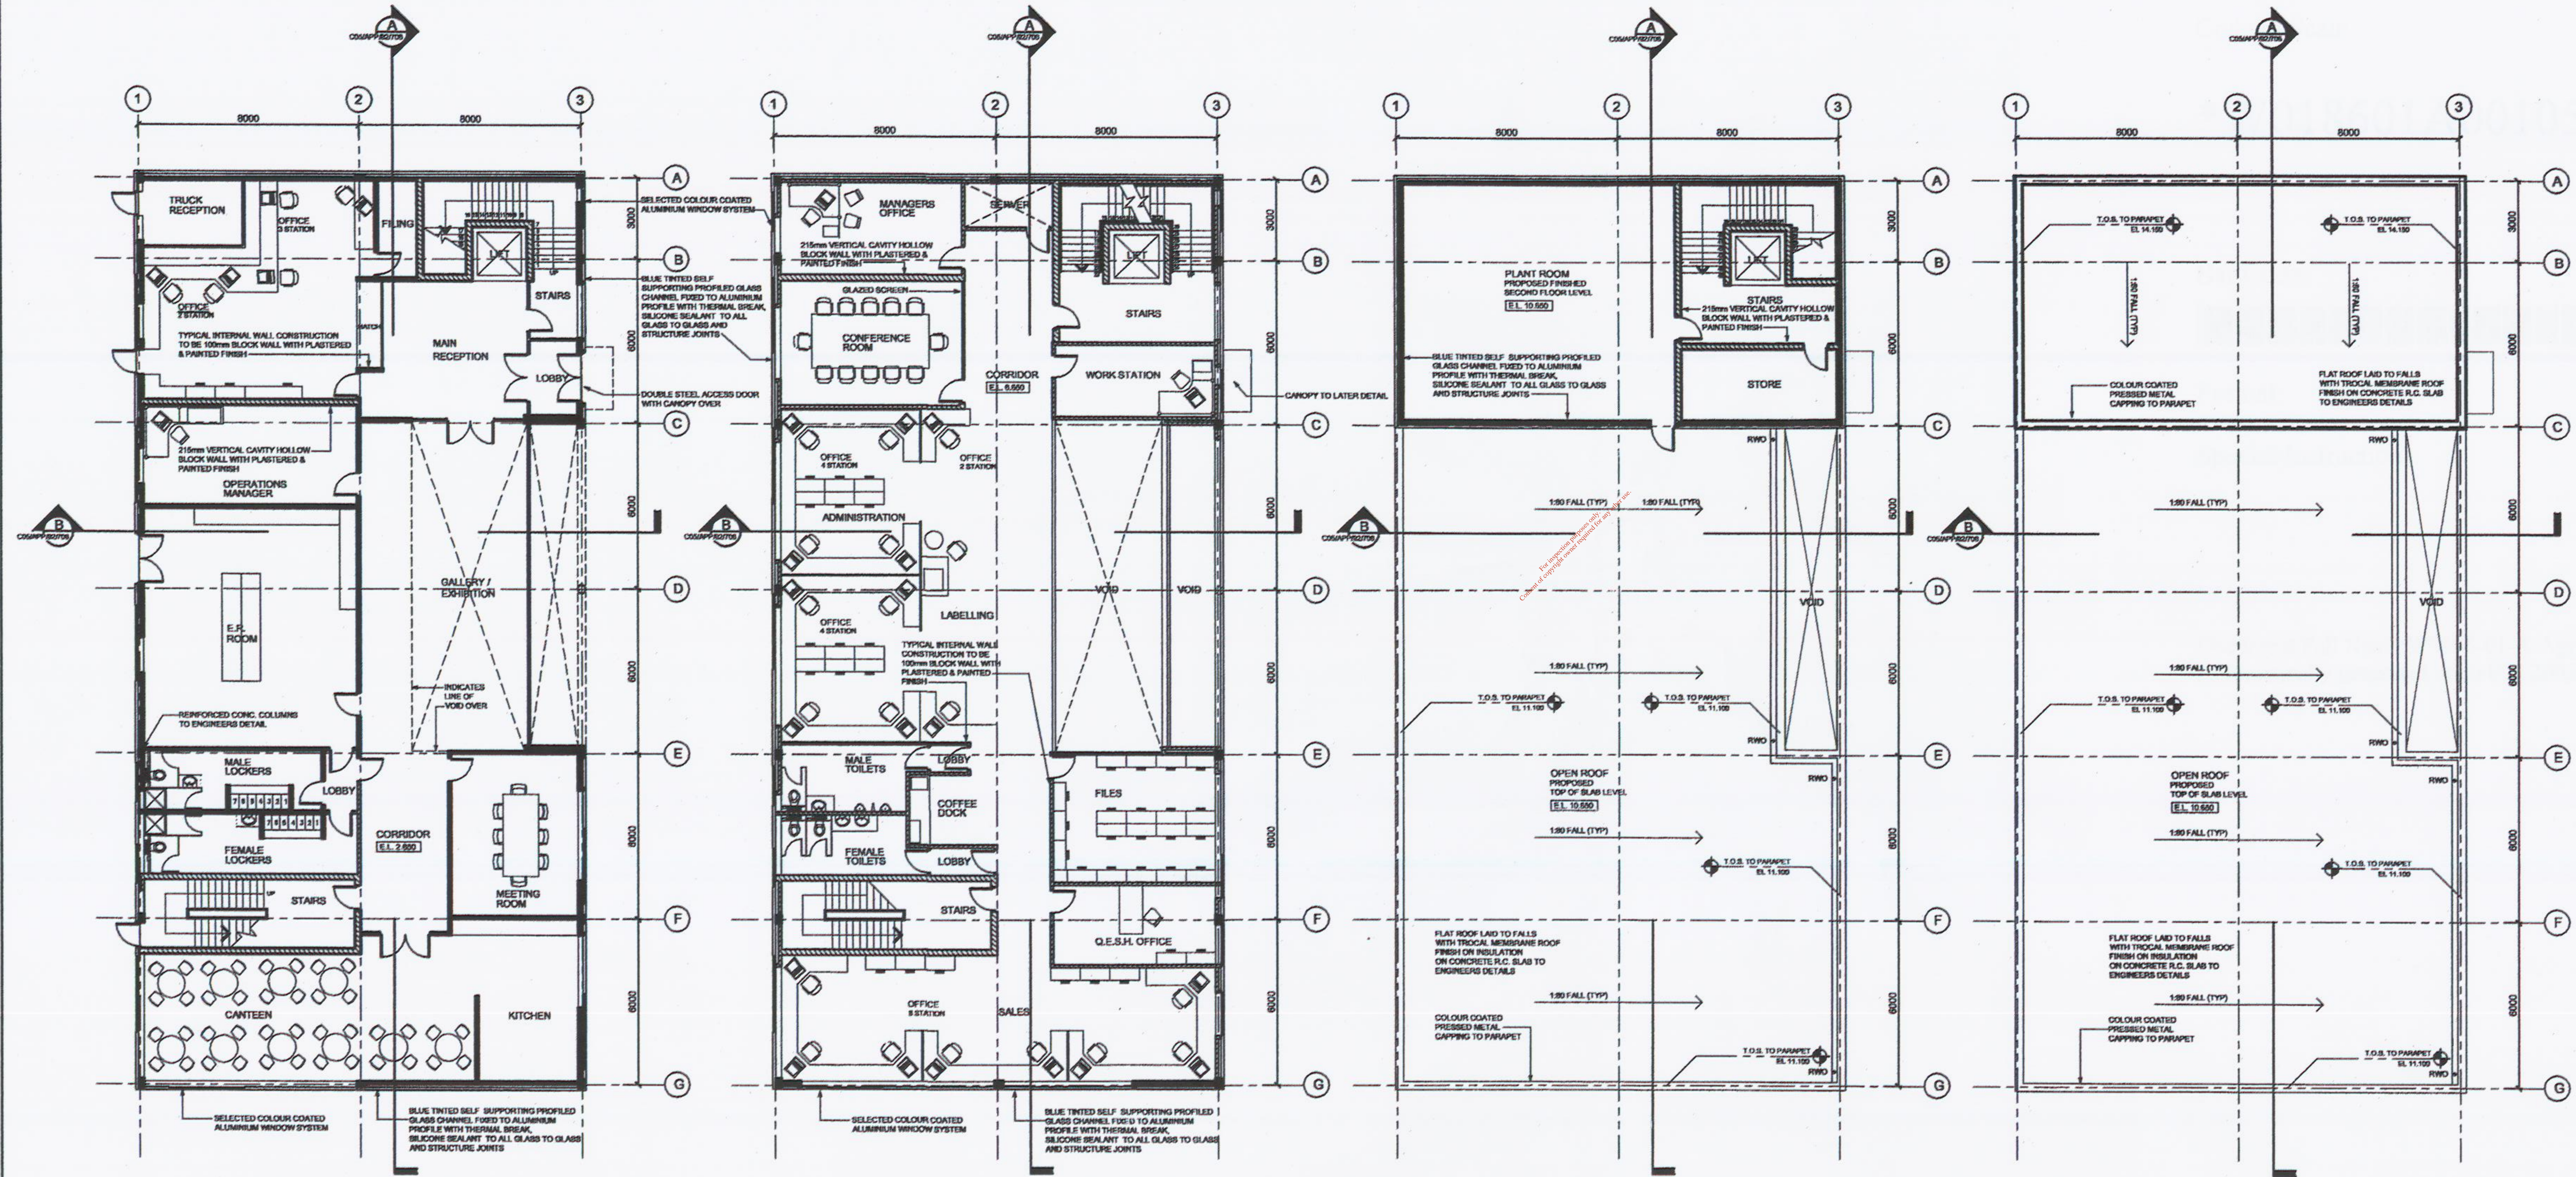

GROUND FLOOR - ADMINISTRATION BLOCK

FIRST FLOOR - ADMINISTRATION BLOCK

PLANT ROOM PLAN - ADMINISTRATION BLOCK

ROOF PLAN - ADMINISTRATION BLOCK

0	ISSUED FOR PLANNING	DC	FOR	LB	10/1/05
1	DESCRIPTION	DRN	CHK	APP	DATE
		INDAVER IRELAND 4 HADDINGTON TCE DEN LAGHARE CO. DUBLIN TEL: +353 1 214880 FAX: +353 1 206280			
				WILSON ASSOCIATES ARCHITECTS	
PROJECT: WASTE MANAGEMENT FACILITY- RINGASKIDDY					
TITLE: ADMINISTRATION BUILDING FLOOR PLANS					
CLIENT REF:		CLIENT DRG No:			
PROJECT No:		CITY/TA DRG No:			
AD	SCALE 1/100	CITY/TA DRG No:		CO5/APP/92/705	