



NOTES

1. THIS DRAWING TO BE READ IN CONJUNCTION WITH ALL RELEVANT ARCHITECTURAL AND ENGINEERS DRAWINGS AND SPECIFICATIONS.
2. DO NOT SCALE - USE FIGURED DIMENSIONS ONLY.
3. LEVELS ARE GIVEN IN METERS AND RELATE TO O.S. DATUM (SEA LEVEL) UNLESS OTHERWISE STATED.
4. ALL DIMENSIONS ARE GIVEN IN METRES.
5. ALL DIMENSIONS TO BE CHECKED ON SITE.

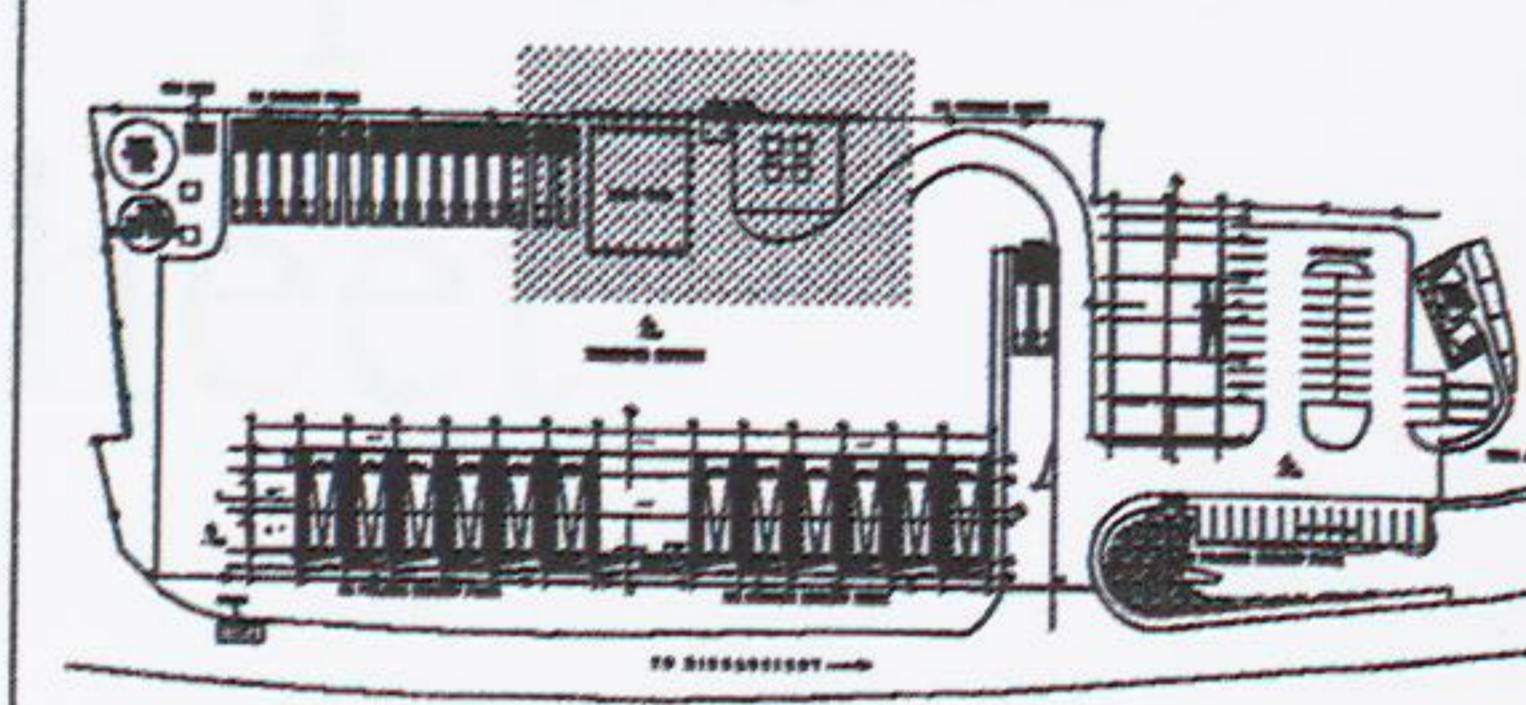


KEY PLAN



SCALE - 1:100

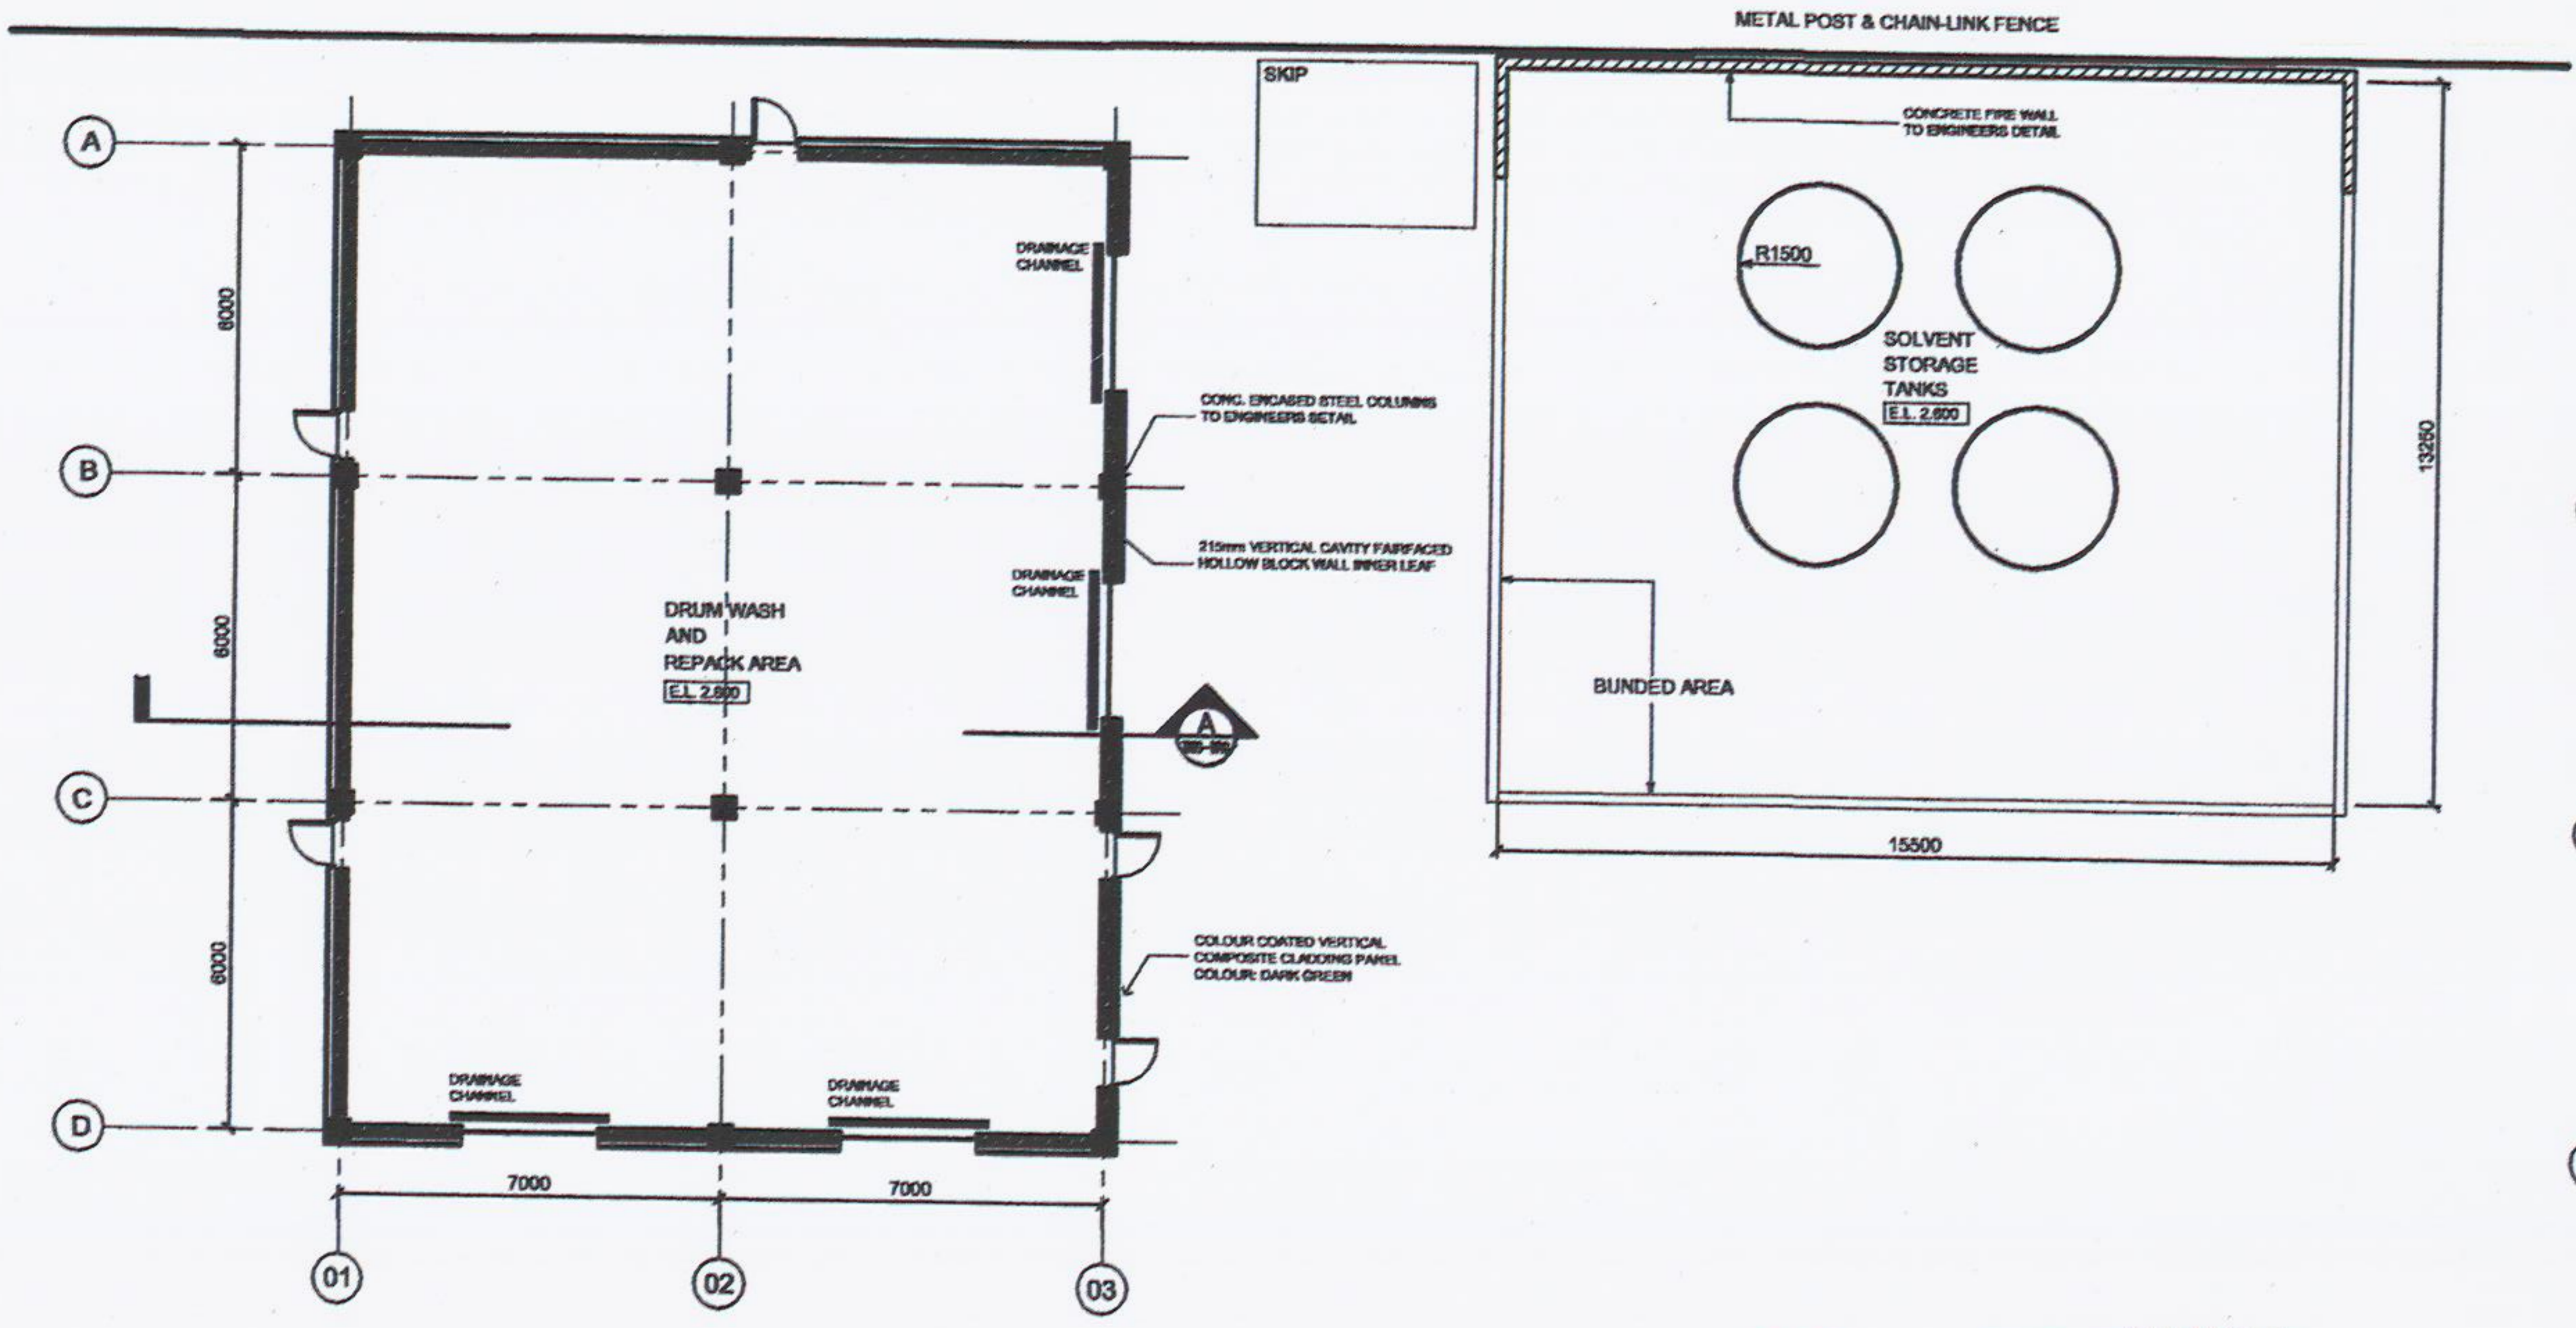


GROUND FLOOR PLAN - DRUM WASH

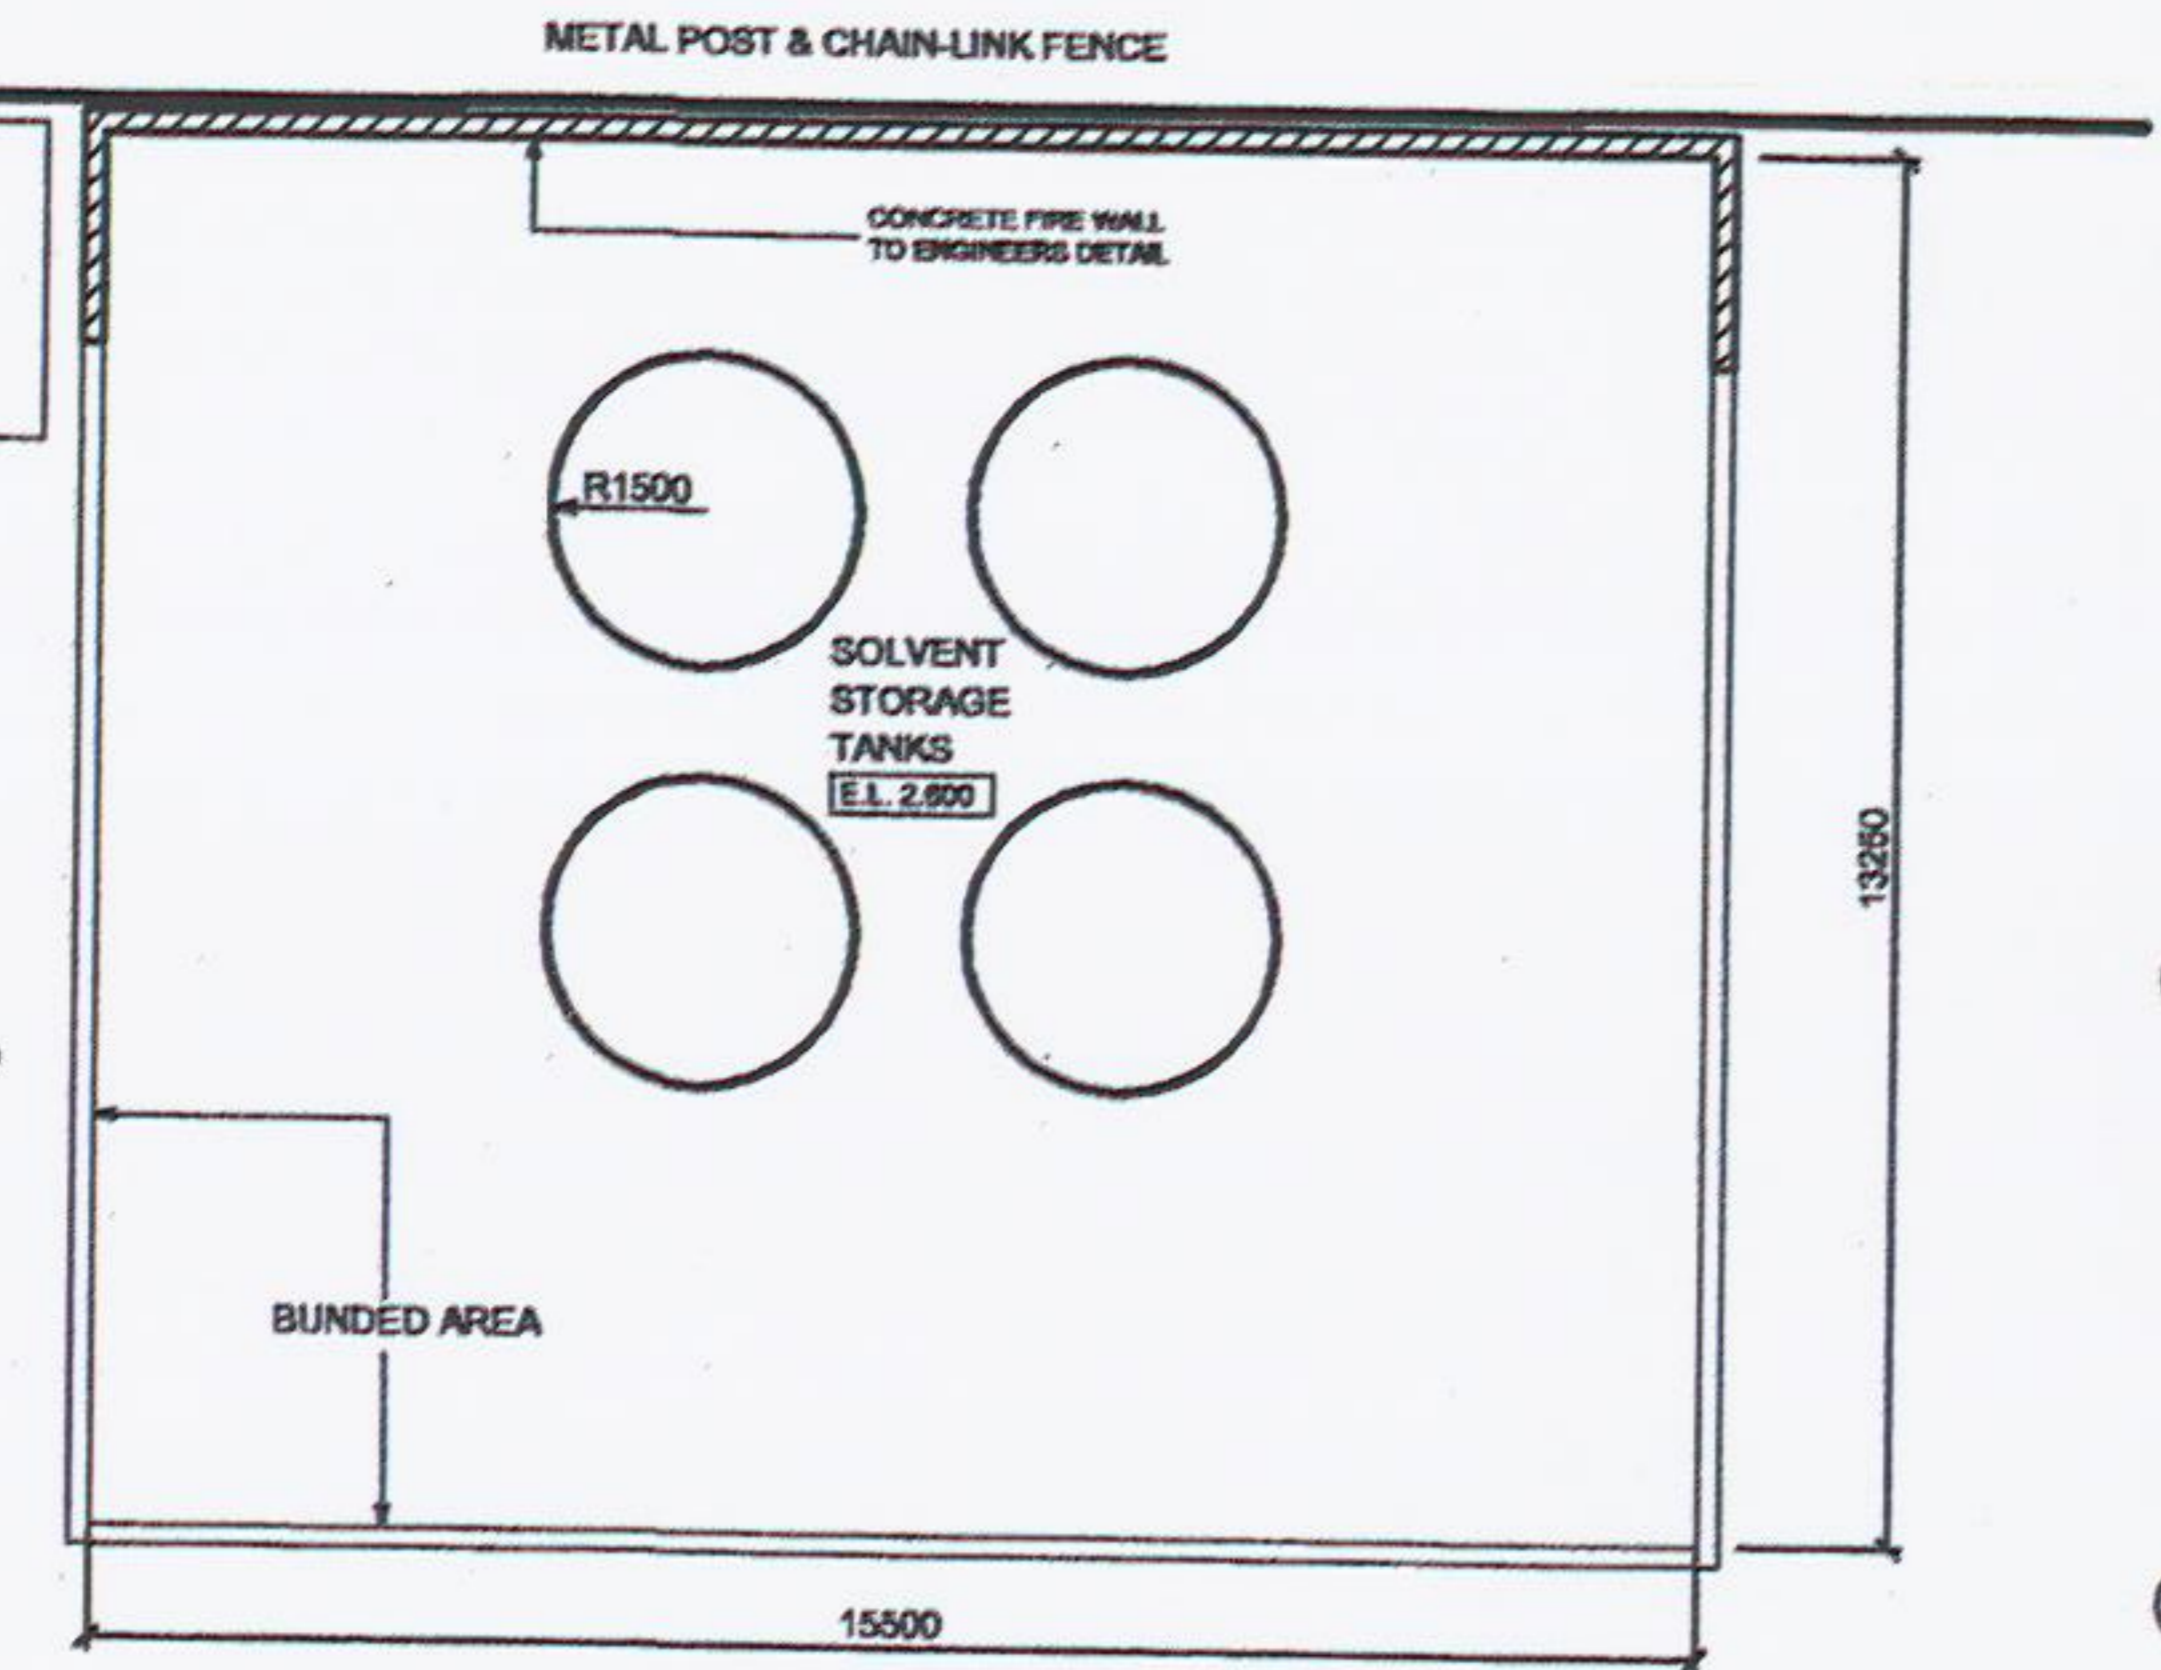

ROOF PLAN - DRUM WASH

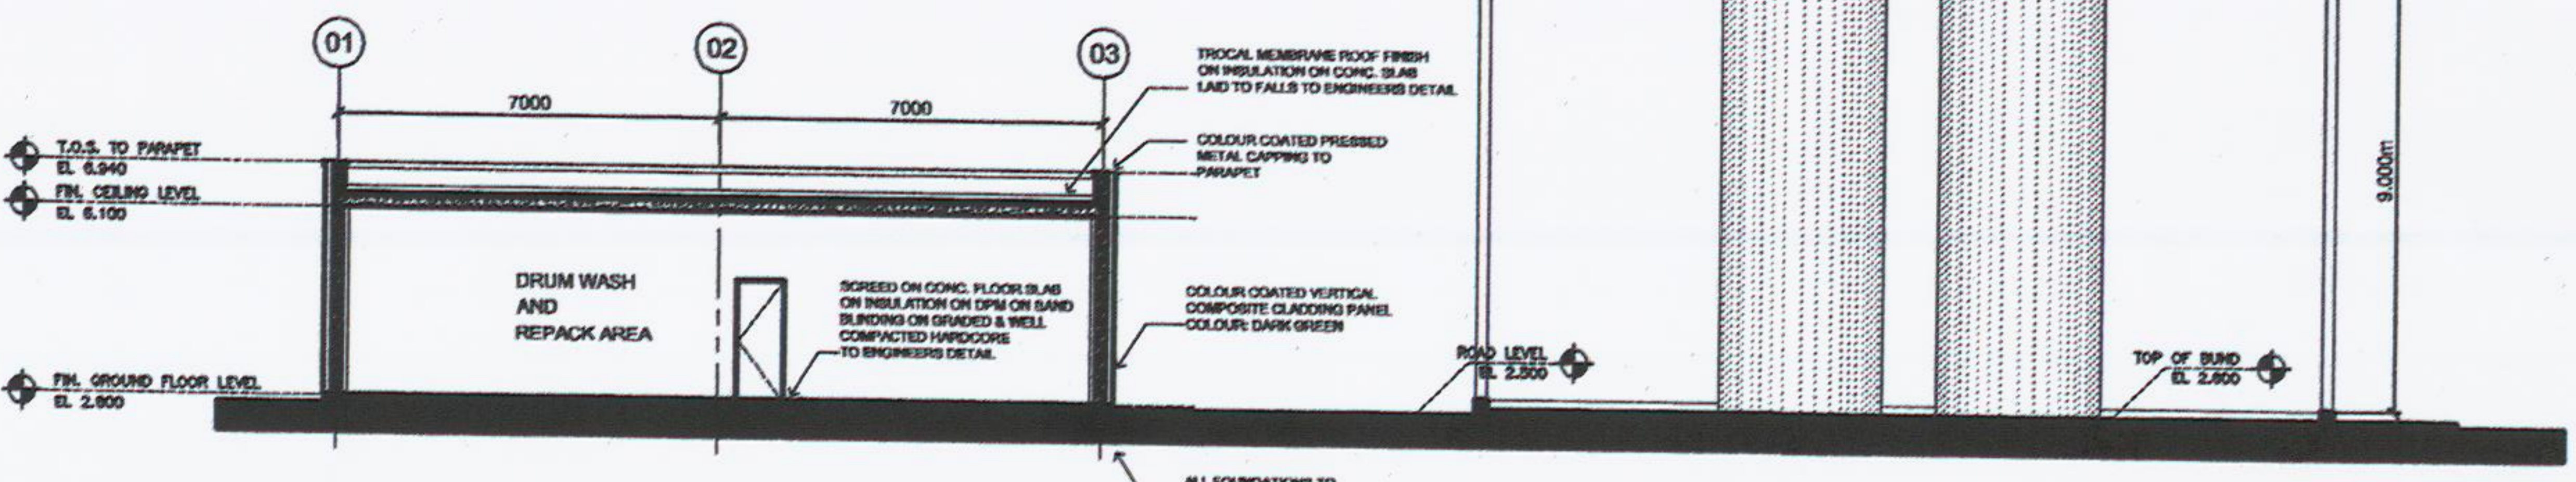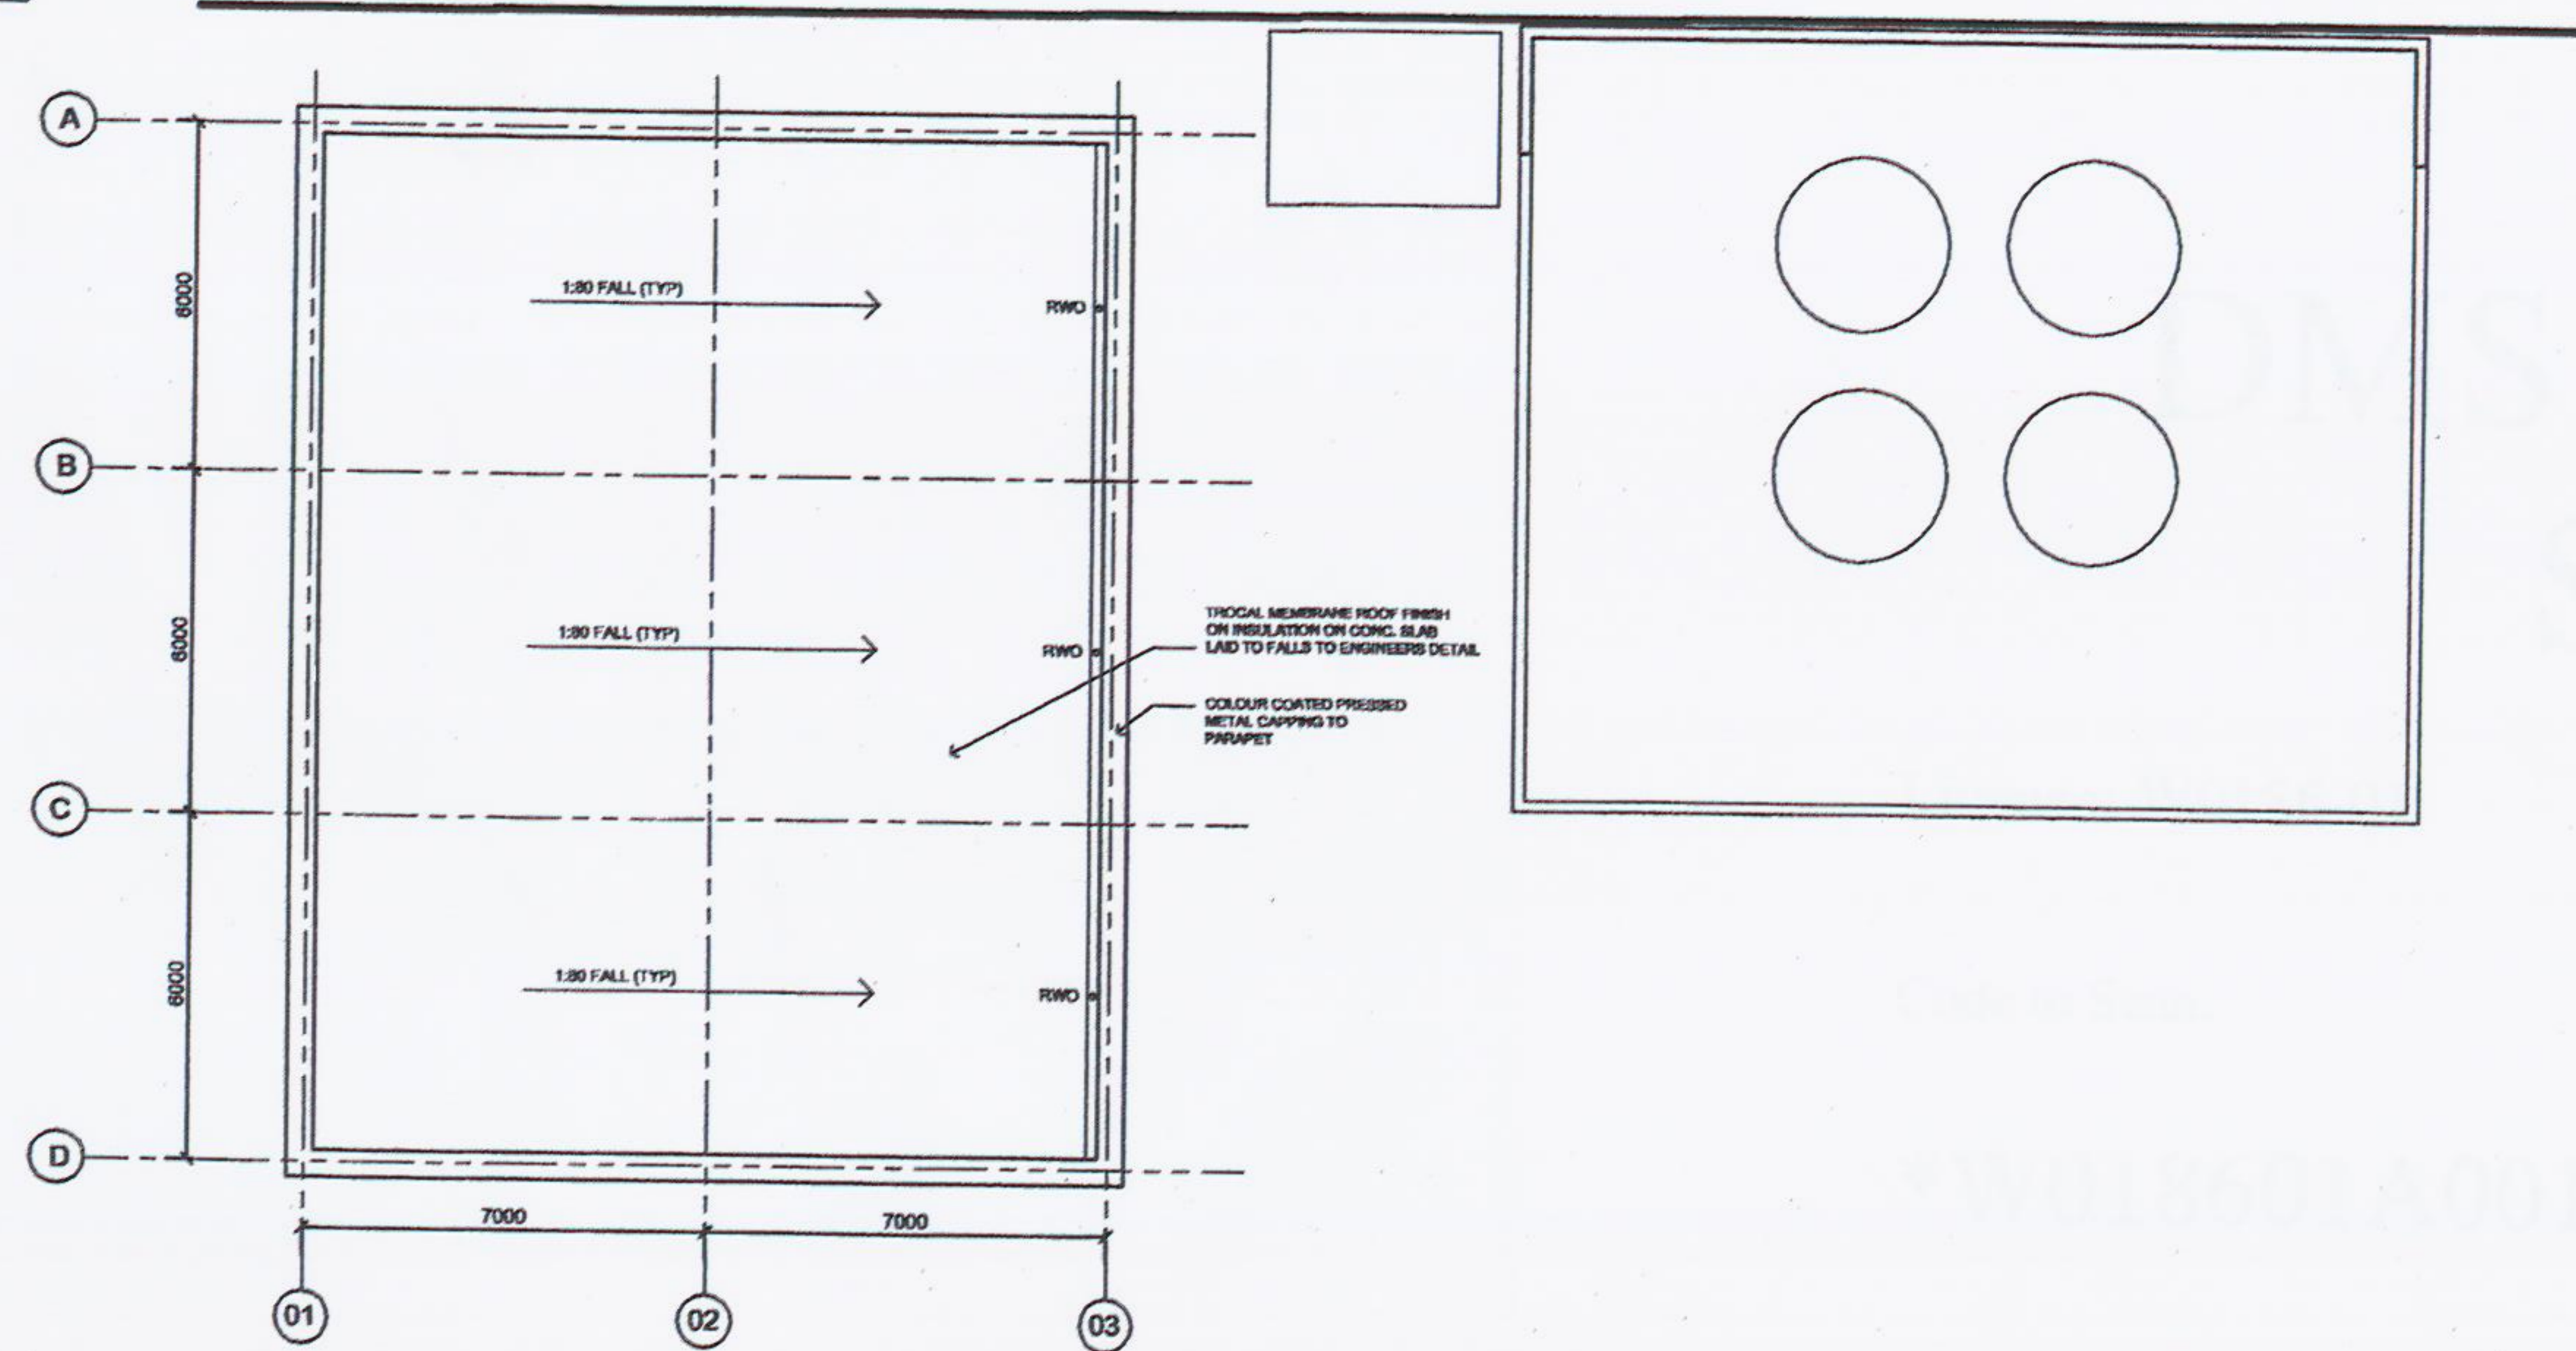

SECTION A-A - DRUM WASH

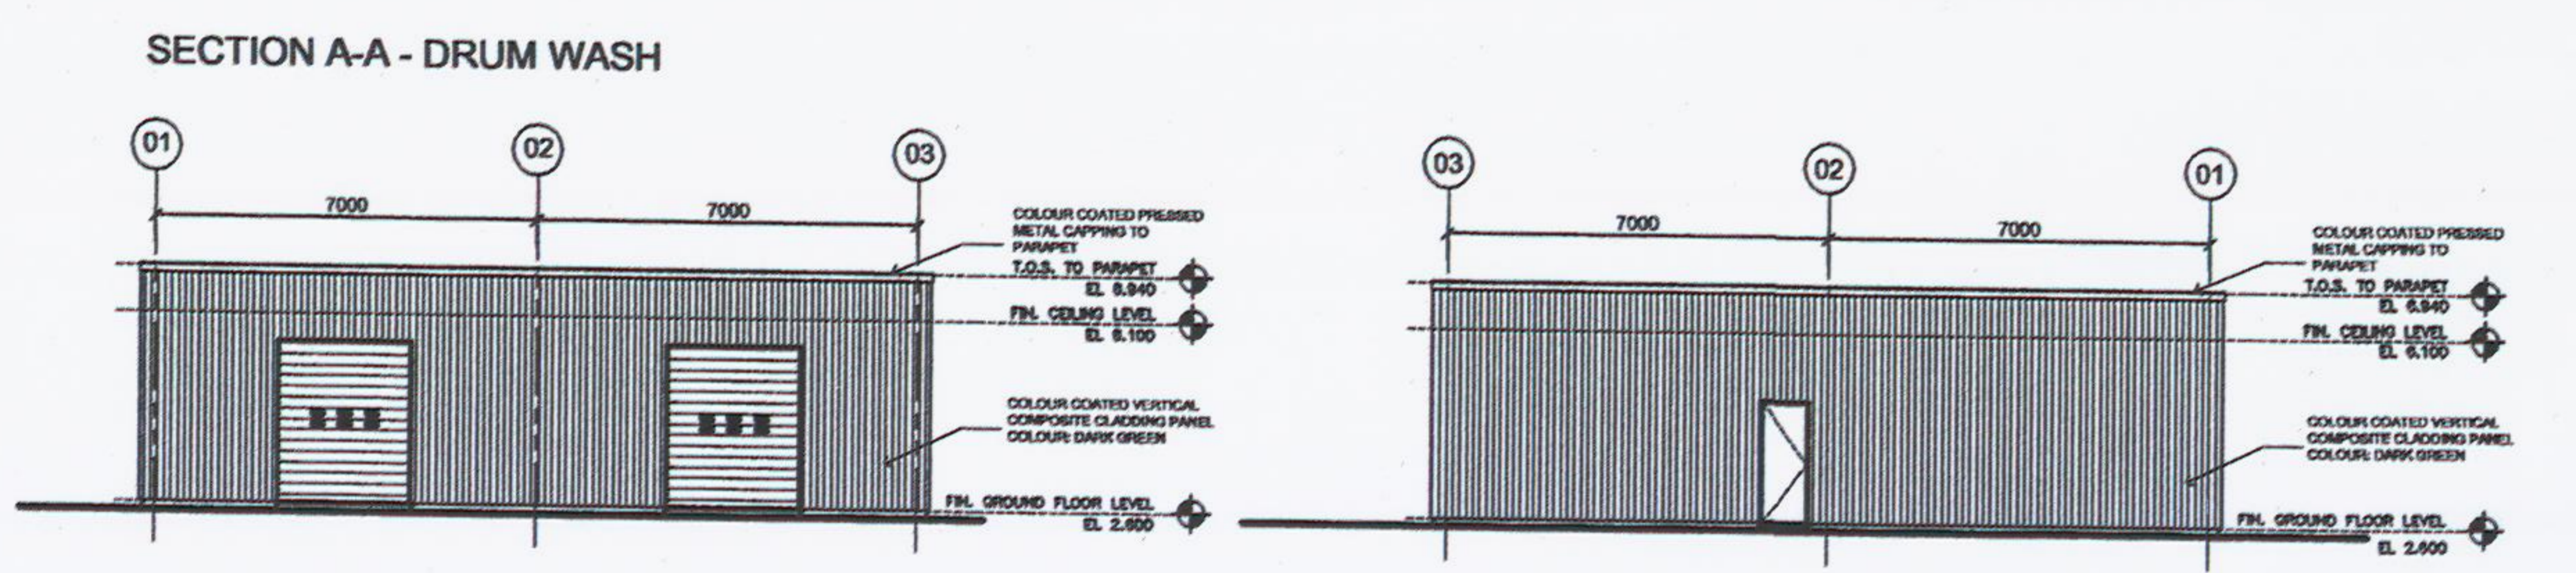


NORTH ELEVATION - DRUM WASH

SOUTH ELEVATION - DRUM WASH

EAST ELEVATION - DRUM WASH


WEST ELEVATION - DRUM WASH

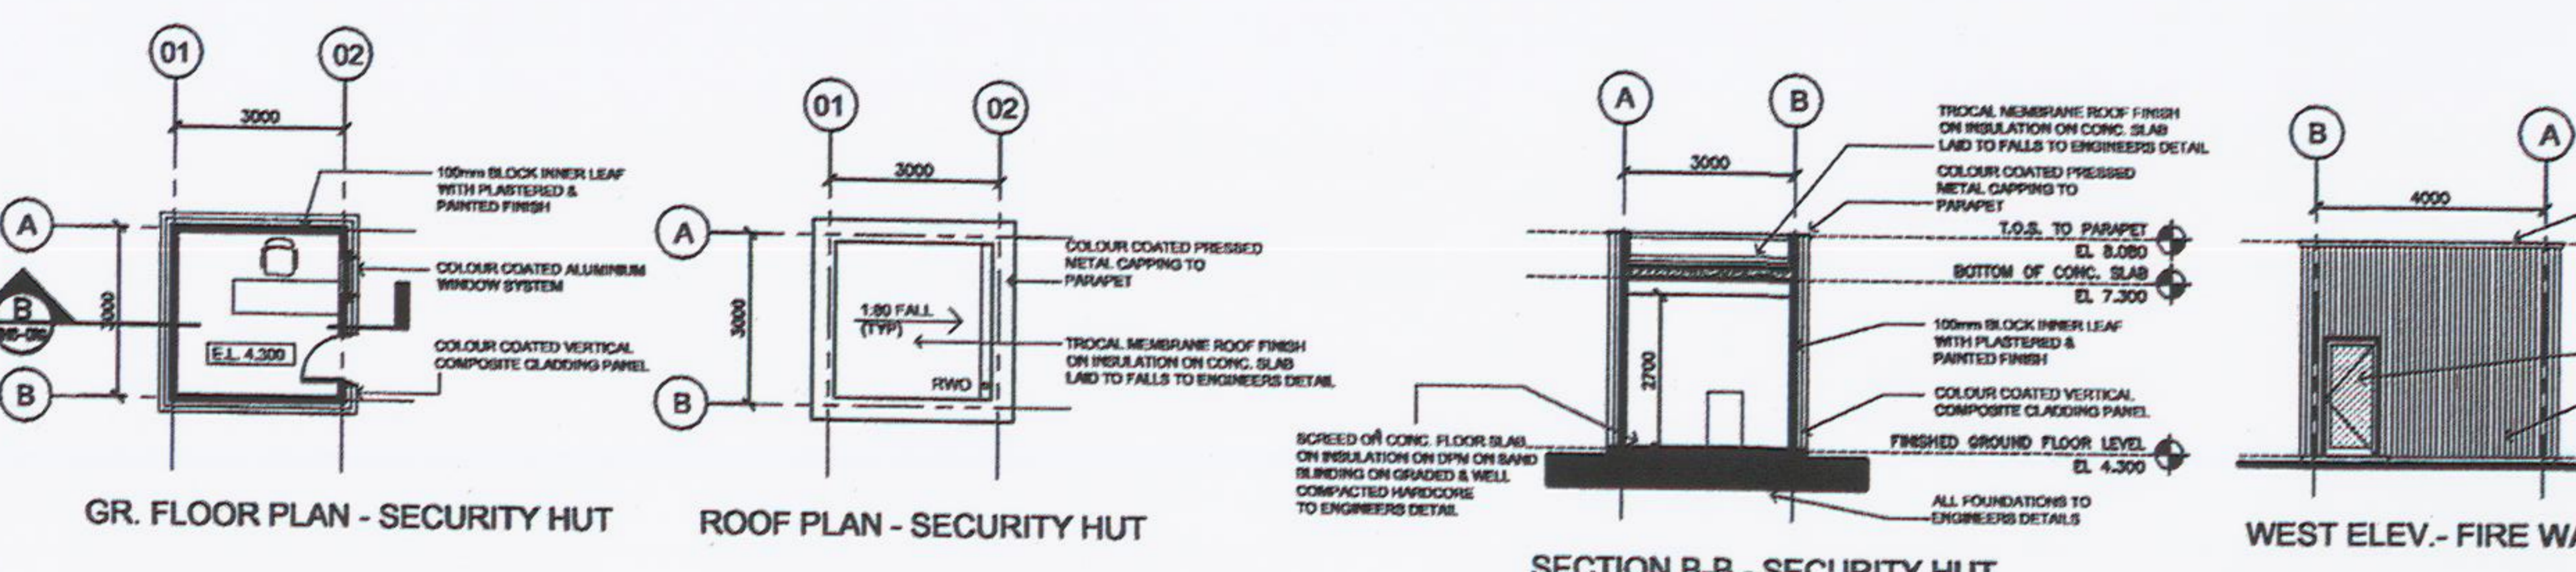

GR. FLOOR PLAN - SECURITY HUT

ROOF PLAN - SECURITY HUT

SECTION B-B - SECURITY HUT

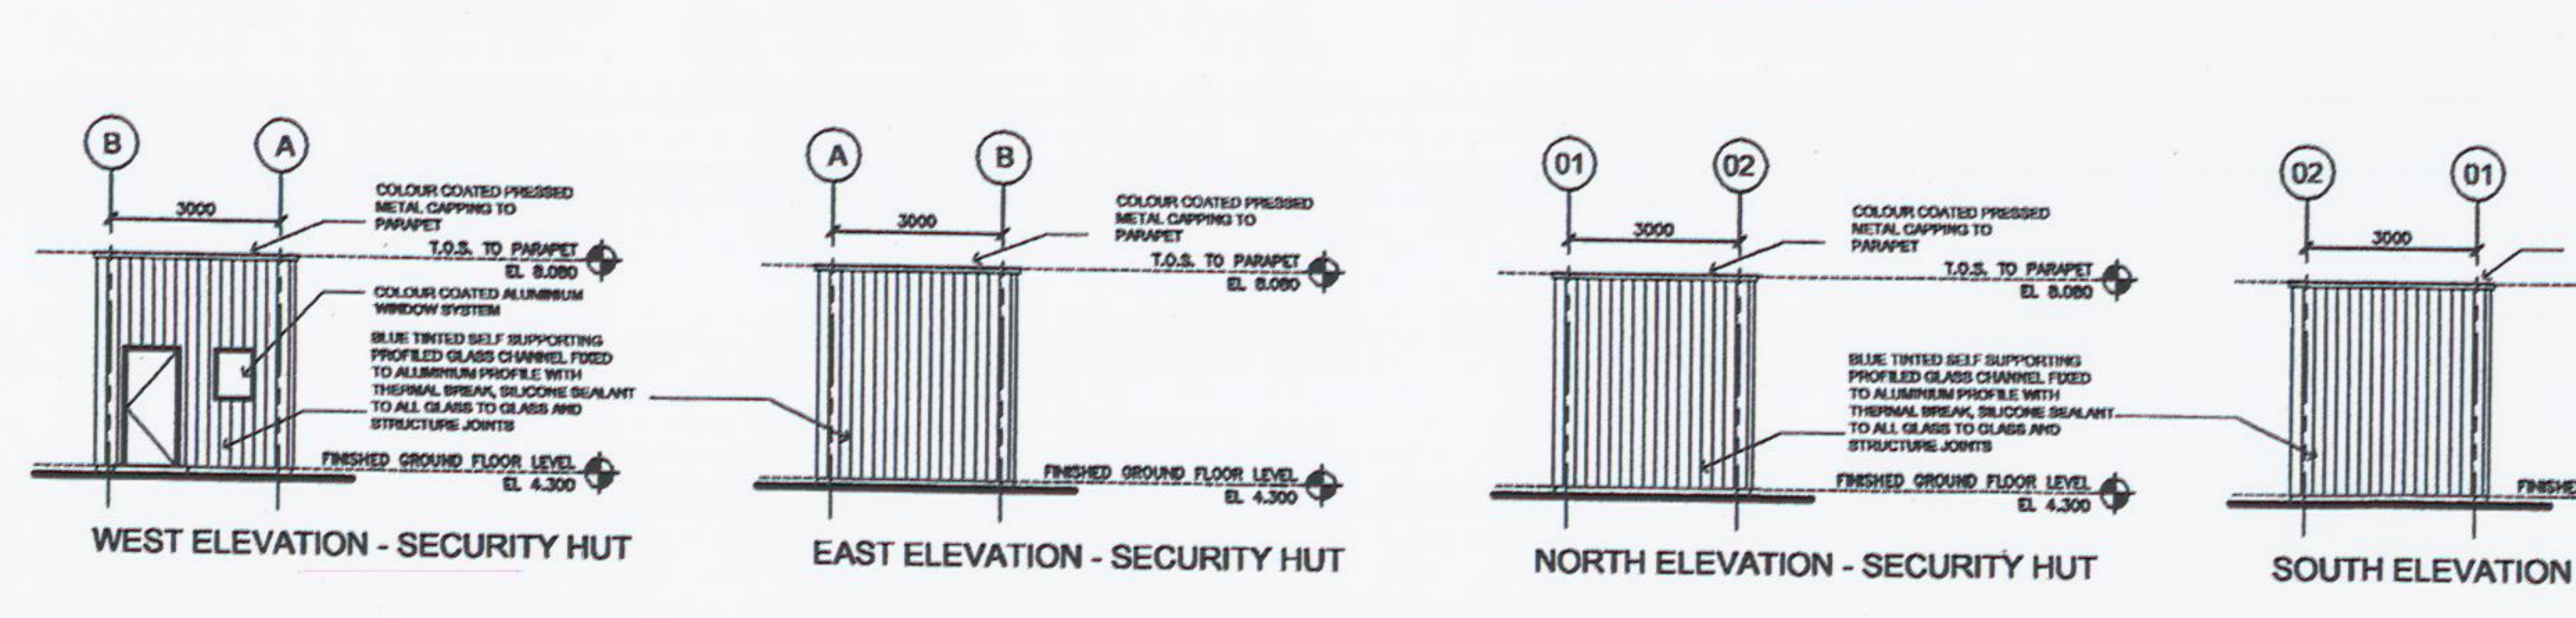


WEST ELEVATION - SECURITY HUT

EAST ELEVATION - SECURITY HUT

NORTH ELEVATION - SECURITY HUT

SOUTH ELEVATION - SECURITY HUT

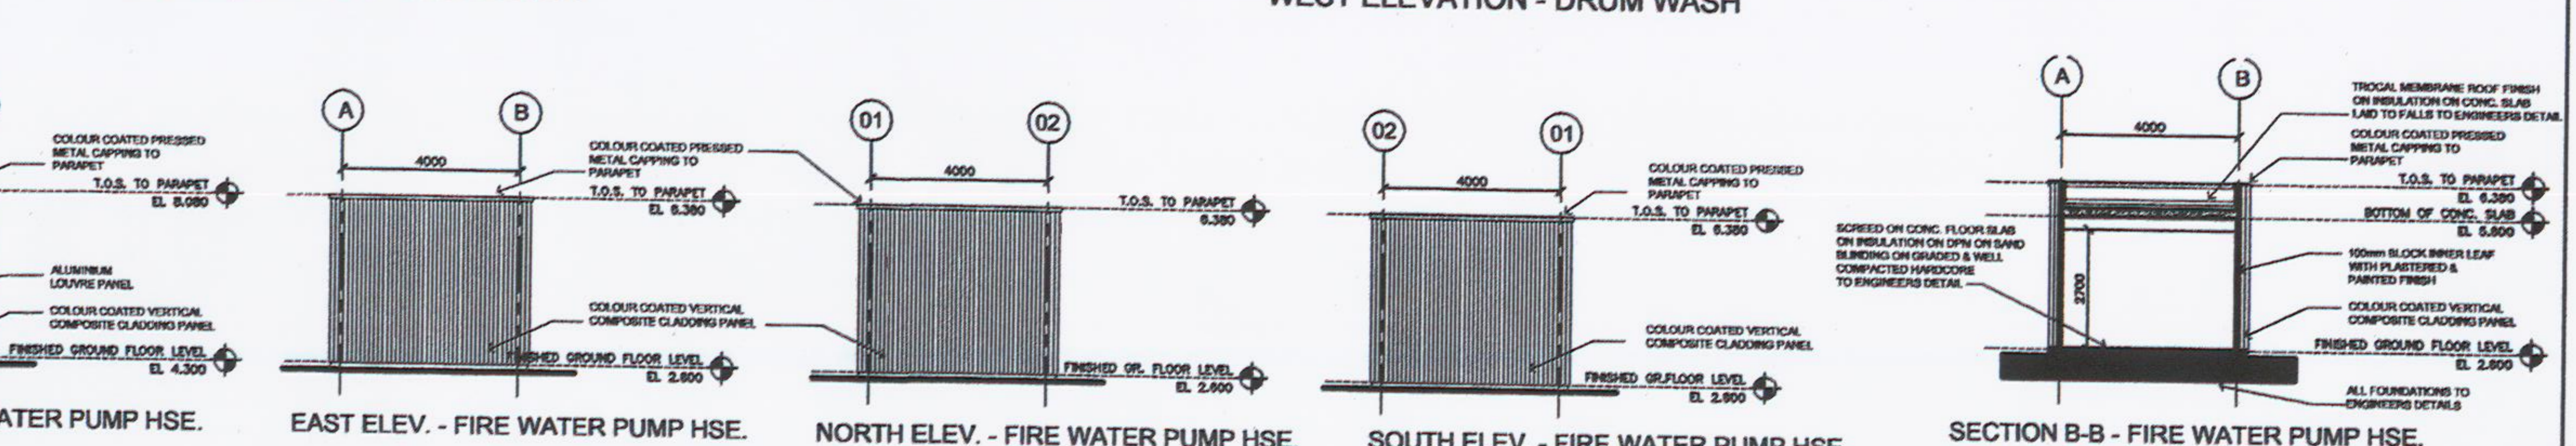


WEST ELEV. - FIRE WATER PUMP HSE.

EAST ELEV. - FIRE WATER PUMP HSE.

NORTH ELEV. - FIRE WATER PUMP HSE.

SOUTH ELEV. - FIRE WATER PUMP HSE.

SECTION B-B - FIRE WATER PUMP HSE.

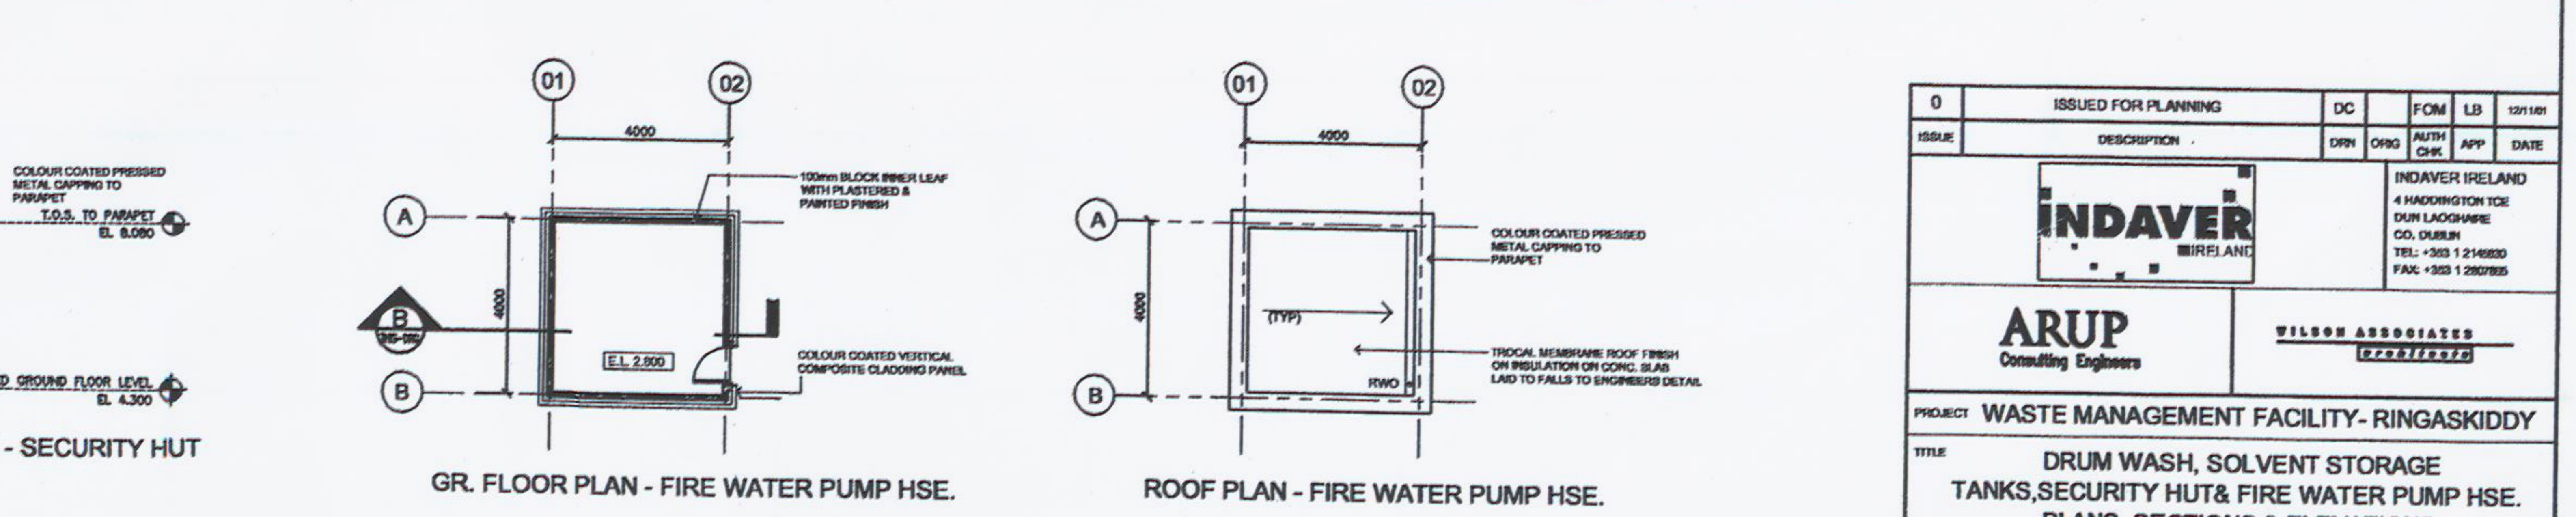

GR. FLOOR PLAN - FIRE WATER PUMP HSE.

ROOF PLAN - FIRE WATER PUMP HSE.

ISSUE	DESCRIPTION	DC	FCM	LD	DATE
0	ISSUED FOR PLANNING				10/11/01

		INDAVER IRELAND 4 HADDINGTON TICE DUBLIN LAGHARE CO. DUBLIN TEL: +353 1 2148800 FAX: +353 1 202085	
		WILSON ASSOCIATES CONSULTANTS	
PROJECT: WASTE MANAGEMENT FACILITY- RINGASKIDDY TITLE: DRUM WASH, SOLVENT STORAGE TANKS, SECURITY HUT & FIRE WATER PUMP HSE. PLANS, SECTIONS & ELEVATIONS			
CLIENT REF.:	CLIENT ENG. No.		
PROJECT No.	CONTR. ENG. No.	CO5/APP/92/707	
AD	SCALE: 1:100		