

Placeholder


This page has been inserted to indicate that content has been extracted from this location in the document and has been stored in a separate file.
(This is due to file size issues.)

The extracted content can be found in the following electronic pdf file:

EIS-Drawing-1

Licence: W0221-01

For inspection purposes only.
Consent of copyright owner required for any other use.

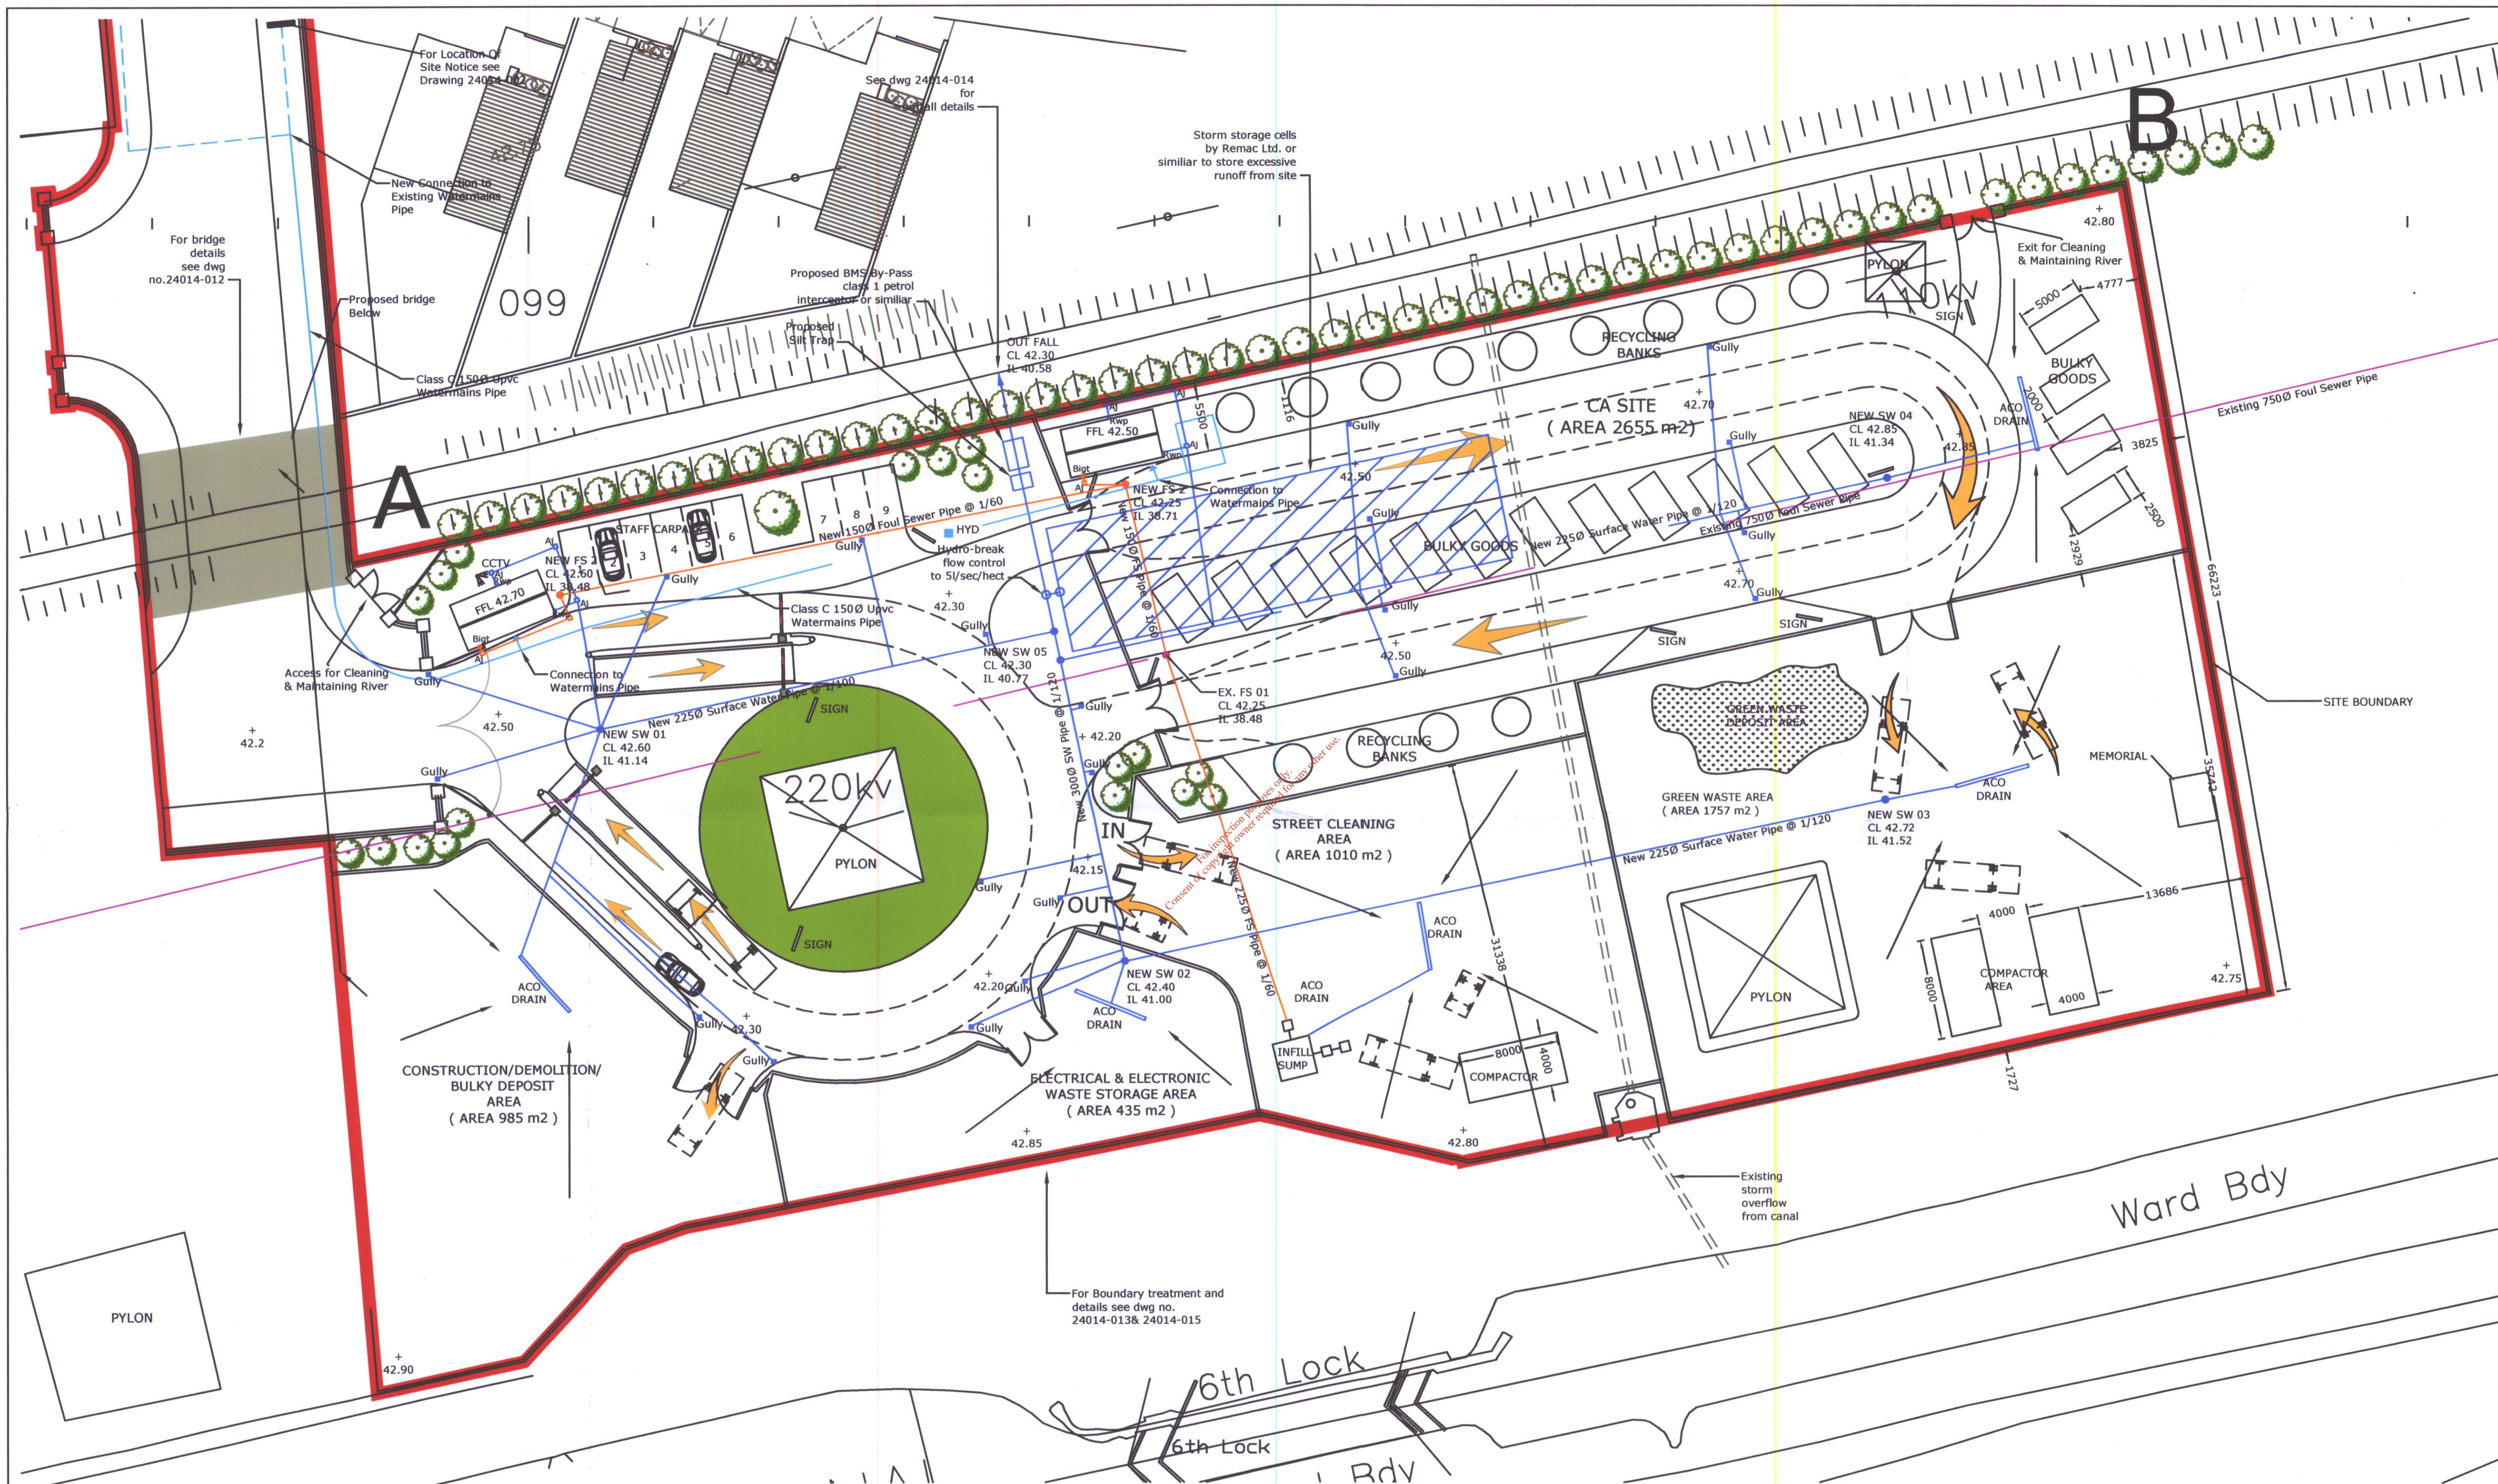

PROPOSED SITE LAYOUT PLAN
 SCALE 1:250
 SITE AREA : 11053 m2
 OS LICENCE : AR0037504
 OS REF : 3262-18 & 23

LEGEND	
EXISTING FOUL SEWER PIPE	
EXISTING FOUL SEWER MANHOLE	
PROPOSED FOUL SEWER PIPE	
PROPOSED FOUL SEWER MANHOLE	
PROPOSED SURFACE WATER PIPE	
PROPOSED SURFACE WATER MANHOLE	
PROPOSED WATERMAINS PIPE	
EXISTING WATERMAINS PIPE	
HYDRANT	
GULLYS	
DIRECTION OF FLOW	

OFFICE	Civil		
REVISIONS	BY	DATE	
A/ Site layout and Entrance Revised	EPP	14/12/04	
B/ Petrol Interceptor and silt trap added	DR	24/3/05	
C/			
D/			
E/			
DRAWN	AR	CHECKED	SURVEYED
			DATE 05/05/2004

Drawing Status	Planning		
VCL Consultants			
12 Ashdale, Wheaton Hall, Drogheda (041) 9839958			
Client	DUBLIN CITY COUNCIL		DRAWING TITLE PROPOSED DRAINAGE PLAN
Job Title	C . A SITE LABRE PARK		
SCALES	1:250	DRAWING No.	24014-003B