



N1 CARRIAGEWAY
DUBLIN BELFAST

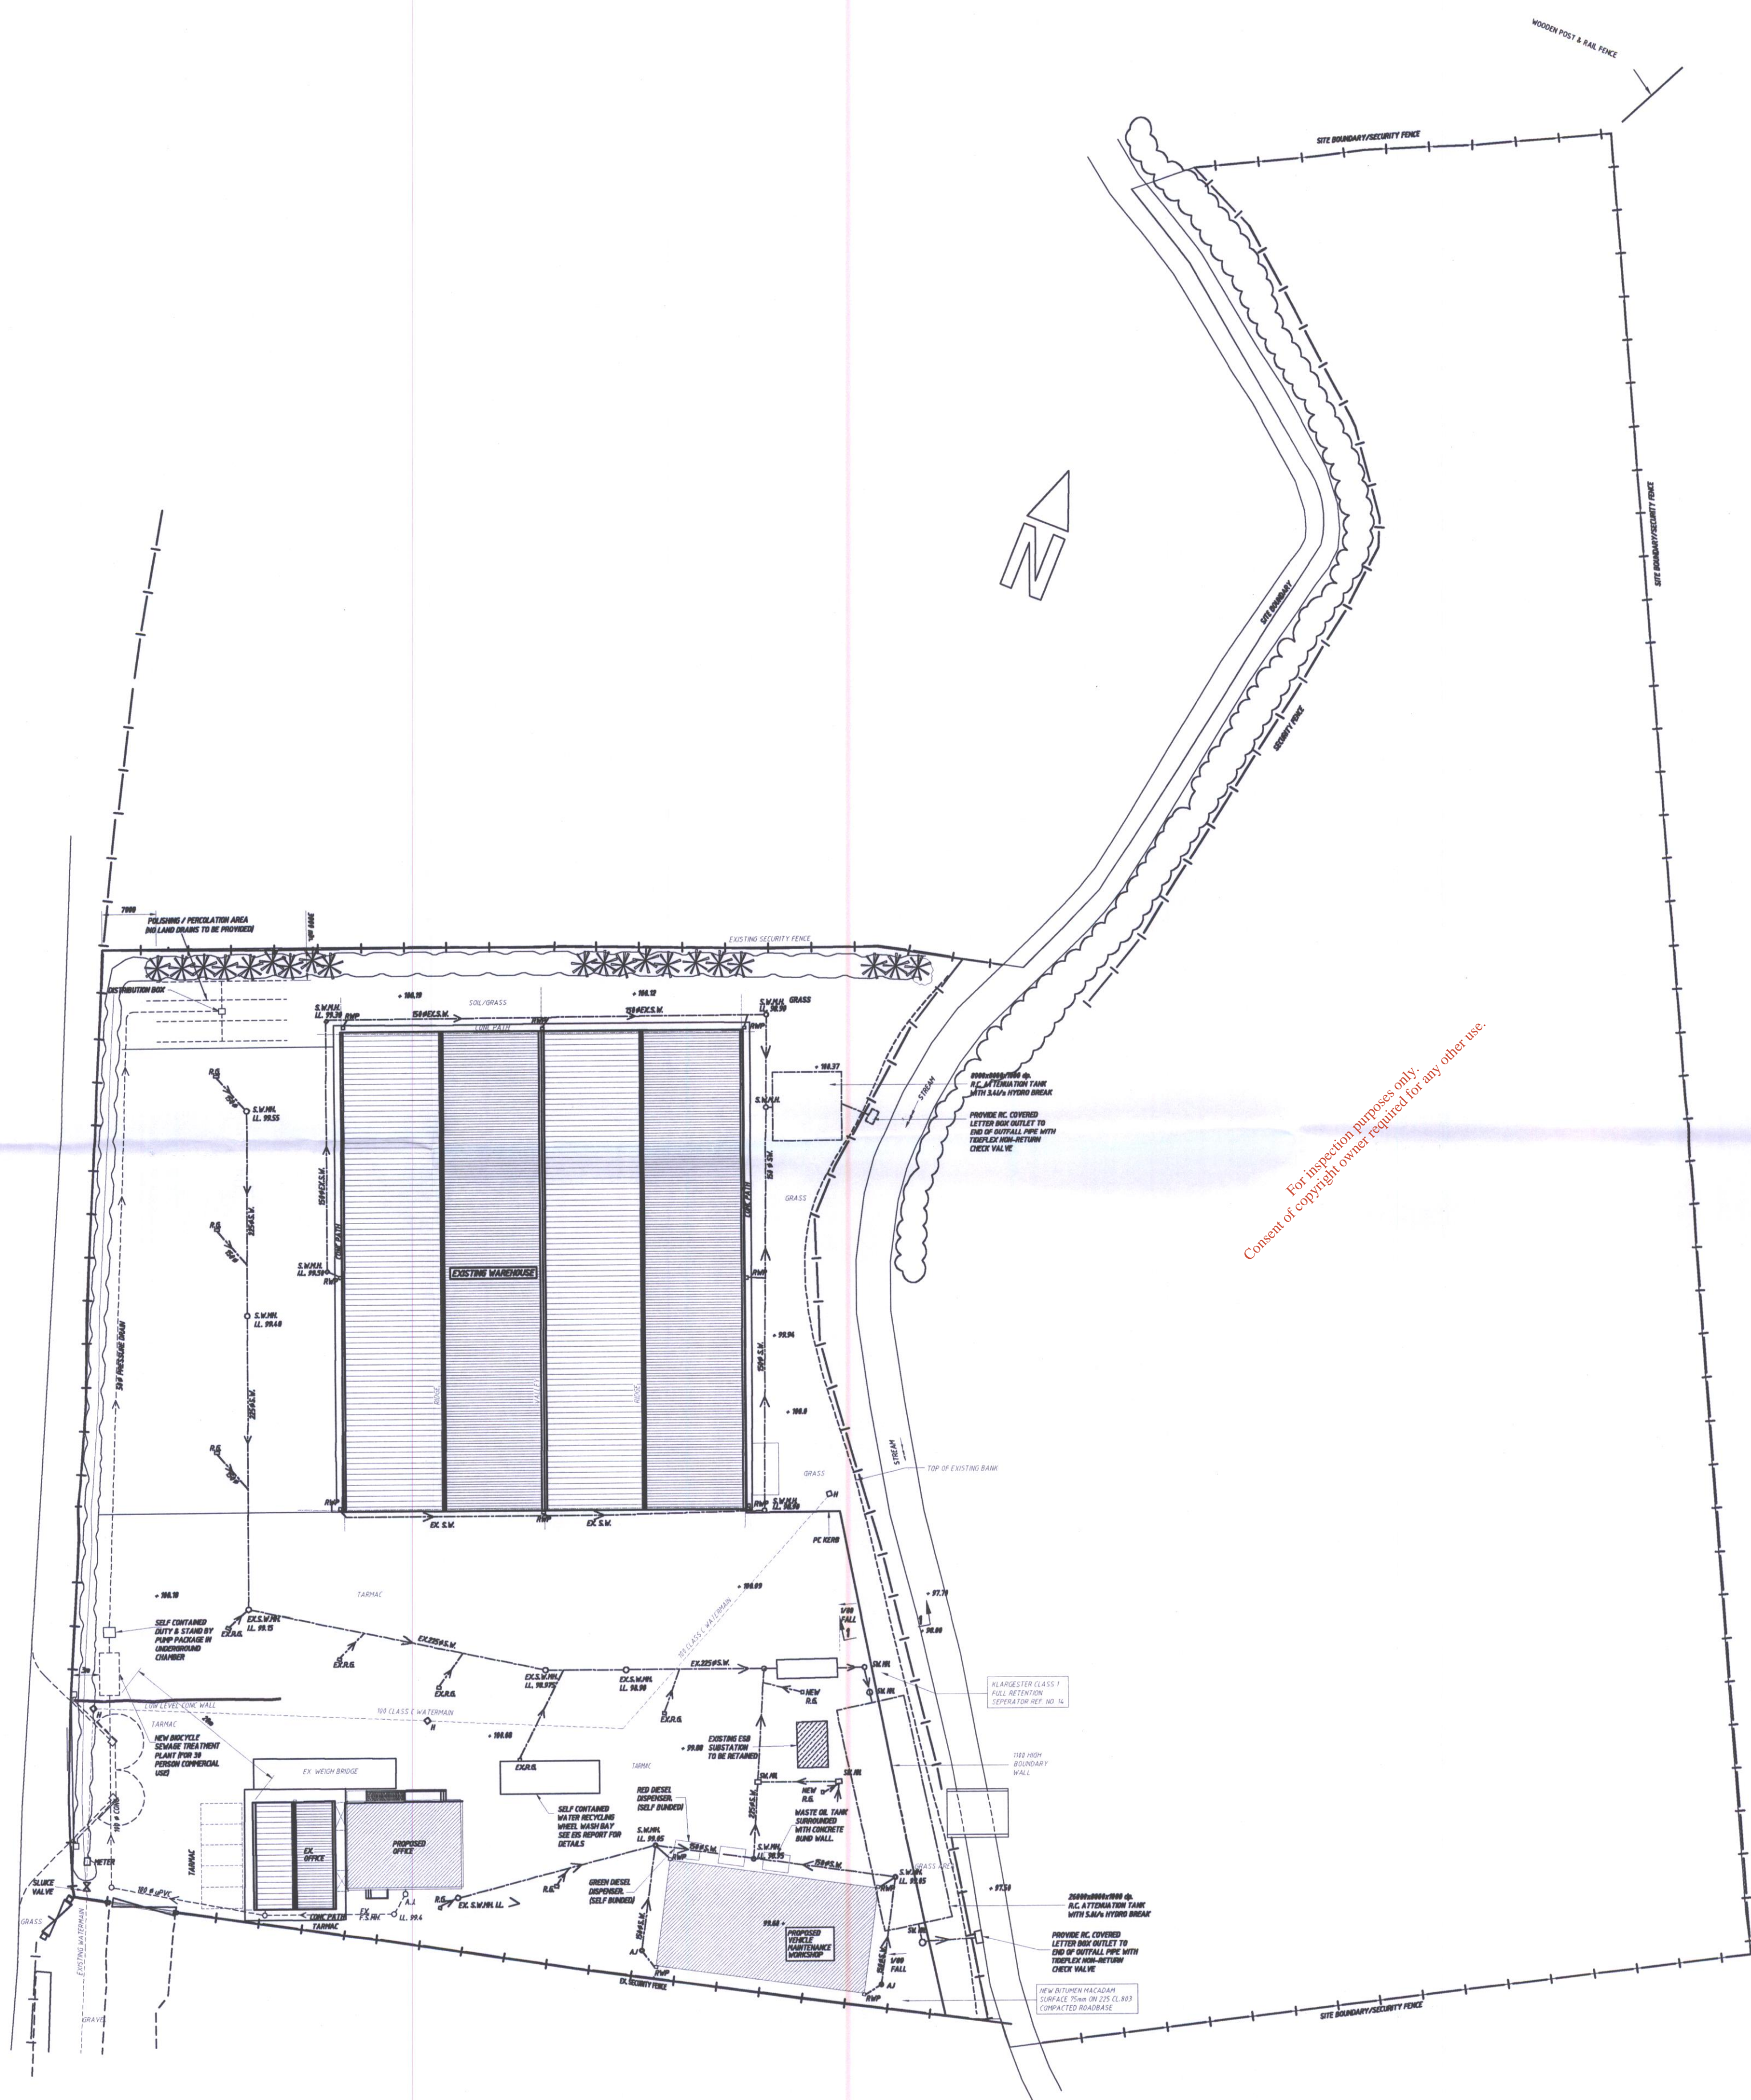

ENVIRONMENTAL PROTECTION
AGENCY WASTE LICENSING
RECEIVED
- 2 SEP 2005
INITIALS.....

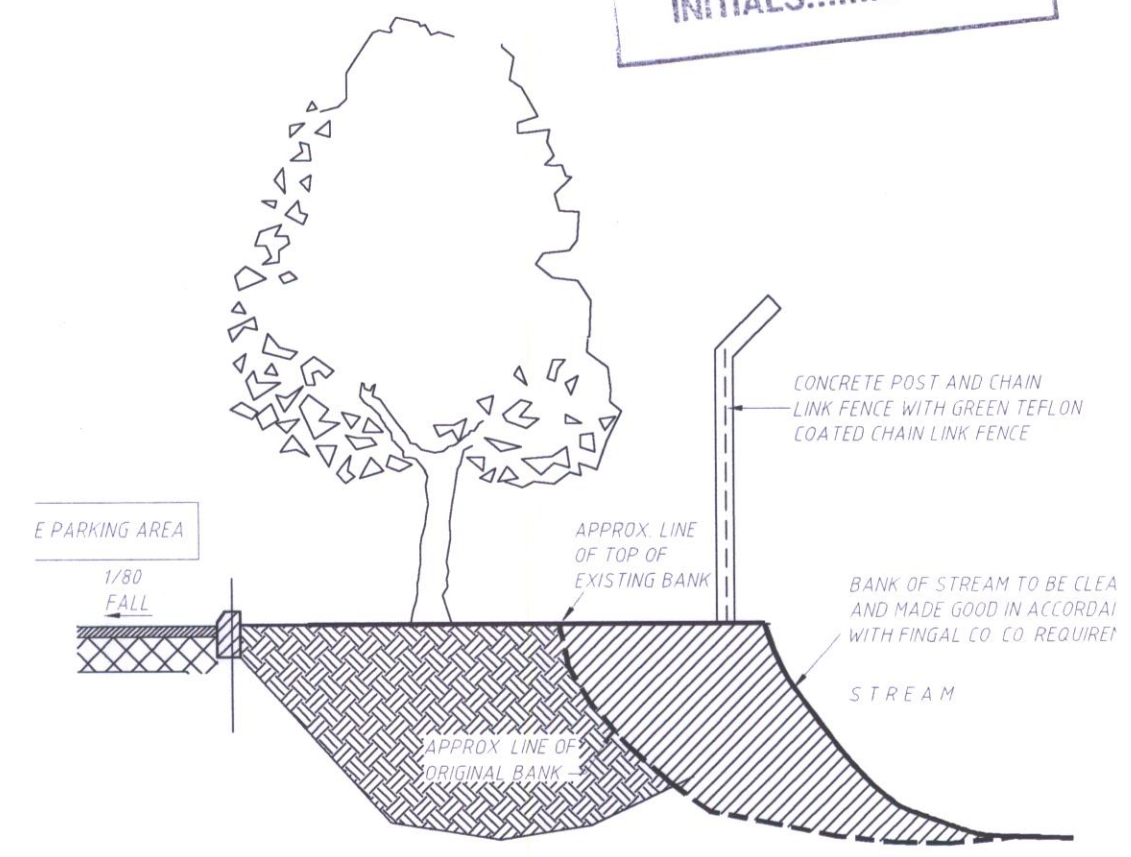

19 AUG 2005 - Issued for
Waste Licence Application

NOTES:
1. THIS DRAWING TO BE READ IN CONJUNCTION WITH ALL ARCHITECTS & ENGINEERS DRAWINGS & SPECIFICATION.
2. DO NOT SCALE. USE FIGURED DIMENSIONS ONLY.

Project
**PROPOSED RECYCLING FACILITY AT
BLAKES CROSS, LUSK, CO. DUBLIN.**

dwg title
MAIN DRAINAGE LAYOUT

consulting civil & structural
DBFL
engineers
22 - 23 holles street dublin 2
telephone: 6766343
facsimile: 6610825
email: dbfl@icli.ie

rev.	date	description	by	chkd
C	22/08/05	REVISED AND UPDATED	JD	DJ
B	20/10/03	ATTENUATION TANK SIZE REVISED	KM	DJ
A	19/08/03	ATTENUATION DETAILS REVISED & WATERMAIN ADDED	KM	DJ
rev.	date	description	by	chkd
none	12/08/03	First Issue	ISSUED FOR INFORMATION	KM DJ

client
INTERNATIONAL PLANT HIRE LTD.

scale	1:500/1:25	dwg. no.	023045-300	C
file ref.	023045-300			