


No part of this document may be re-produced or transmitted in any form or stored in any retrieval system of any nature without the written permission of the Consulting Engineer as copyright holder except as agreed for use on the project for the document was originally issued.

- Legend:
- SITE ACTIVITY BOUNDARY
 - FOUL WATER SEWER
 - SURFACE WATER SEWER
 - WATER MAINS
 - GULLY TRAP

Extract from OSI 6 Inch Series Sheet No. 13 Dublin
 NOTE: Ordnance Survey Ireland Licence No. EN001602
 (© Ordnance Survey Ireland Government of Ireland)

- Notes:
1. Figured Dimensions only to be taken from this drawing.
 2. All Drawings to be checked by the Contractor on site.
 3. Engineer to be informed of any discrepancies before any work commences.
 4. All levels relate to Ordnance Survey Datum at Malin Head.

29 SEP 2005

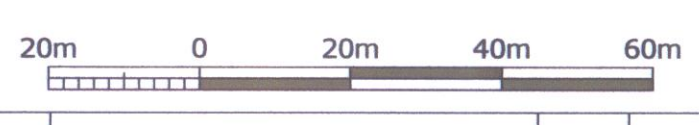

suffix	revisions	date	int.

Client
Fingal County Council
 Comhairle Contae Fhine Gall

Project
 KILSHANE CROSS
 RECYCLING PARK

Drawing Title
 SITE DRAINAGE LAYOUT PLAN

Scale: 1:1000 @ A1
 Drawn by: Colin Peacock
 Checked by:
 Date: September 2005

ENGINEER IN CHARGE: Sean Finlay

TES
 CONSULTING ENGINEERS

BLOCK 10-5,
 BLACKROCK TOWN CORPORATE PARK,
 DUBLIN 15,
 IRELAND.
 TEL: 01 8030401
 FAX: 01 8030410
 email: admin@tes.ie

Drawing No.
 1234/01/305

Rev.			