




**LEGEND:**

- SITE BOUNDARY
- EXISTING COMBINED SEWER

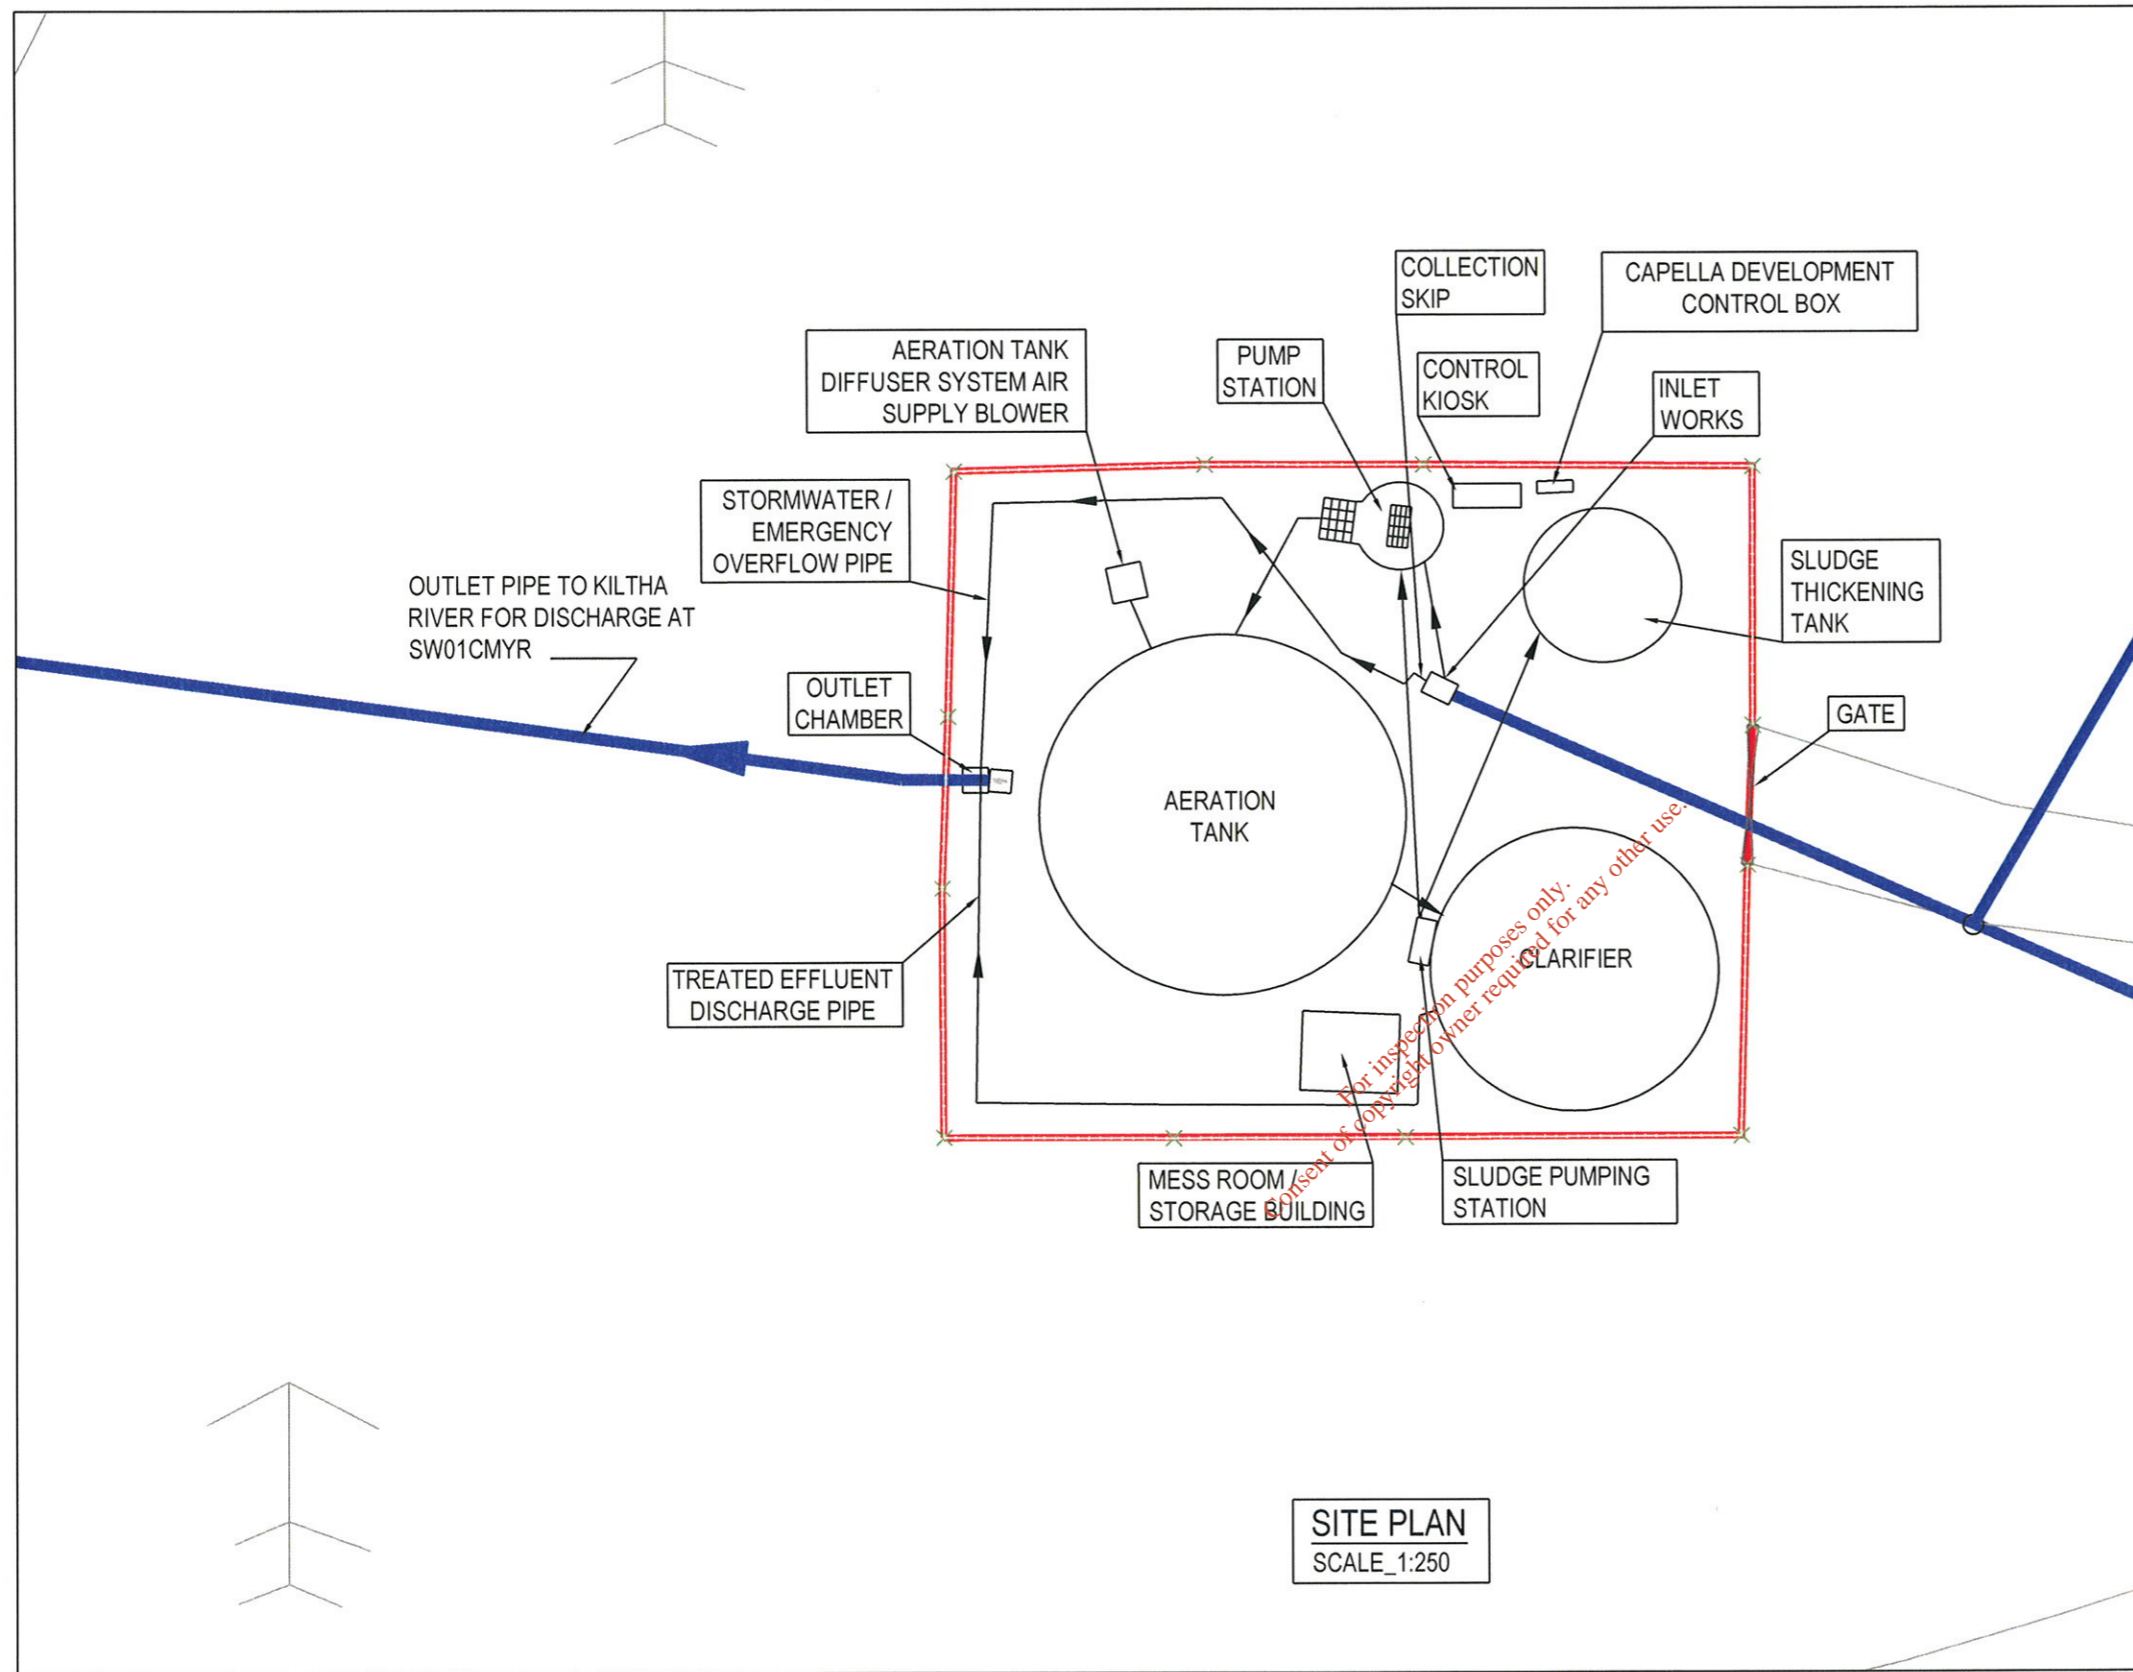

**SITE PLAN**  
SCALE\_1:250

*A ISSUE A*

REV	DESCRIPTION	BY	CHK	APP	DATE

DRAWING TITLE:  
APPLICATION FORM ATTACHMENT C1 - DRAWING 01  
CASTLEMARTYR WASTE WATER TREATMENT PLANT  
SITE PLAN


SCALE	@ A3	DRAWN	DATE	CHECKED	DATE	APPROVED	DATE
AS SHOWN		MK	12/08/08	SL	12/08/08	KT	12/08/08
C006842		OFFICE	1201	TYPE	C	ATTACHMENT No.	C1-DRAWING 01
						REVISION	A

© White Young Green Ireland Ltd. SHEET SIZE : A3 LANDSCAPE

ENGINEERING MANAGEMENT ENVIRONMENTAL PLANNING  
UNIT 2 UNIVERSITY TECHNOLOGY CENTRE CURAHEEN ROAD BISHOPTOWN CORK  
White Young Green  
Ireland  
TEL: +353 (0)21 4933200  
e-mail: cork@wyg.com

PROJECT:  
CASTLEMARTYR WASTEWATER PLANT: WASTEWATER DISCHARGE LICENCE APPLICATION  
CLIENT:  
CORK COUNTY COUNCIL

SUBMERSIBLE  
PUMPING STATION  
DUTY /ASSIST

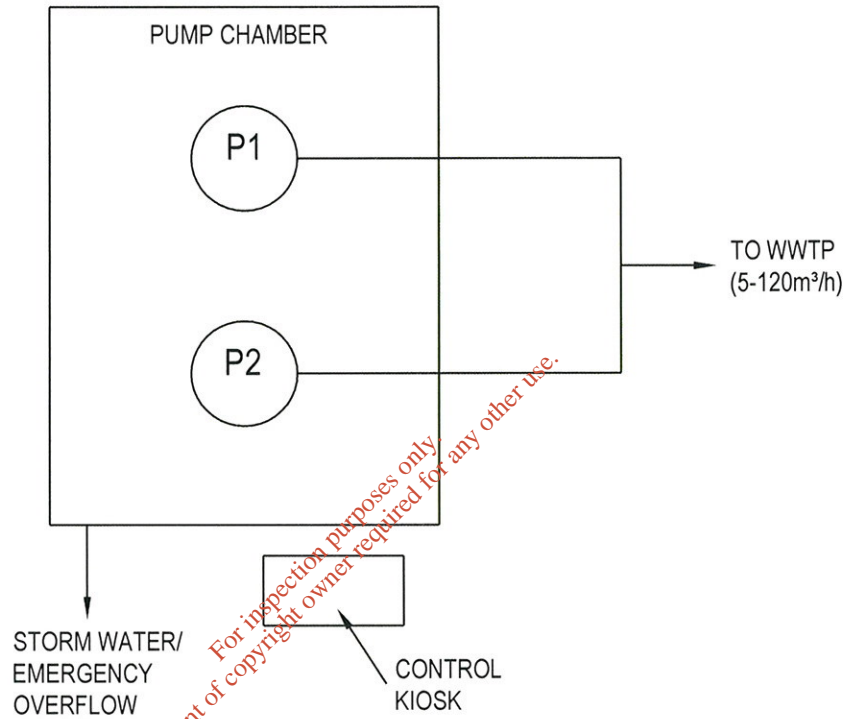

For inspection purposes only  
Consent of copyright owner required for any other use.

**A ISSUE A** MK 19/08/08

REV	DESCRIPTION	BY	CHK	APP	DATE

ENGINEERING  
MANAGEMENT  
ENVIRONMENTAL  
PLANNING

UNIT 2  
UNIVERSITY TECHNOLOGY CENTRE  
CURAHEEN ROAD  
BISHOPTOWN  
CORK

TEL: +353 (0)21 4933200  
e-mail: cork@wyg.com

www.wyg.com



PROJECT:  
CASTLEMARTYR WASTE WATER PLANT:  
WASTE WATER DISCHARGE LICENCE  
APPLICATION

CLIENT:  
CORK COUNTY COUNCIL


DRAWING TITLE:  
APPLICATION FORM ATTACHMENT C1 - DRAWING 02  
CASTLEMARTYR MAIN ROAD PUMP STATION  
PROCESS FLOW DIAGRAM

SCALE	@ A3	DRAWN	DATE	CHECKED	DATE	APPROVED	DATE
N.T.S.		MK	12/08/08	SL	12/08/08	KT	12/08/08
C006842		OFFICE	1201	TYPE	C	DRAWING No.	C1-DRAWING 02
						REVISION	A

E:\FINAME\G:\C006842\015 PROJECT DRAWING\03 C&S\07 DRAWINGS-FIG1\RFSC1-DRAWING 02 DWG 1 PLOTTED BY MICHAEL KOJAR 1 PLOTTED DATE 19 September 2008 16:05:48





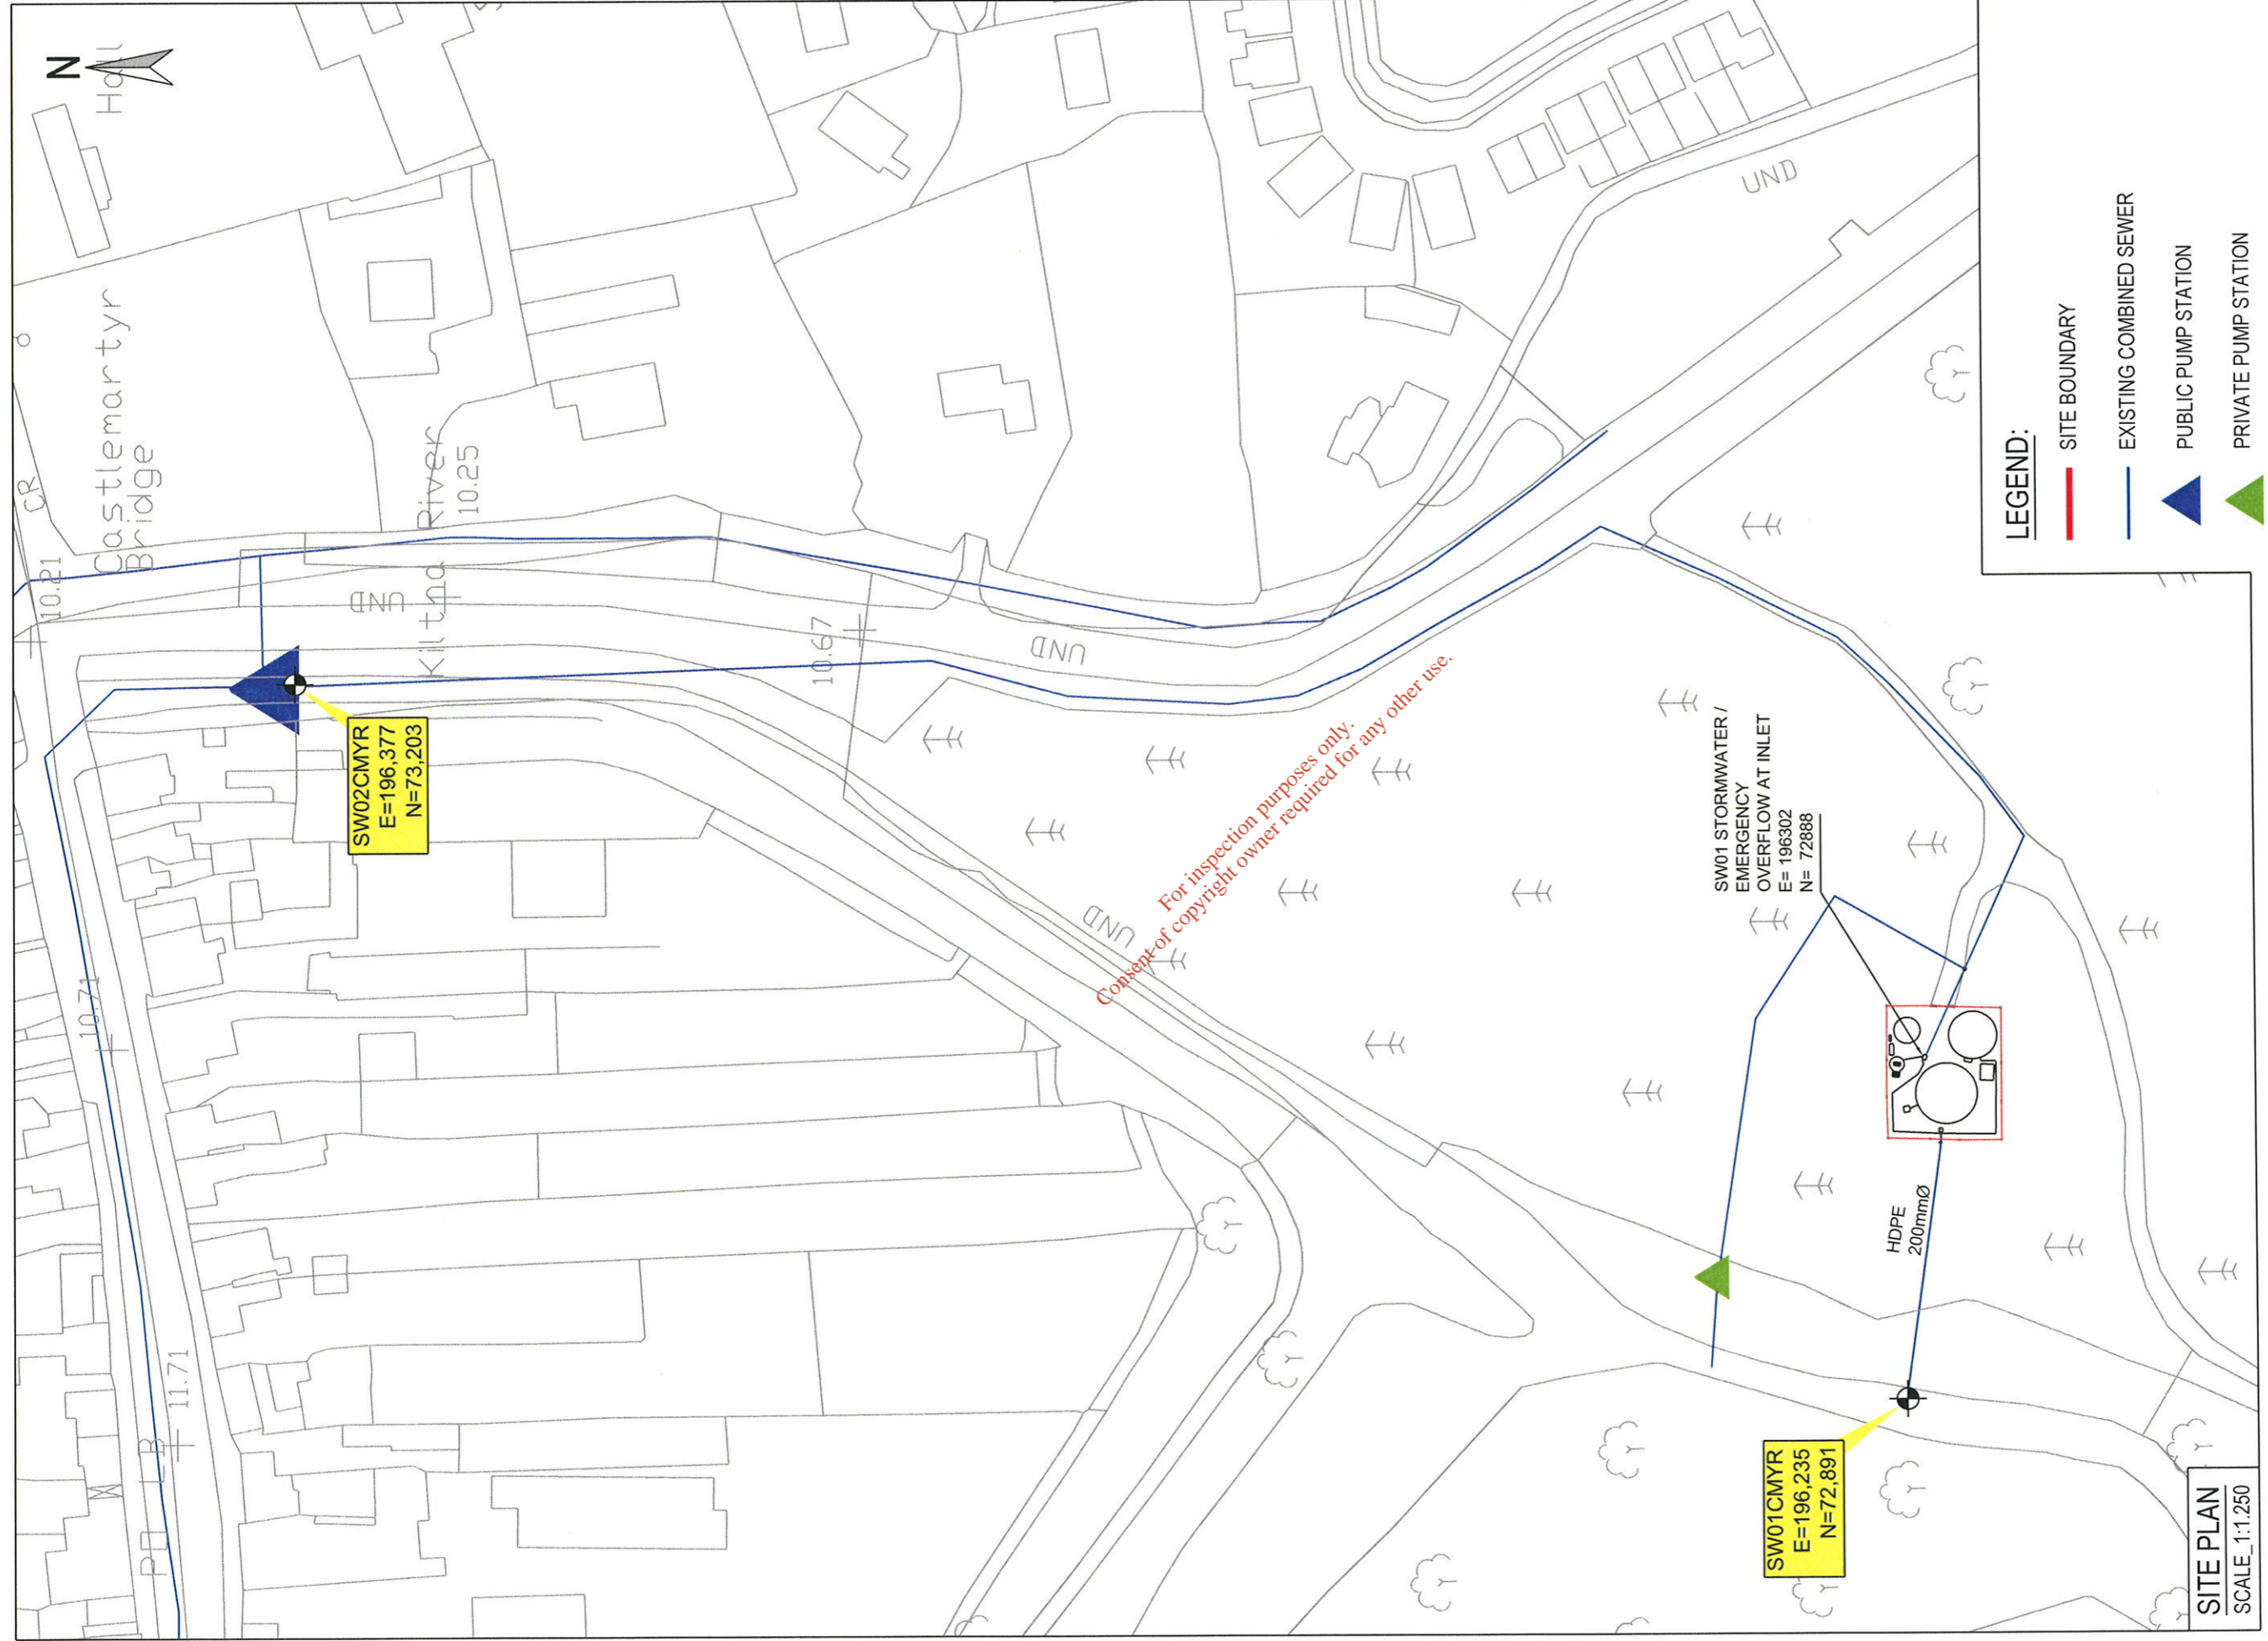

BY: *M. Kelly* DATE: *12/08/08*  
 A ISSUE A

REV	DESCRIPTION	CHK	APP	DATE
1				

SCALE	@ A3	DRAWN	DATE	CHECKED	DATE	APPROVED	DATE
AS SHOWN			12/08/08	SL	12/08/08	KT	12/08/08

OFFICE TYPE	ATTACHMENT NO.	REVISION
C0006842	1201	C
		C2-DRAWING 04
		A

SHEET SIZE: A3 PORTRAIT  
 © White Young Green Ireland Ltd.

PROJECT: CASTLEMARTYR WASTEWATER PLANT: WASTEWATER DISCHARGE LICENCE APPLICATION  
 CLIENT: CORK COUNTY COUNCIL

**White Young Green Ireland**

ENGINEERING MANAGEMENT ENVIRONMENTAL PLANNING

UNIT 2 UNIVERSITY TECHNOLOGY CENTRE CURAHEEN ROAD BISHOPTOWN CORK

TEL: +353 (0)21 493200  
 e-mail: cork@wyg.com

www.wyg.com