


ATTACHMENT B.2

Site Location Map

Site Plan

Services Plan

*For inspection purposes only.
Consent of copyright owner required for any other use.*

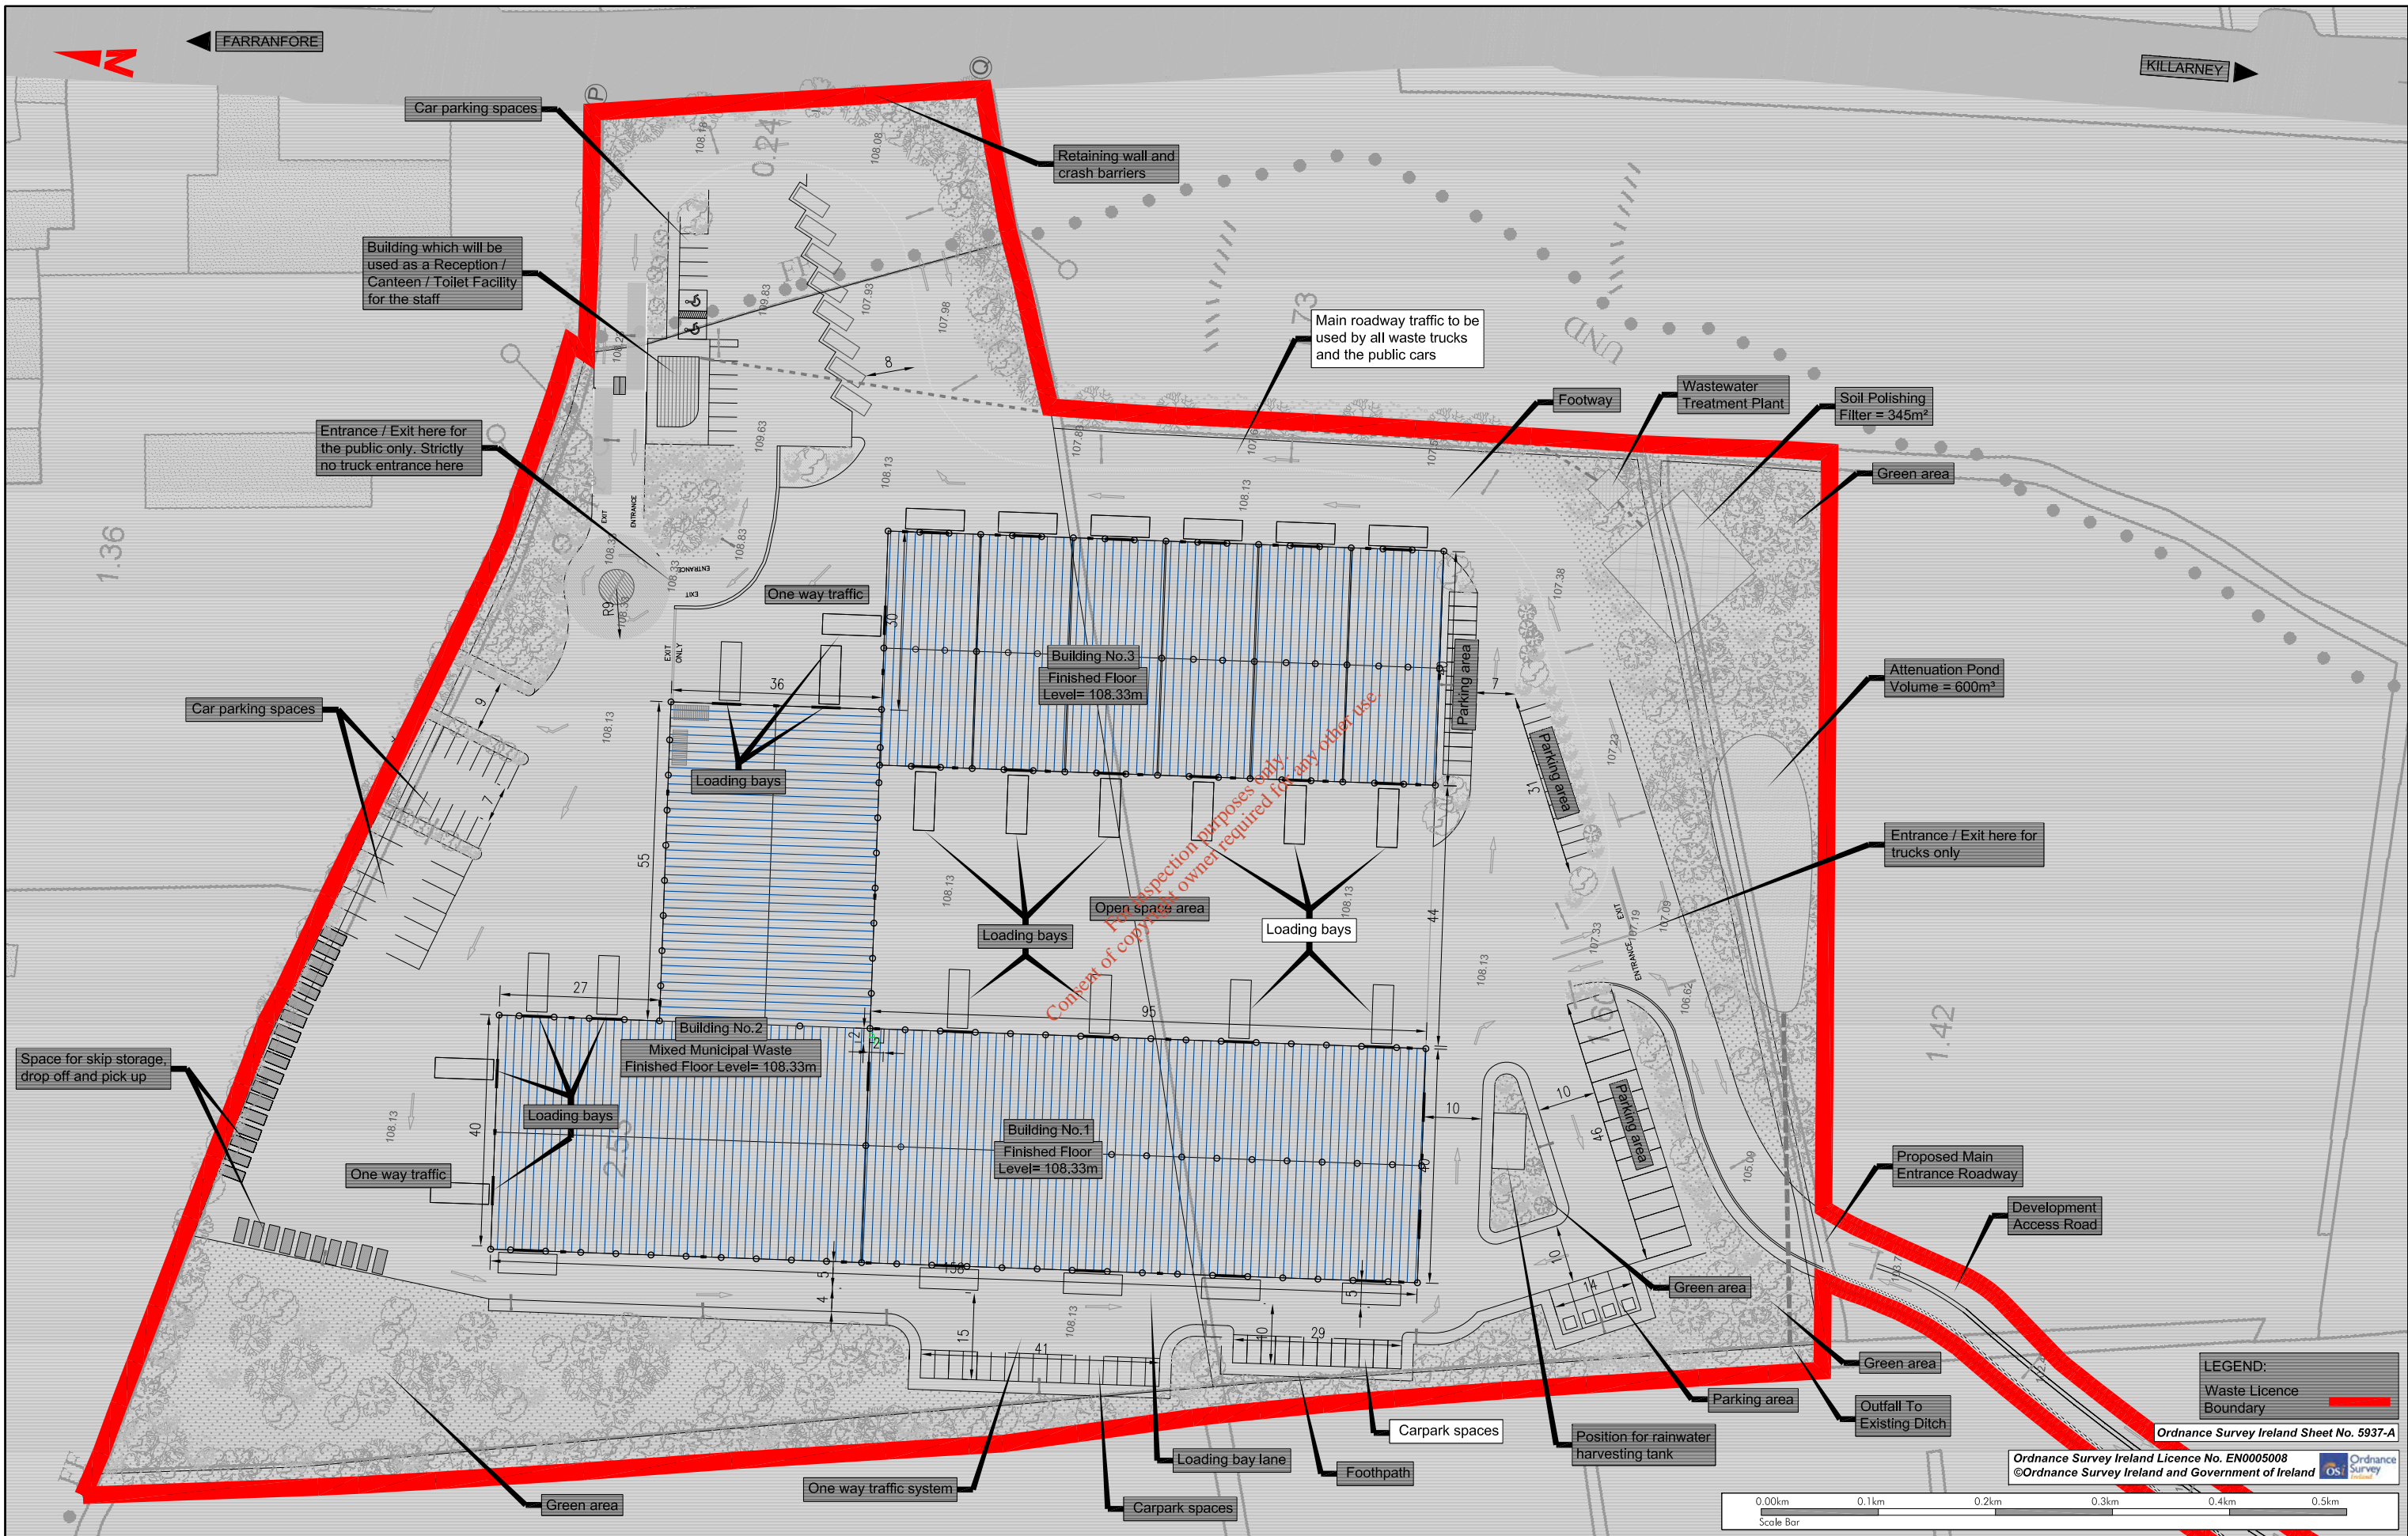

LEGEND:
 Waste Licence Boundary

Ordnance Survey Ireland Sheet No. 5937-A
 Ordnance Survey Ireland Licence No. EN0005008
 ©Ordnance Survey Ireland and Government of Ireland



NOTES

- This drawing is the property of RPS Consulting Engineers it is a confidential document and must not be copied, used, or its content divulged without prior written consent.
- DO NOT SCALE, use figured dimensions only. If in doubt ask.
- Levels are in metres to local datum.

No.	Date	By	Amendment / Issue	App
F01	29.07.08	M.S.G.	Waste Licence Planning	W.M.


Client
 KERRY CENTRAL
 RECYCLING FACILITY LTD.

Drawn By: A.N.
 Checked By: S.G.
 Approved By: W.M.
 Date: Sept'08

RPS
 Lyrr Building
 IDA Business & Technology Park
 Meruise, Galway
 T: +353 91 534100
 F: +353 91 534199
 W: www.rpsgroup.com/ireland
 E: ireland@rpsgroup.com

Project: WASTE LICENCE APPLICATION
 Drawing Status: FINAL
 Scale / Sheet Size: 1:500 @ A1, 1:1000 @ A3

Drawing Number: DG0019/01
 Title: SITE PLAN
 Rev: F01
 (Sheet 1 of 1)

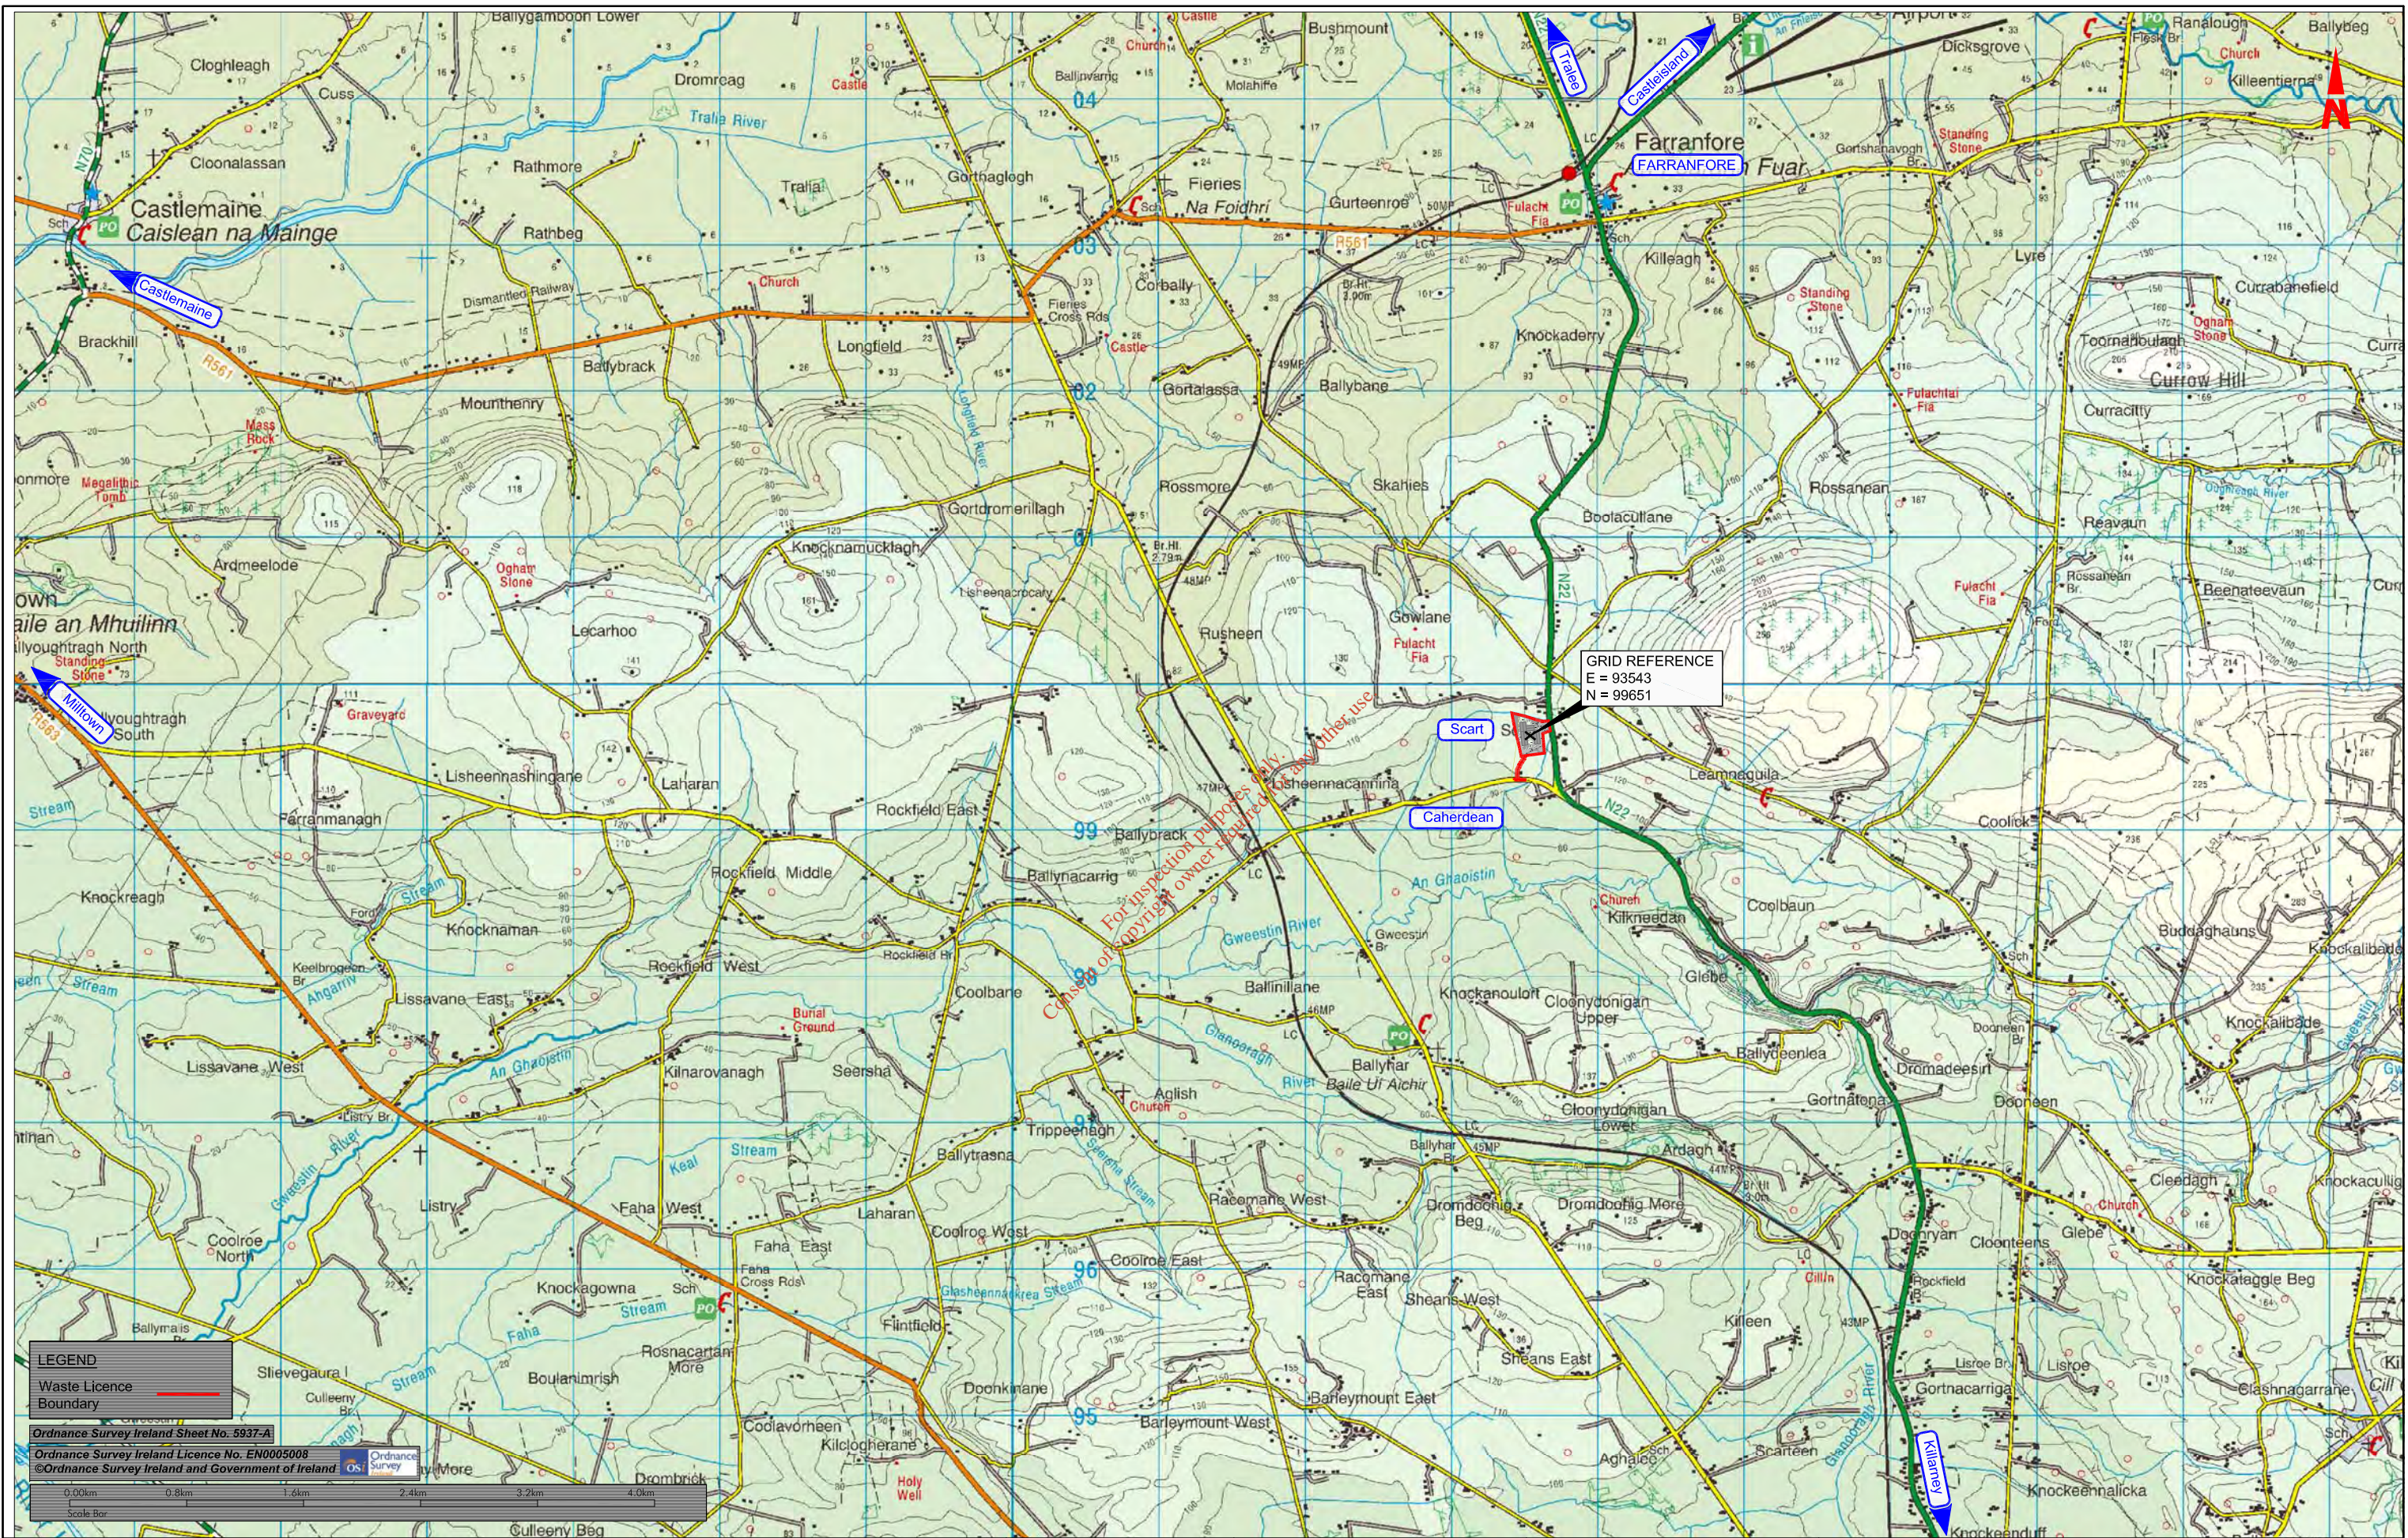

LEGEND
 Waste Licence Boundary

Ordnance Survey Ireland Sheet No. 5937-A

Ordnance Survey Ireland Licence No. EN0005008

© Ordnance Survey Ireland and Government of Ireland



For inspection purposes only.
 Cause of copyright owner required for any other use.

GRID REFERENCE
 E = 93543
 N = 99651

NOTES
 1. This drawing is the property of RPS Consulting Engineers it is a confidential document and must not be copied, used, or its content divulged without prior written consent.
 2. DO NOT SCALE, use figured dimensions only. If in doubt ask.
 3. Levels are in metres to local datum.

No.	Date	Amendment / Issue	App
F01	29.07.08	Waste Licence Application	W.M.

Client			
KERRY CENTRAL RECYCLING FACILITY LTD.			
Drawn By	Checked By	Approved By	Date
A.N.	S.G.	W.M.	Sept'08

	Project	
	WASTE LICENCE APPLICATION	
Drawing Status	Scale / Sheet Size	Title
FINAL	1:20000 @ A1	SITE LOCATION MAP (Sheet 1 of 1)

Drawing Number	Rev
DG0017/01	F01



For inspection purposes only. Consent of copyright owner required for any other use.

LEGEND	
Waste Licence Boundary	—
Foul Sewer	---
Filter Drain	---
Carrier Pipe	---
Washdown Sewer	---
Watermain 150mm Ø	—W—
Hydrant	[H]
Water Meter	[M]
Sluice Valve	[X]

Ordnance Survey Ireland Licence No. EN0005008
©Ordnance Survey Ireland and Government of Ireland



NOTES

- This drawing is the property of RPS Consulting Engineers it is a confidential document and must not be copied, used, or its content divulged without prior written consent.
- DO NOT SCALE, use figured dimensions only. If in doubt ask.
- Levels are in metres to local datum.

No.	Date	By	Amendment / Issue	App
P01	29.07.08	ML/S.G.	Waste Licence Planning	W.M.

Client
KERRY CENTRAL RECYCLING FACILITY LTD.

Drawn By: A.N. | Checked By: S.G. | Approved By: W.M. | Date: Sept'08

Project: **WASTE LICENCE APPLICATION**

Drawing Status: FINAL | Scale / Sheet Size: 1:1000 @ A1 | 1:2000 @ A3

Drawing Number: **DG0020/01** | Rev: **F01**

Title: **SERVICES PLAN**
(Sheet 1 of 1)