

WASTEWATER TREATMENT WORKS

For inspection purposes only.
Consent of copyright owner required for any other use.

LEGEND:
LICENCE APPLICATION AREA

A Site boundary amended S.M. MCC 9/05/12

Monaghan County Council
Comhairle Contae Mhúineacháin




PH MCCARTHY HOUSE
NUTSGROVE OFFICE PARK
NUTSGROVE AVENUE,
RATHFRANKHAM, DUBLIN 14
TEL: +353 (0) 1291 4800
FAX: +353 (0) 1298 9521
e-mail: info@phmcc.com



 
Project:
SCOTSHOUSE
DISCHARGE LICENCE APPLICATION

Drawing Title:
WASTE WATER TREATMENT WORKS
AGGLOMERATION PLAN


Scale @	A3	Drawn	Date	Checked	Date	Approved	Date
AS SHOWN	HS	15.06.09	CS	15.06.09	TK	15.06.09	
Project No.	C007400	Office	Type	Drawing No.	DRAWING 1		
Revision	A						

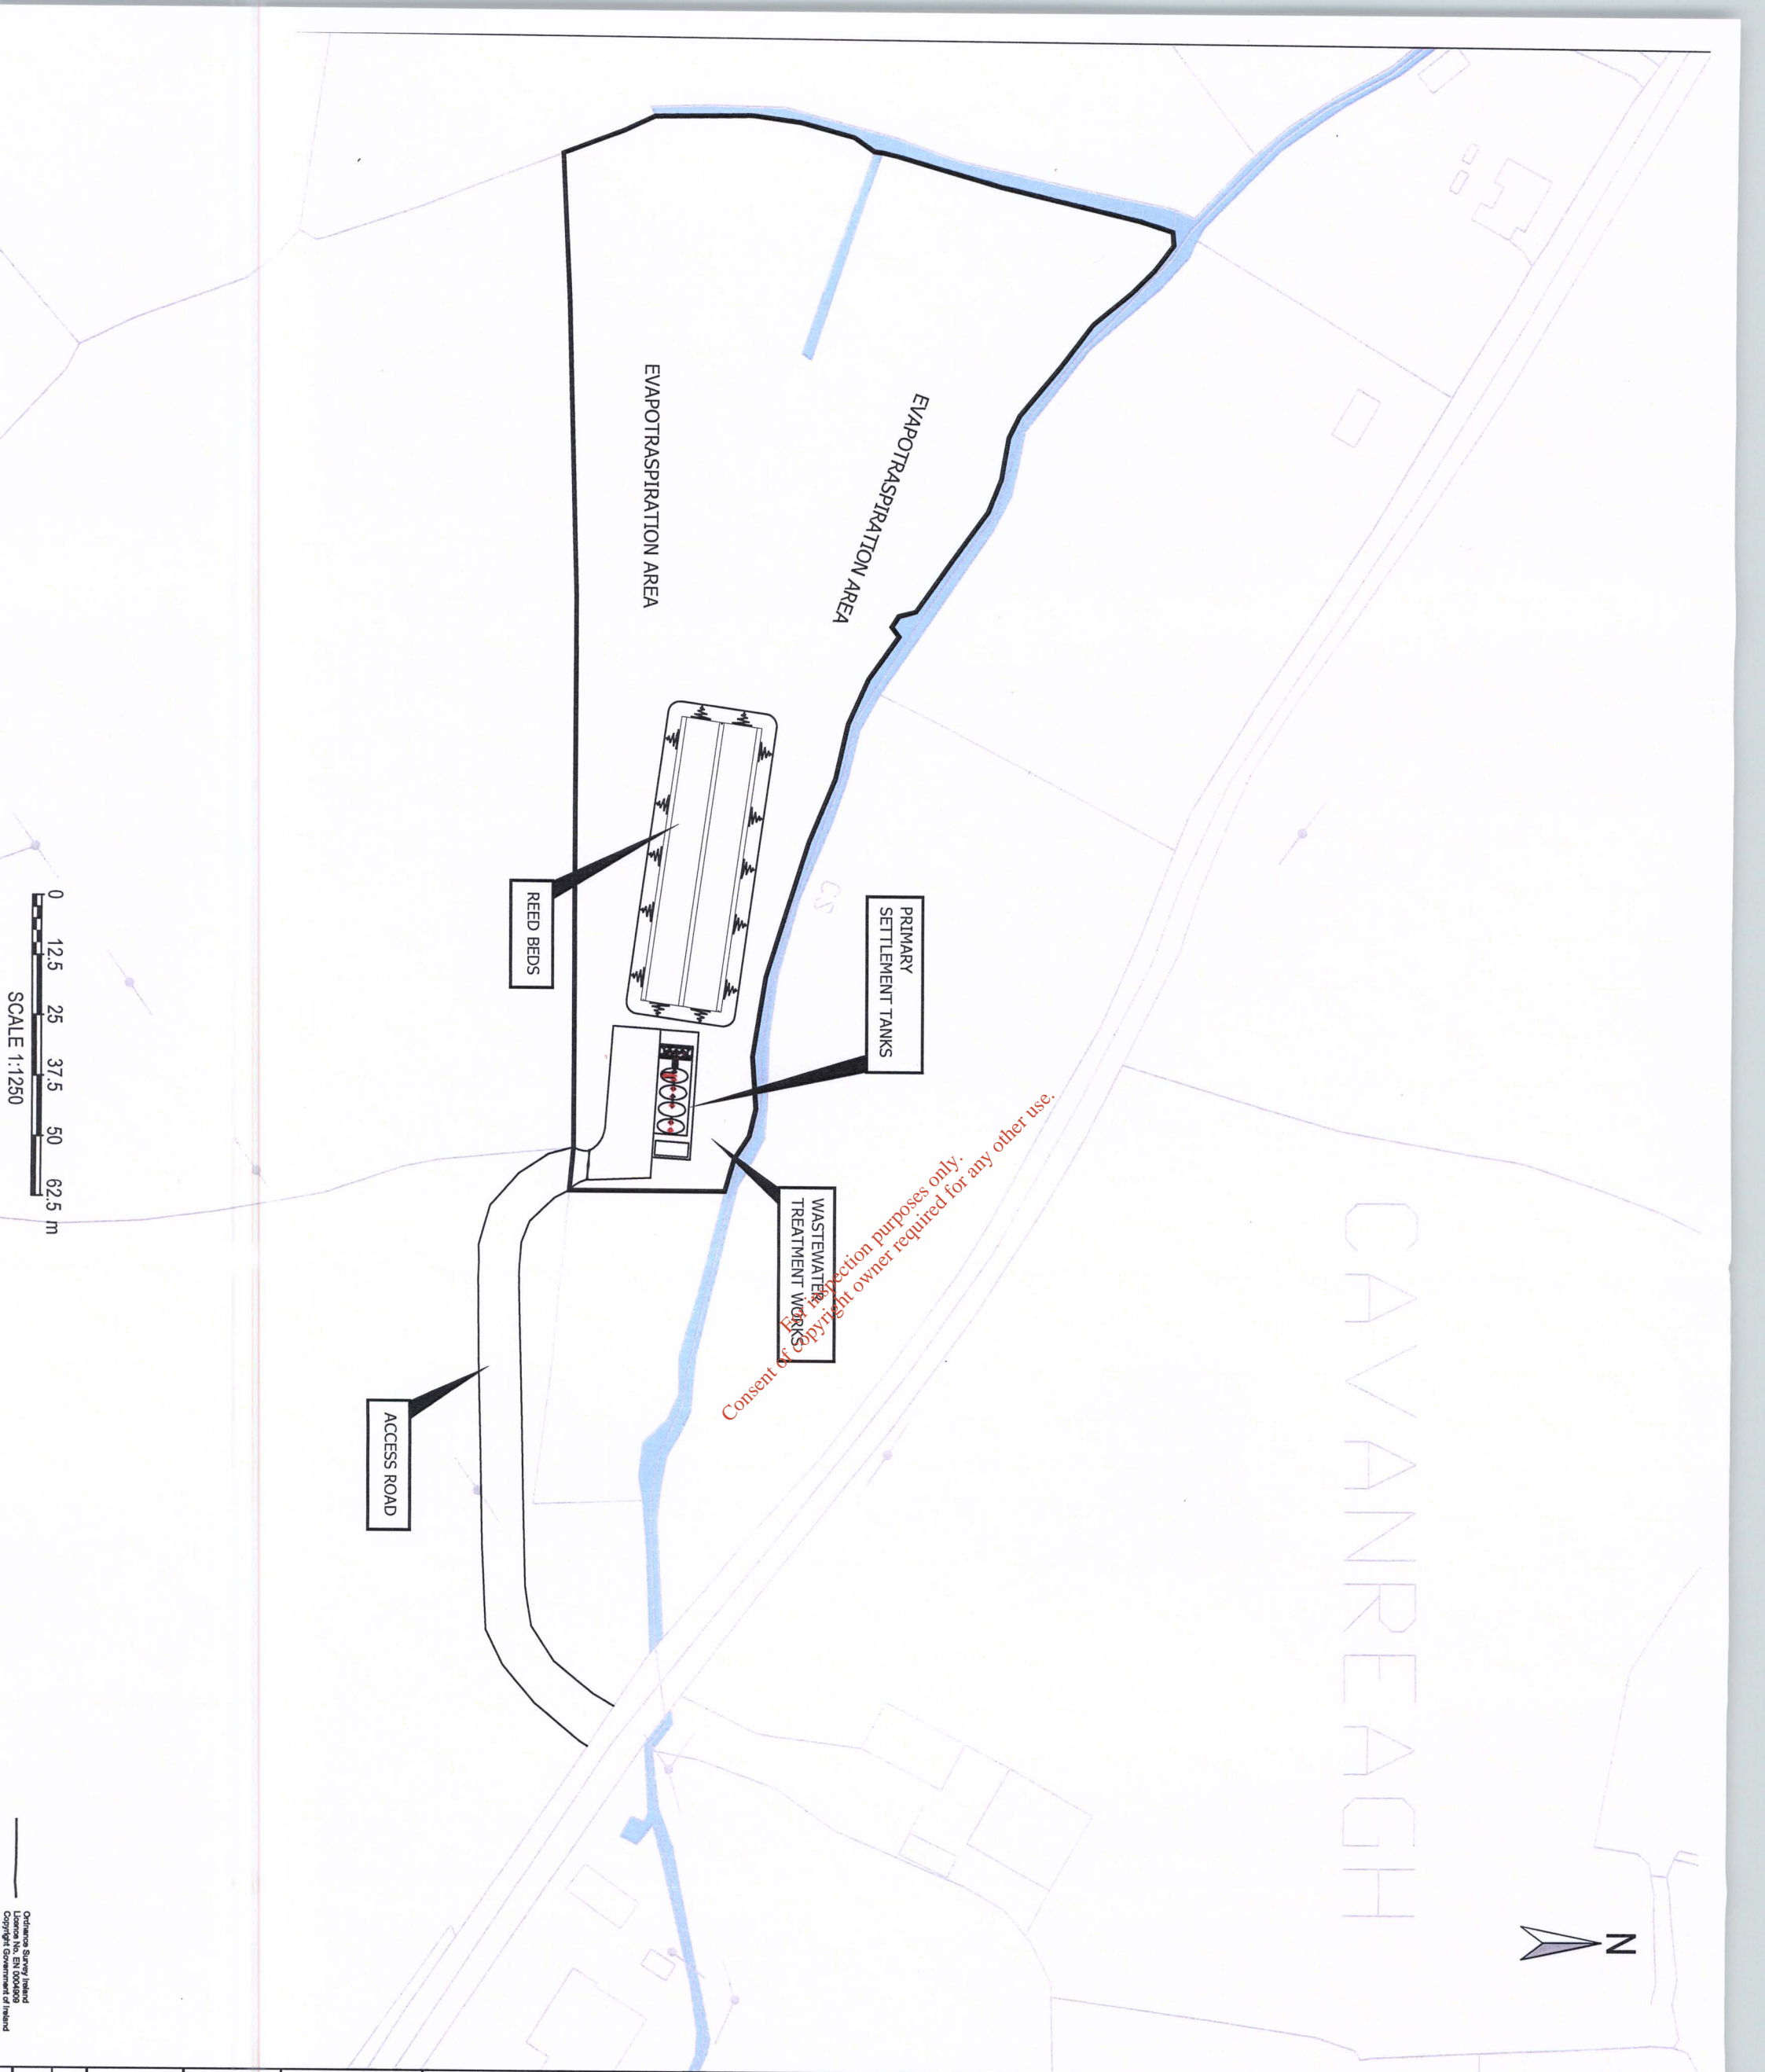



CAVVANREAGH

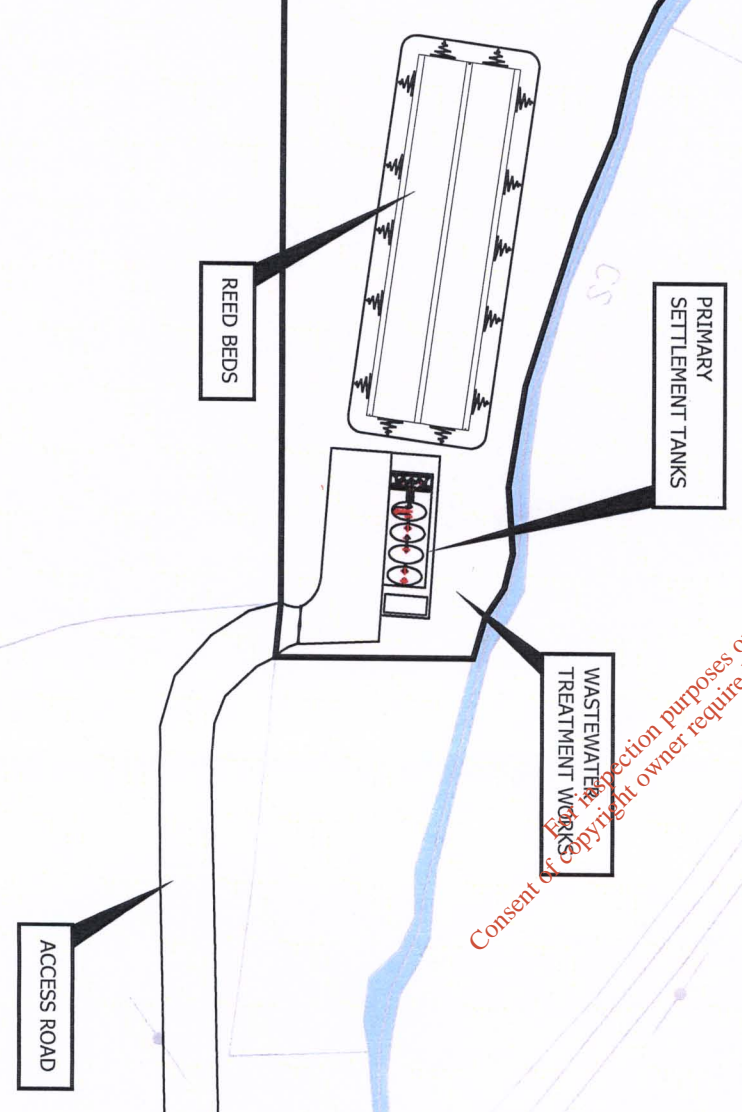

Consent of EPA for protection purposes only.
Copyright owner required for any other use.




0 12.5 25 37.5 50 62.5 m
SCALE 1:1250

REV	DESCRIPTION	BY	CHK	APP	DATE
<p>Monaghan County Council Comhairle Contae Mhúineacháin</p> 					
<p>PH MCGARTHY HOUSE NUTGROVE OFFICE PARK NUTGROVE AVENUE RATHFRANKLIN, DUBLIN 14</p> <p>TEL: +353 (0) 1291 4800 FAX: +353 (0) 1298 9521 e-mail: info@pimcc.com</p> 					
<p>Project: SCOTSHOUSE DISCHARGE LICENCE APPLICATION</p>					
<p>Drawing Title: WASTE WATER TREATMENT PLANT SITE PLAN & BOUNDARY</p>					
Scale @ A3	Drawn	Date	Checked	Date	Approved
AS SHOWN	HS	15.06.09	CS	15.06.09	TK
Project No.	Office	Type	Drawing No.	Revision	Date
C007400			DRAWING 2	0	15.06.09



LEGEND:

● DISCHARGE POINT

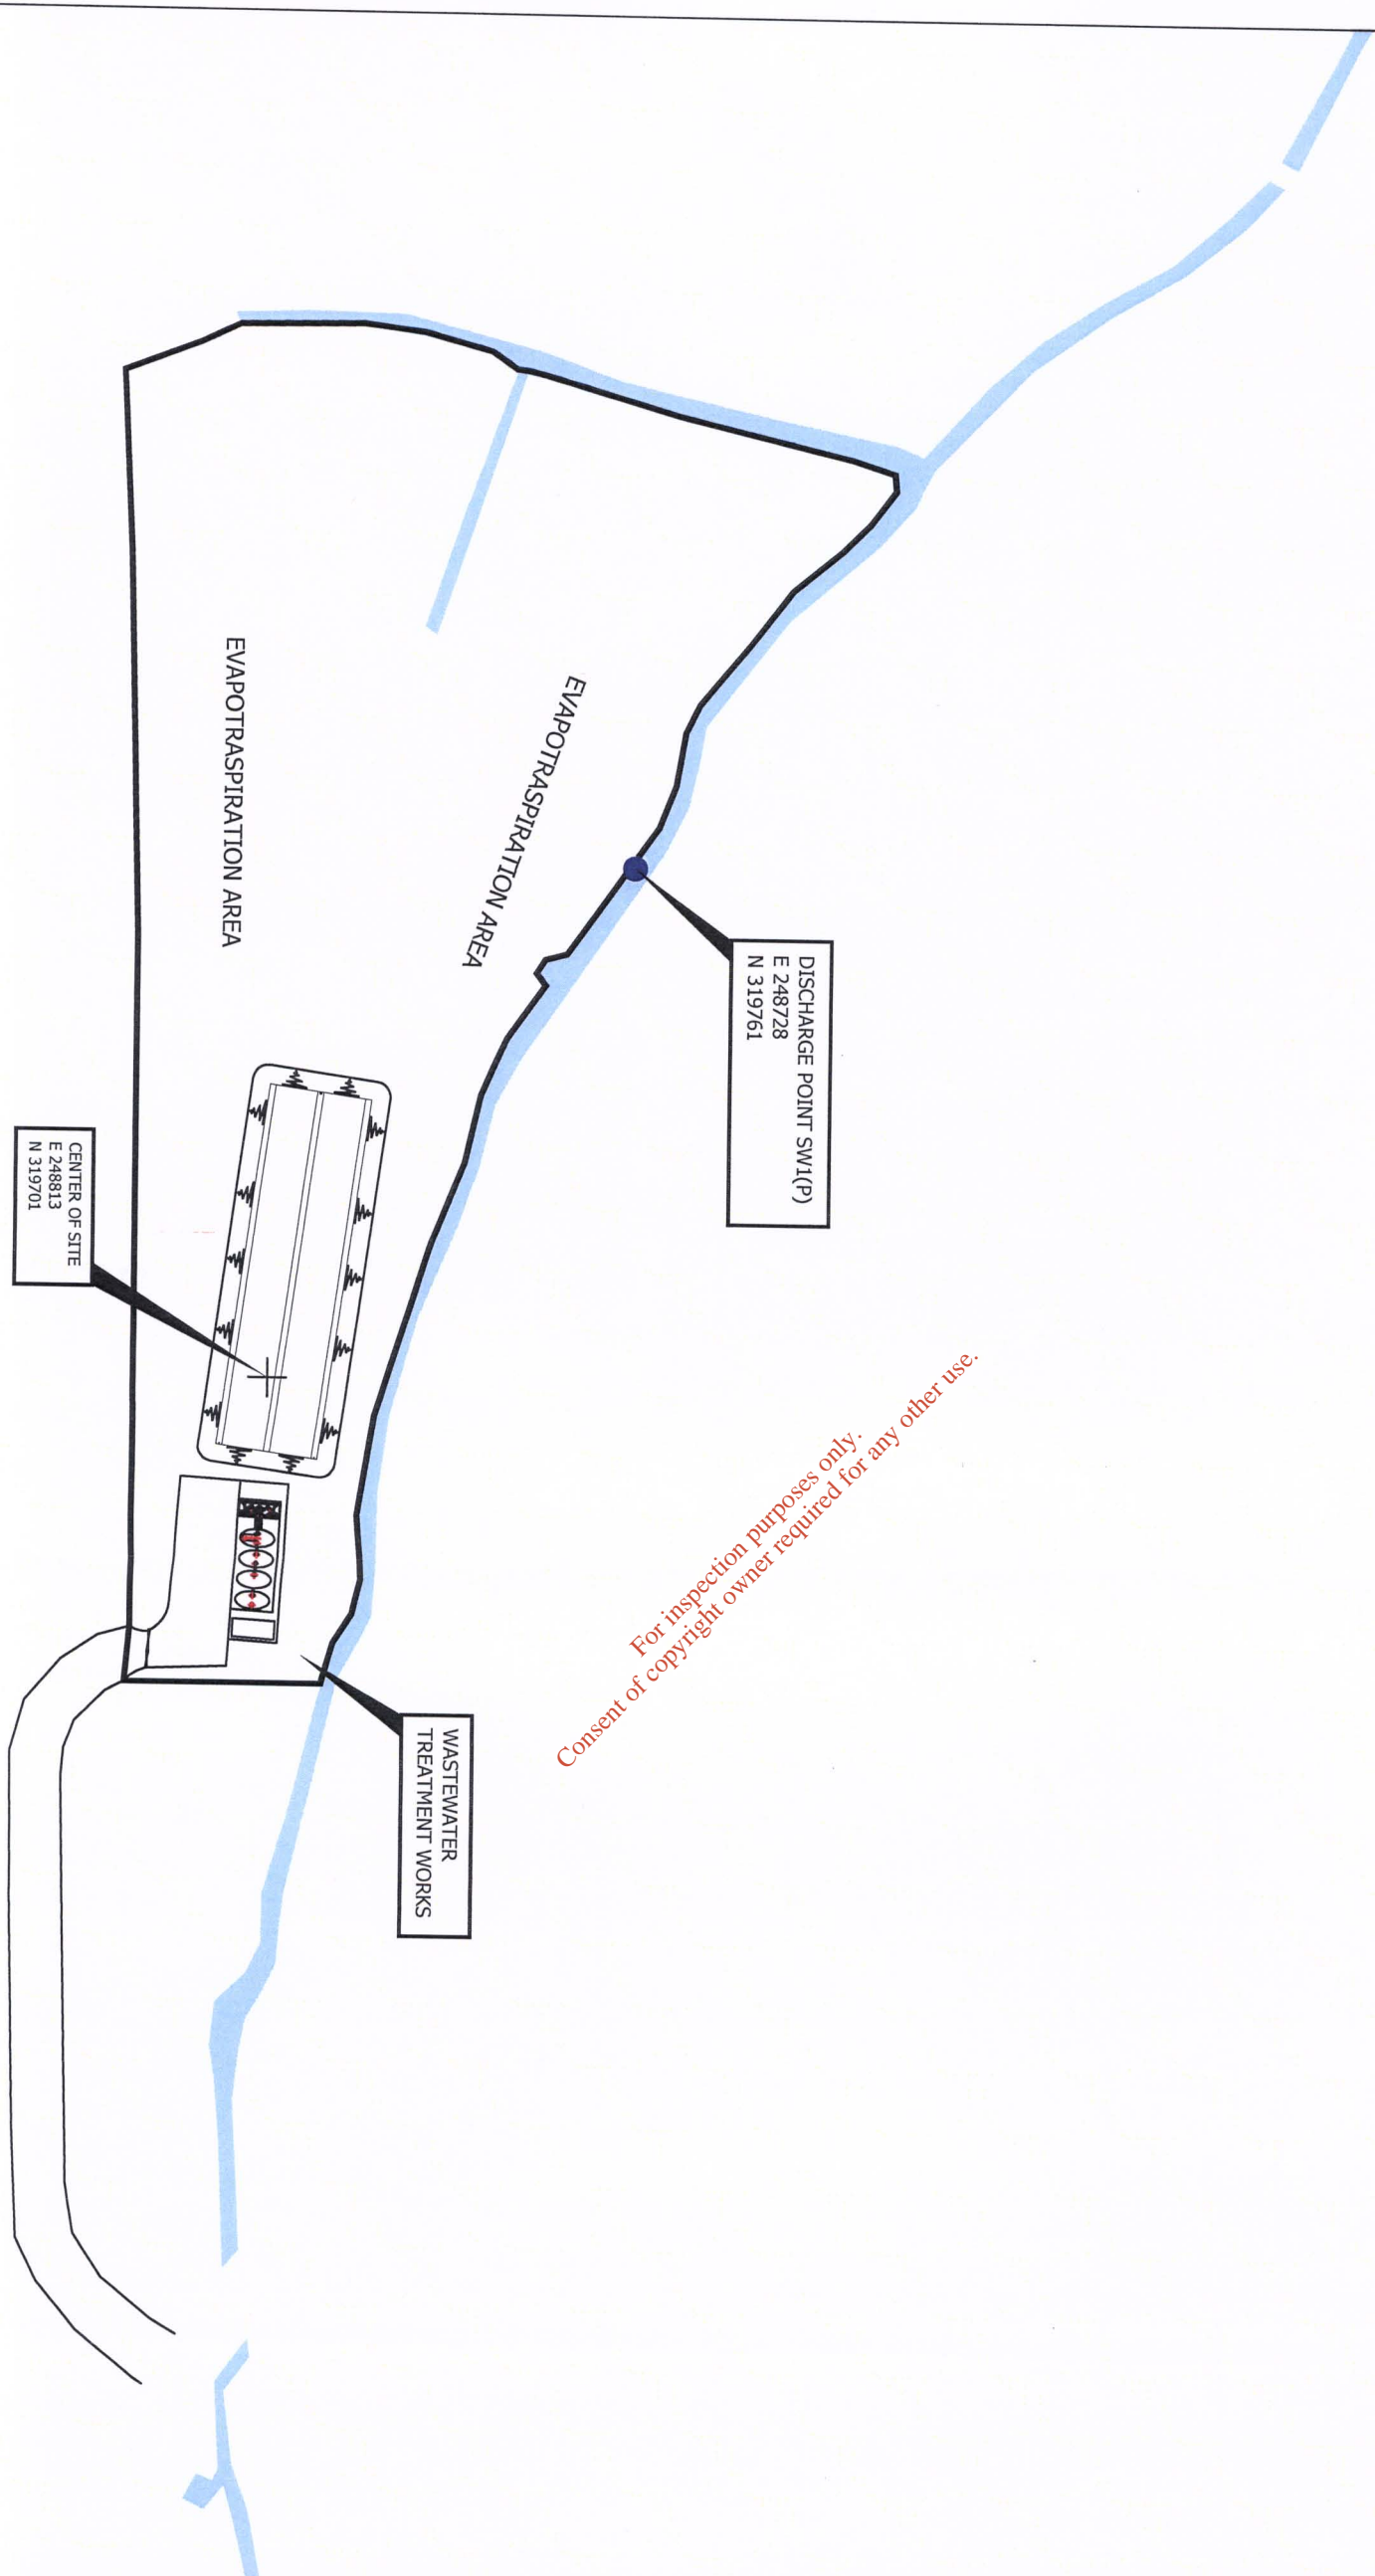

For inspection purposes only.
Consent of copyright owner required for any other use.

CENTER OF SITE
E 248813
N 319701

DISCHARGE POINT SW1(P)
E 248728
N 319761

WASTEWATER
TREATMENT
WORKS

EVAPOTRASPIRATION AREA

EVAPOTRASPIRATION AREA



Ordnance Survey / Ireland / Ordnance
No. EN 0004800 Copyright
Government of Ireland

REV	DESCRIPTION	BY	CHK	APP	DATE
-----	-------------	----	-----	-----	------

Monaghan County Council
Comhairle Contae Mhúineacháin



PH MCCARTHY HOUSE
NUTSGROVE OFFICE PARK
NUTSGROVE AVENUE
RATHFARHAM, DUBLIN 14
TEL: +353 (0) 1291 4800
FAX: +353 (0) 1298 9521
e-mail: info@phmc.com




Project:
SCOTSHOUSE
DISCHARGE LICENCE APPLICATION

Drawing Title:
WASTE WATER TREATMENT PLANT
LOCATION OF PRIMARY DISCHARGE POINT


Scale @	A3	Drawn	Date	Checked	Date	Approved	Date
AS SHOWN	HS	15.06.09	CS	15.06.09	TK	15.06.09	
Project No.	Office	Type	Drawing No.	Revision			
C007400			DRAWING 3	0			

© WYG Group Ltd.

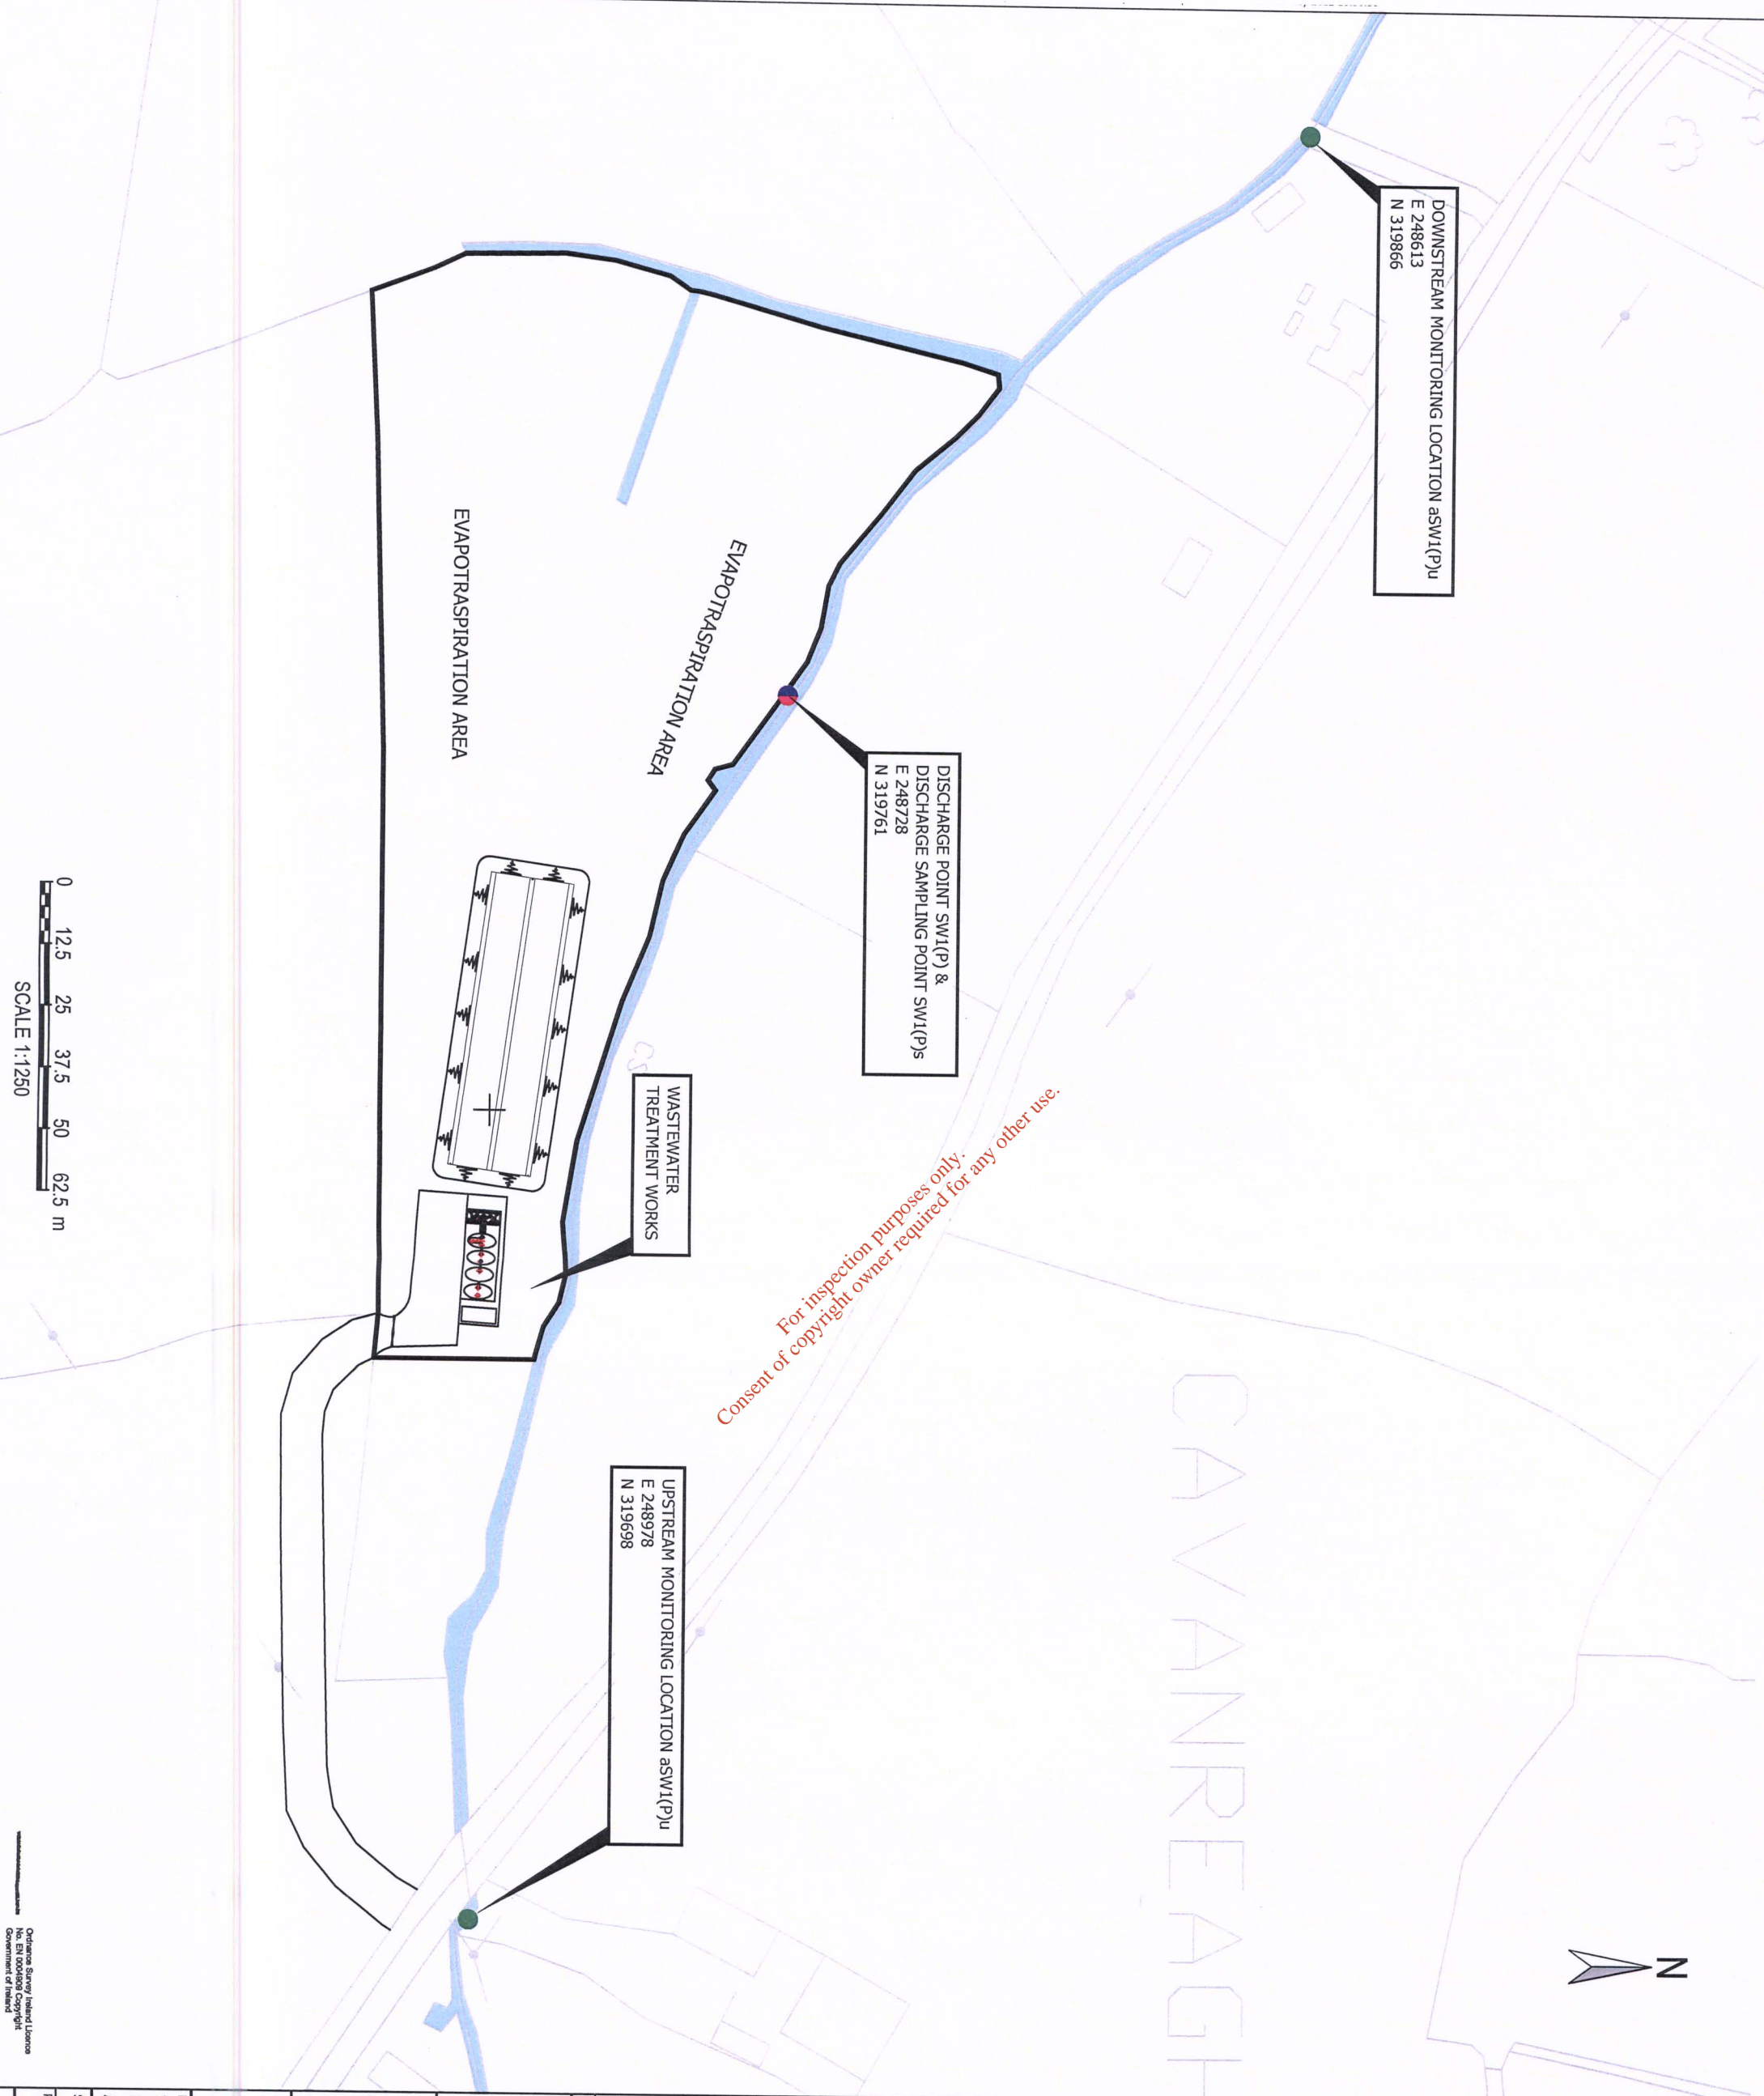



 
- LEGEND:**
- SAMPLING POINT
 - MONITORING LOCATION
 - DISCHARGE POINT

For inspection purposes only.
Consent of copyright owner required for any other use.



Ordinance Survey/ Ireland Licence
No. E11 0004000 Copyright
Government of Ireland

PH MCGARTHY HOUSE NUTGROVE OFFICE PARK NUTGROVE AVENUE RATHFRANKHAM, DUBLIN 14 TEL: +353 (0) 1291 4800 FAX: +353 (0) 1298 9521 e-mail: info@phmcc.com			
Project: SCOTSHOUSE DISCHARGE LICENCE APPLICATION			
Drawing Title: WASTE WATER TREATMENT PLANT MONITORING AND SAMPLING LOCATIONS ASSOCIATED WITH DISCHARGE POINT			
REV A U/S IGS amended SM, MCC.	DESCRIPTION 9/05/12	BY CHK	APP DATE
Monaghan County Council Comhairle Contae Mhúineacháin			
			
Scale @ A3 AS SHOWN Project No. C007400		Drawn HS Date 15.06.09 Office Type	Checked CS Date 15.06.09 Drawing No. DRAWING 4 Revision A

 


EVAPOTRASPIRATION AREA


EVAPOTRASPIRATION AREA

FENCING

ENTRANCE GATE

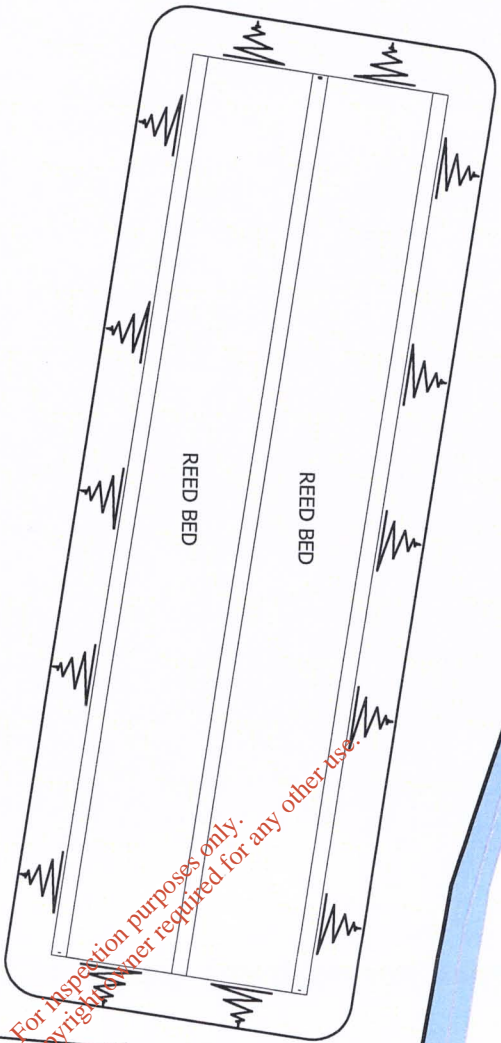

For inspection purposes only.
Consent of copyright owner required for any other use.

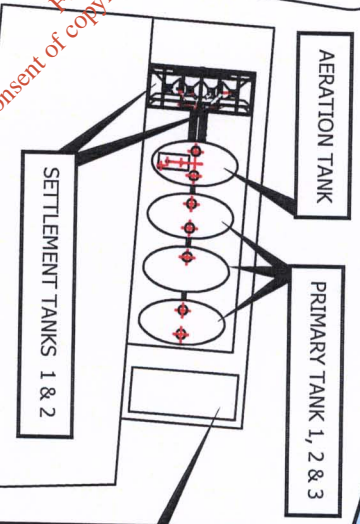

© WYFG Group Ltd.

A Dwg no. changed: SM M.C.C. 9-05-12

REV	DESCRIPTION	BY	CHK	APP	DATE

Monaghan County Council
Comhairle Contae Mhuineacháin



PH MCCARTHY HOUSE
NUTGROVE OFFICE PARK
NUTGROVE AVENUE,
RATHFARNHAM, DUBLIN 14




TEL: +353 (0) 1291 4800
FAX: +353 (0) 1298 9521
e-mail: info@phmcc.com

Project: SCOTSHOUSE
DISCHARGE LICENCE APPLICATION

Drawing Title: WASTE WATER TREATMENT PLANT
GENERAL ARRANGEMENTS

Scale @	A3	Drawn	Date	Checked	Date	Approved	Date
AS SHOWN	HS	15.06.09	CS	15.06.09	TK	15.06.09	
Project No.	Office	Type	Drawing No.	Revision			
C007400			DRAWING 5	A			

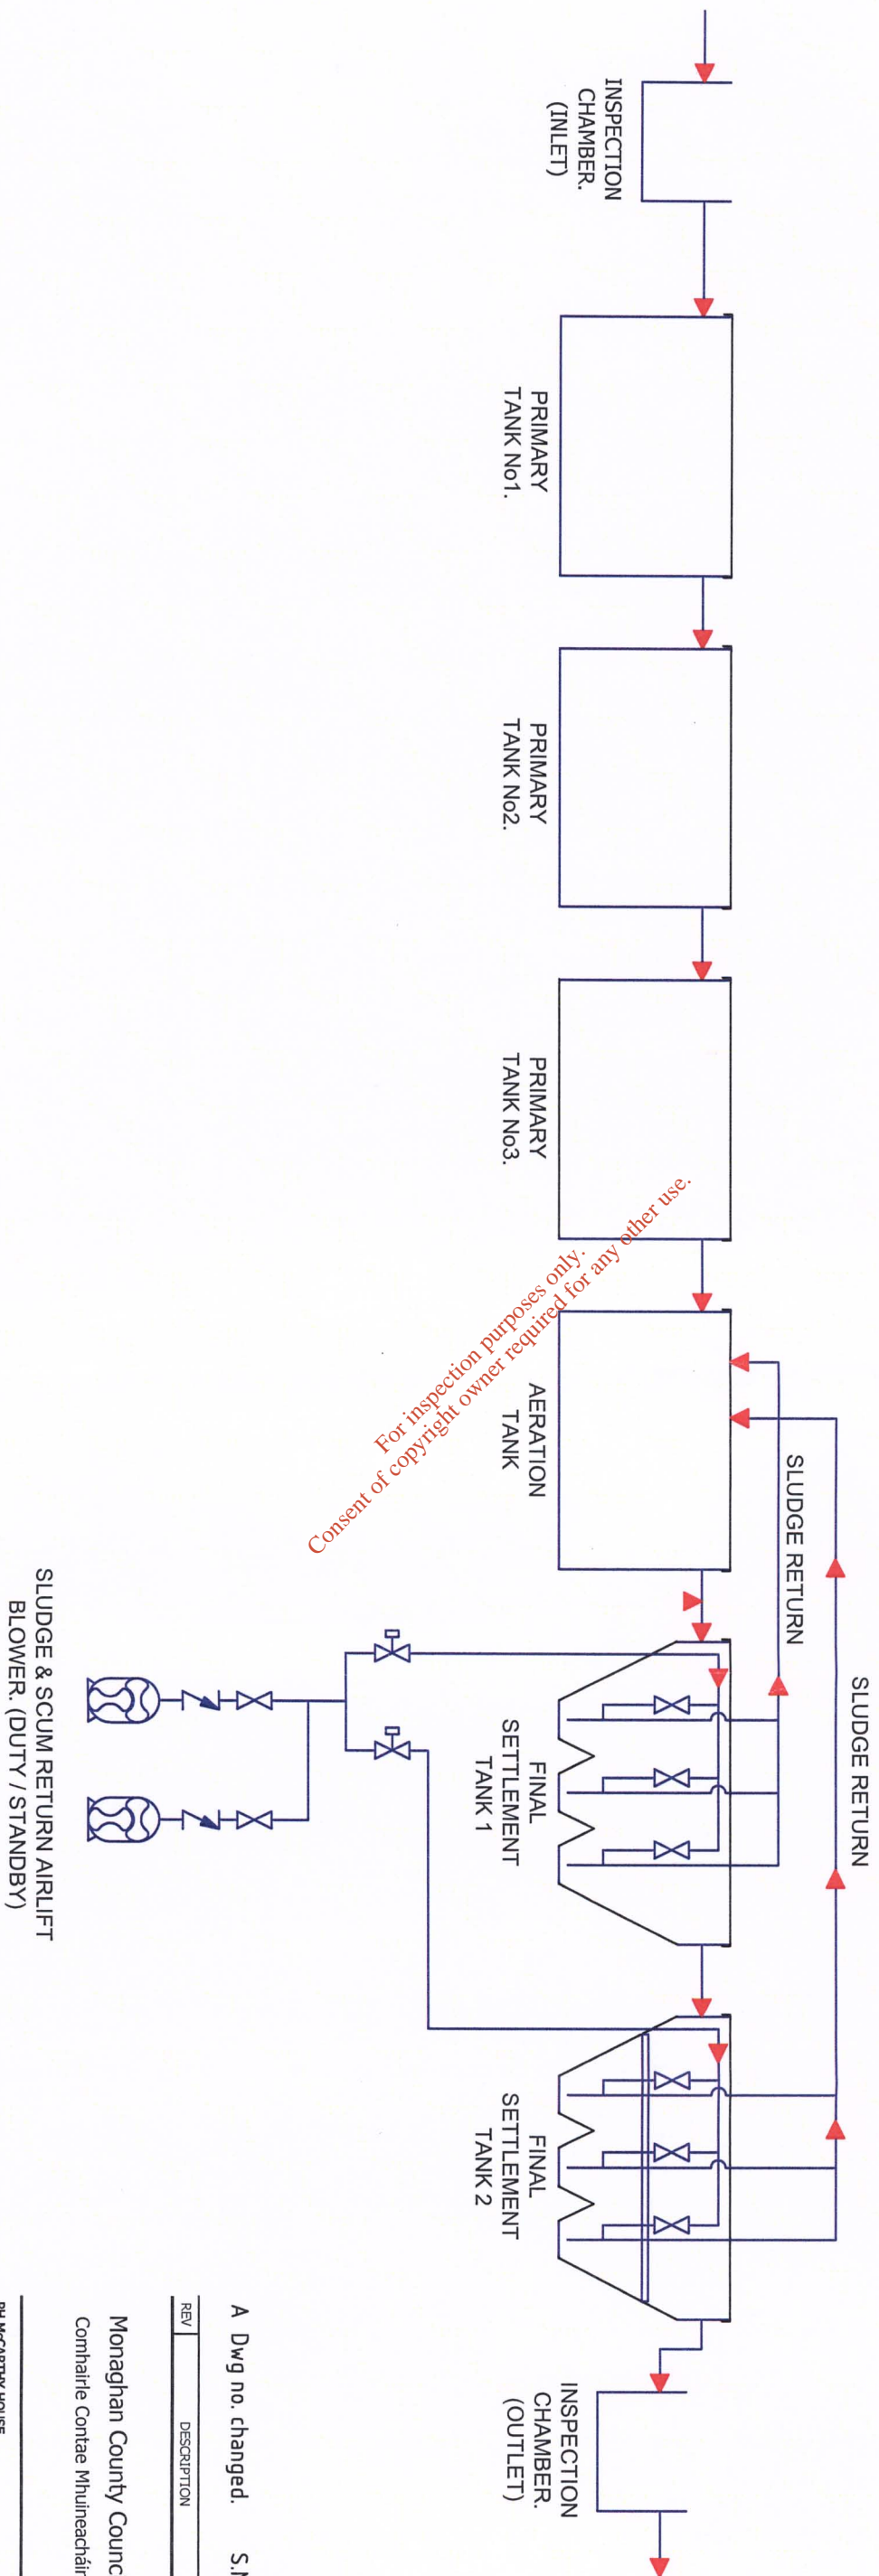

For inspection purposes only.
Consent of copyright owner required for any other use.

A Dwg no. changed. S.M. M.C.C. 9/05/12

REV/	DESCRIPTION	BY	CHK/APP	DATE

Monaghan County Council
Comhairle Contae Mhúineacháin



PH MCGARTHY HOUSE
NUTSGROVE OFFICE PARK
NUTSGROVE AVENUE,
RAITHFRANKHAM, DUBLIN 14



TEL: +353 (0) 1291 4800
FAX: +353 (0) 1298 9521
e-mail: info@phmcc.com

Project: SCOTSHOUSE
DISCHARGE LICENCE APPLICATION

Scale @	A3	Drawn	Date	Checked	Date	Approved	Date
AS SHOWN	HS	15.06.09	CS	15.06.09	TK	15.06.09	
Project No.	C007400	Office	Type	Drawing No.	DRAWING 6	Revision	A