


1. Copyright © 2010 AXIS Architecture
2. Work to signed dimensions only. Do not scale drawing.
3. The contractor is responsible for checking all levels and dimension on site and shall refer all discrepancies to the Architect.
4. Where appropriate, for details of c.i.e. structures, or mechanical and electrical details, see Engineer's drawings.
5. Proprietary items shall be fixed in strict accordance with manufacturers instructions.
6. Scales of proprietary items shall be checked with manufacturer.
7. The contractor shall be responsible for the coordination of structure, finishes and services.

NOTES:

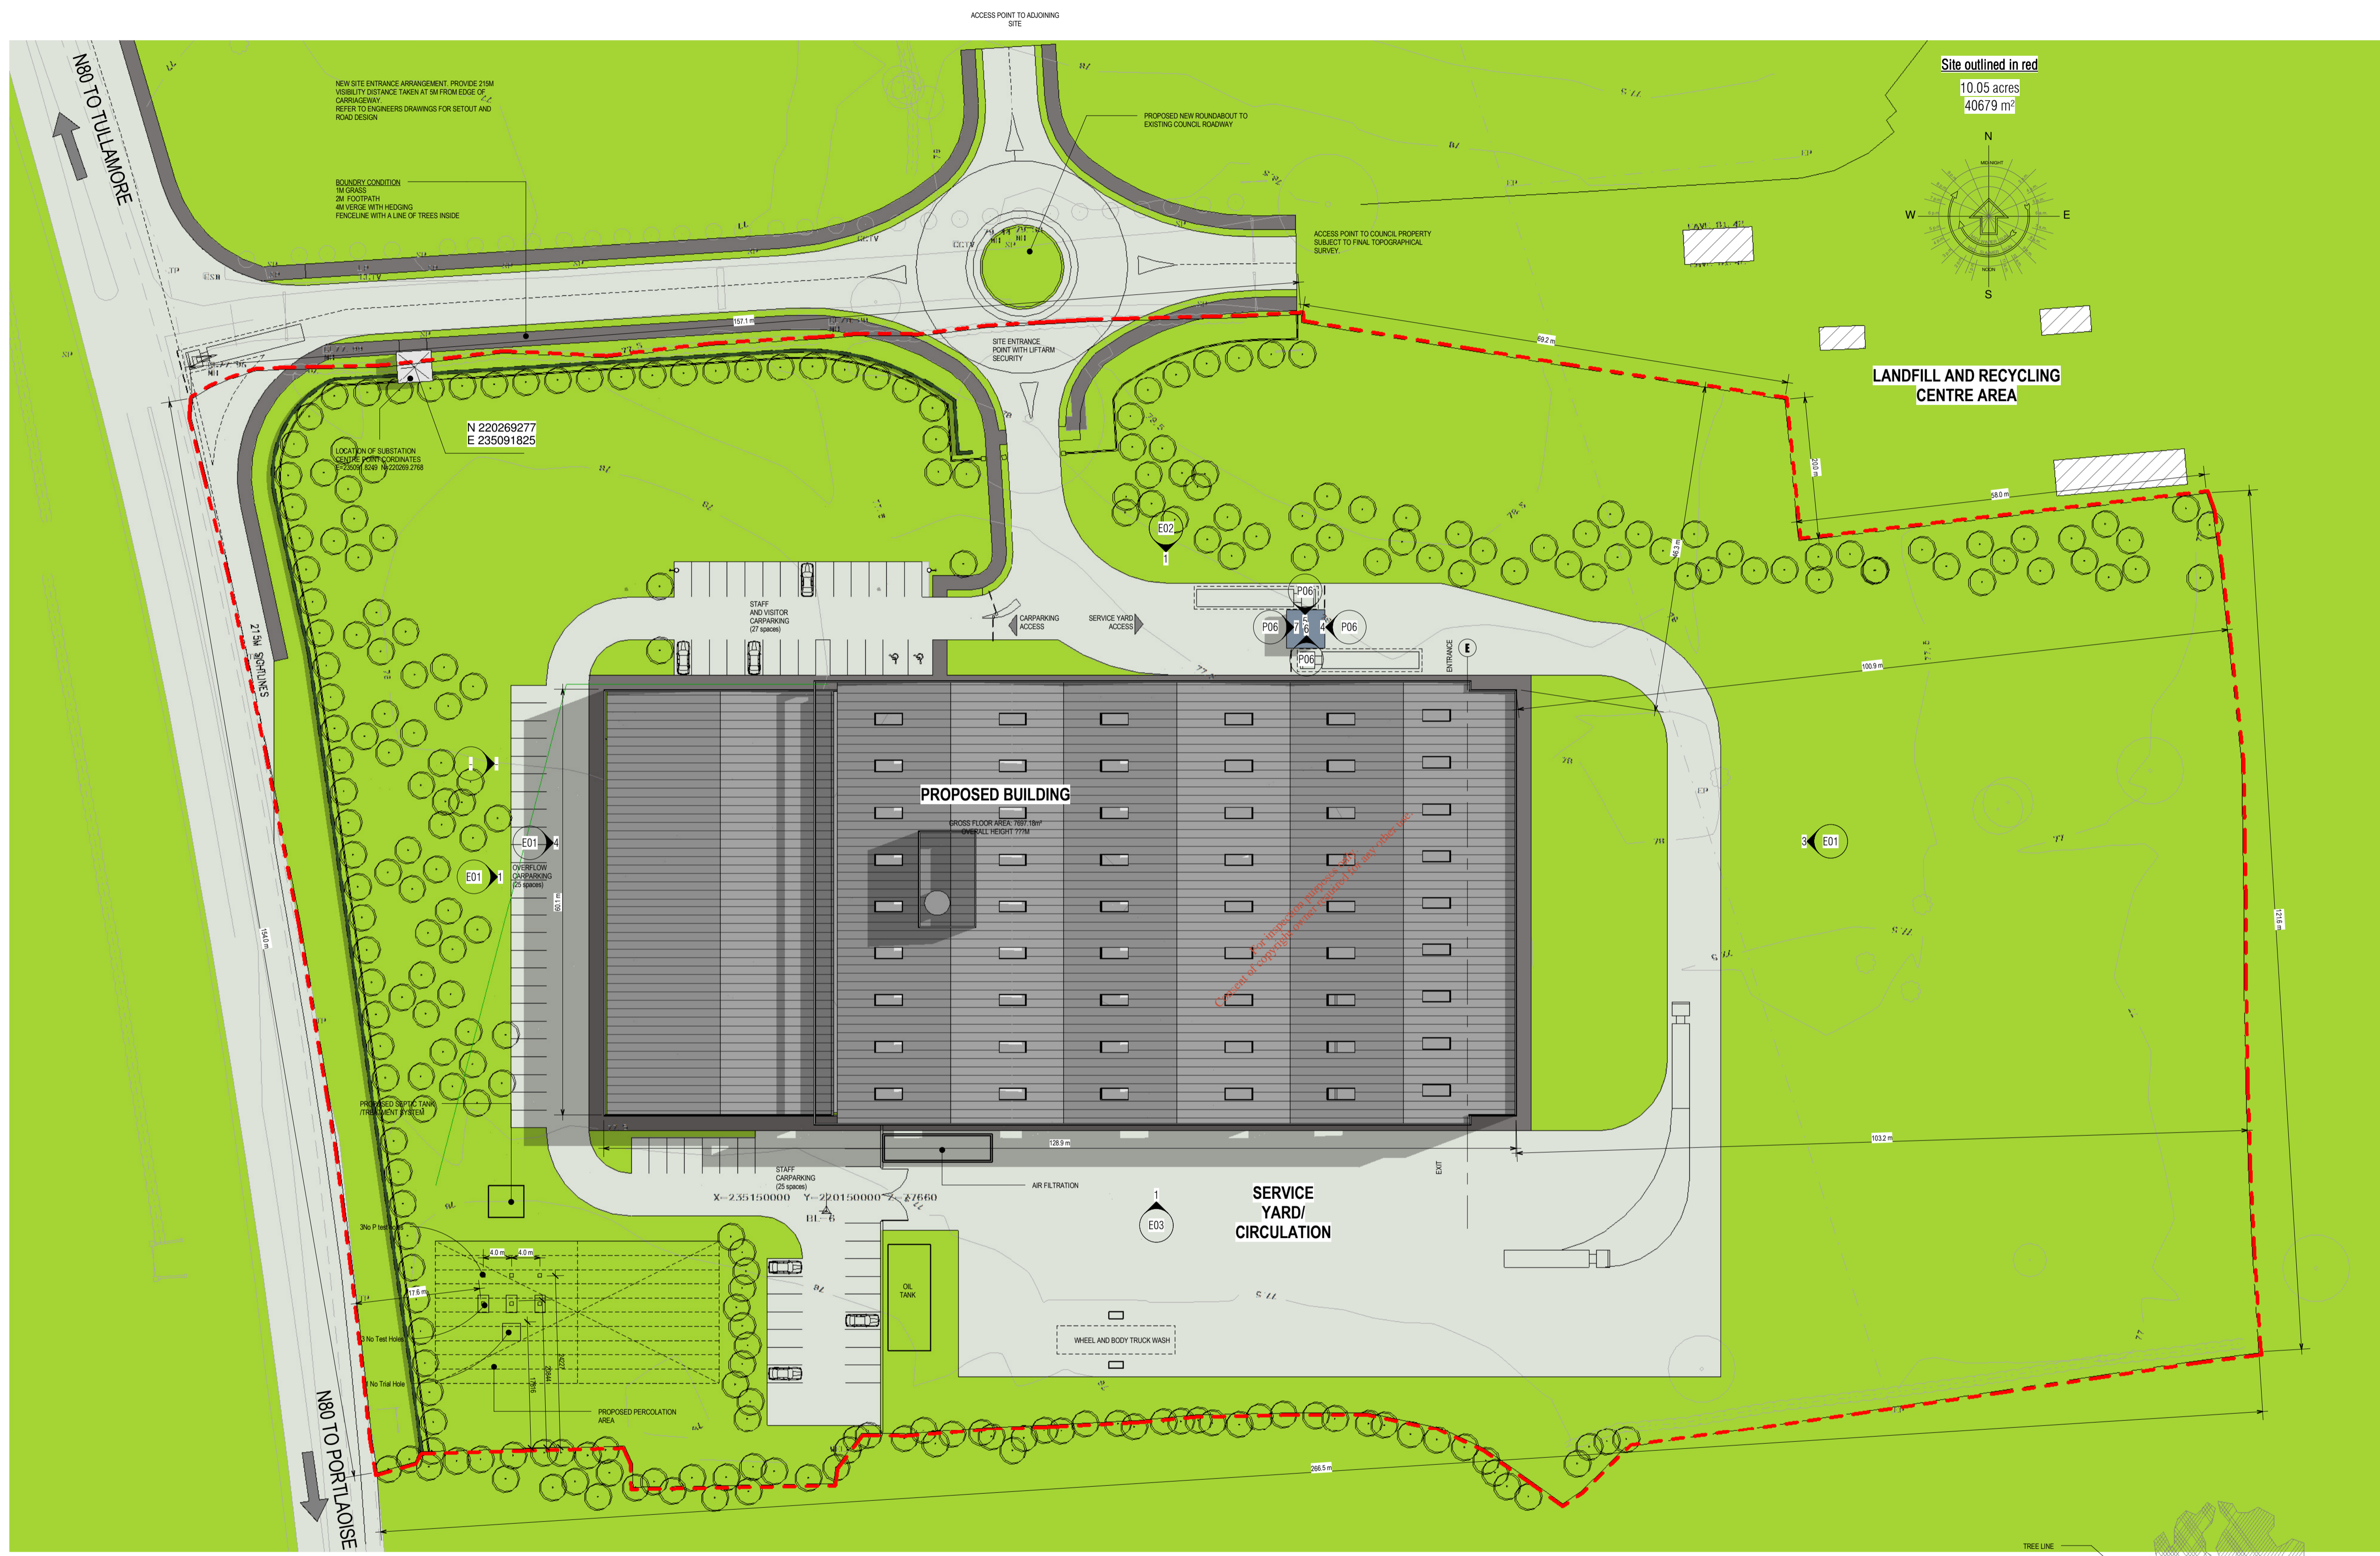

Rev	Description	Date	Issued

SKETCH

Client:
GLANPOWER
 CLEAN. GREEN. ENERGY.


Project:
ENERGY PARK

Address:
 DERRYCLURE, TULLAMORE, CO. OFFALY.

Sheet Name:
SITE LAYOUT PLAN

Drawing No:	Revision
P03	
Scale:	Date:
As indicated	ON A1 SHEET DEC 2009
Prepared:	Job No:
Author	0906

1 Site layout Plan
 1:500 RE: 1/E01

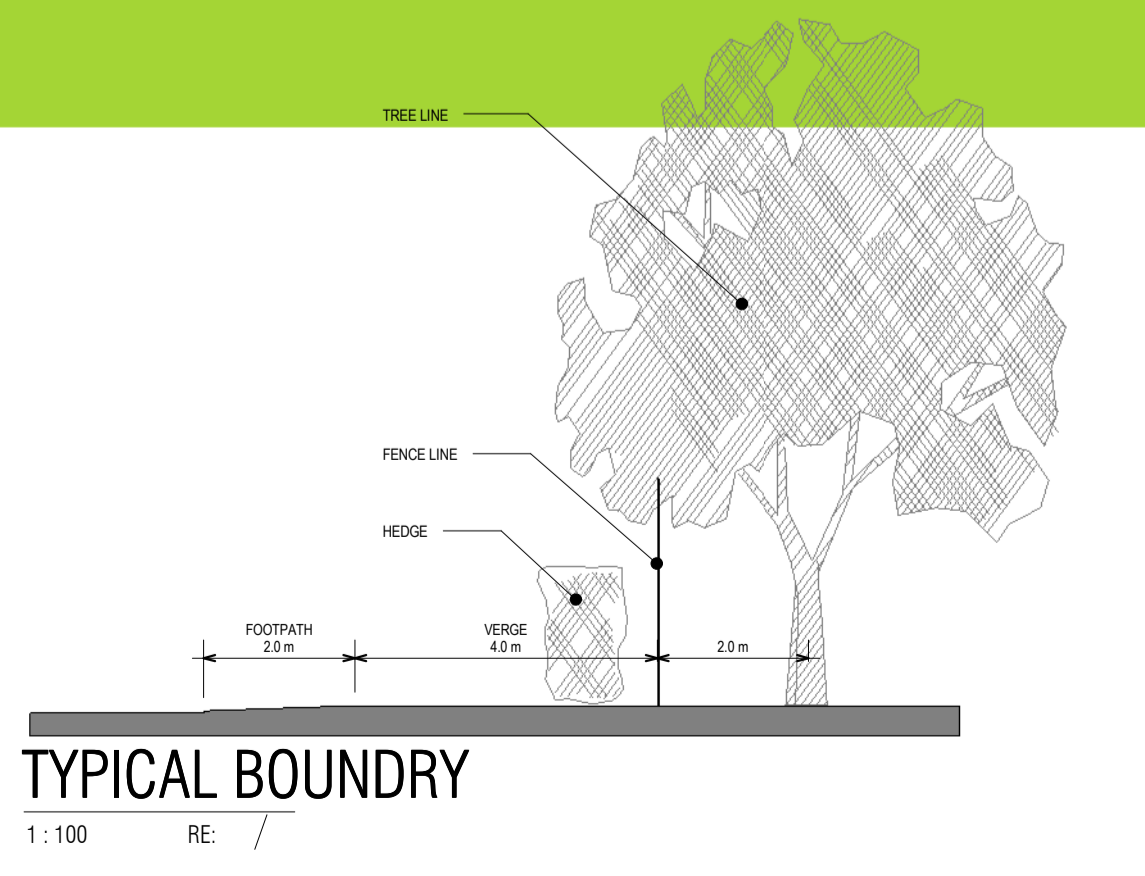

AXIS
 architecture

Penhouse Suite, Castle Buildings, Tara Street, Tullamore, Co. Offaly.
 T: 057 9329628 F: 057 9329638 E: info@axisarch.ie

