
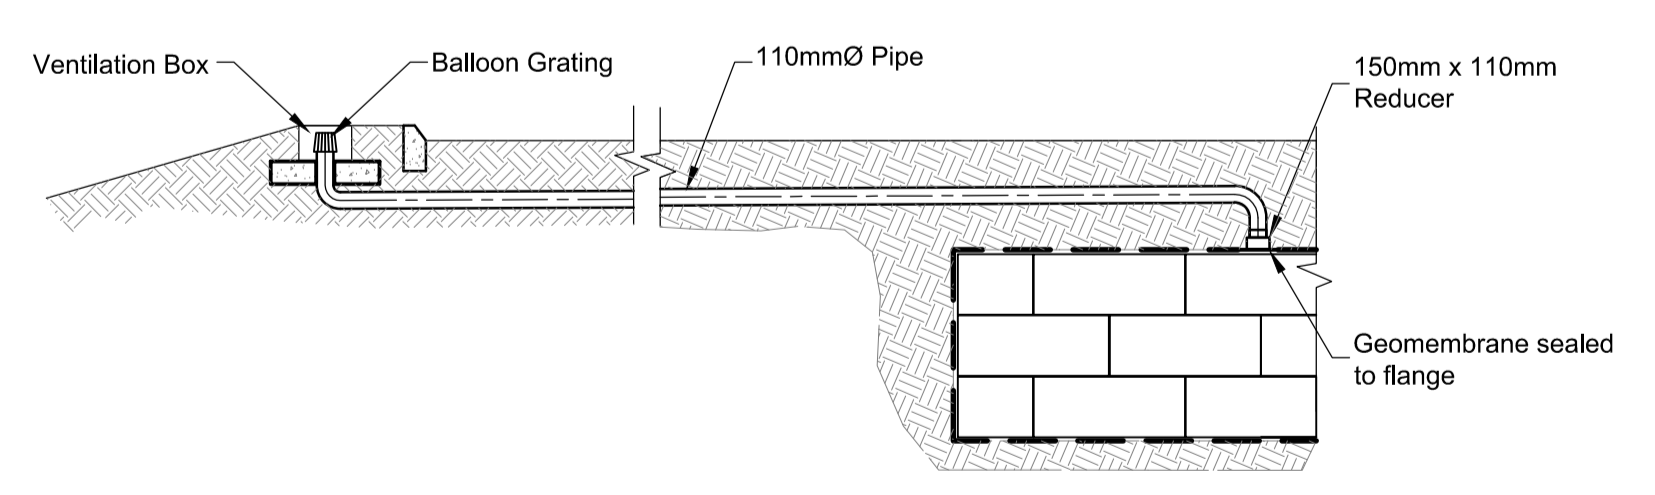


For construction purposes only.  
Consent of copyright owner required for any other use.

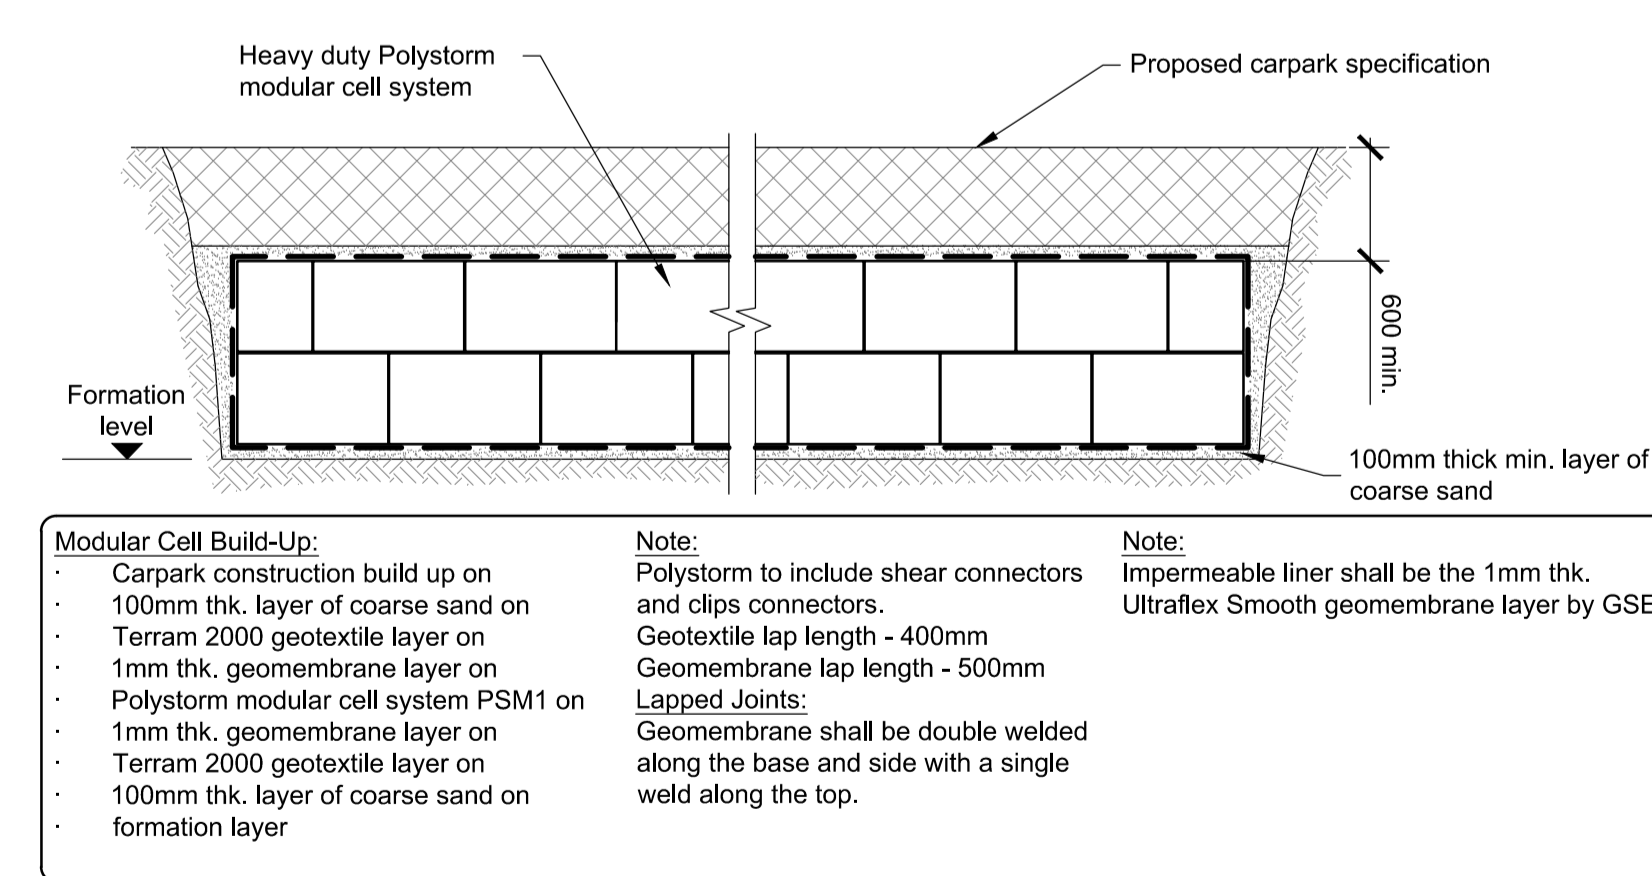

**Typical Section Through Air Vent**  
Scale: 1:50

**Proposed Polypipe Polystorm Modular Cell System**  
Scale: 1:50

<p><b>Notes:</b></p> <p>1) Proposed pipework shall be Polypipe Ridgidrain pipework and fittings u.n.o.</p> <p>2) Proposed drainage channel shall be the Aco MultiDrain M150D 20.0 with ductile iron Heelguard grating load class C250.</p> <p>3) Proposed hydrocarbon interceptor shall be a Class 1 by-pass separator ref. NSBP003 by Kingspan Klargestor</p> <p>4) The flow control shall be a hydrobrake by HRD Technologies: Head: 800mm Flow: 3L/Sec</p>	<p>5) Proposed attenuation structure shall be the Polypipe Polystorm modular cell ref. PSM1</p> <p><b>Legend:</b></p> <p>Pipework &amp; Manhole </p> <p>Hydrocarbon Interceptor </p> <p>Drainage Channel </p>	<table border="1"> <tr> <td>C1</td> <td>05/08/16</td> <td>D.F.</td> <td>J.B.</td> <td>J.MacC.</td> </tr> <tr> <td colspan="5">Issued for Construction</td> </tr> <tr> <td>T1</td> <td>29/04/16</td> <td>J.M.</td> <td>J.B.</td> <td>J.MacC.</td> </tr> <tr> <td colspan="5">Issued for Tender</td> </tr> <tr> <td>Rev</td> <td>Date</td> <td>By</td> <td>Chkd</td> <td>Appd</td> </tr> </table>	C1	05/08/16	D.F.	J.B.	J.MacC.	Issued for Construction					T1	29/04/16	J.M.	J.B.	J.MacC.	Issued for Tender					Rev	Date	By	Chkd	Appd	<p><b>ARUP</b></p> <p>15 Oliver Plunkett Street Cork, Ireland Tel +353 (0)21 427 7670 Fax +353 (0)21 427 2345 www.arup.com</p>	<p>Client: <b>Wyeth Nutritionals Ireland</b></p> <p>Project Title: <b>New Car Park Project</b></p>	<p>Drawing Title: <b>Proposed Surface Water Drainage Layout</b></p>	<p>Scale at A1: 1:250</p> <p>Role: <b>Site Infrastructure</b></p> <p>Suitability: <b>Construction</b></p> <p>Arup Job No: <b>233421-03</b></p> <p>Name: <b>C-000-007</b></p> <p>Rev: <b>C1</b></p>
C1	05/08/16	D.F.	J.B.	J.MacC.																											
Issued for Construction																															
T1	29/04/16	J.M.	J.B.	J.MacC.																											
Issued for Tender																															
Rev	Date	By	Chkd	Appd																											