
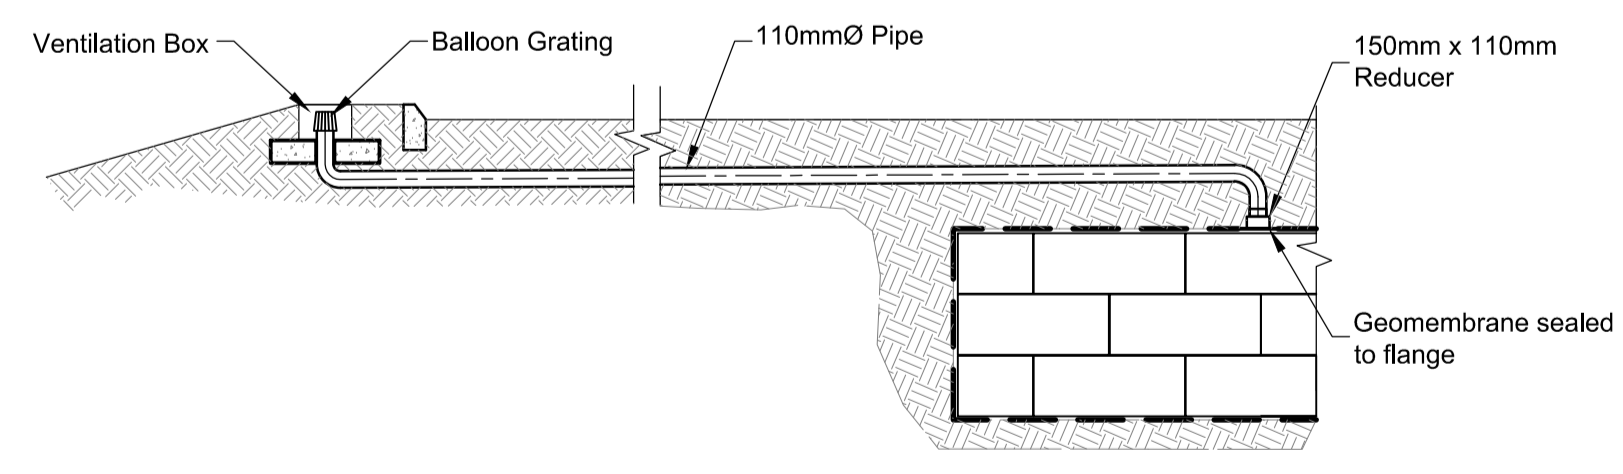


For construction purposes only.
Consent of copyright owner required for any other use.

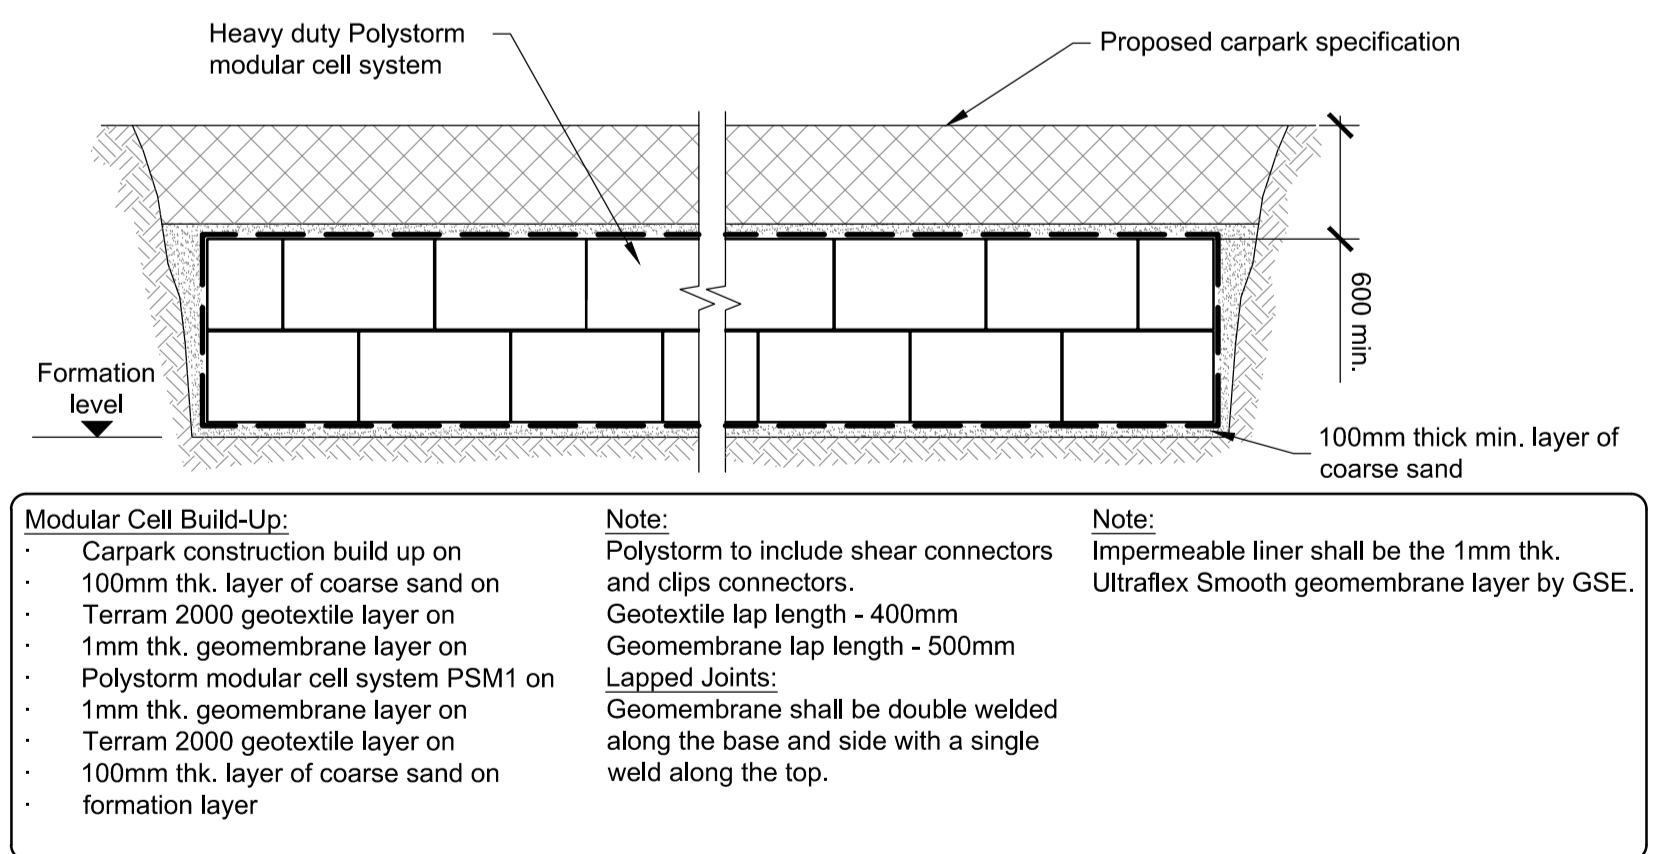

Typical Section Through Air Vent
Scale: 1:50

Proposed Polypipe Polystorm Modular Cell System
Scale: 1:50

<p>Notes:</p> <ol style="list-style-type: none"> Proposed pipework shall be Polypipe Ridgidrain pipework and fittings u.n.o. Proposed drainage channel shall be the Aco MultiDrain M150D 20.0 with ductile iron Heelguard grating load class C250. Proposed hydrocarbon interceptor shall be a Class 1 by-pass separator ref. NSBP003 by Kingspan Klargestor The flow control shall be a hydrobrake by HRD Technologies: Head: 800mm Flow: 3L/Sec 	<p>5) Proposed attenuation structure shall be the Polypipe Polystorm modular cell ref. PSM1</p> <p>Legend:</p> <p>Pipework & Manhole </p> <p>Hydrocarbon Interceptor </p> <p>Drainage Channel </p>	<table border="1" style="width: 100%; border-collapse: collapse;"> <tr> <td>C1</td> <td>05/08/16</td> <td>D.F.</td> <td>J.B.</td> <td>J.MacC.</td> </tr> <tr> <td colspan="5" style="text-align: center;">Issued for Construction</td> </tr> <tr> <td>T1</td> <td>29/04/16</td> <td>J.M.</td> <td>J.B.</td> <td>J.MacC.</td> </tr> <tr> <td colspan="5" style="text-align: center;">Issued for Tender</td> </tr> <tr> <td>Rev</td> <td>Date</td> <td>By</td> <td>Chkd</td> <td>Appd</td> </tr> </table>	C1	05/08/16	D.F.	J.B.	J.MacC.	Issued for Construction					T1	29/04/16	J.M.	J.B.	J.MacC.	Issued for Tender					Rev	Date	By	Chkd	Appd	<p style="text-align: center;">ARUP</p> <p style="font-size: small;">15 Oliver Plunkett Street Cork, Ireland Tel +353 (0)21 427 7670 Fax +353 (0)21 427 2345 www.arup.com</p> <p style="text-align: center;">Wyeth Nutrition</p>	<p>Client Wyeth Nutritionals Ireland</p> <p>Project Title New Car Park Project</p>	<p>Drawing Title Proposed Surface Water Drainage Layout</p>	<p>Scale at A1: 1:250</p> <p>Role: Site Infrastructure</p> <p>Suitability: Construction</p> <p>Arup Job No: 233421-03</p> <p>Name: C-000-007</p> <p>Rev: C1</p>
C1	05/08/16	D.F.	J.B.	J.MacC.																											
Issued for Construction																															
T1	29/04/16	J.M.	J.B.	J.MacC.																											
Issued for Tender																															
Rev	Date	By	Chkd	Appd																											