

ATTACHMENT NO. E

EMISSIONS


*For inspection purposes only.
Consent of copyright owner required for any other use.*

E.3 - Emissions to Ground

Refer to the Attached Drawings:

- Storm Drainage Layout Plan Drawing No. 214037-02
- Pig Manure Drainage Layout Plan Drawing No. 214037-01

*For inspection purposes only.
Consent of copyright owner required for any other use.*

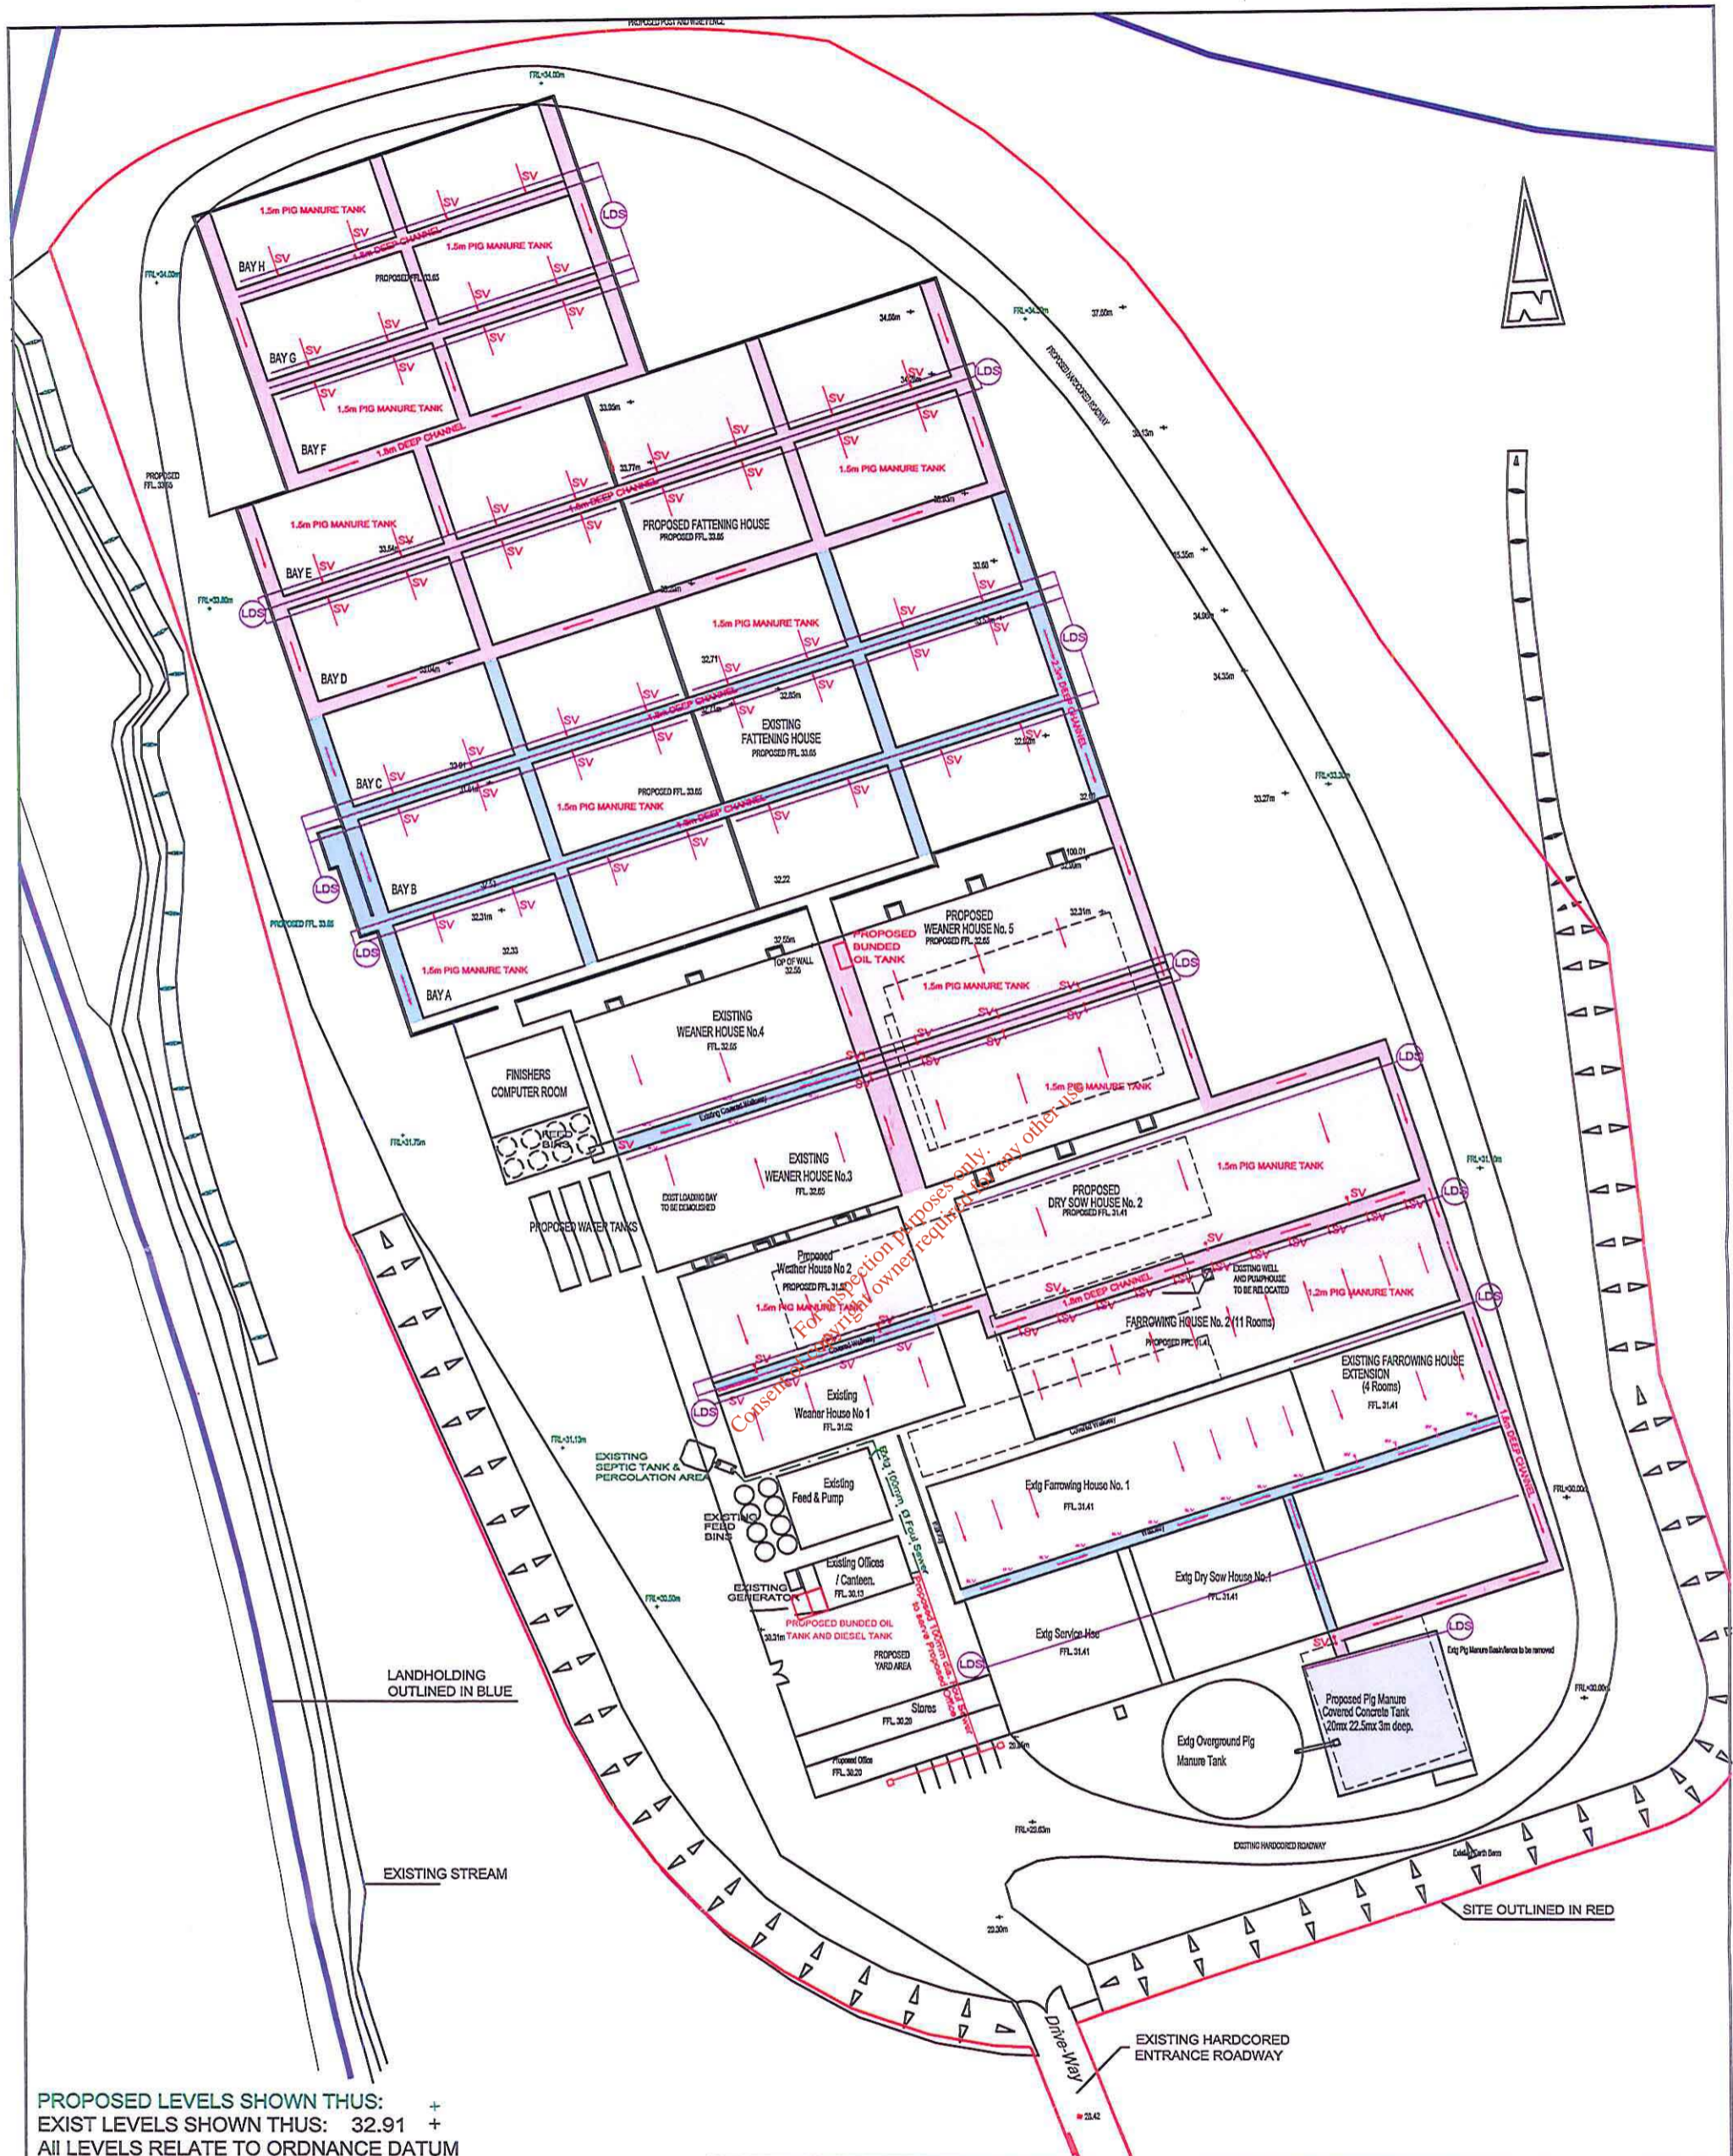

PROPOSED LEVELS SHOWN THUS: +
 EXIST LEVELS SHOWN THUS: 32.91 +
 ALL LEVELS RELATE TO ORDNANCE DATUM

EXISTING PIG MANURE CHANNELS INDICATED THUS
 PROPOSED PIG MANURE CHANNELS INDICATED THUS
 EXISTING PIG MANURE LINES INDICATED THUS
 PROPOSED PIG MANURE LINES INDICATED THUS

EXISTING STRUCTURE/BUILDING TO BE DEMOLISHED SHOWN THUS

LEAK DETECTION SUMP (LDS) LDS


Refer to Drg No. 214037-03 for details

Client Eoin O'Brien	Project EPA Submission	Date 12.04.17
Drawing Title Proposed Pig Manure Drainage Layout Plan		Scale 1:1000@A3
		Drawing No 214037-01



Murphy McCarthy Consulting Engineers Ltd.

EastPark House, Marina Commercial Park, Centre Park Road, Cork.
 Telephone: 021-4317992 Fax: 021-4311410 Email: murmac@iol.ie

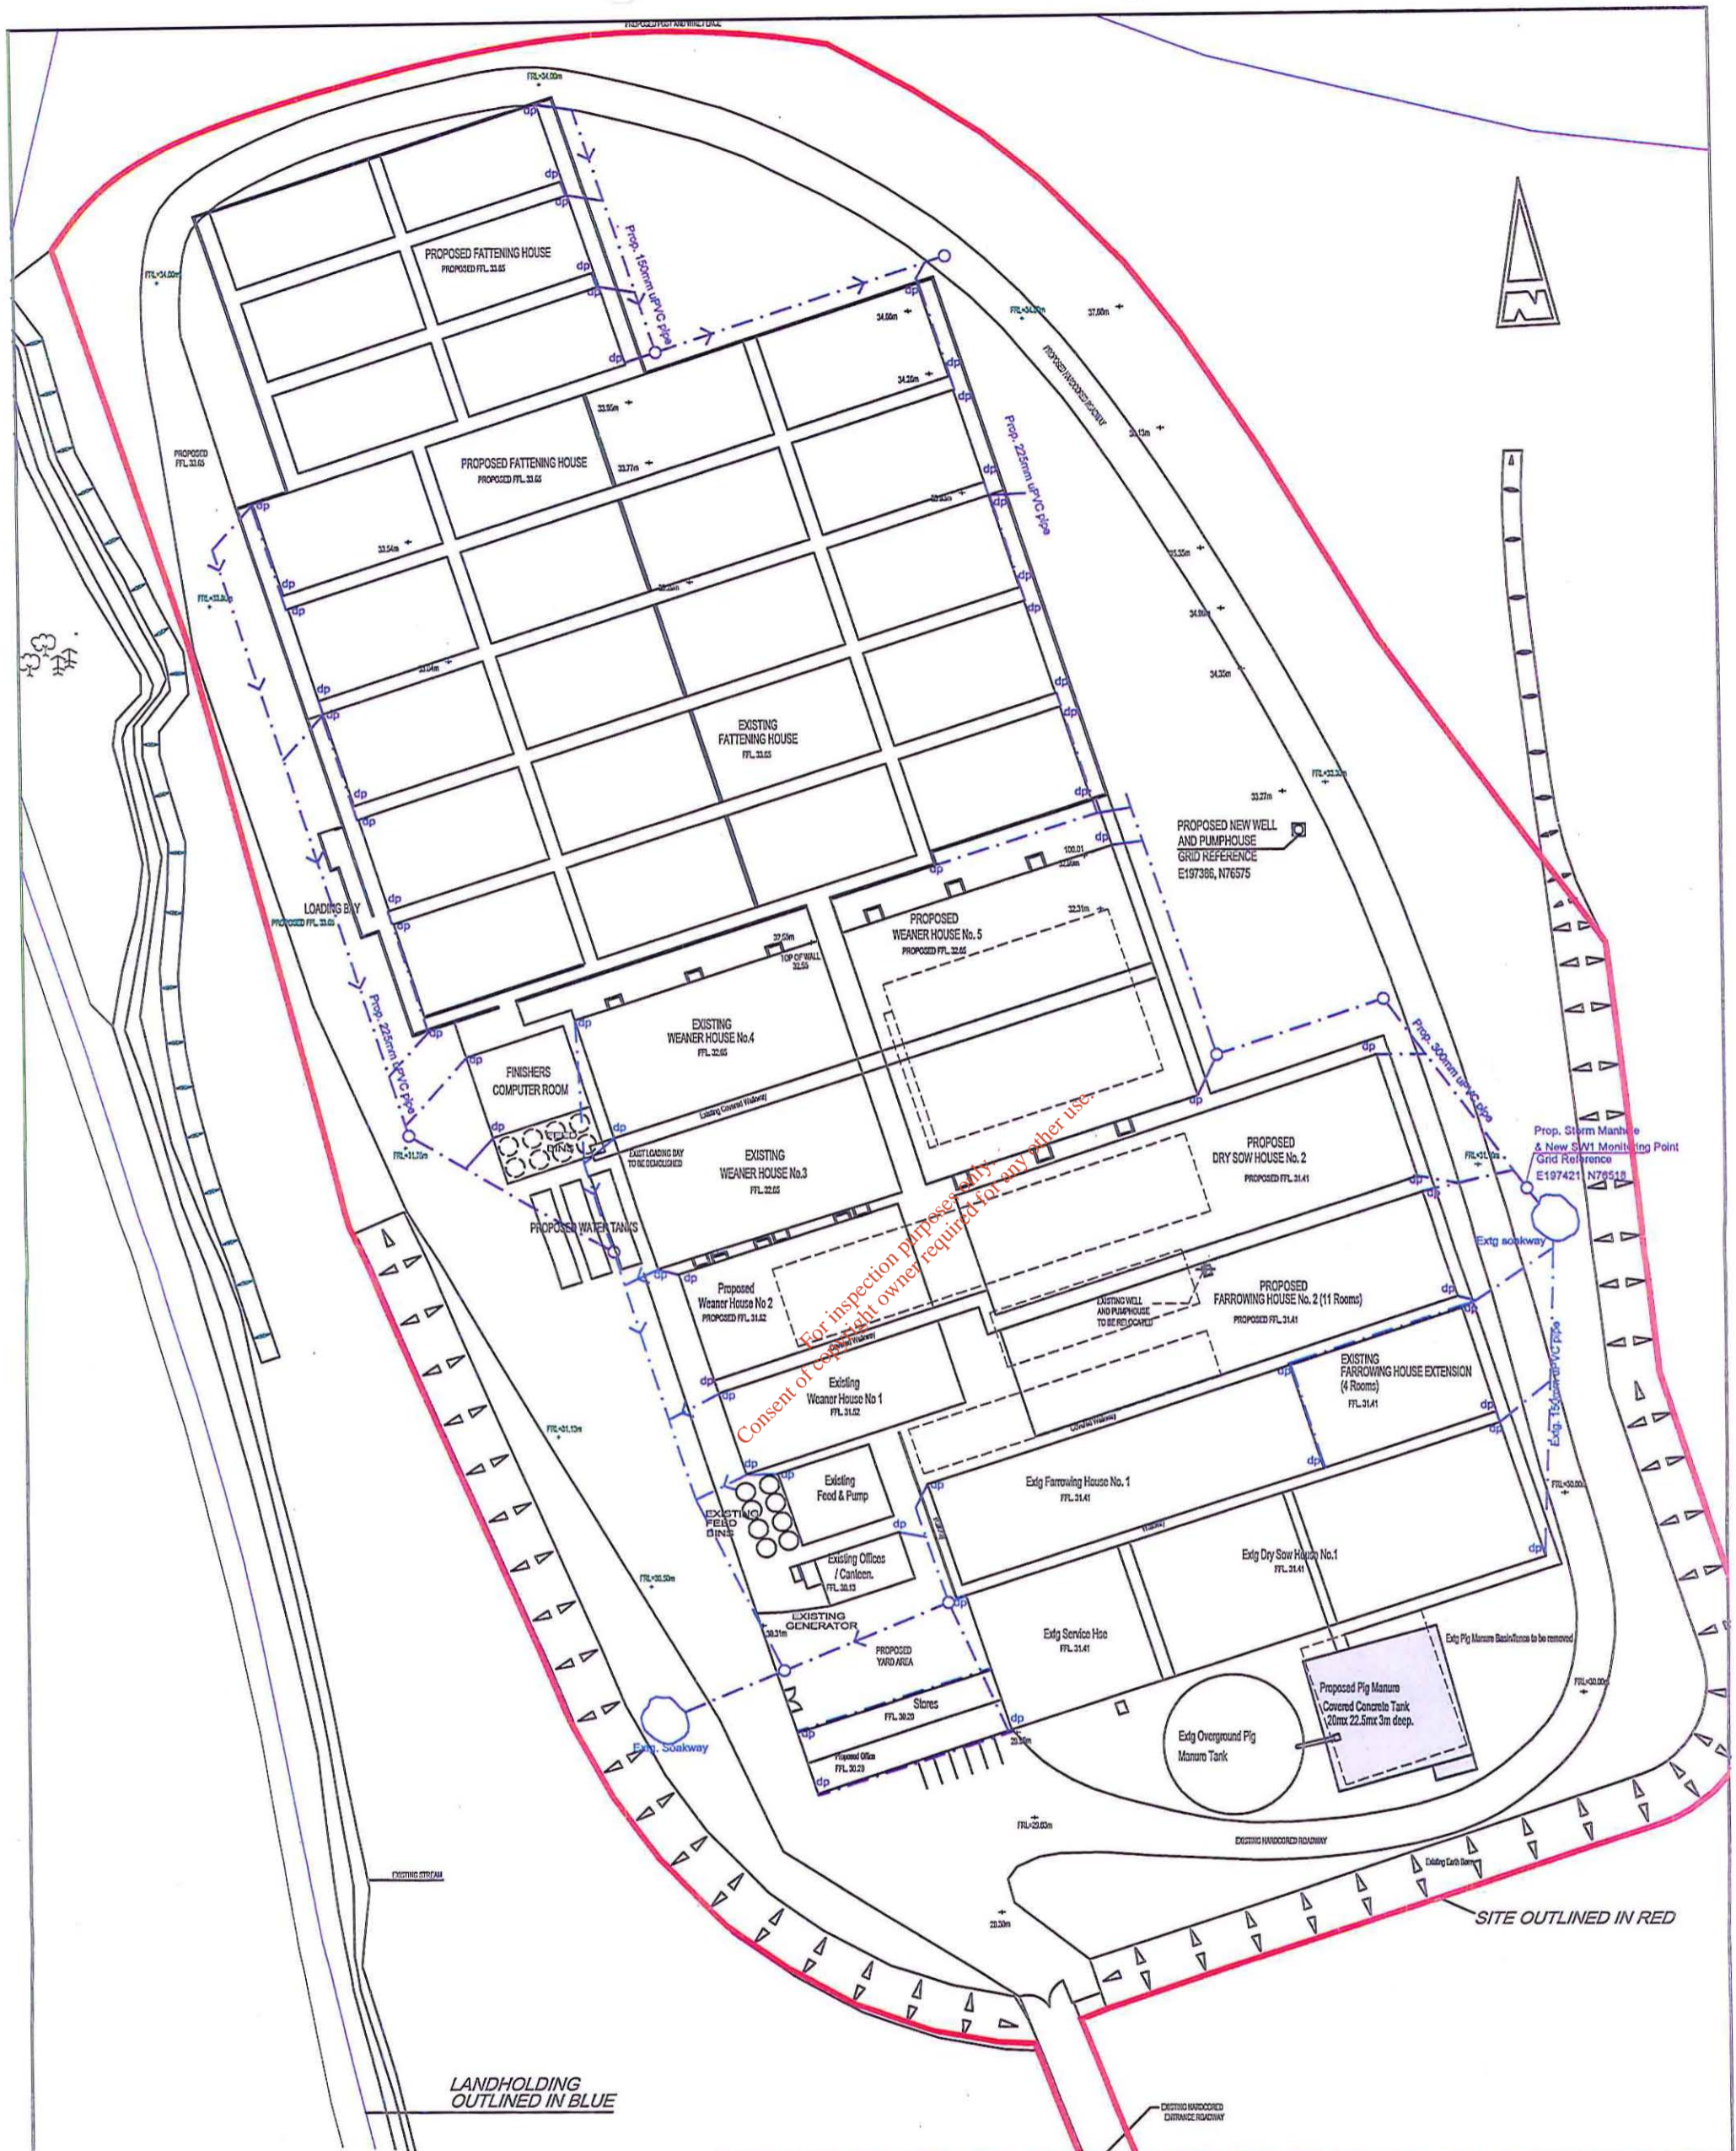

For inspection purposes only
 Consent of copyright owner required for any other use

PROPOSED LEVELS SHOWN THUS: + 32.91
 EXIST LEVELS SHOWN THUS: + 32.91
 ALL LEVELS RELATE TO ORDNANCE DATUM

EXISTING ROOF WATER DRAINAGE - - - - -
 PROPOSED ROOF WATER DRAINAGE - - - - -

EXISTING STRUCTURE/BUILDING TO
 BE DEMOLISHED SHOWN THUS

Client	Eoin O'Brien	Project	EPA Submission	Date	12.04.17
Drawing Title	Storm Drainage Layout Plan			Scale	1:1000@A3
				Drawing No	214037-02



Murphy McCarthy Consulting Engineers Ltd.

EastPark House, Marina Commercial Park, Centre Park Road, Cork.
 Telephone: 021-4317992 Fax: 021-4311410 Email: murmac@iol.ie