
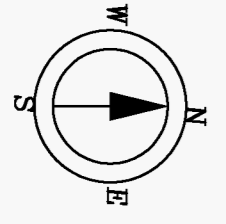


LEGEND

	Water course
	Direction of flow
	Storm Water Routes Enclosed
	Open
	Downpipe
	Direction of Effluent Flow
	Process Water Routes Enclosed
	Open
	Areas for Fire Water
	Containment
	Site Buildings
	Communications
	Aerial
	Spot Levels

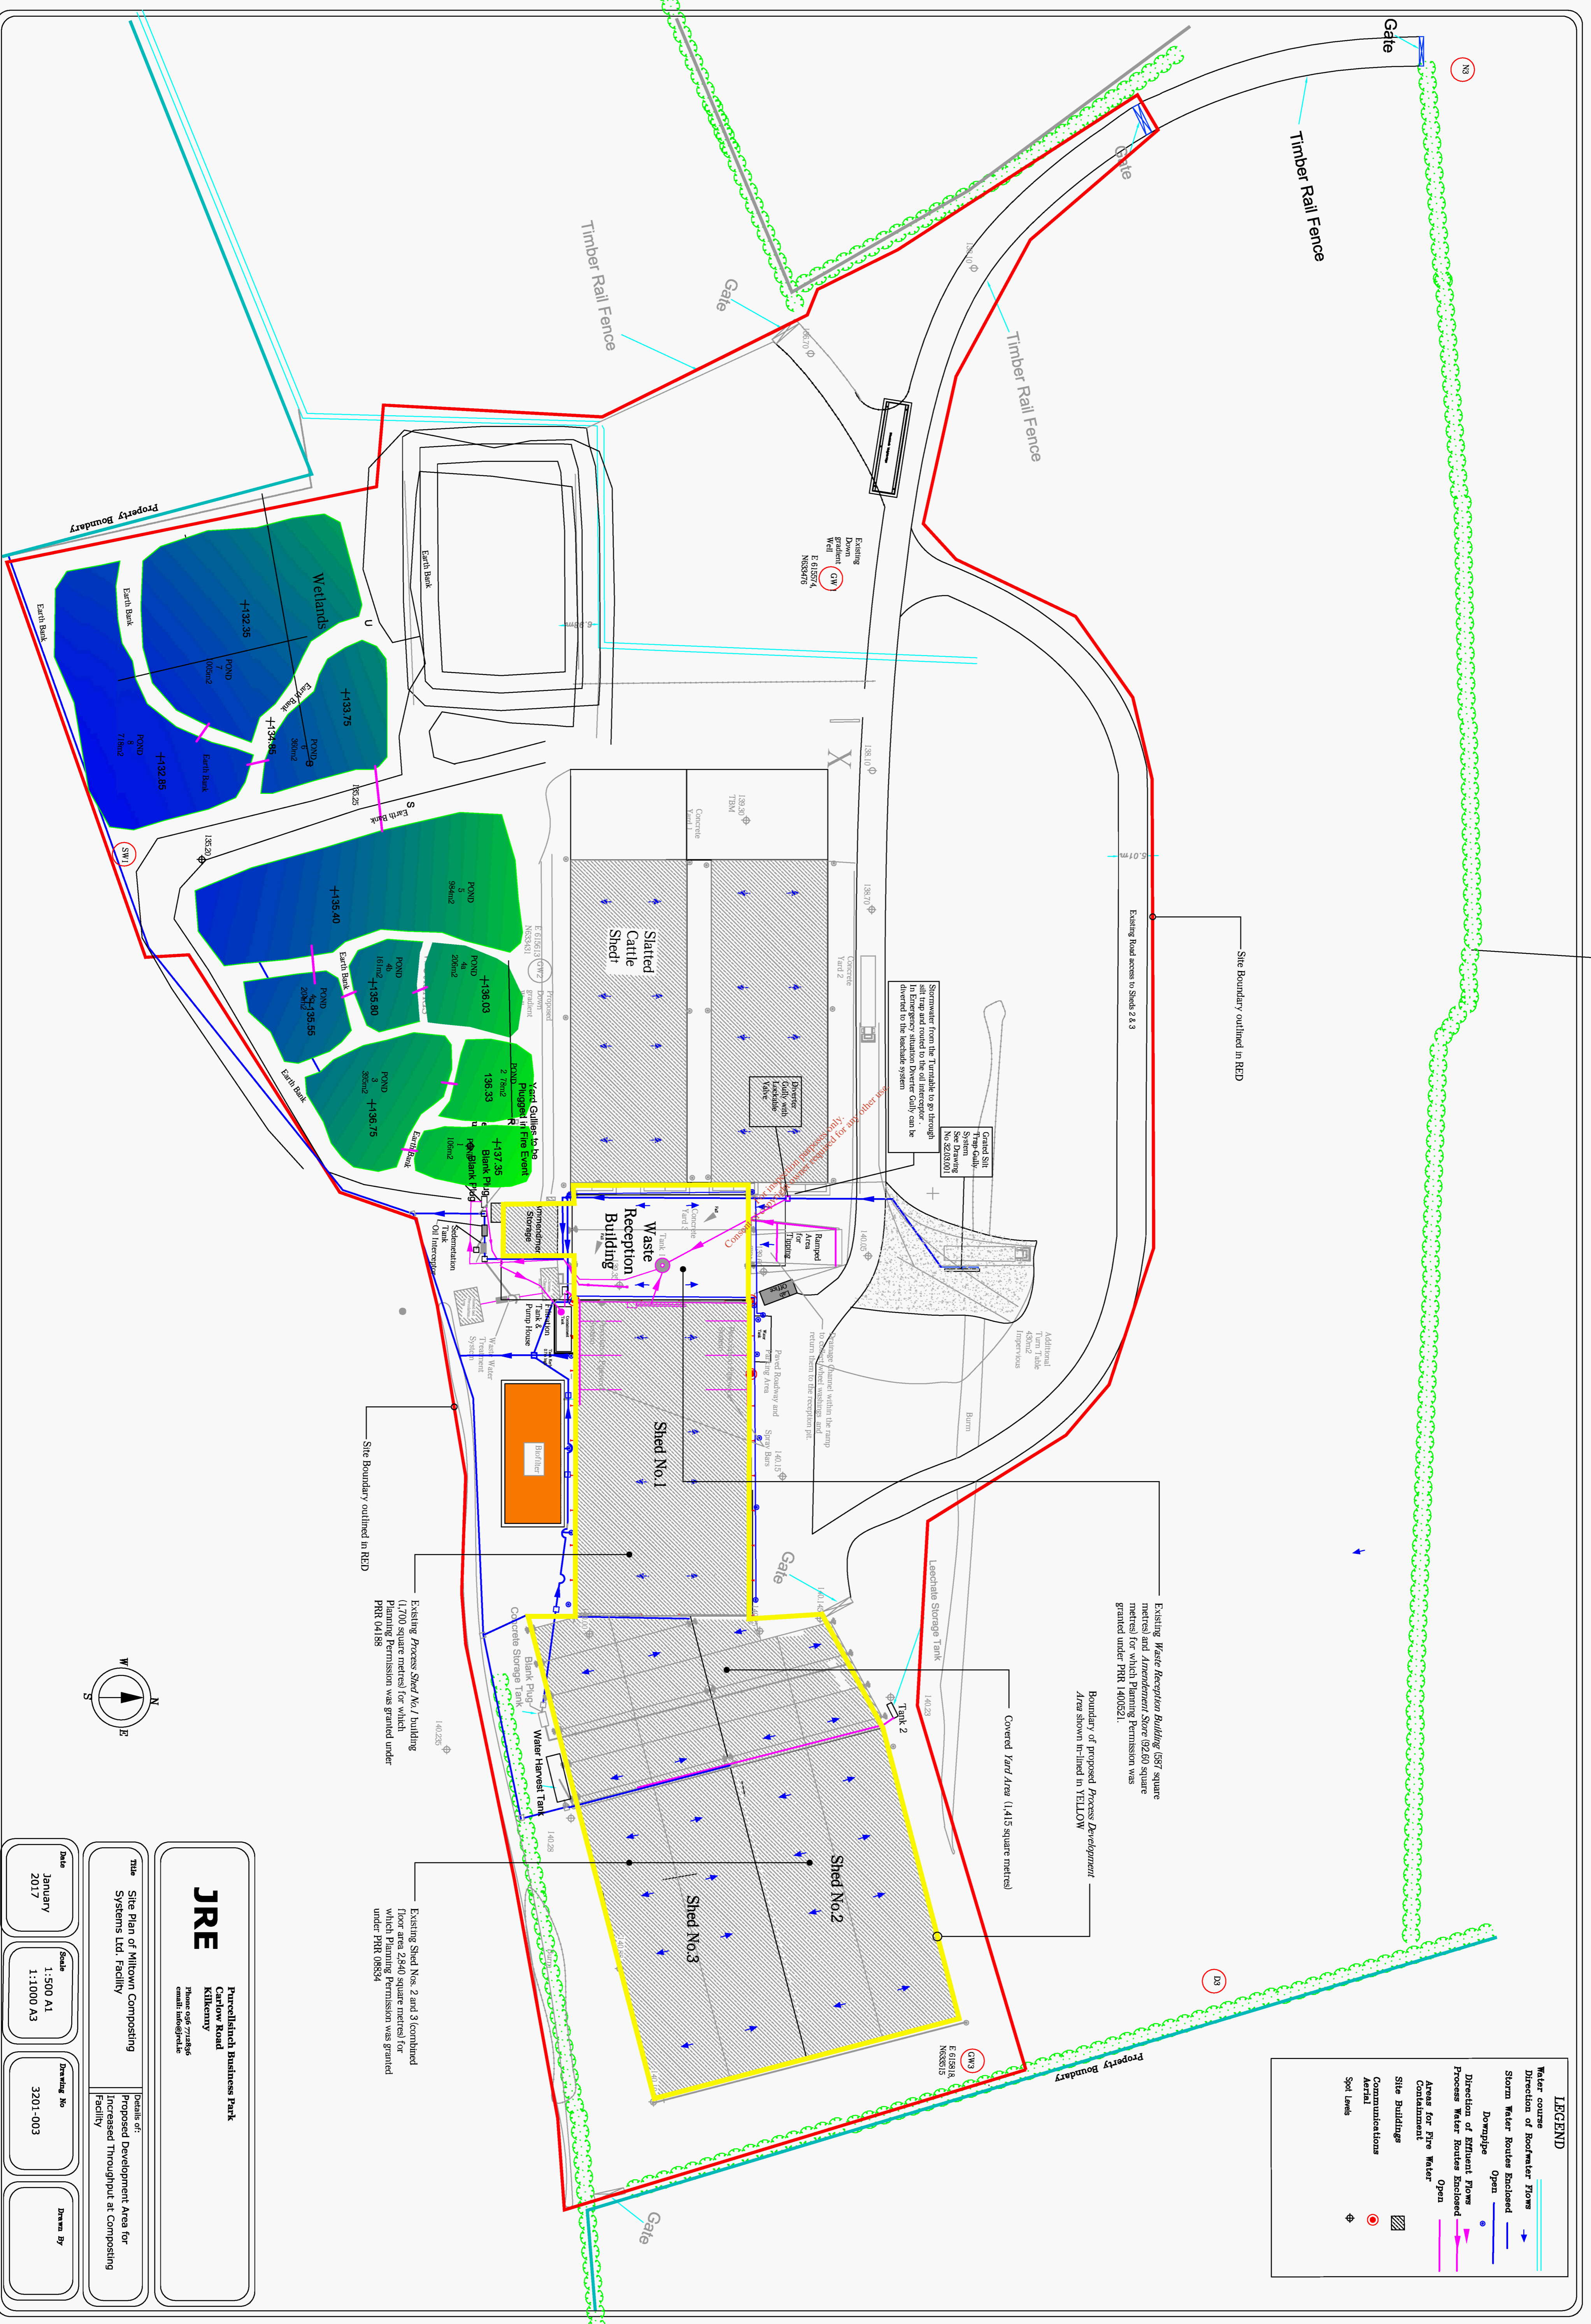

JRE
 Pricelastach Business Park
 Carrrow Road
 Kilkenny
 Phone: 041 7714865
 Email: info@jre.ie

Title: Site Plan of Milltown Composting Facility
Details of: Proposed Development Area for Increased Throughput at Composting Facility

Date: January 2017

Scale: 1:500 A1
1:1000 A3

Drawing No: 3201-003

Drawn By: