


Attachment 3

*For inspection purposes only.
Consent of copyright owner required for any other use.*

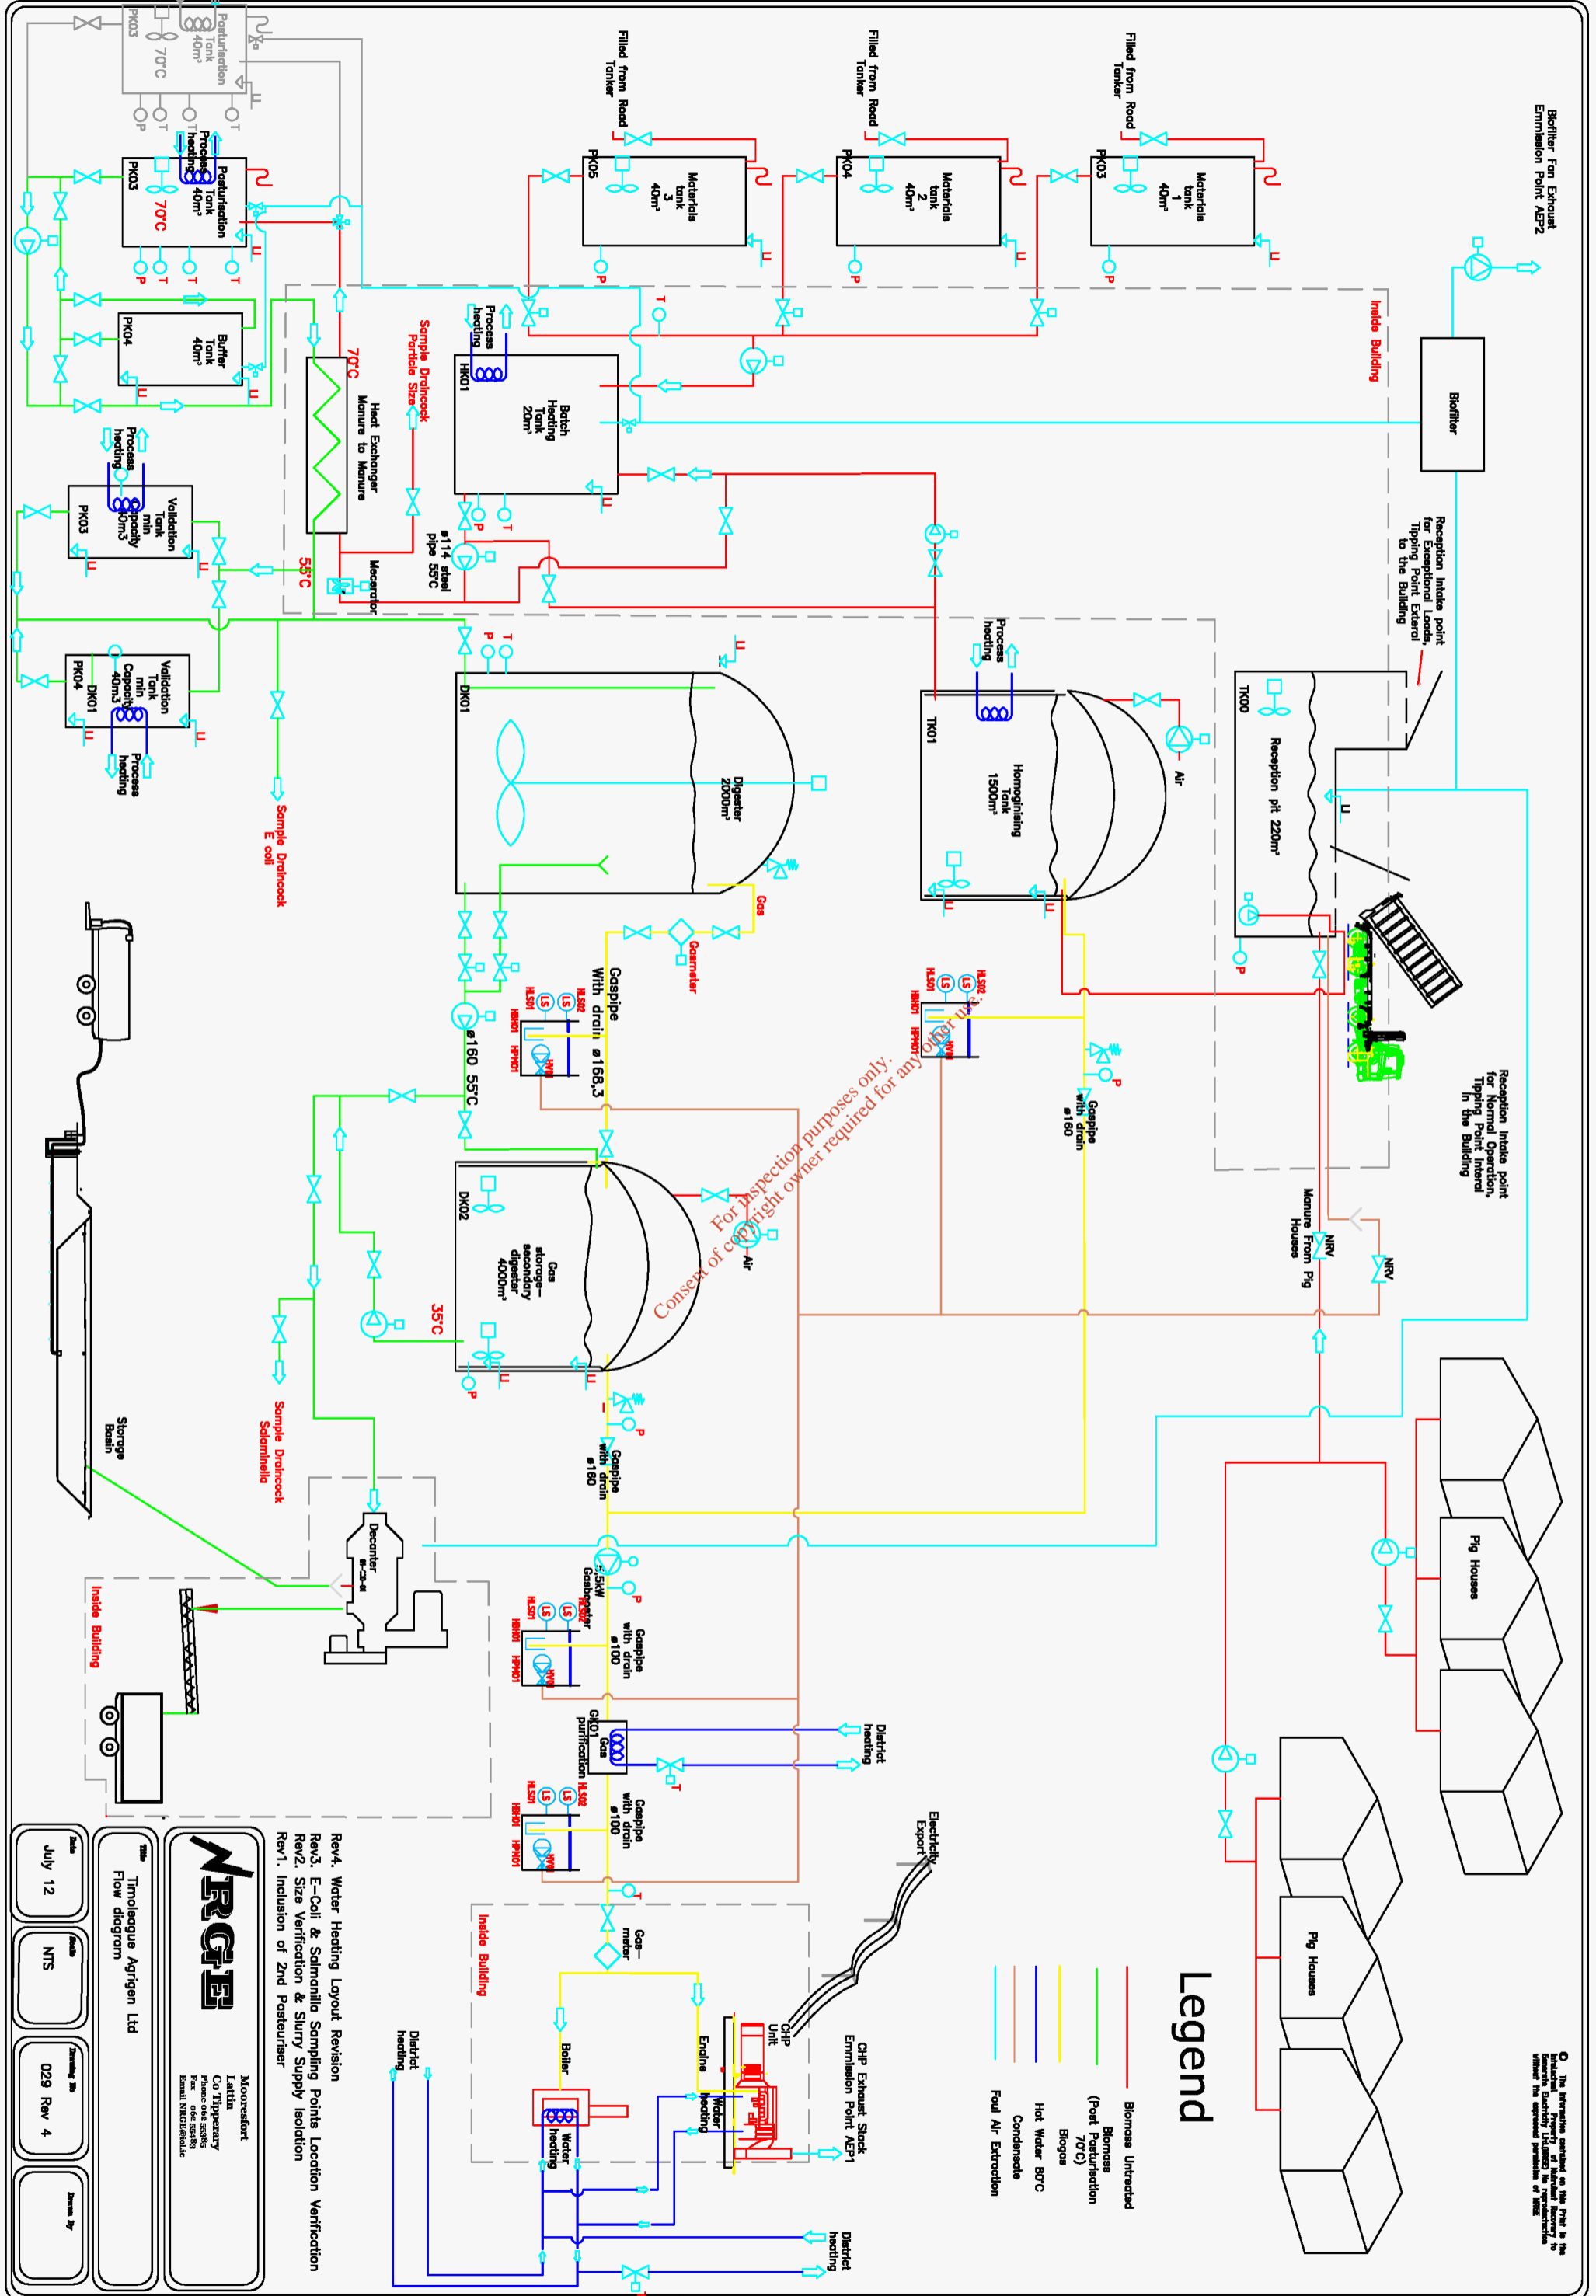

For inspection purposes only.
Consent of copyright owner required for any other use.

Legend

- Biomass Untreated
- Biomass (Post) Pasteurisation (70°C)
- Biomass
- Hot Water BWC
- Condensate
- Foul Air Extraction

- Rev4. Water Heating Layout Revision
- Rev3. E-Coil & Salinella Sampling Points Location Verification
- Rev2. Size Verification & Slurry Supply Isolation
- Rev1. Inclusion of 2nd Pasteuriser



Macrossfort
Lathin
Oa Ippengary
Farm
E-mail: nrcgate@bt.com

Timoleague Agrigen Ltd
Flow diagram

Date	Drawn	Checked By	Drawn By
July 12	NTS	029 Rev 4	