




ATTACHMENT NO: B.1

DRAWING NO. 01: AGGLOMERATION PLAN

IW-10015228-03-02-001

*For inspection purposes only.
Consent of copyright owner required for any other use.*

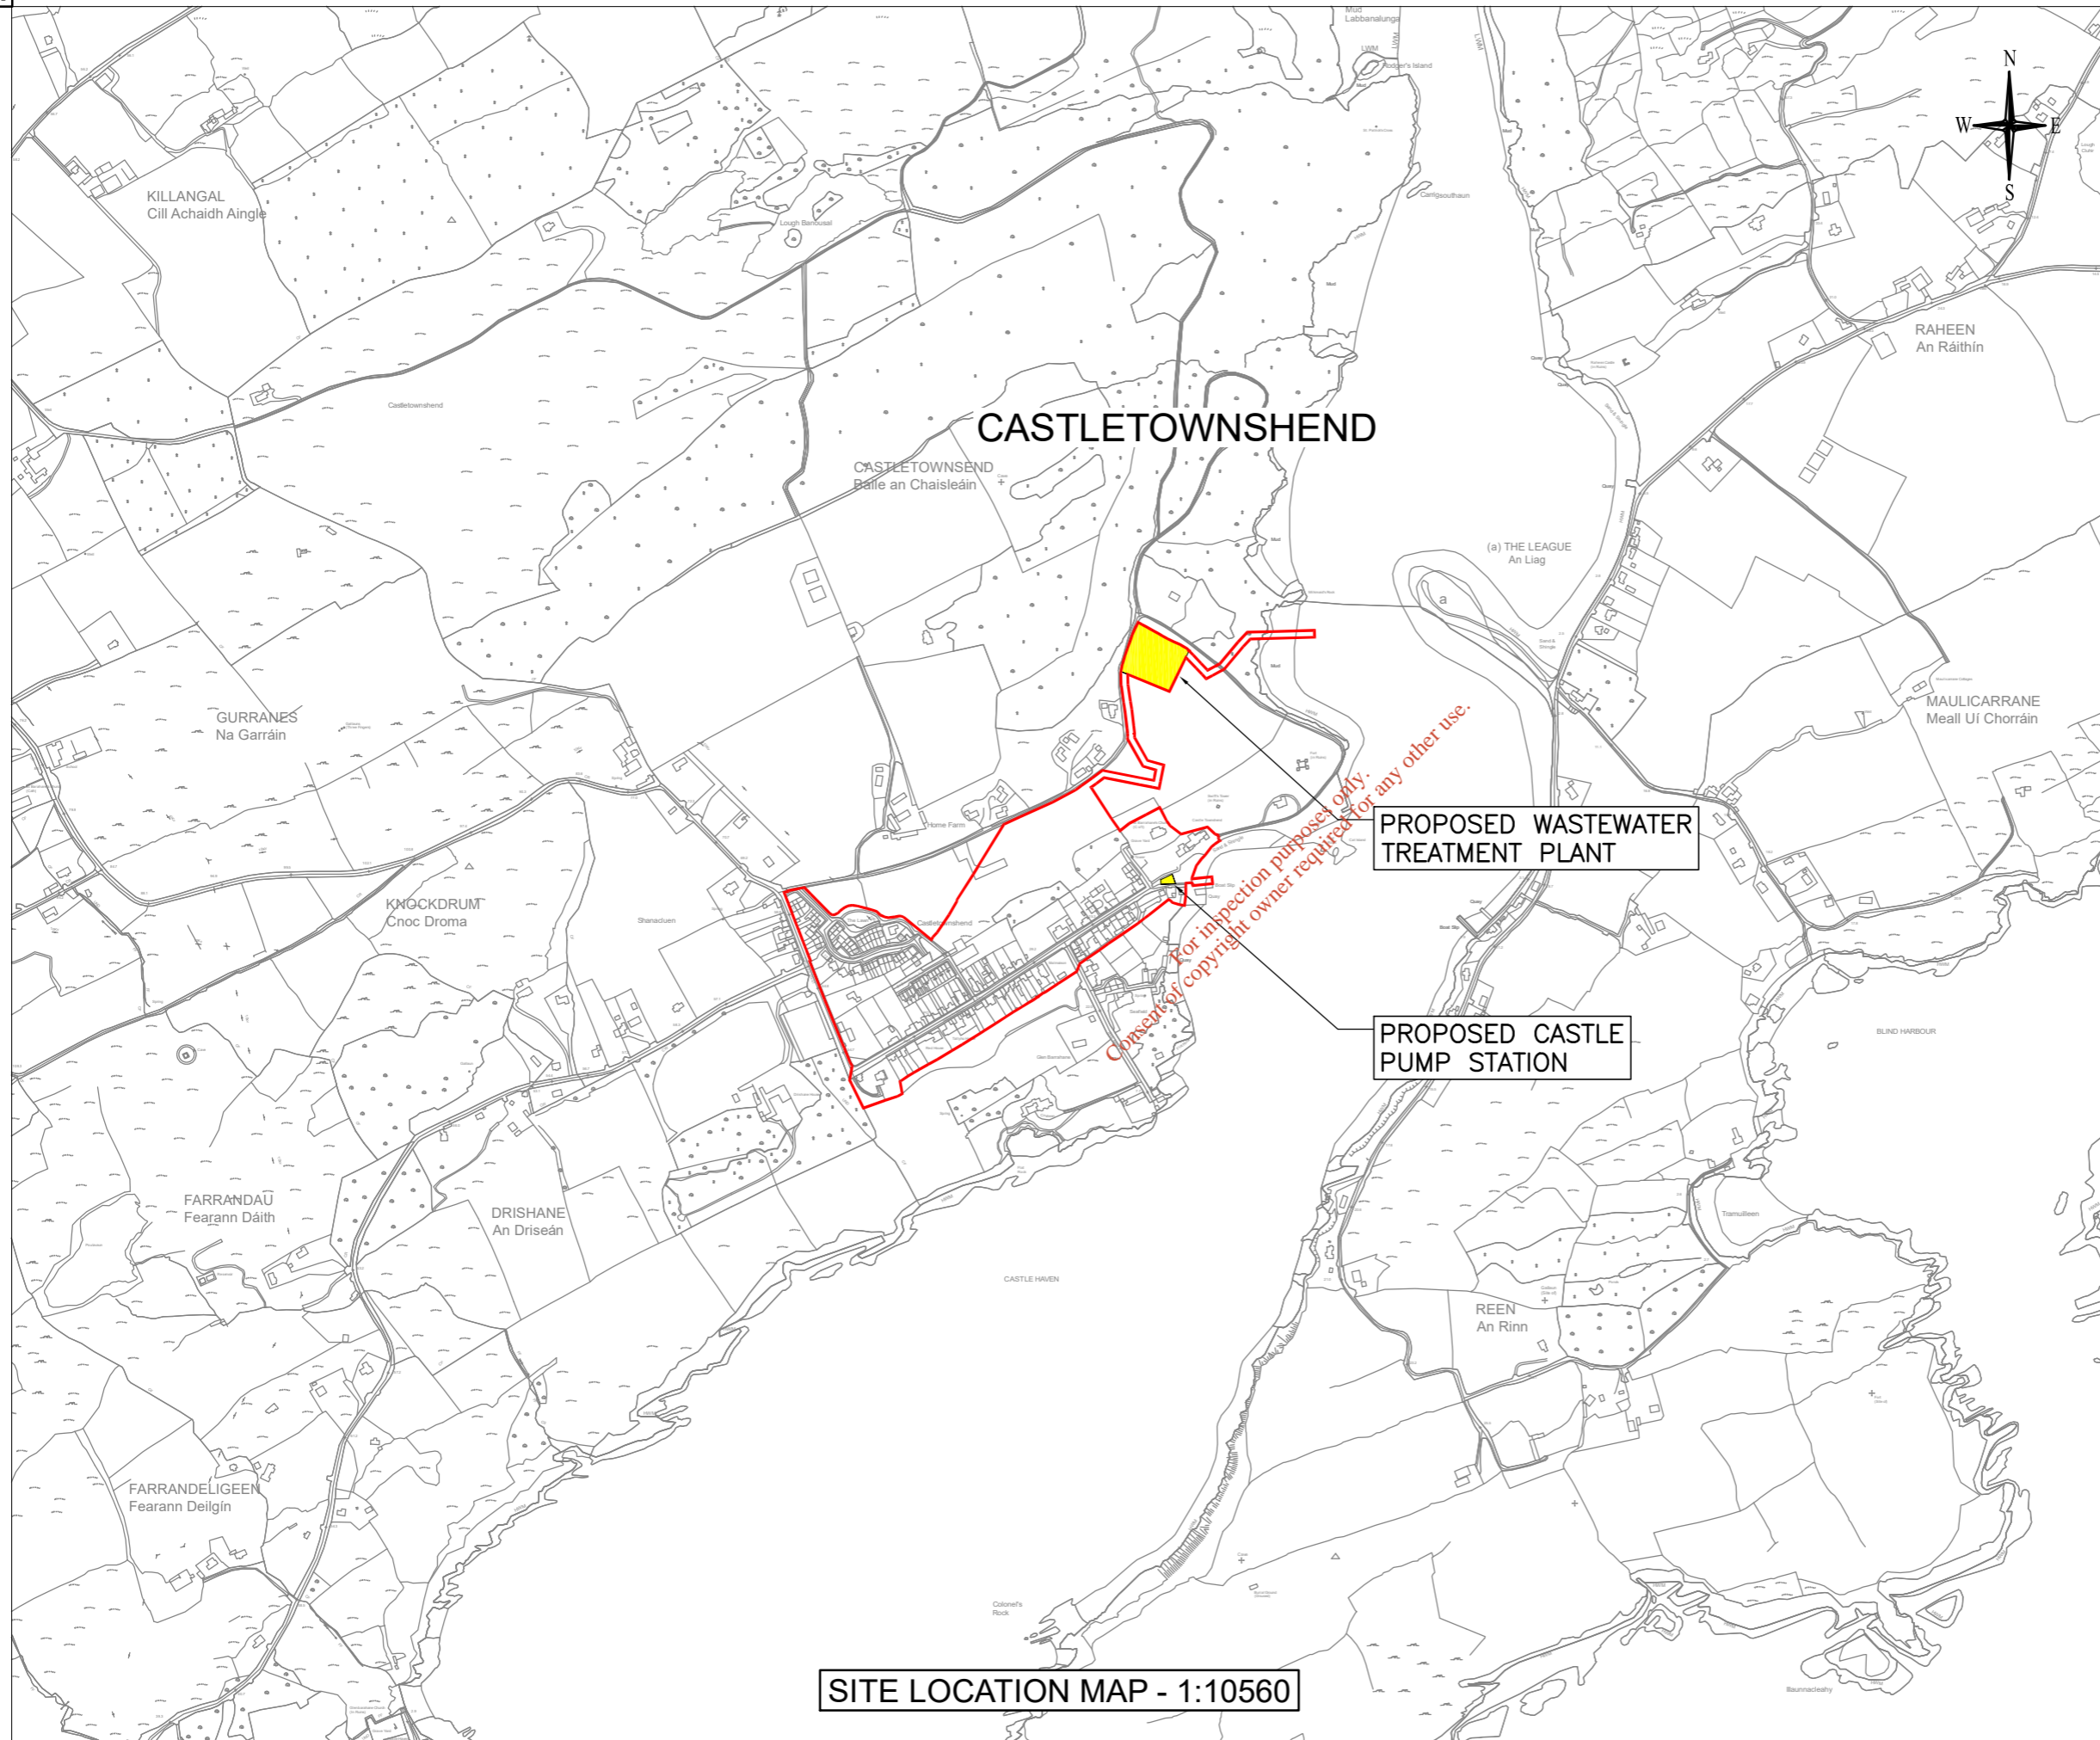

SITE LOCATION MAP - 1:10560

GENERAL NOTES

NOTES:

1. ORDNANCE SURVEY IRELAND LICENCE NUMBER EN 3-3-34.
2. THIS DRAWING TO BE READ IN CONJUNCTION WITH ALL OTHER RELEVANT DRAWINGS.

LEGEND:

- AGGLOMERATION BOUNDARY
- WASTEWATER TREATMENT PLANT & PUMP STATION LOCATIONS

Rev	Date	Description	By	Chk	App
02	07.10.21	ISSUED FOR LICENCE APPLICATION	LT	OL	KT
01	30.09.21	ISSUED FOR LICENCE APPLICATION	LT	OL	KT
00	29.07.21	ISSUED FOR LICENCE APPLICATION	LT	OL	KT

BYRNE LOOBY

2100 Cork Airport Business Park, Kinsale Road, Cork
 tel: +353 (0) 21 2407988
 email: cork@ByrneLooby.com www.ByrneLooby.com

BAHRAIN • IRELAND • QATAR • SAUDI ARABIA • UAE • UK
 CIVIL STRUCTURAL WATER & GEOTECHNICAL SPECIALISTS

ARUP

Arup,
 One Albert Quay
 Cork
 Tel +353(0)21 422 3200
 www.arup.com

CLIENT

Obair i gcompháirtíocht
 Working in Partnership



PROJECT

UTAS – CORK BUNDLE
 CASTLETOWNSHEND SEWERAGE SCHEME

DRAWING TITLE

DISCHARGE LICENCE APPLICATION
 ATTACHMENT B.1
 AGGLOMERATION PLAN

STATUS

FOR LICENCE APPLICATION

Date: 15.06.21	Scale: 1:10,560	Drawn: LT	Chk: OL	App: KT
Project No: 257589_00	Drg. No: IW-10015228-03-02-001	Rev:		02




ATTACHMENT NO: B.2

DRAWING NO. 02:

WWTP SITE PLAN LAYOUT & SITE BOUNDARY

IW-10015228-03-02-002

*For inspection purposes only.
Consent of copyright owner required for any other use.*

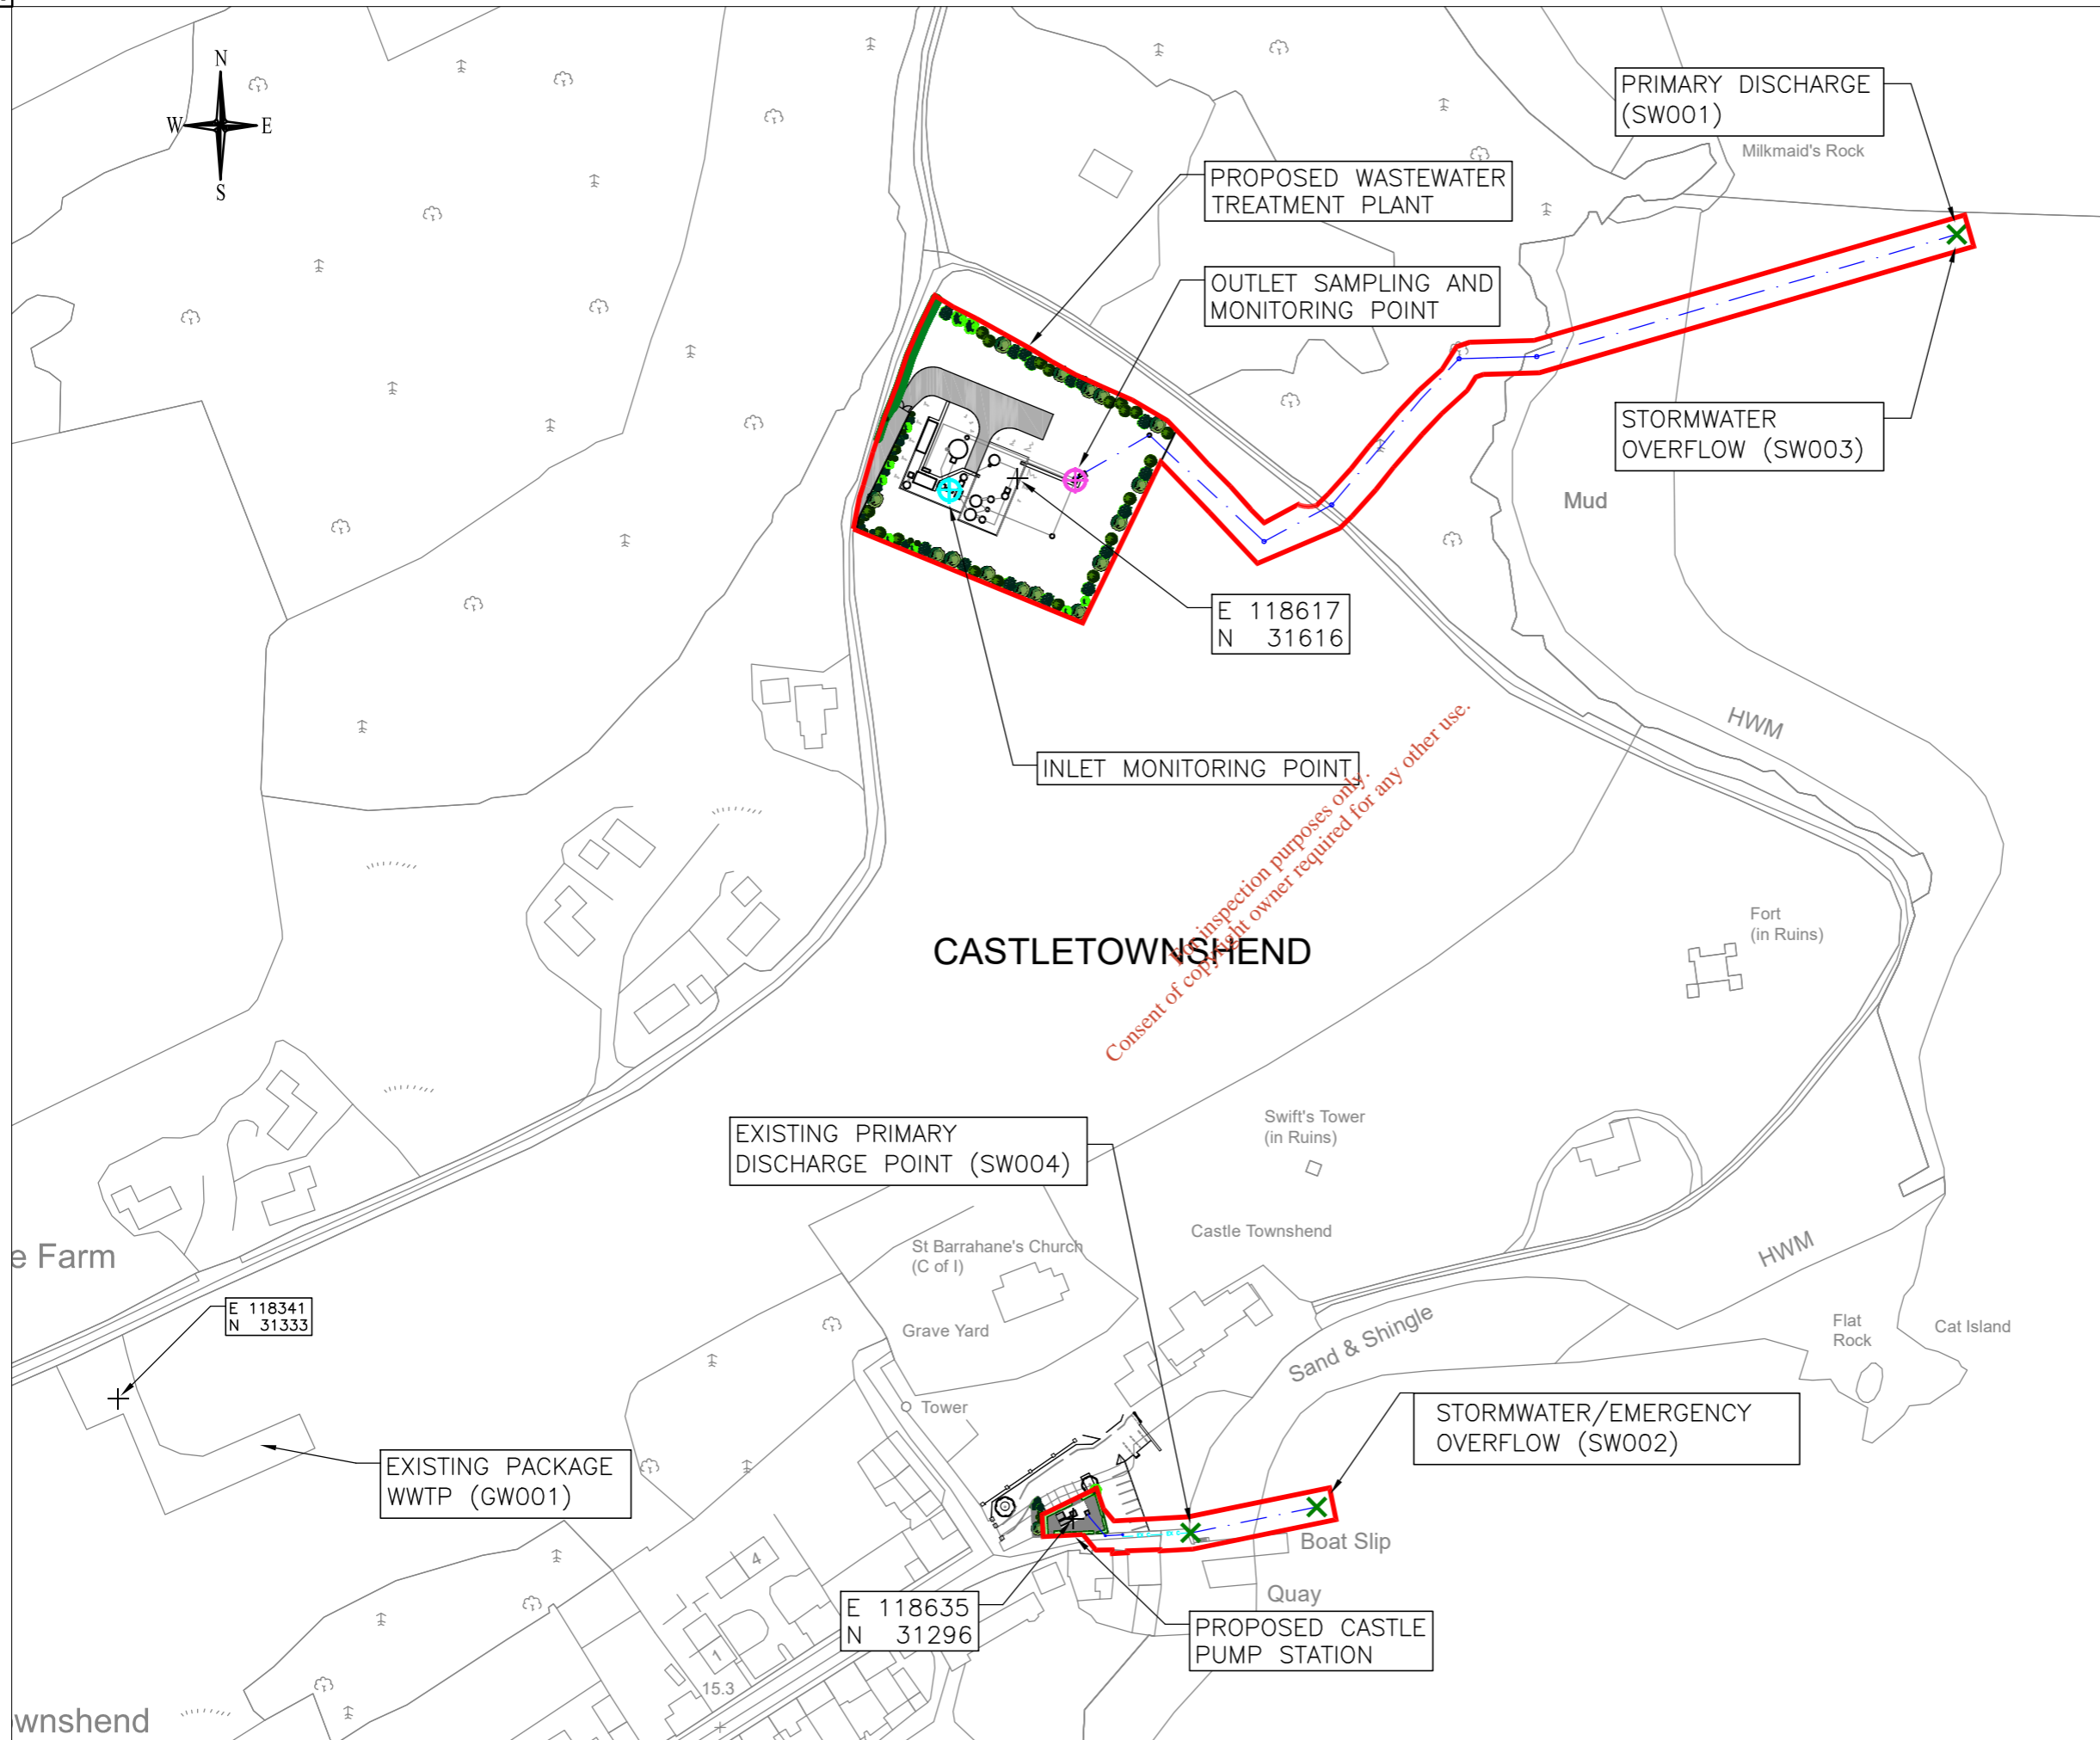

Consent of copyright owner required for any other use.

GENERAL NOTES

NOTES:

1. ORDNANCE SURVEY IRELAND LICENCE NUMBER EN 3-3-34.
2. THIS DRAWING TO BE READ IN CONJUNCTION WITH ALL OTHER RELEVANT DRAWINGS.

LEGEND:

- SITE BOUNDARY —
- PRIMARY DISCHARGE POINT AND SWO X
- PRIMARY DISCHARGE INLET SAMPLING, AND MONITORING POINT ⊕
- PRIMARY DISCHARGE OUTLET MONITORING POINT ⊕

Rev	Date	Description	By	Chk	App
00	29.07.21	ISSUED FOR LICENCE APPLICATION	LT	OL	KT

BYRNE LOOBY

2100 Cork Airport Business Park, Kinsale Road, Cork
 tel: +353 (0) 21 2407988
 email: cork@ByrneLooby.com www.ByrneLooby.com

BAHRAIN • IRELAND • QATAR • SAUDI ARABIA • UAE • UK
 CIVIL STRUCTURAL WATER & GEOTECHNICAL SPECIALISTS

ARUP

Arup,
 One Albert Quay
 Cork
 Tel +353(0)21 422 3200
 www.arup.com

CLIENT

Obair i gcomhpháirtíocht
 Working in Partnership

PROJECT
**UTAS – CORK BUNDLE
 CASTLETOWNSHEND SEWERAGE SCHEME**

DRAWING TITLE
**DISCHARGE LICENCE APPLICATION
 ATTACHMENT B.2
 WWTP & PS SITE BOUNDARY**

STATUS
FOR LICENCE APPLICATION

Date: 15.06.21	Scale: 1:2000	Drawn: LT	Chk: OL	App: KT
Project No: 257589_00	Drg. No: IW-10015228-03-02-002	Rev:		00



ATTACHMENT NO: B.2


DRAWING NO. 03:

WWTP LAYOUT PLAN & SECTIONS


IW-10015228-03-02-003A

*For inspection purposes only.
Consent of copyright owner required for any other use.*


A3

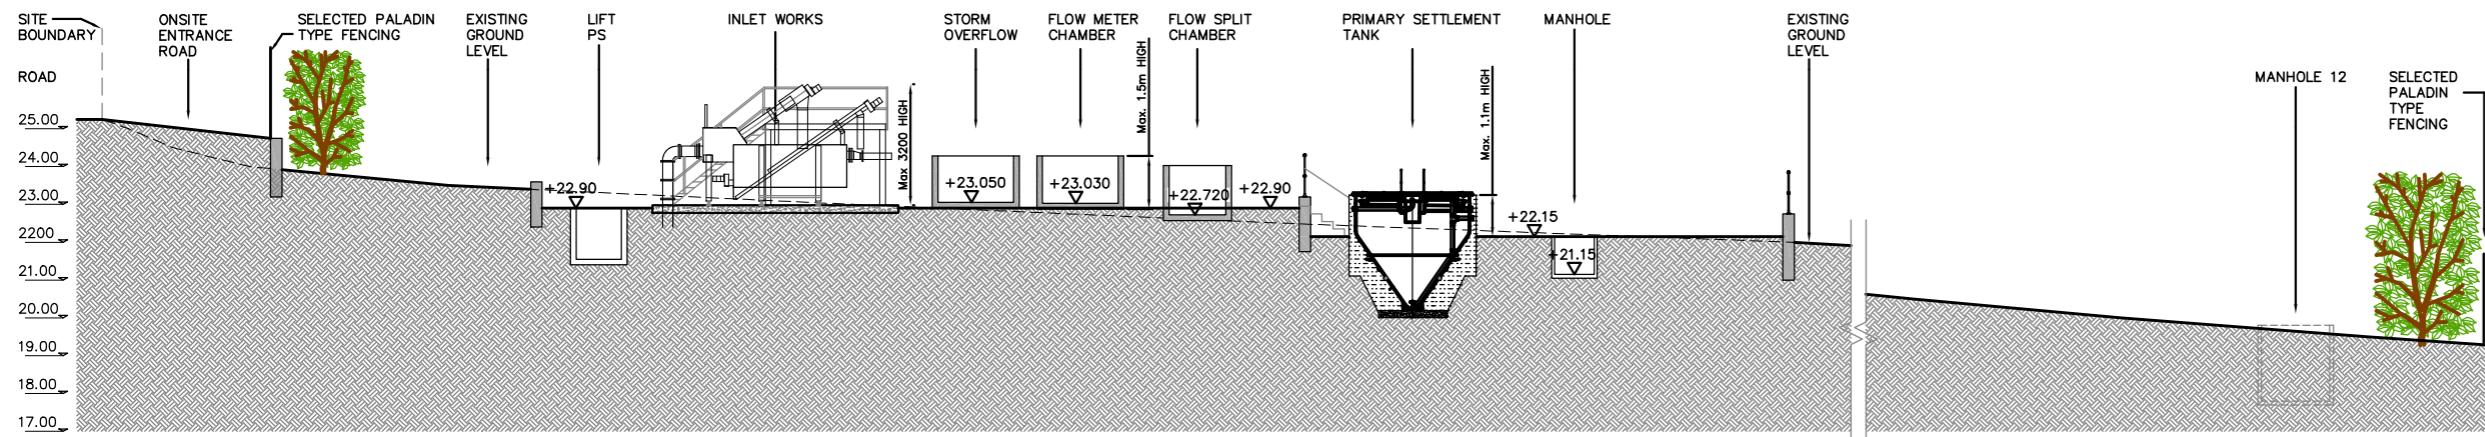

SECTION A-A
SCALE 1:100

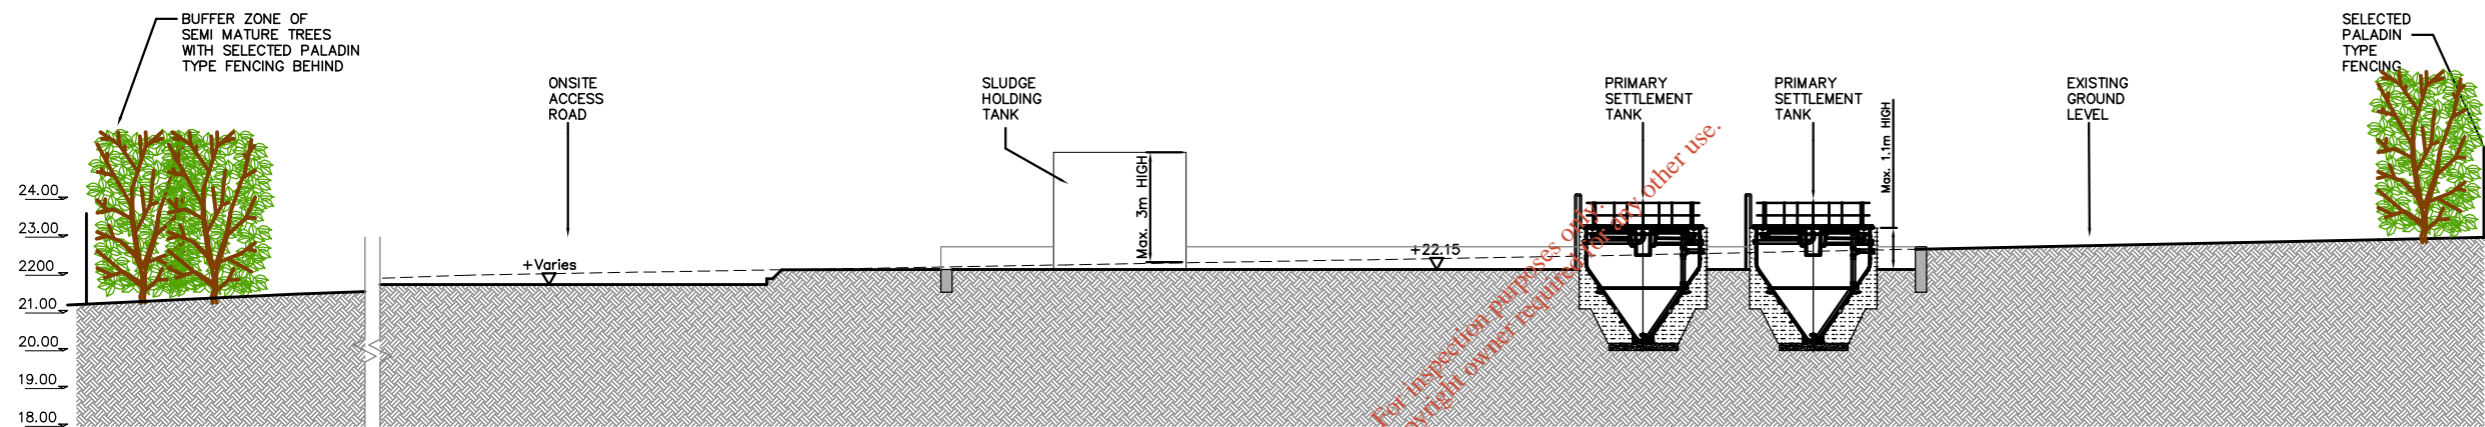

SECTION B-B
SCALE 1:100

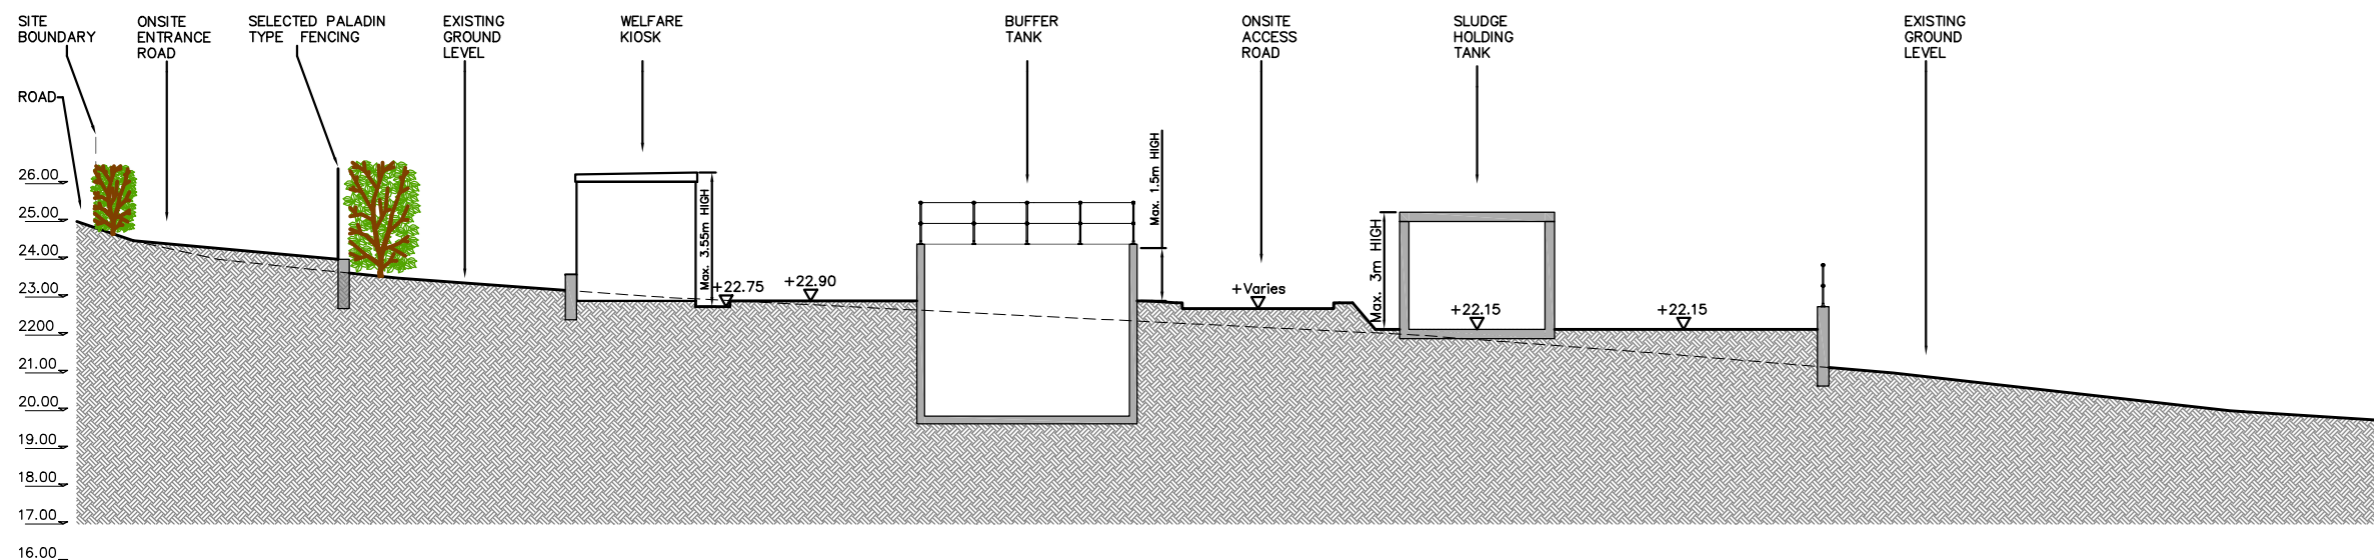

SECTION C-C
SCALE 1:100

GENERAL NOTES

LEGEND

- PROPOSED GROUND LEVEL
- EXISTING GROUND LEVEL
- INDICATIVE LEVELS +xx.xxx
▽

Rev	Date	Description	By	Chk	App
00	02.07.21	ISSUED FOR LICENCE APPLICATION	LT	OL	KT

BYRNE LOOBY

2100 Cork Airport Business Park, Kinsale Road, Cork
tel: +353 (0) 21 2407988
email: cork@ByrneLooby.com www.ByrneLooby.com

BAHRAIN • IRELAND • QATAR • SAUDI ARABIA • UAE • UK
CIVIL STRUCTURAL WATER & GEOTECHNICAL SPECIALISTS

ARUP

Arup,
One Albert Quay
Cork
Tel +353(0)21 422 3200
www.arup.com

CLIENT

Obair i gcomhpháirtíocht
Working in Partnership



PROJECT

UTAS – CORK BUNDLE
CASTLETOWNSHEND SEWERAGE SCHEME

DRAWING TITLE

DISCHARGE LICENCE APPLICATION
ATTACHMENT B.2
PROPOSED WWTP SECTIONS

STATUS

FOR LICENCE APPLICATION


Date: 30.06.21	Scale: 1:200	Drawn: LT	Chk: OL	App: KT
Project No: 257589_00	Drg. No: IW-10015228-03-02-003A	Rev:		00



ATTACHMENT NO: B.3

**DRAWING NO. 04:
PRIMARY DISCHARGE POINT
IW-10015228-03-02-004**

*For inspection purposes only.
Consent of copyright owner required for any other use.*

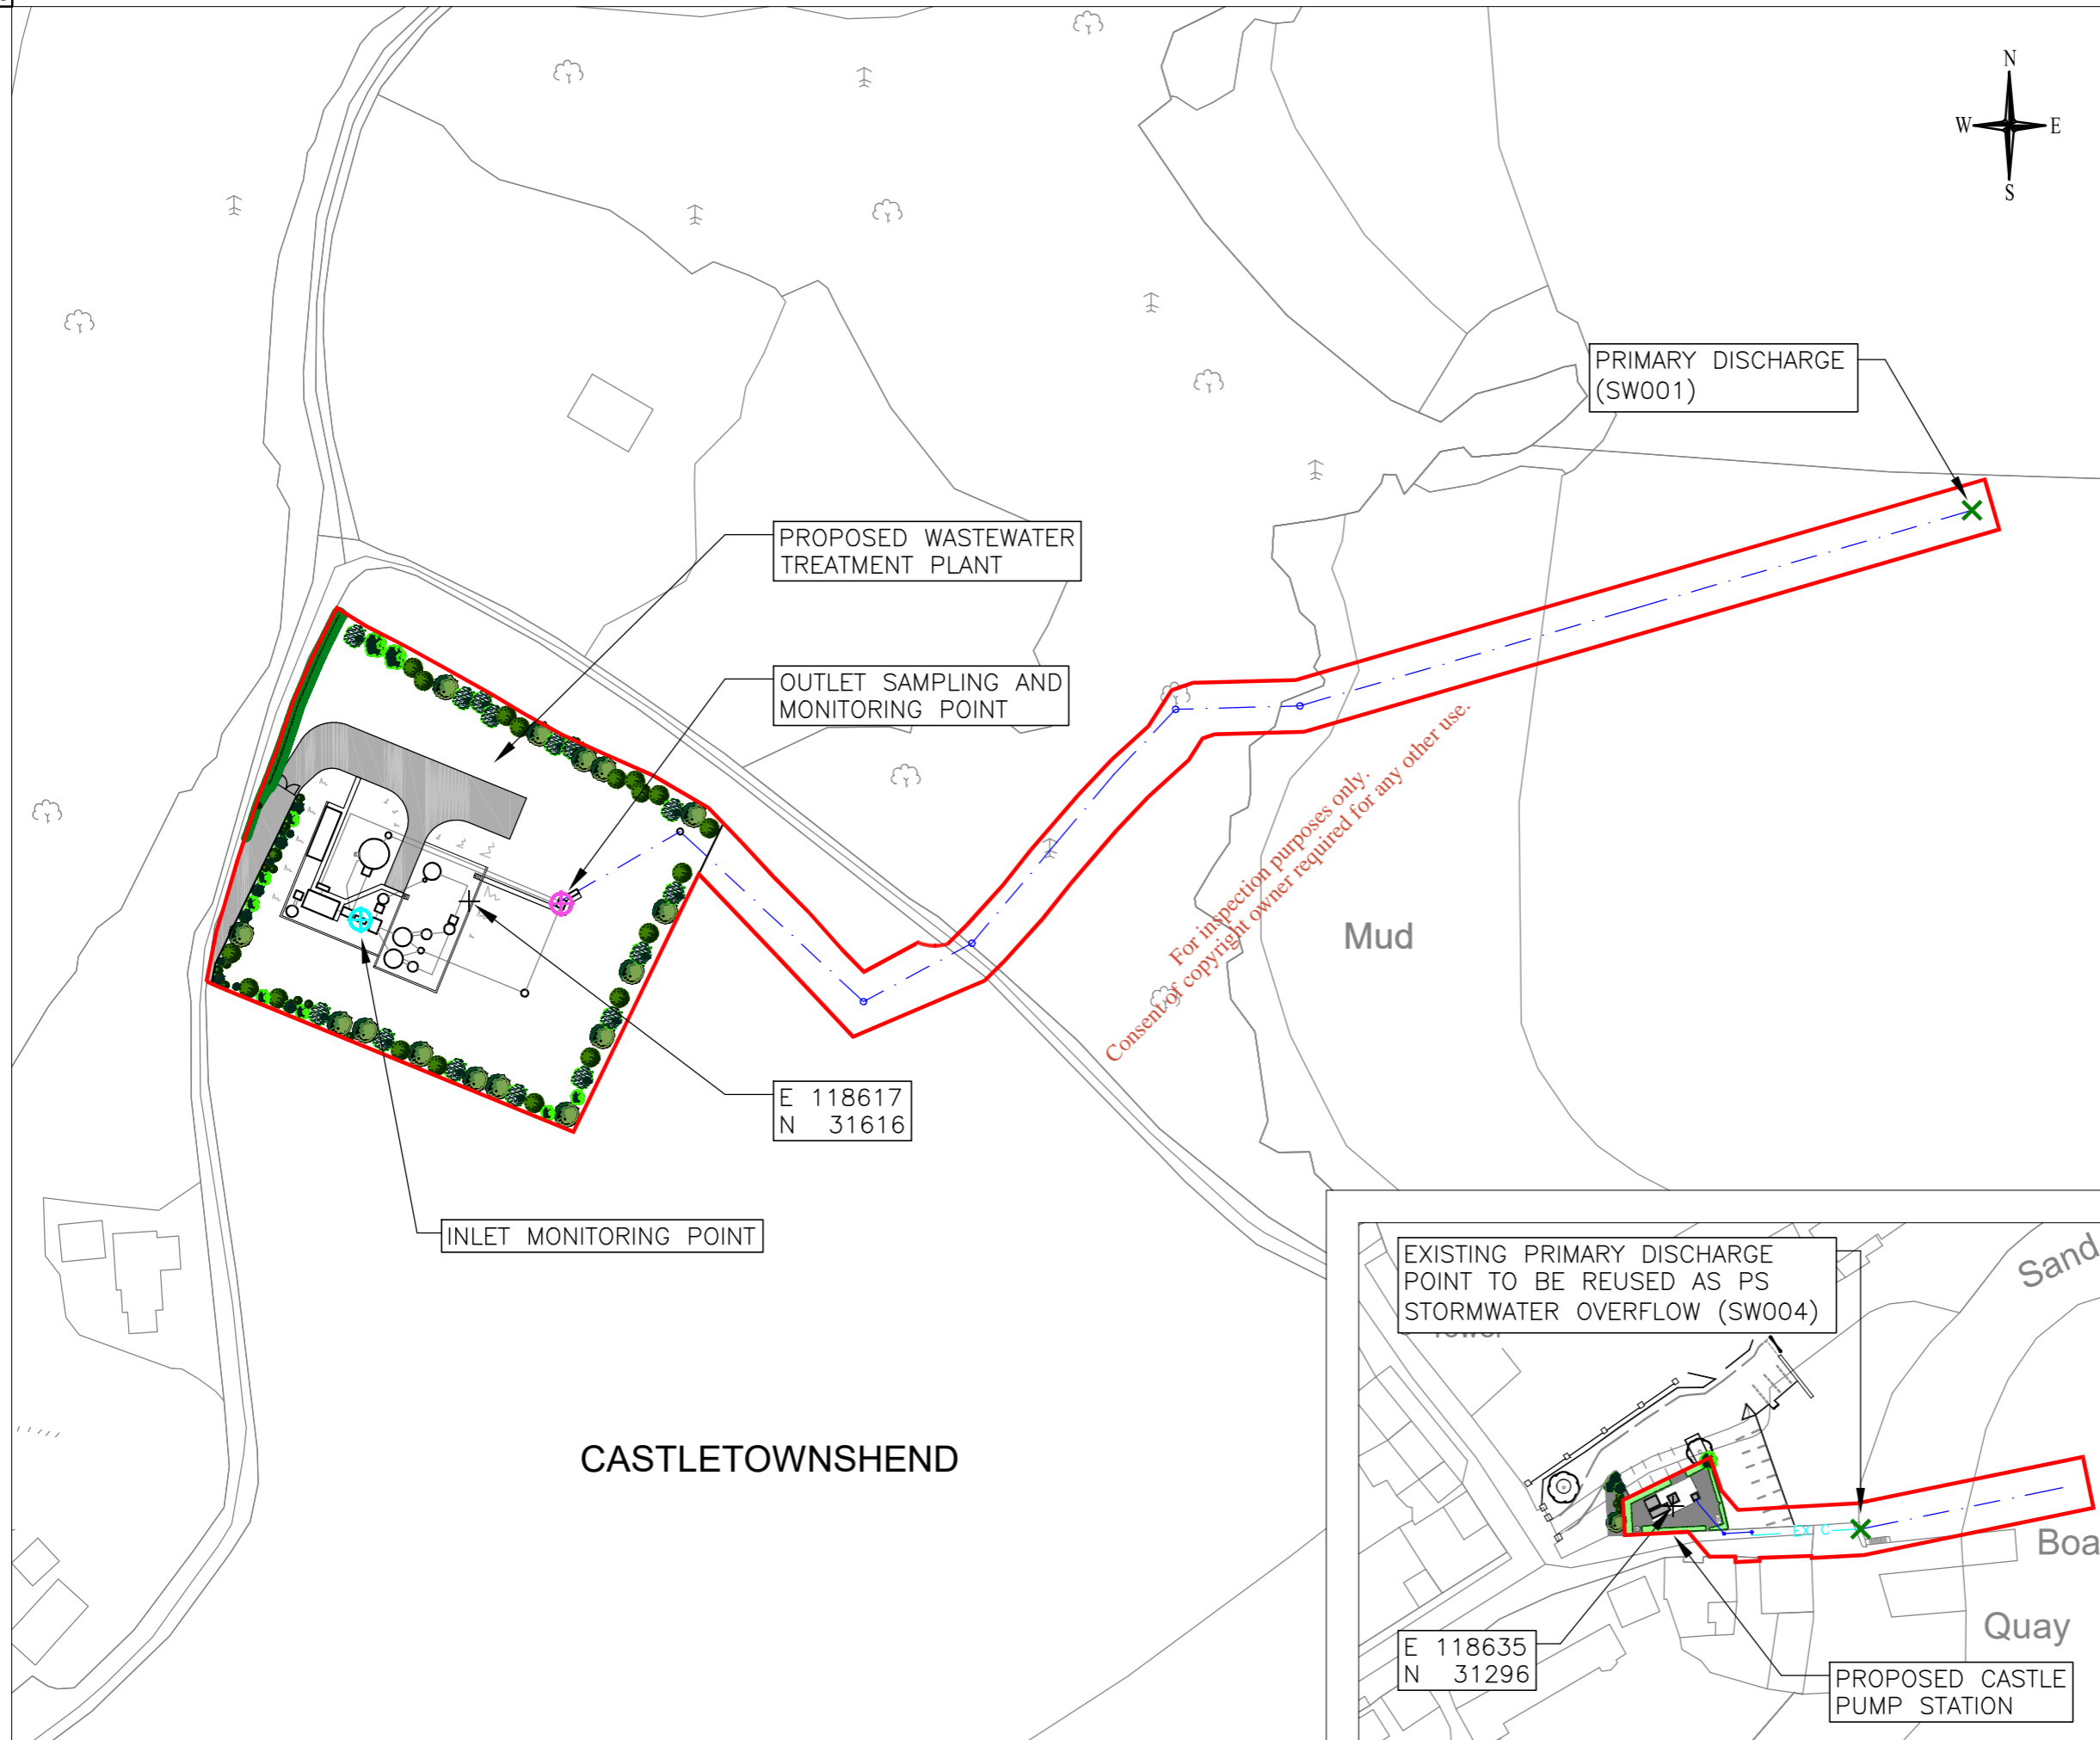

GENERAL NOTES

NOTES:

1. ORDNANCE SURVEY IRELAND LICENCE NUMBER EN 3-3-34.
2. THIS DRAWING TO BE READ IN CONJUNCTION WITH ALL OTHER RELEVANT DRAWINGS.

LEGEND:

- SITE BOUNDARY ———
- PRIMARY DISCHARGE POINT ✕
- PRIMARY DISCHARGE INLET SAMPLING, AND MONITORING POINT ⊕
- PRIMARY DISCHARGE OUTLET MONITORING POINT ⊕

Rev	Date	Description	By	Chk	App
00	02.07.21	ISSUED FOR LICENCE APPLICATION	LT	OL	KT

BYRNE LOOBY

2100 Cork Airport Business Park, Kinsale Road, Cork
 tel: +353 (0) 21 2407988
 email: cork@ByrneLooby.com www.ByrneLooby.com

BAHRAIN • IRELAND • QATAR • SAUDI ARABIA • UAE • UK
 CIVIL STRUCTURAL WATER & GEOTECHNICAL SPECIALISTS

ARUP

Arup,
 One Albert Quay
 Cork
 Tel +353(0)21 422 3200
 www.arup.com

CLIENT

Obair i gcomhpháirtíocht
 Working in Partnership



PROJECT

UTAS – CORK BUNDLE
 CASTLETOWNSHEND SEWERAGE SCHEME

DRAWING TITLE

DISCHARGE LICENCE APPLICATION
 ATTACHMENT B.3
 PRIMARY DISCHARGE POINT

STATUS

FOR LICENCE APPLICATION

Date: 30.06.21	Scale: 1:1250	Drawn: LT	Chk: OL	App: KT
Project No: 257589_00	Drg. No: IW-10015228-03-02-004	Rev: 00		




ATTACHMENT NO: B.3

DRAWING NO. 05:

SECONDARY DISCHARGE POINT (TO BE
DECOMMISSIONED)

IW-10015228-03-02-004A

*For inspection purposes only.
Consent of copyright owner required for any other use*

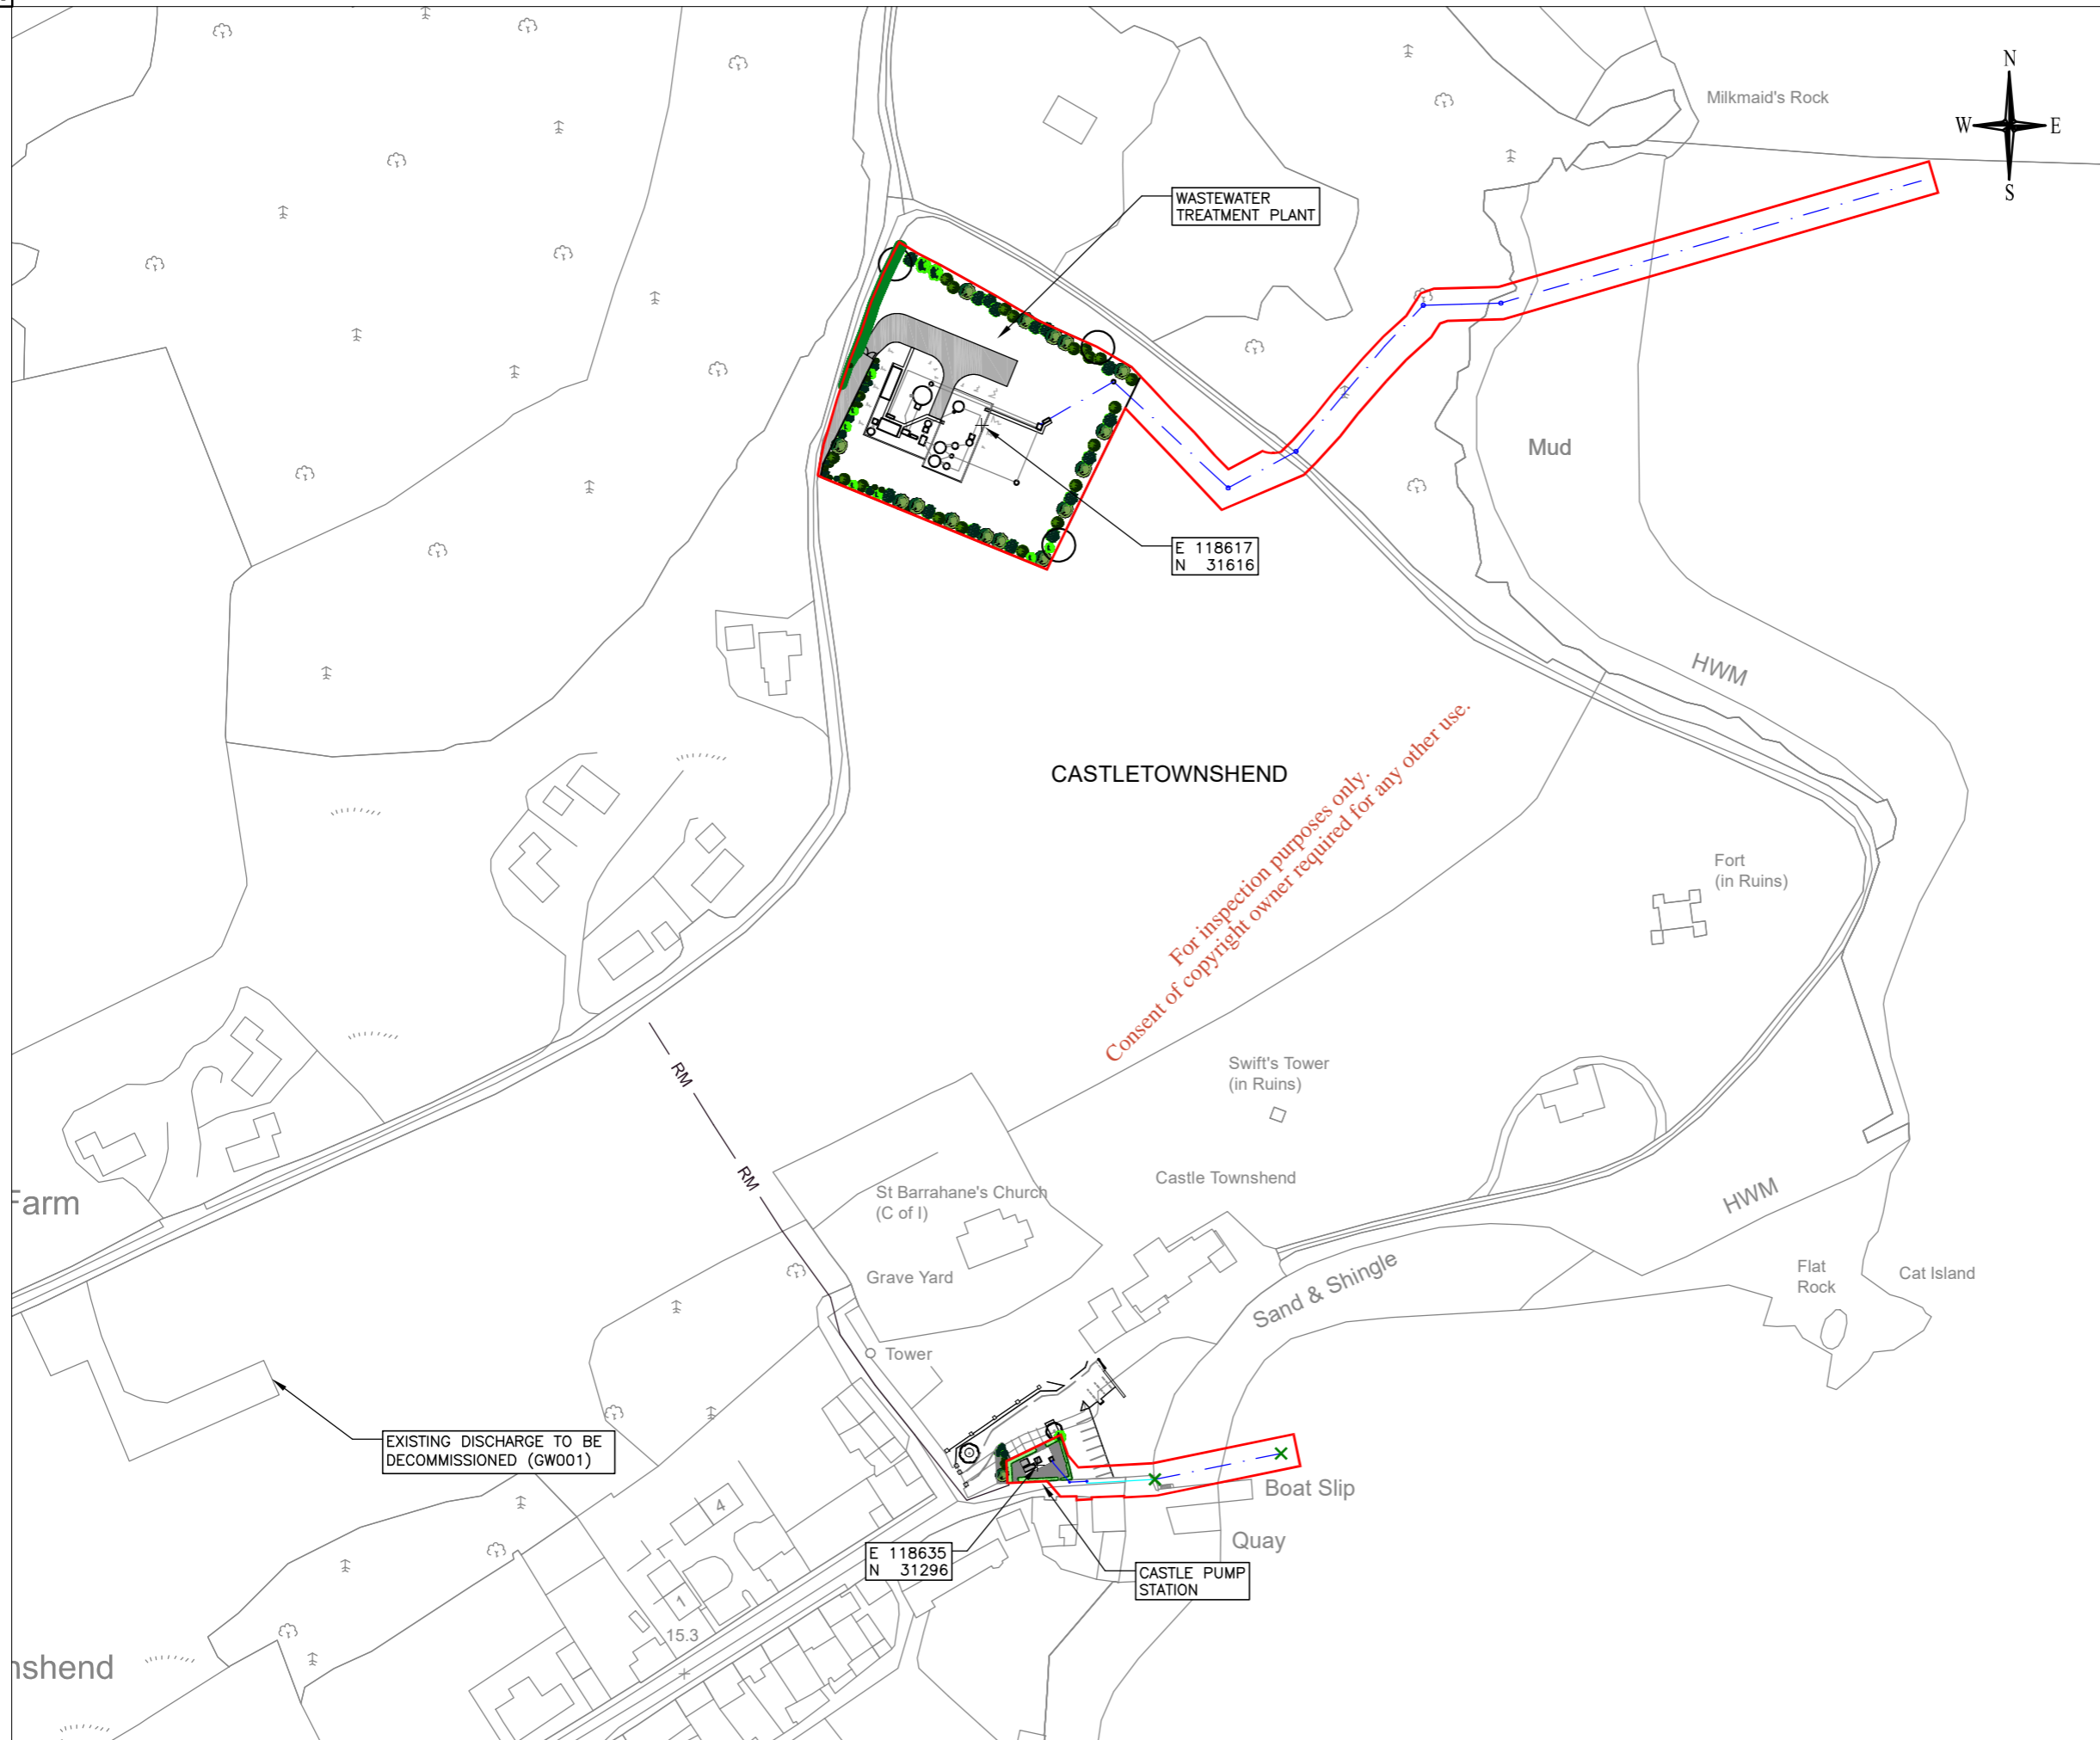

GENERAL NOTES

NOTES:

1. ORDNANCE SURVEY IRELAND LICENCE NUMBER EN 3-3-34.
2. THIS DRAWING TO BE READ IN CONJUNCTION WITH ALL OTHER RELEVANT DRAWINGS.

LEGEND:

- SITE BOUNDARY ———
- EXISTING SECONDARY DISCHARGE POINT TO BE DECOMMISSIONED X

Rev	Date	Description	By	Chk	App
00	02.07.21	ISSUED FOR LICENCE APPLICATION	LT	OL	KT

BYRNE LOOBY

2100 Cork Airport Business Park, Kinsale Road, Cork
 tel: +353 (0) 21 2407988
 email: cork@ByrneLooby.com www.ByrneLooby.com

BAHRAIN • IRELAND • QATAR • SAUDI ARABIA • UAE • UK
 CIVIL STRUCTURAL WATER & GEOTECHNICAL SPECIALISTS

ARUP

Arup,
 One Albert Quay
 Cork
 Tel +353(0)21 422 3200
 www.arup.com

CLIENT

Obair i gcomhpháirtíocht
 Working in Partnership



PROJECT

UTAS – CORK BUNDLE
 CASTLETOWNSHEND SEWERAGE SCHEME

DRAWING TITLE

DISCHARGE LICENCE APPLICATION
 ATTACHMENT B.3
 SECONDARY DISCHARGE POINTS

STATUS

FOR LICENCE APPLICATION


Date: 30.06.21	Scale: 1:2000	Drawn: LT	Chk: OL	App: KT
Project No: 257589_00	Drg. No: IW-10015228-03-02-004A	Rev: 00		



ATTACHMENT NO: B.5

**DRAWING NO. 06:
STORM WATER OVERFLOW
IW-10015228-03-02-005**

*For inspection purposes only.
Consent of copyright owner required for any other use.*

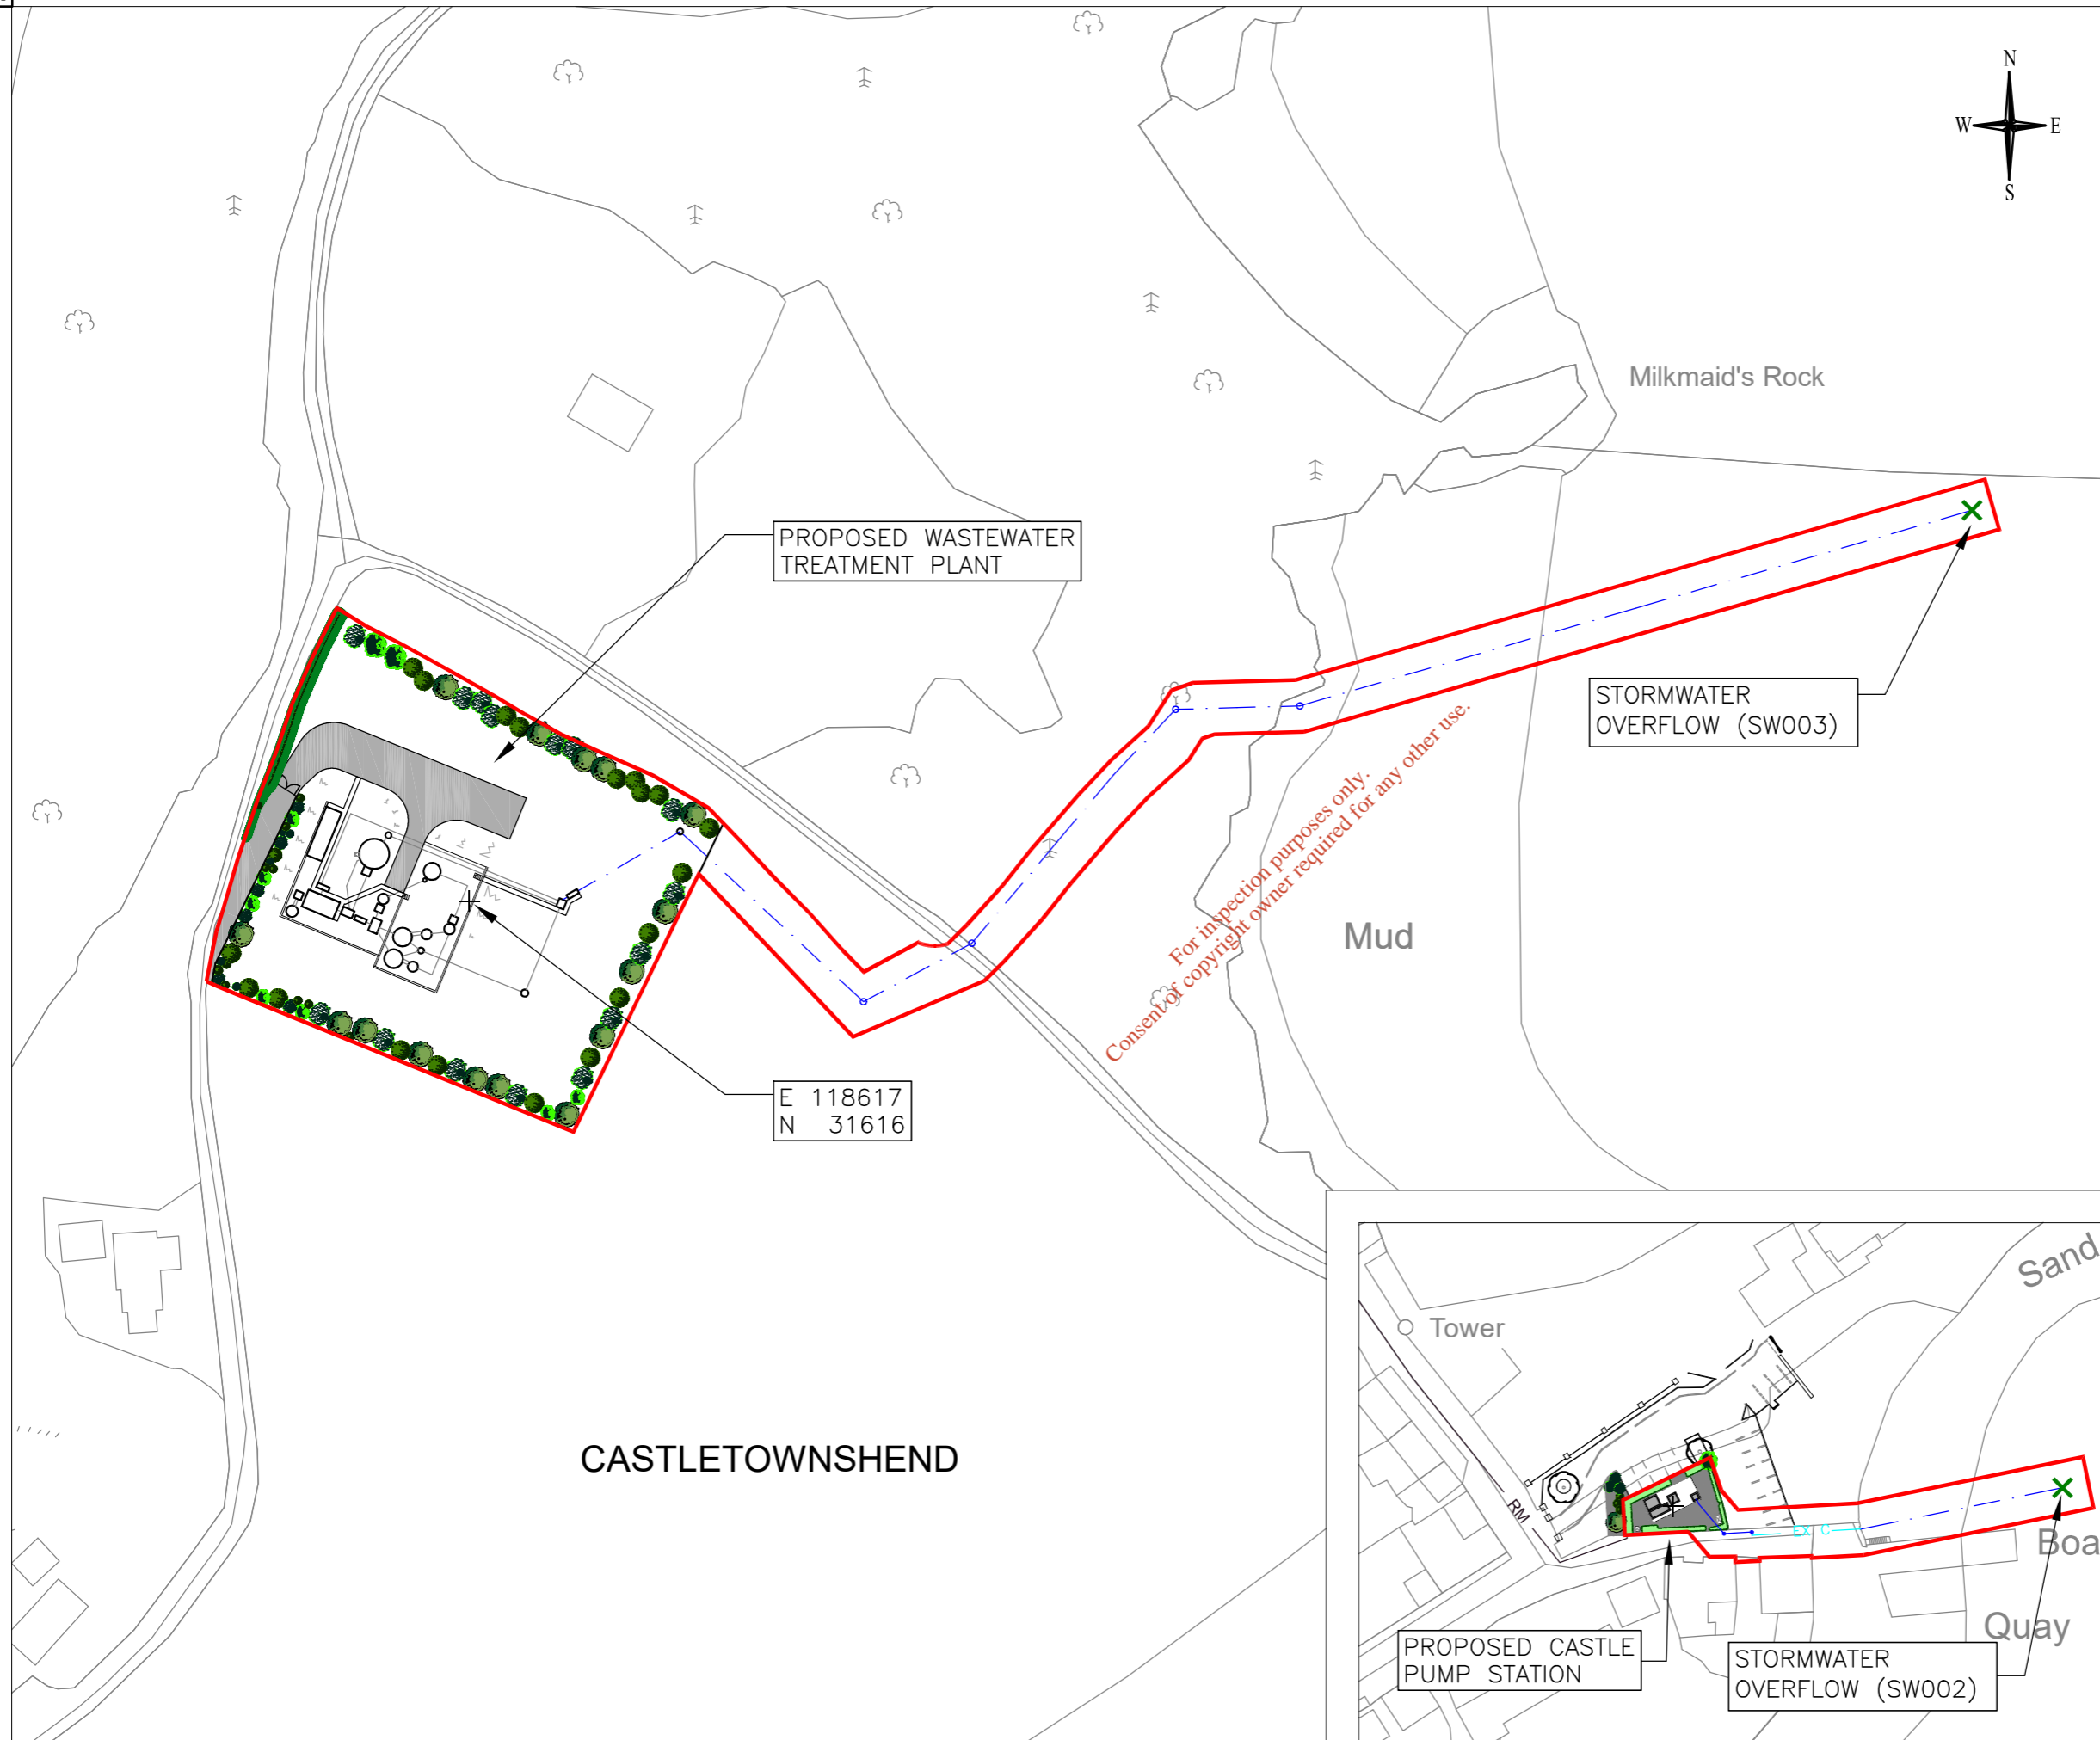

PROPOSED WASTEWATER TREATMENT PLANT


STORMWATER OVERFLOW (SW003)

E 118617
N 31616

Consent of copyright owner required for any other use.

Mud

CASTLETOWNSHEND

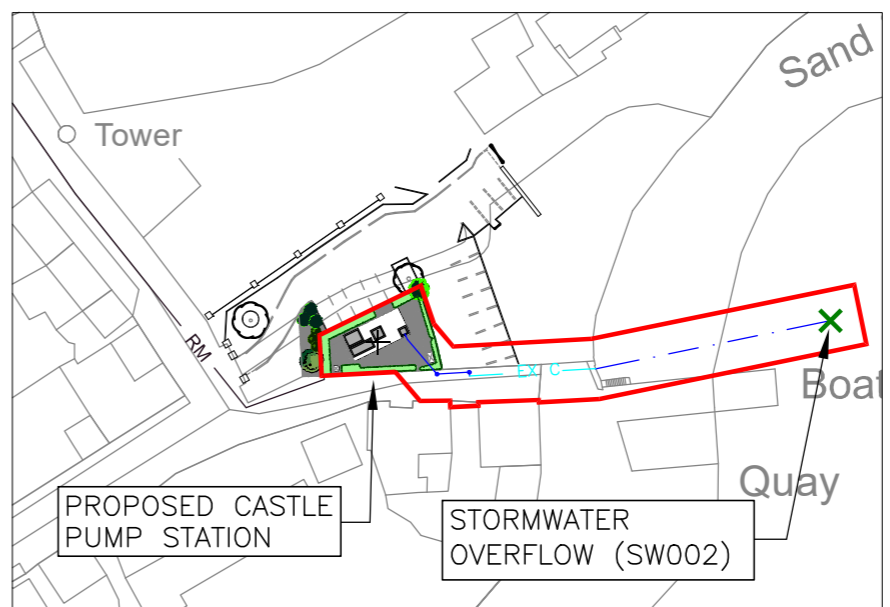

PROPOSED CASTLE PUMP STATION

STORMWATER OVERFLOW (SW002)

GENERAL NOTES

NOTES:

1. ORDNANCE SURVEY IRELAND LICENCE NUMBER EN 3-3-34.
2. THIS DRAWING TO BE READ IN CONJUNCTION WITH ALL OTHER RELEVANT DRAWINGS.

LEGEND:

- SITE BOUNDARY —
- PROPOSED STORMWATER OVERFLOW X

Rev	Date	Description	By	Chk	App
00	02.07.21	ISSUED FOR LICENCE APPLICATION	LT	OL	KT

BYRNE LOOBY

2100 Cork Airport Business Park, Kinsale Road, Cork
tel: +353 (0) 21 2407988
email: cork@ByrneLooby.com www.ByrneLooby.com

BAHRAIN • IRELAND • QATAR • SAUDI ARABIA • UAE • UK
CIVIL STRUCTURAL WATER & GEOTECHNICAL SPECIALISTS

ARUP

Arup,
One Albert Quay
Cork
Tel +353(0)21 422 3200
www.arup.com

CLIENT

Obair i gcompháirtíocht Working in Partnership

PROJECT
UTAS – CORK BUNDLE
CASTLETOWNSHEND SEWERAGE SCHEME

DRAWING TITLE
DISCHARGE LICENCE APPLICATION
ATTACHMENT B.5
STORMWATER OVERFLOW

STATUS
FOR LICENCE APPLICATION

Date: 30.06.21	Scale: 1:1250	Drawn: LT	Chk: OL	App: KT
Project No: 257589_00	Drg. No: IW-10015228-03-02-005	Rev: 00		