
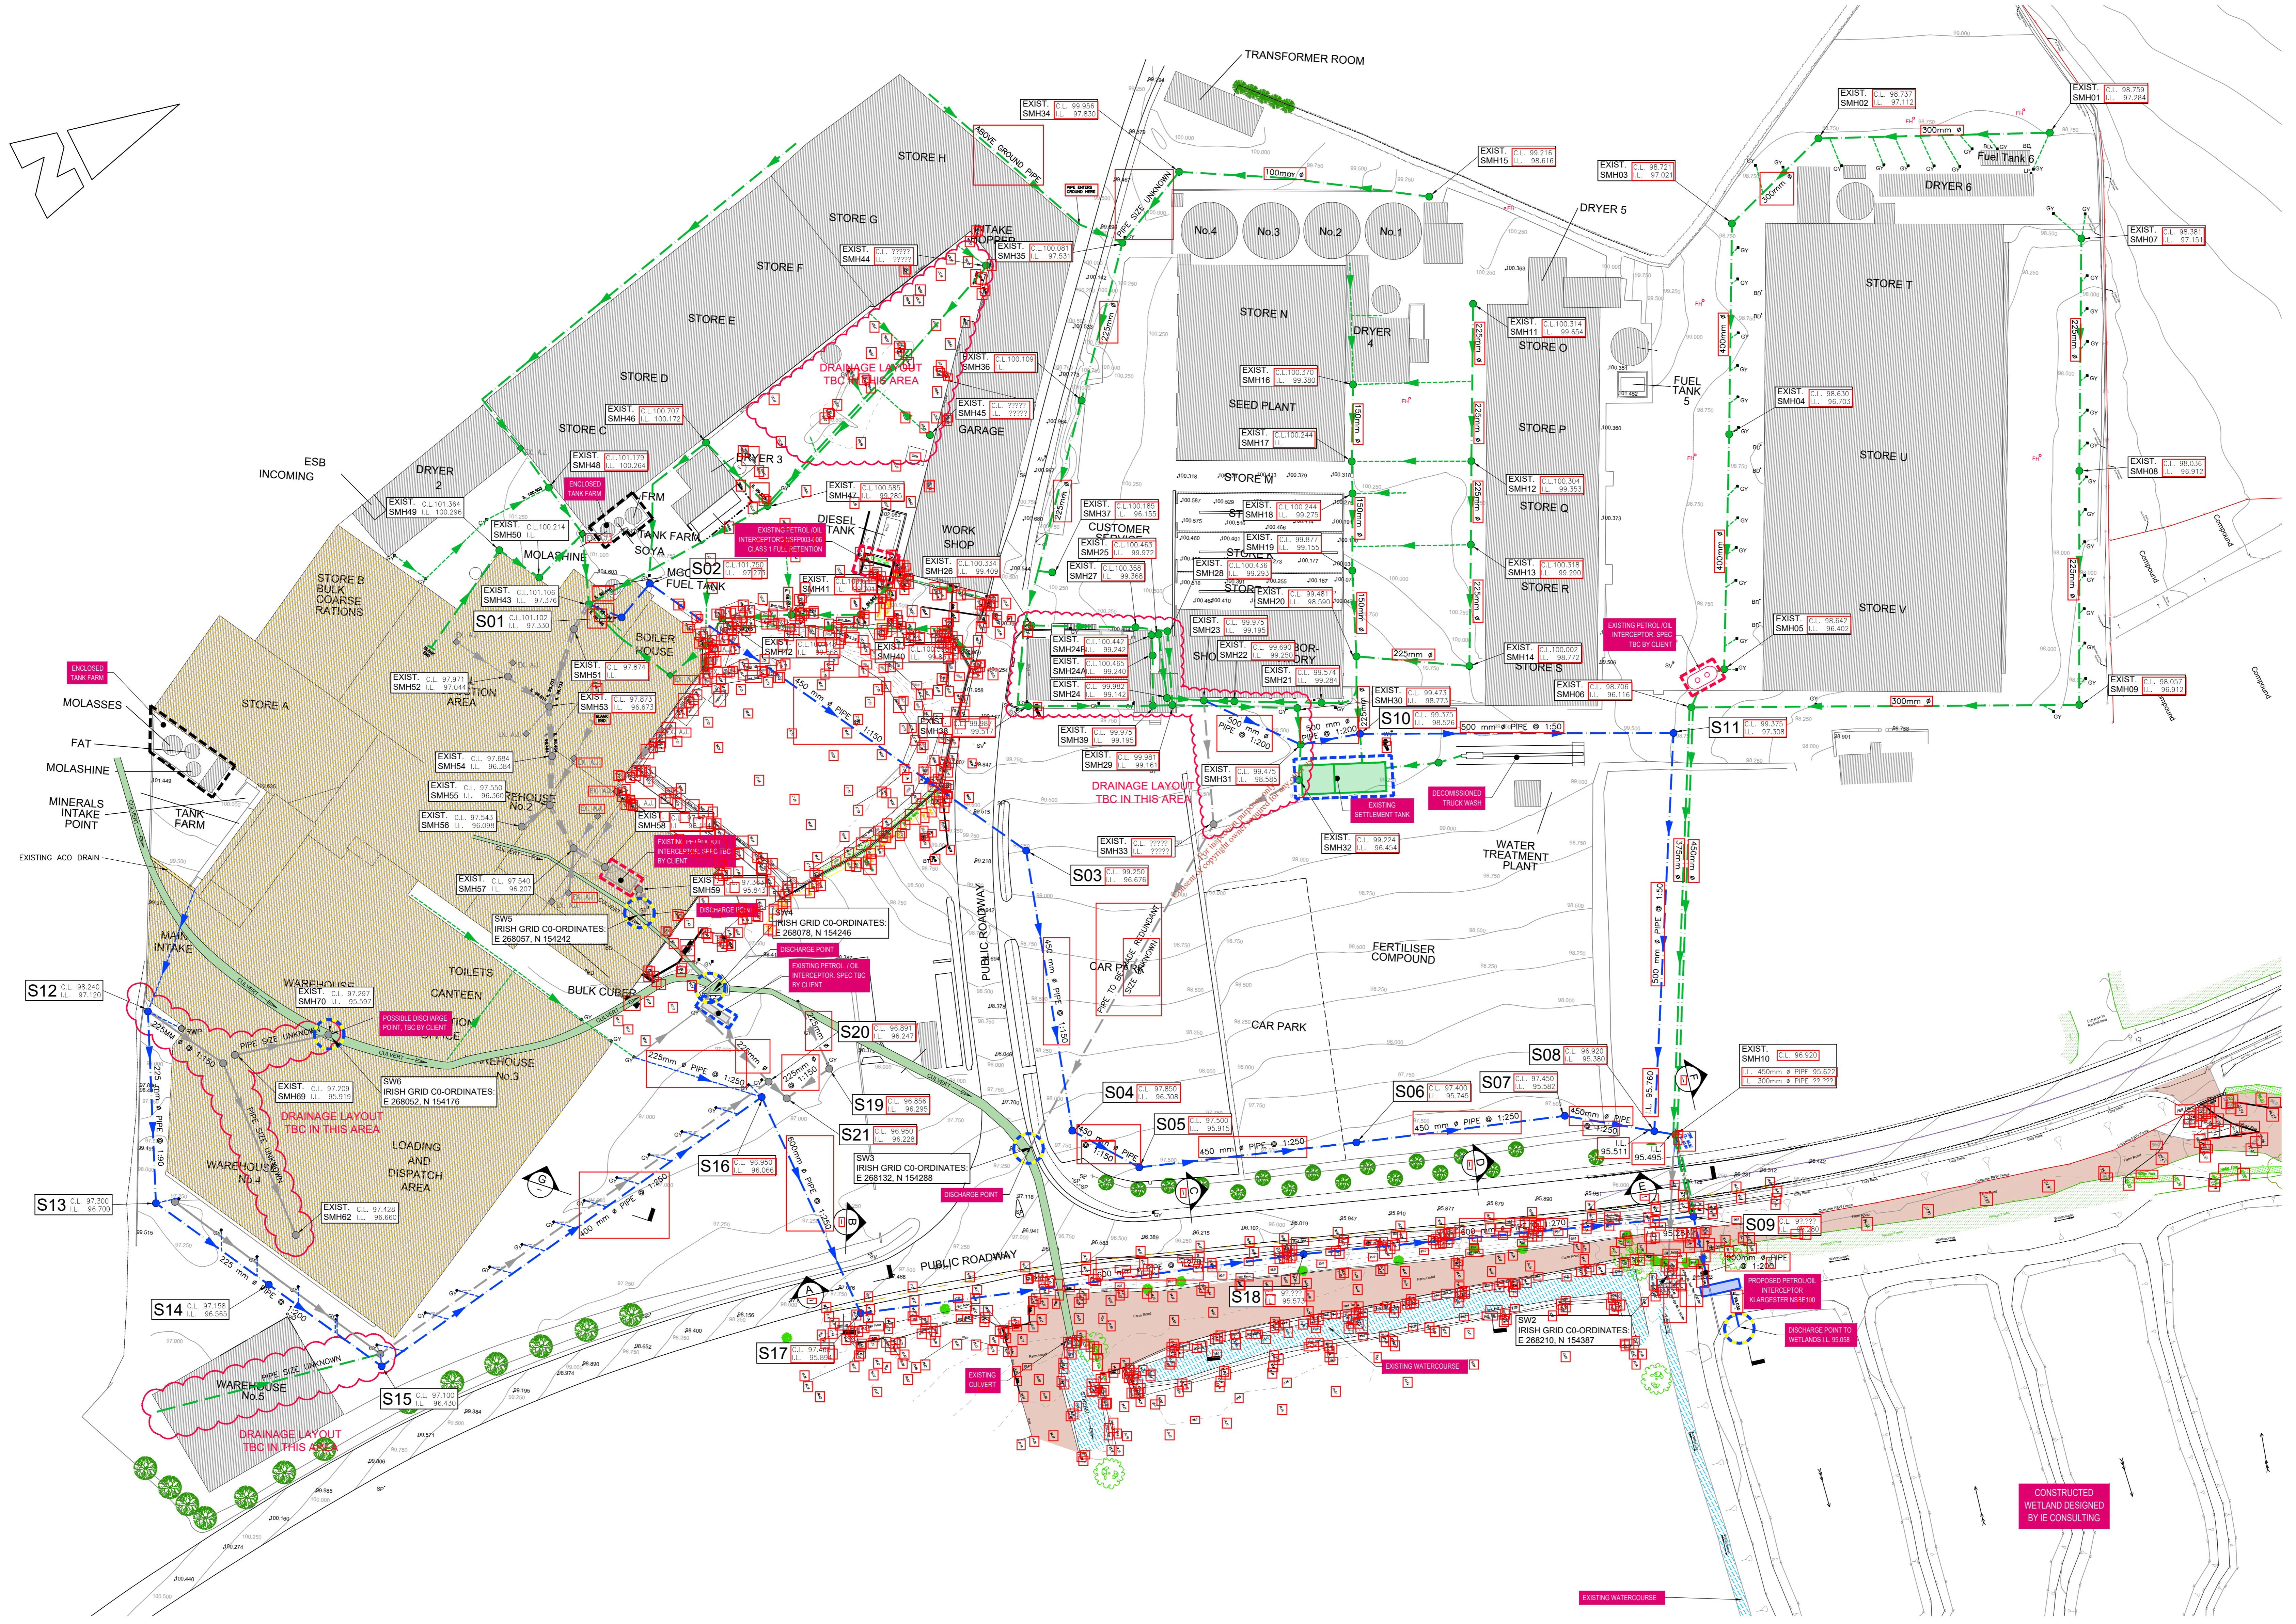


For inspection purposes only.  
Consent of copyright owner required for any other use.

# Drawing 2 - Proposed

DON'T SCALE DIMENSIONS

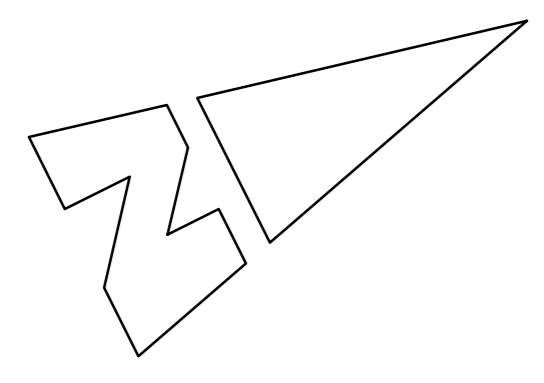

**Health and Safety:**

THIS DRAWING TO BE READ IN CONJUNCTION WITH ALL OTHER RELEVANT DRAWINGS, THE SPECIFICATION AND THE SAFETY AND HEALTH PLAN.



THE APPOINTMENT OF THE PROJECT SUPERVISOR DESIGN PROCESS IS THE CLIENT'S RESPONSIBILITY.

TEMPORARY WORKS PROPOSALS AND/OR METHOD STATEMENTS TO BE SUBMITTED TO THE PSOP AND THE PSOS FOR WORKS WHICH INVOLVE PARTICULAR RISKS.

- Notes:**
- NO PART OF THIS DRAWING MAY BE REPRODUCED OR TRANSMITTED IN ANY FORM OR STORED IN ANY RETRIEVAL SYSTEM OF ANY NATURE WITHOUT THE WRITTEN PERMISSION OF MALONE O'REGAN CONSULTING ENGINEERS AS COPYRIGHT HOLDER EXCEPT AS AGREED FOR USE ON THE PROJECT FOR WHICH THE DRAWING WAS ORIGINALLY ISSUED.
  - THE APPOINTMENT OF THE PROJECT SUPERVISOR DESIGN PROCESS IS THE CLIENT'S RESPONSIBILITY.
  - ALL DIMENSIONS IN mm UNLESS NOTED OTHERWISE.
  - THE CONTRACTOR SHALL CHECK ALL DIMENSIONS PRIOR TO COMMENCEMENT OF CONSTRUCTION; DISCREPANCIES SHALL BE REPORTED TO THIS OFFICE IN WRITING.
  - THIS DRAWING TO BE READ IN ACCORDANCE WITH ALL RELEVANT ENGINEERS' DRAWINGS AND SPECIFICATIONS.



**KEY PLAN**  
N.T.S.

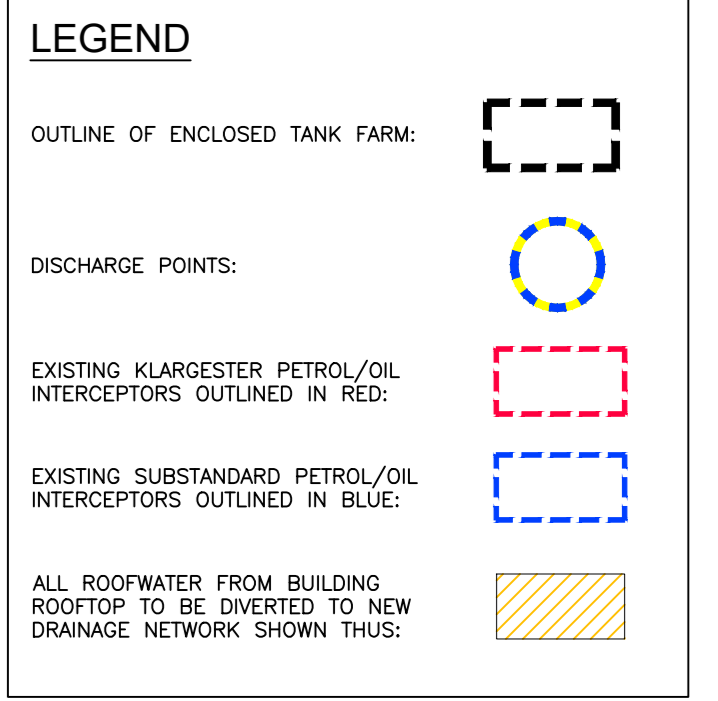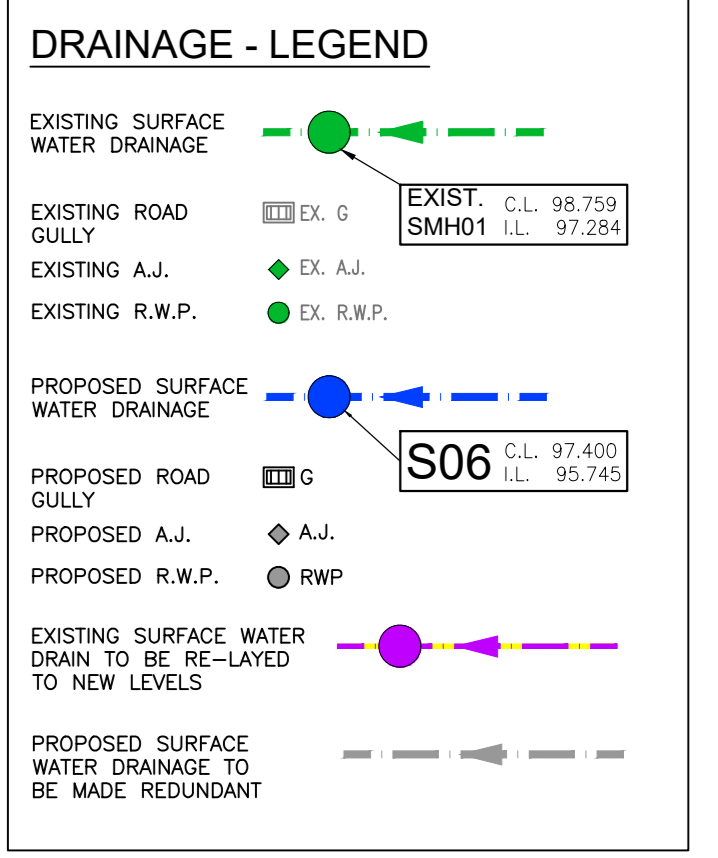

**NOTE:** DRAINAGE LINES BASED ON SURVEY DATA PROVIDED BY CARROLL SURVEYORS.  
DRAWING REFERENCE: 17-121-01  
DATE: 11/09/2017.  
LEVELS SHOWN AROUND PLANT ARE TO 100.00m TO CONVERT TO MALIN HEAD DATUM SUBTRACT 68.406.

**PRELIMINARY**  
26/11/21

Rev.	Description	Date	Drawn	Chkd	Appr.

THIS DRAWING TO BE USED FOR PRELIMINARY PURPOSES ONLY

**ADR**  
MALONE O'REGAN  
CONSULTING ENGINEERS

3-4 Canada Street  
Waterford  
Co. Waterford  
X91 V52K  
Tel: +353 51 876 855  
Email: waterford@moroe.ie  
Web: www.maloroegan.com

Offices also in:  
DUBLIN: Tel: +353 1 260 2655 Email: dublin@moroe.ie  
GALWAY: Tel: +353 91 531 069 Email: galway@moroe.ie  
LONDON: Tel: +44 208 5281685 Email: london@moroe.ie

Client: CONNOLLY REDMILLS


Job: ENVIRONMENTAL LICENCE APPLICATION

Drawing: PROPOSED DRAINAGE LAYOUT

Job No	Orig No	Stage	Revision	Scale
W21084	P710	PP	PP	A3 1:500 N.T.S.

DON'T SCALE DIMENSIONS

R:\2021\W21084\01 - Design and Drawings\1\Waterford - Preliminary\CDR - Proposed Drainage Layout.dwg


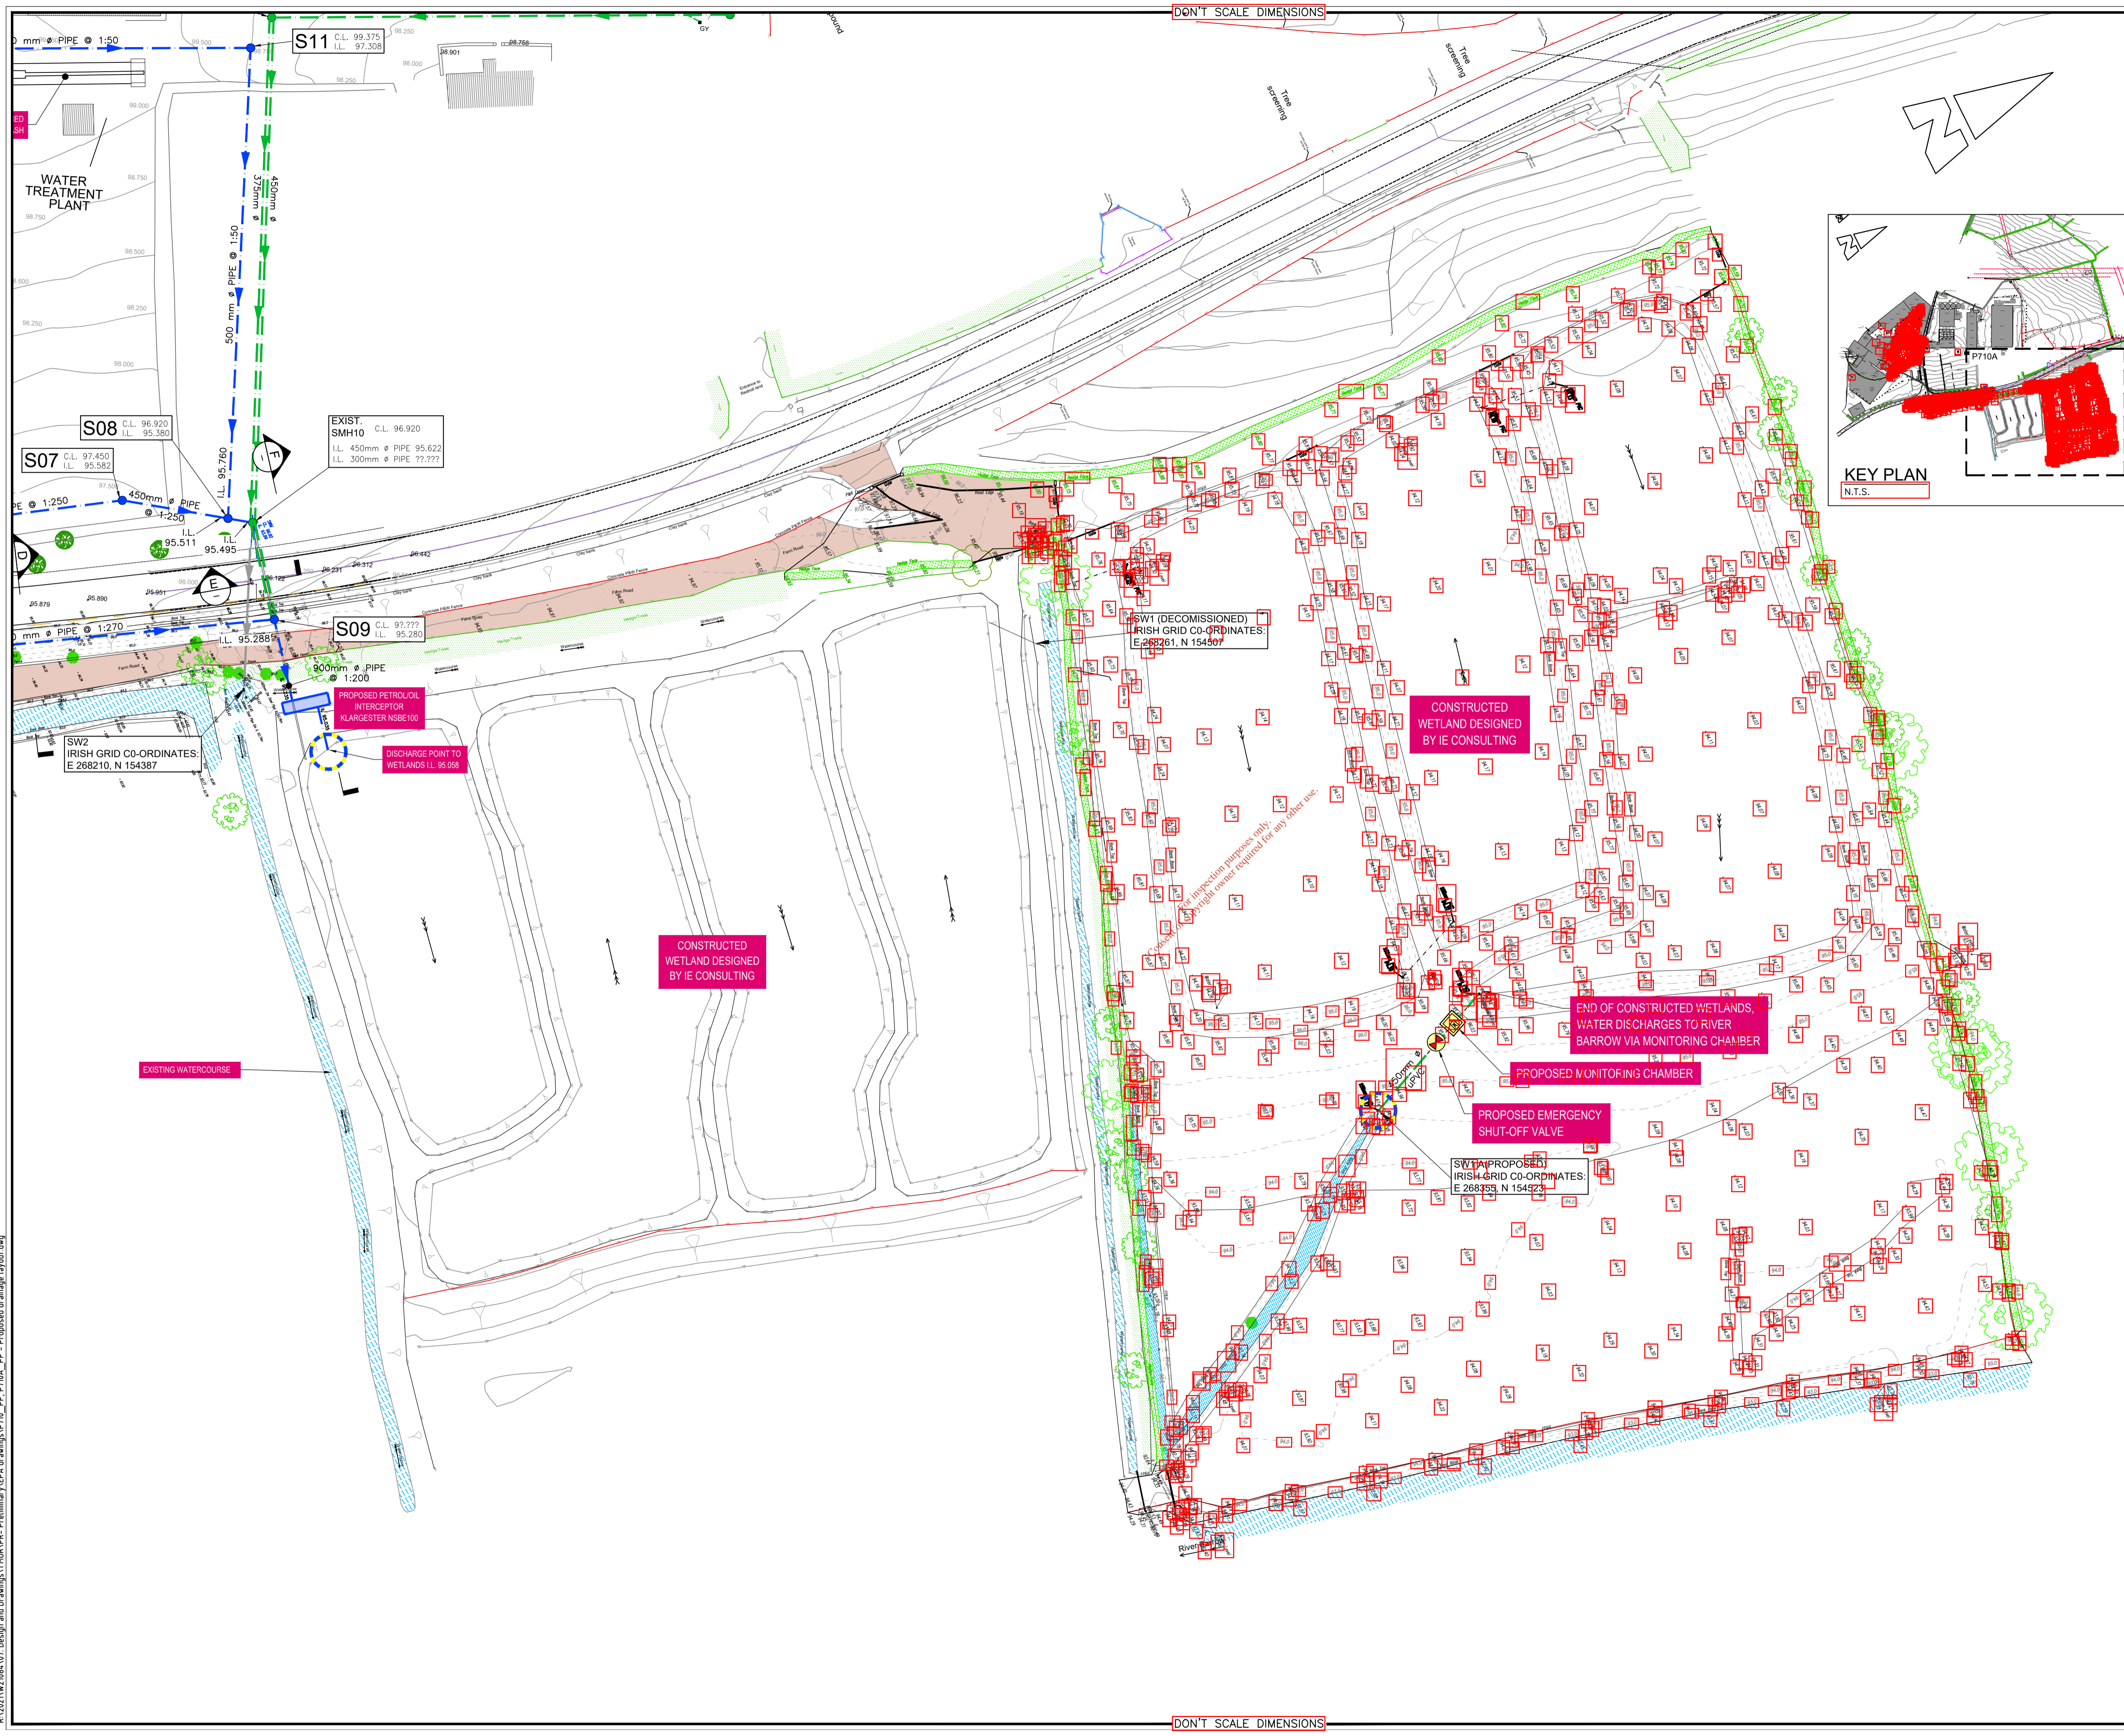


DON'T SCALE DIMENSIONS

DON'T SCALE DIMENSIONS

**Health and Safety:**  
 THIS DRAWING TO BE READ IN CONJUNCTION WITH ALL OTHER RELEVANT DRAWINGS, THE SPECIFICATION AND THE SAFETY AND HEALTH PLAN.  
 THE APPOINTMENT OF THE PROJECT SUPERVISOR DESIGN PROCESS IS THE CLIENT'S RESPONSIBILITY.  
 TEMPORARY WORKS PROPOSALS AND/OR METHOD STATEMENTS TO BE SUBMITTED TO THE PSPD AND THE PSCS FOR WORKS WHICH INVOLVE PARTICULAR RISKS.

- Notes:**
- NO PART OF THIS DRAWING MAY BE REPRODUCED OR TRANSMITTED IN ANY FORM OR STORED IN ANY RETRIEVAL SYSTEM OF ANY NATURE, WITHOUT THE WRITTEN PERMISSION OF MALONE O'REGAN CONSULTING ENGINEERS AS COPYRIGHT HOLDER EXCEPT AS AGREED FOR USE ON THE PROJECT FOR WHICH THE DRAWING WAS ORIGINALLY ISSUED.
  - THE APPOINTMENT OF THE PROJECT SUPERVISOR DESIGN PROCESS IS THE CLIENT'S RESPONSIBILITY.
  - ALL DIMENSIONS IN mm UNLESS NOTED OTHERWISE.
  - THE CONTRACTOR SHALL CHECK ALL DIMENSIONS PRIOR TO COMMENCEMENT OF CONSTRUCTION. DISCREPANCIES SHALL BE REPORTED TO THIS OFFICE IN WRITING.
  - THIS DRAWING TO BE READ IN ACCORDANCE WITH ALL RELEVANT ENGINEERS' DRAWINGS AND SPECIFICATIONS.

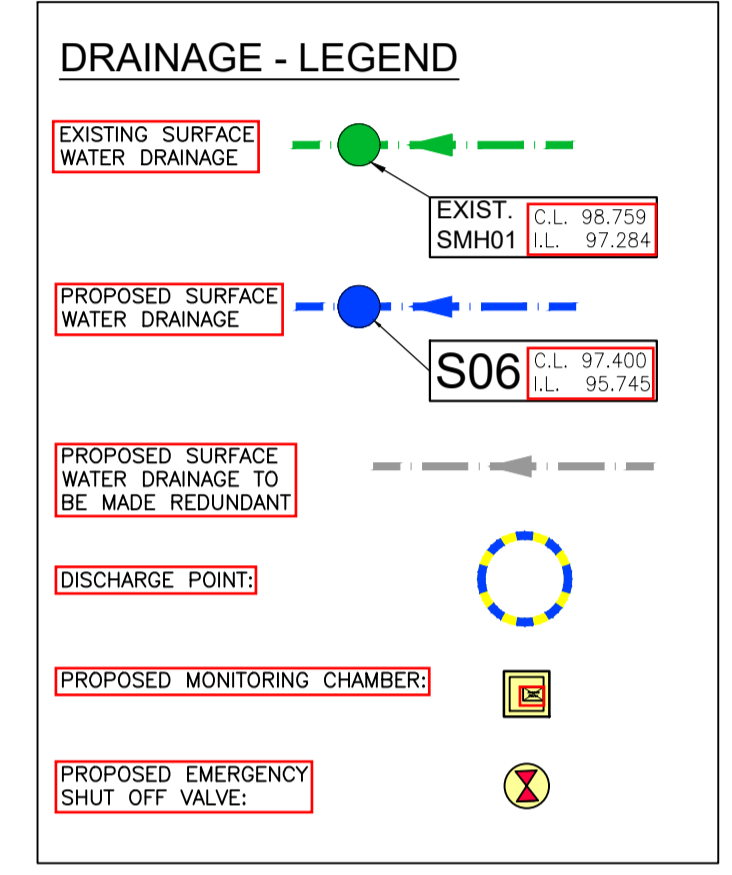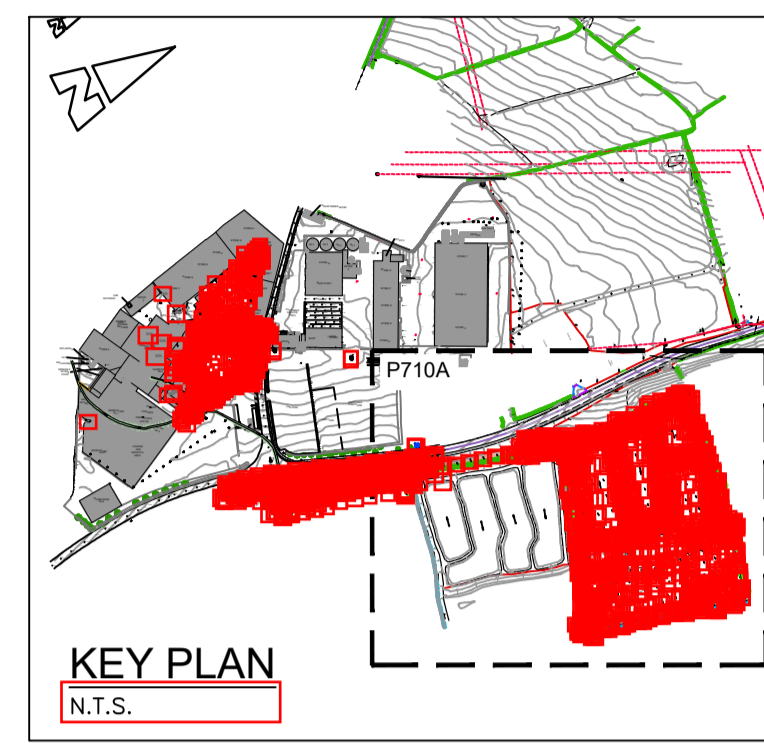

**NOTE:**  
 DRAINAGE LINES BASED ON SURVEY DATA PROVIDED BY CARDINAL SURVEYORS.  
 DRAWING REFERENCE: 17-121-01  
 DATE: 11/09/2017.  
 LEVELS SHOWN AROUND PLANT ARE TO TBM OF 100.00m. TO CONVERT TO MALIN HEAD DATUM SUBTRACT 68.406.

**PRELIMINARY**  
 26/11/21

Rev.	Description	Date	Drawn	Chkd	Appr

THIS DRAWING TO BE USED FOR PRELIMINARY PURPOSES ONLY

**ADR**  
**MALONE O'REGAN**  
 CONSULTING ENGINEERS

3-4 Canada Street  
 Waterford  
 Co. Waterford.  
 X91 V52K  
 Tel: +353 51 876 855  
 Email: waterford@morco.ie  
 Web: www.maloneoregan.com

Offices also in:  
 DUBLIN : Tel: +353 1 260 2655 Email: dublin@morco.ie  
 GALWAY: Tel: +353 91 531 069 Email: galway@morco.ie  
 LONDON: Tel: +44 208 5281685 Email: london@morco.ie

Client: **CONNOLLY'S REDMILLS**

Job: **ENVIRONMENTAL LICENCE APPLICATION**

Drawing: **PROPOSED DRAINAGE LAYOUT SHEET 2 OF 2**

Job No	Drg No	Stage	Revision	Scale
W21084	P710A	PP	PP	1:500 A3 1:1000

R:\2021\W21084\07\_Design and Drawings\1\MDR\Pre-Preliminary\EPA Drawings\PT10\_PP\_P710A\_PP\_Proposed drainage layout.dwg