

GENERAL NOTES

- NOTES:**
1. ORDNANCE SURVEY IRELAND LICENCE NUMBER EN 3-3-34.
 2. THIS DRAWING TO BE READ IN CONJUNCTION WITH ALL OTHER RELEVANT DRAWINGS.

LEGEND:

SITE BOUNDARY	
PRIMARY DISCHARGE POINT AND SWO	
SECONDARY DISCHARGE POINT	
PRIMARY DISCHARGE SAMPLING, AND MONITORING POINT	
SECONDARY DISCHARGE MONITORING POINT	

Rev	Date	Description	By	Chk	App
FO	06.05.21	ISSUED FOR INFORMATION	LT	OL	KT

BYRNE LOOBY

2100 Cork Airport Business Park, Kinsale Road, Cork
 tel: +353 (0) 21 2407988
 email: cork@ByrneLooby.com www.ByrneLooby.com

BAHRAIN • IRELAND • QATAR • SAUDI ARABIA • UAE • UK
 CIVIL STRUCTURAL WATER & GEOTECHNICAL SPECIALISTS

ARUP

Arup,
 One Albert Quay
 Cork
 Tel +353(0)21 422 3200
 www.arup.com

CLIENT

Obair i gcomhpháirtíocht
 Working in Partnership

PROJECT

**UTAS – CORK BUNDLE
 INCHIGEELAGH SEWERAGE SCHEME**


DRAWING TITLE

**DISCHARGE CERTIFICATE APPLICATION
 ATTACHMENT B.2
 WWTP & PS SITE BOUNDARY**

STATUS

FOR INFORMATION

Date: 06.05.21	Scale: 1:2000	Drawn: LT	Chk: OL	App: KT
Project No: 257589_00	Drg. No: IW-10015227-03-02-002	Rev:	FO	

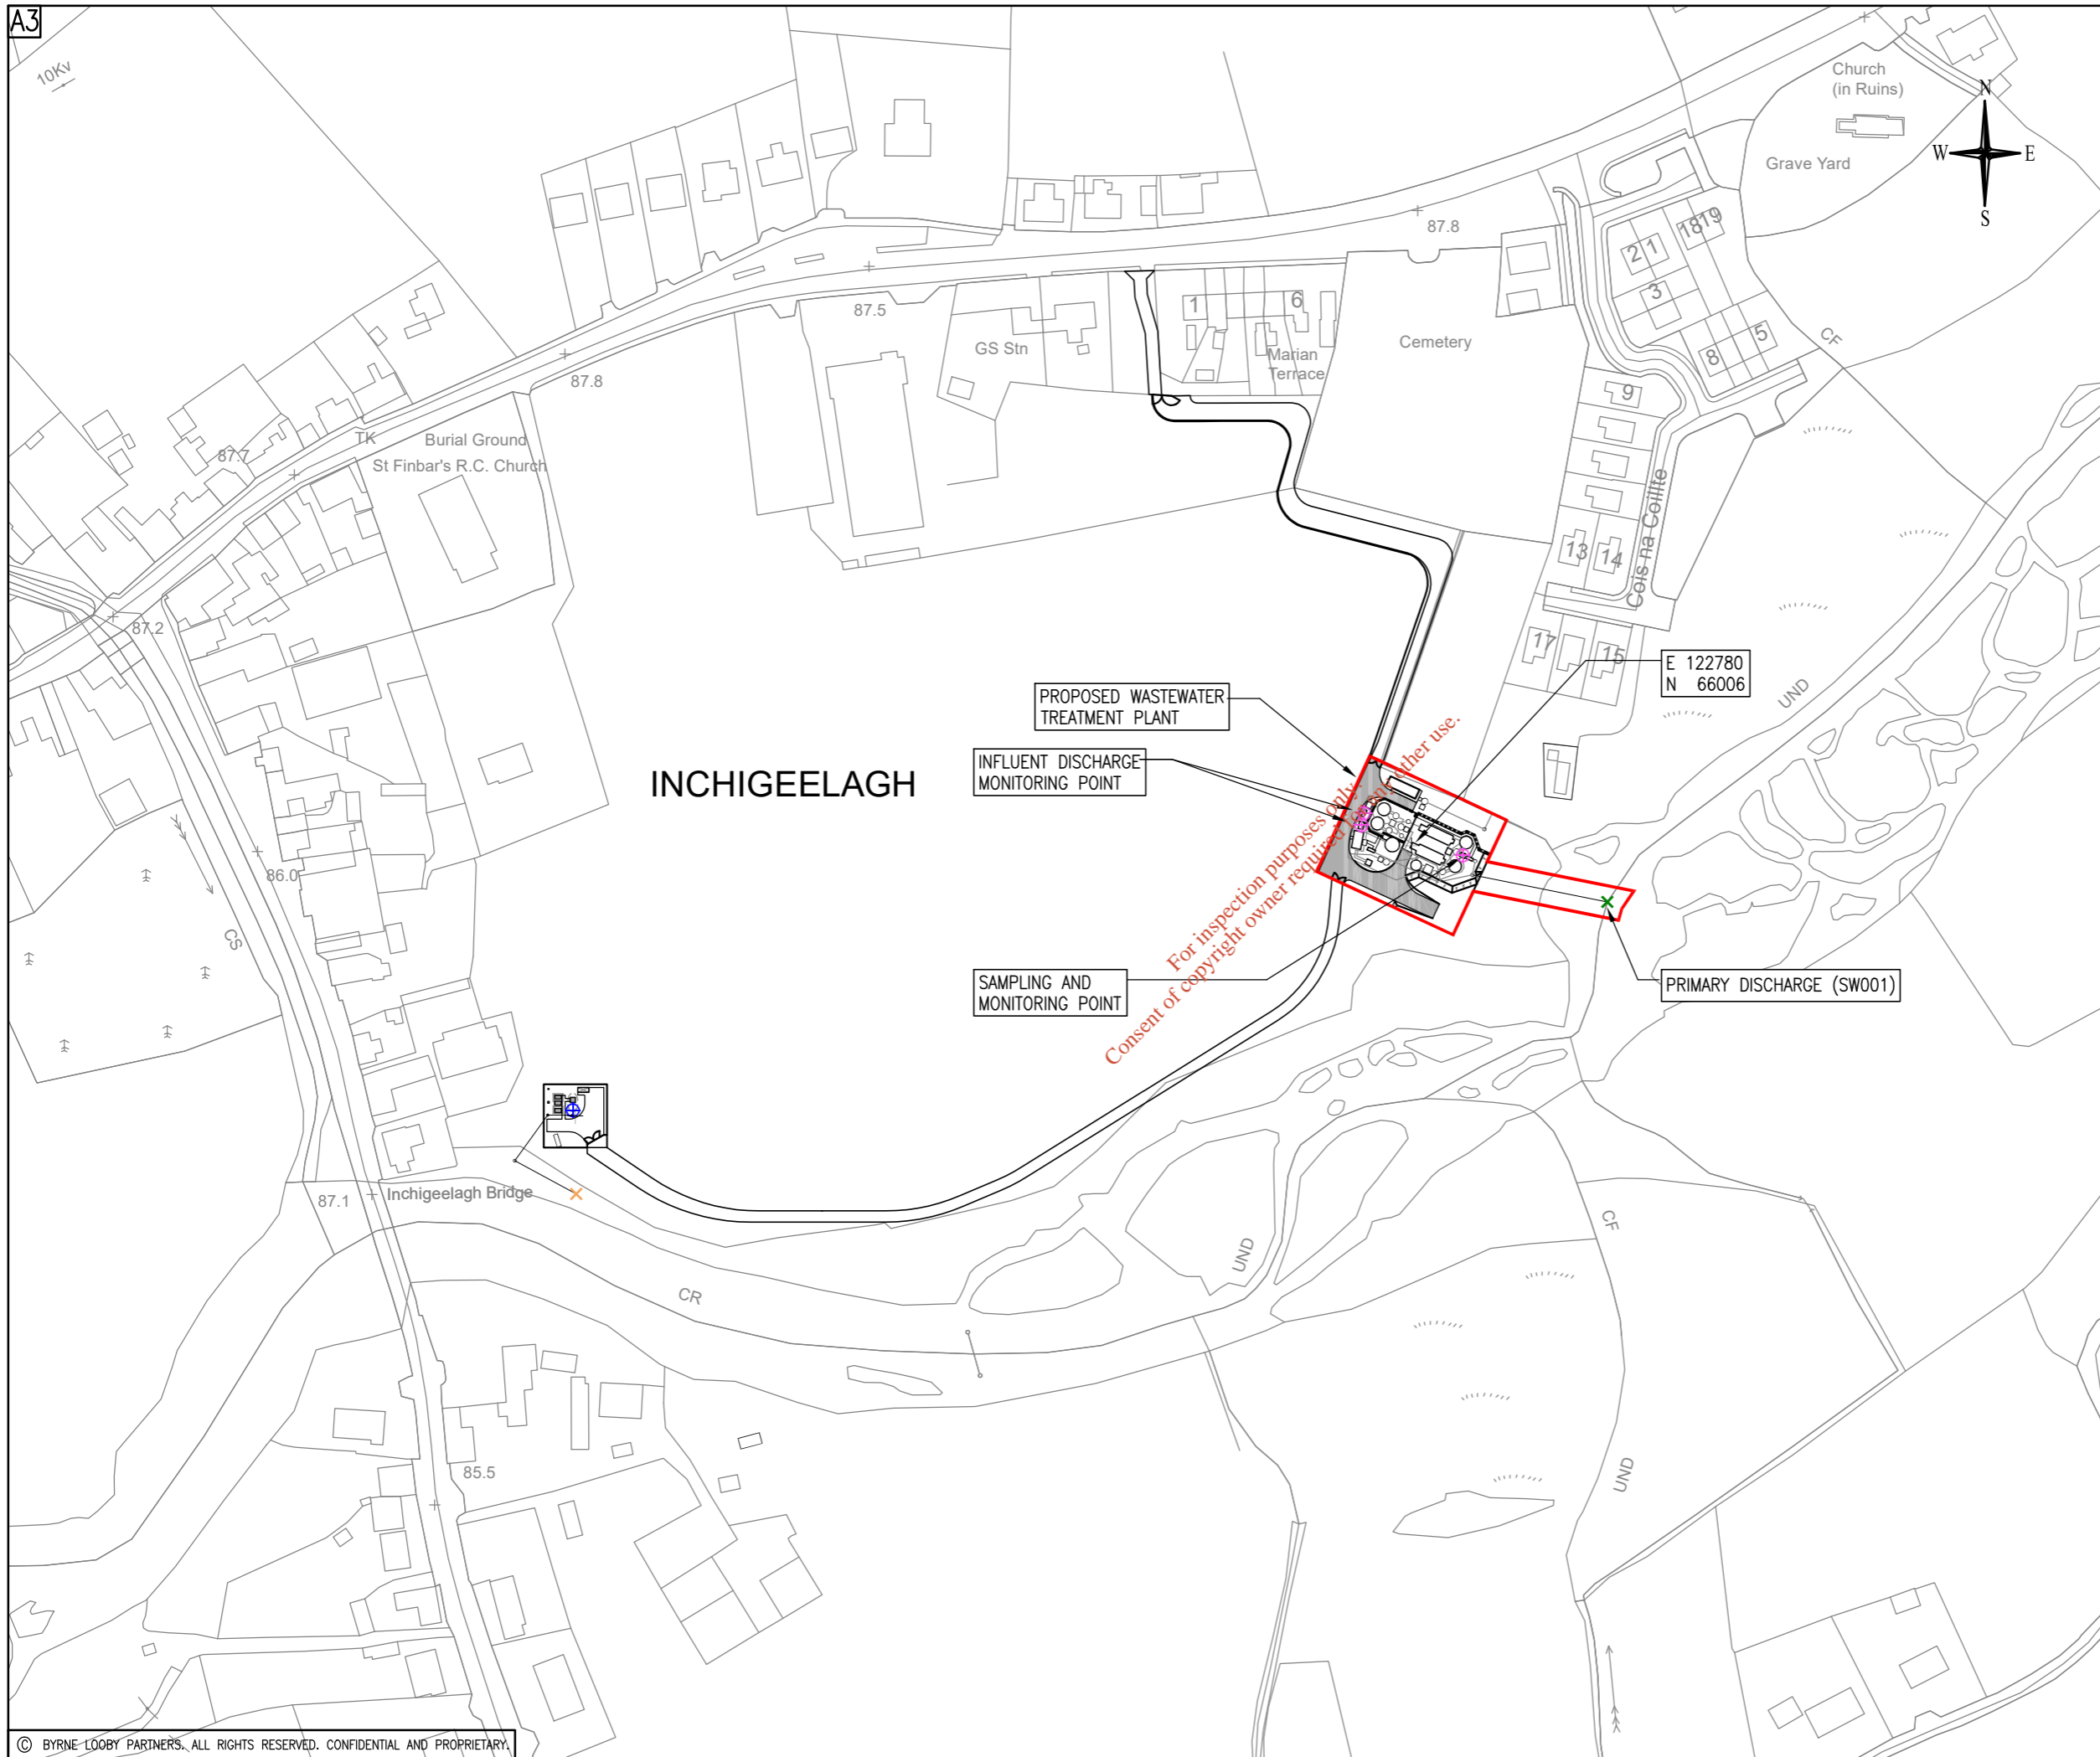

GENERAL NOTES

NOTES:

1. ORDNANCE SURVEY IRELAND LICENCE NUMBER EN 3-3-34.
2. THIS DRAWING TO BE READ IN CONJUNCTION WITH ALL OTHER RELEVANT DRAWINGS.

LEGEND:

SITE BOUNDARY	
PRIMARY DISCHARGE POINT AND SWO	
SECONDARY DISCHARGE POINT	
PRIMARY DISCHARGE SAMPLING, AND MONITORING POINT	
SECONDARY DISCHARGE MONITORING POINT	

Rev	Date	Description	By	Chk	App
F1	28.07.21	ISSUED FOR INFORMATION	OL	OL	KT
F0	18.01.21	ISSUED FOR INFORMATION	LT	OL	KT

BYRNE LOOBY

2100 Cork Airport Business Park, Kinsale Road, Cork
 tel: +353 (0) 21 2407988
 email: cork@ByrneLooby.com www.ByrneLooby.com

BAHRAIN • IRELAND • QATAR • SAUDI ARABIA • UAE • UK
 CIVIL STRUCTURAL WATER & GEOTECHNICAL SPECIALISTS

ARUP

Arup,
 One Albert Quay
 Cork
 Tel +353(0)21 422 3200
 www.arup.com

CLIENT

Obair i gcomhpháirtíocht
 Working in Partnership

PROJECT

**UTAS – CORK BUNDLE
 INCHIGEELAGH SEWERAGE SCHEME**


DRAWING TITLE

**DISCHARGE CERTIFICATE APPLICATION
 ATTACHMENT B.3
 PRIMARY DISCHARGE POINT**

STATUS

FOR INFORMATION

Date: 02.10.20	Scale: 1:2000	Drawn: LT	Chk: OL	App: KT
Project No: 257589_00	Drg. No: IW-10015227-03-02-003	Rev:		F1

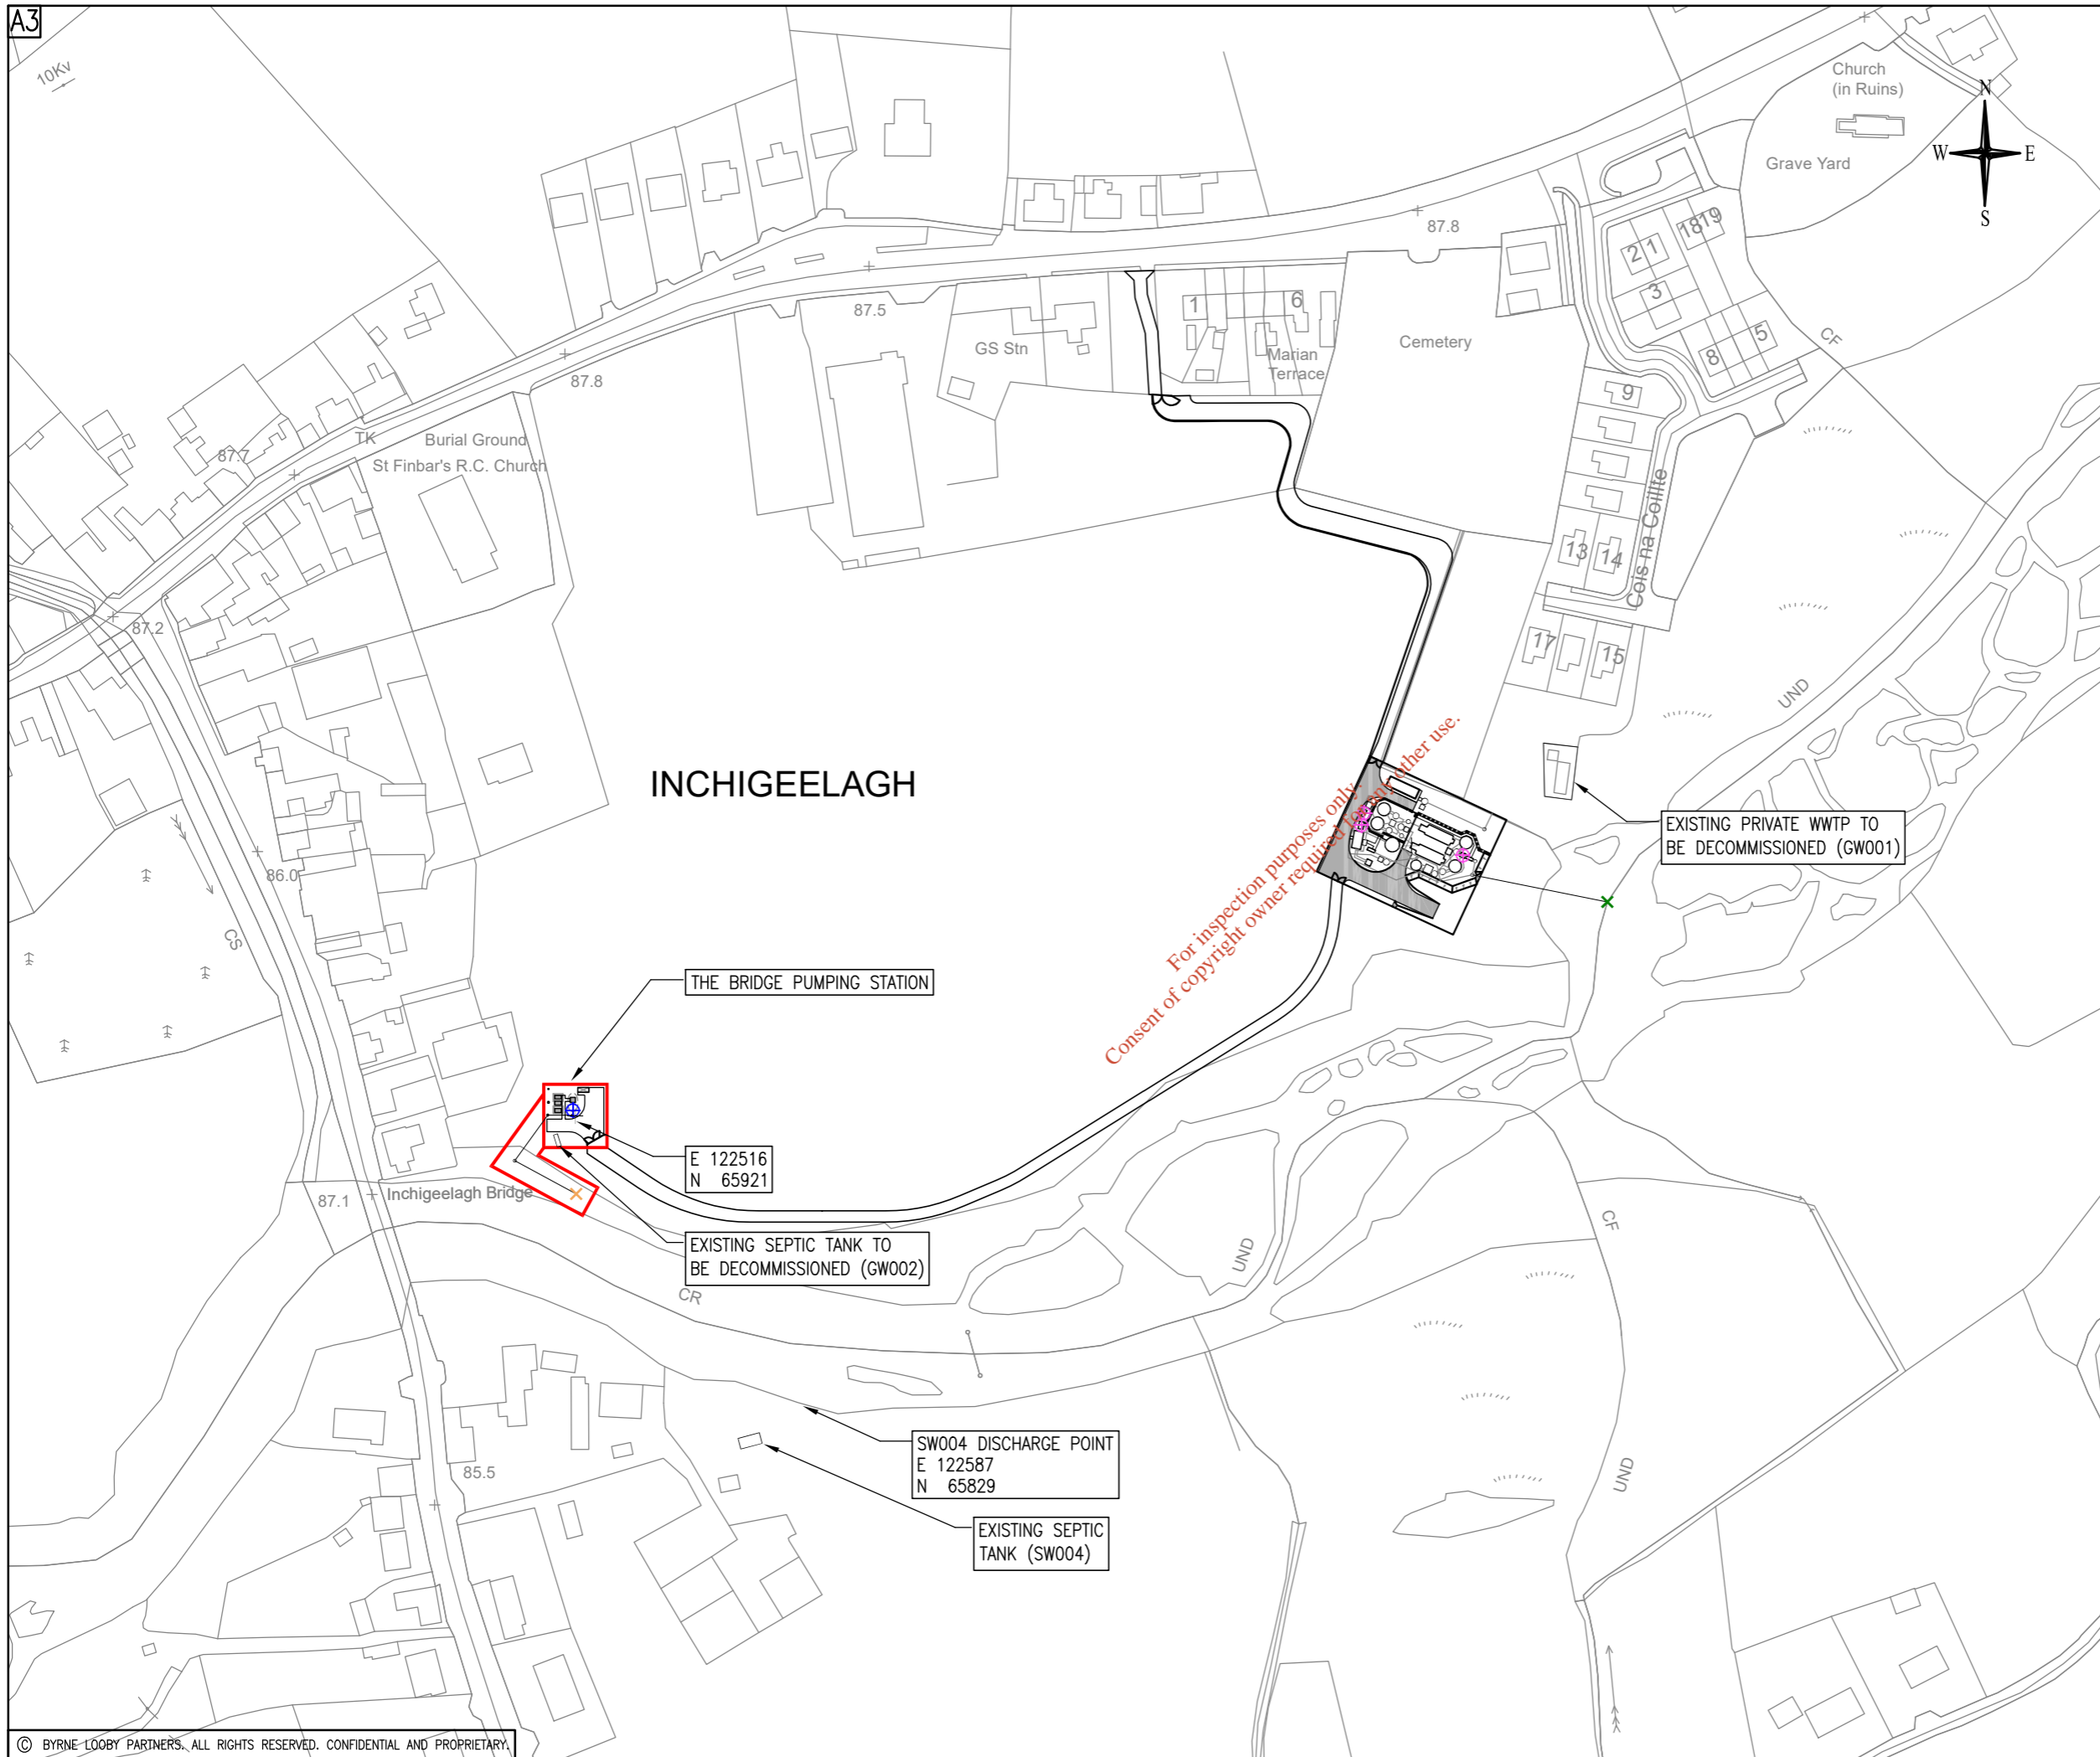

GENERAL NOTES

NOTES:

1. ORDNANCE SURVEY IRELAND LICENCE NUMBER EN 3-3-34.
2. THIS DRAWING TO BE READ IN CONJUNCTION WITH ALL OTHER RELEVANT DRAWINGS.

LEGEND:

- SITE BOUNDARY —
- PRIMARY DISCHARGE POINT AND SWO ✕
- SECONDARY DISCHARGE POINT ✕
- PRIMARY DISCHARGE SAMPLING, AND MONITORING POINT ⊕
- SECONDARY DISCHARGE MONITORING POINT ⊕

Rev	Date	Description	By	Chk	App
F1	30.07.21	ISSUED FOR INFORMATION	OL	OL	KT
F0	18.01.21	ISSUED FOR INFORMATION	LT	OL	KT

BYRNE LOOBY

2100 Cork Airport Business Park, Kinsale Road, Cork
 tel: +353 (0) 21 2407988
 email: cork@ByrneLooby.com www.ByrneLooby.com

BAHRAIN • IRELAND • QATAR • SAUDI ARABIA • UAE • UK
 CIVIL STRUCTURAL WATER & GEOTECHNICAL SPECIALISTS

ARUP

Arup,
 One Albert Quay
 Cork
 Tel +353(0)21 422 3200
 www.arup.com

CLIENT

Obair i gcomhpháirtíocht
 Working in Partnership

PROJECT

**UTAS – CORK BUNDLE
 INCHIGEELAGH SEWERAGE SCHEME**


DRAWING TITLE

**DISCHARGE CERTIFICATE APPLICATION
 ATTACHMENT B.4
 SECONDARY DISCHARGE POINTS**

STATUS

FOR INFORMATION

Date: 02.10.20	Scale: 1:2000	Drawn: LT	Chk: OL	App: KT
Project No: 257589_00	Drg. No: IW-10015227-03-02-004	Rev:		F1

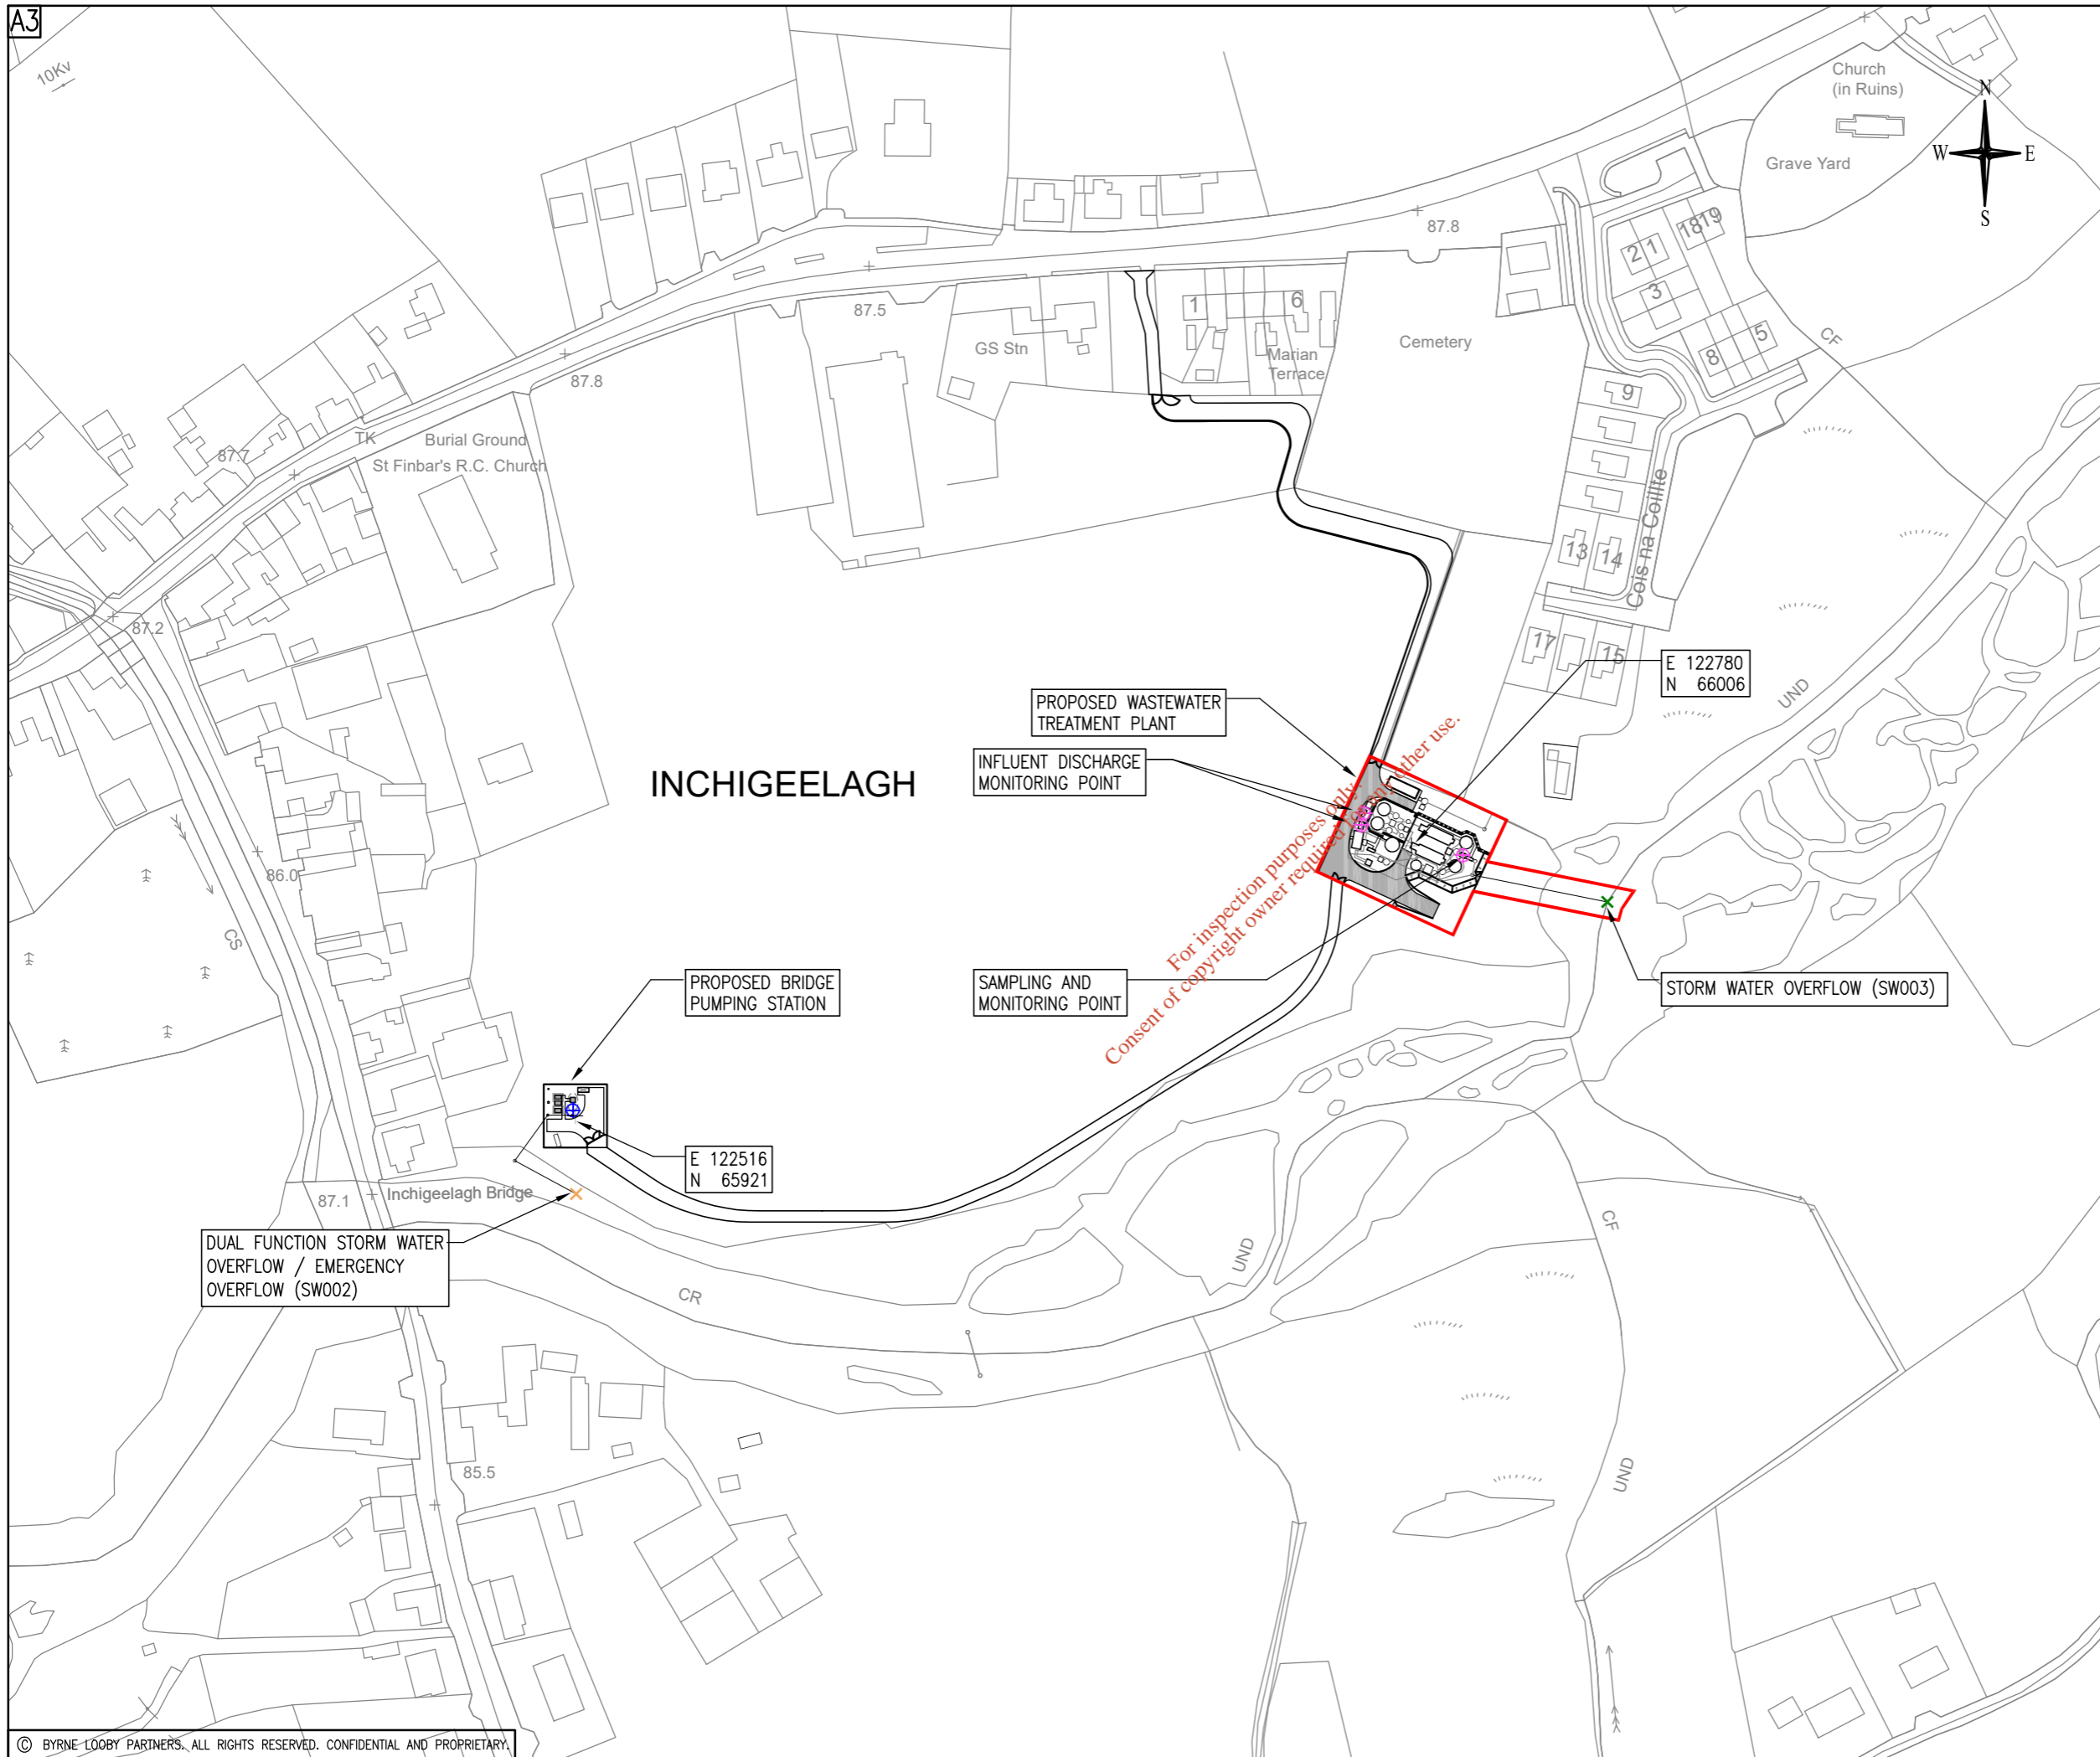

GENERAL NOTES

NOTES:

1. ORDNANCE SURVEY IRELAND LICENCE NUMBER EN 3-3-34.
2. THIS DRAWING TO BE READ IN CONJUNCTION WITH ALL OTHER RELEVANT DRAWINGS.

LEGEND:

SITE BOUNDARY	
PRIMARY DISCHARGE POINT AND SWO	
SECONDARY DISCHARGE POINT	
PRIMARY DISCHARGE SAMPLING, AND MONITORING POINT	
SECONDARY DISCHARGE MONITORING POINT	

Rev	Date	Description	By	Chk	App
F1	30.07.21	ISSUED FOR INFORMATION	OL	OL	KT
F0	18.01.21	ISSUED FOR INFORMATION	LT	OL	KT

BYRNE LOOBY

2100 Cork Airport Business Park, Kinsale Road, Cork
 tel: +353 (0) 21 2407988
 email: cork@ByrneLooby.com www.ByrneLooby.com

BAHRAIN • IRELAND • QATAR • SAUDI ARABIA • UAE • UK
 CIVIL STRUCTURAL WATER & GEOTECHNICAL SPECIALISTS

ARUP

Arup,
 One Albert Quay
 Cork
 Tel +353(0)21 422 3200
 www.arup.com

CLIENT

Obair i gcomhpháirtíocht
 Working in Partnership

PROJECT

**UTAS – CORK BUNDLE
 INCHIGEELAGH SEWERAGE SCHEME**


DRAWING TITLE

**DISCHARGE CERTIFICATE APPLICATION
 ATTACHMENT B.5
 STORM WATER OVERFLOW**

STATUS

FOR INFORMATION

Date: 02.10.20	Scale: 1:2000	Drawn: LT	Chk: OL	App: KT
Project No: 257589_00	Drg. No: IW-10015227-03-02-005	Rev:		F1

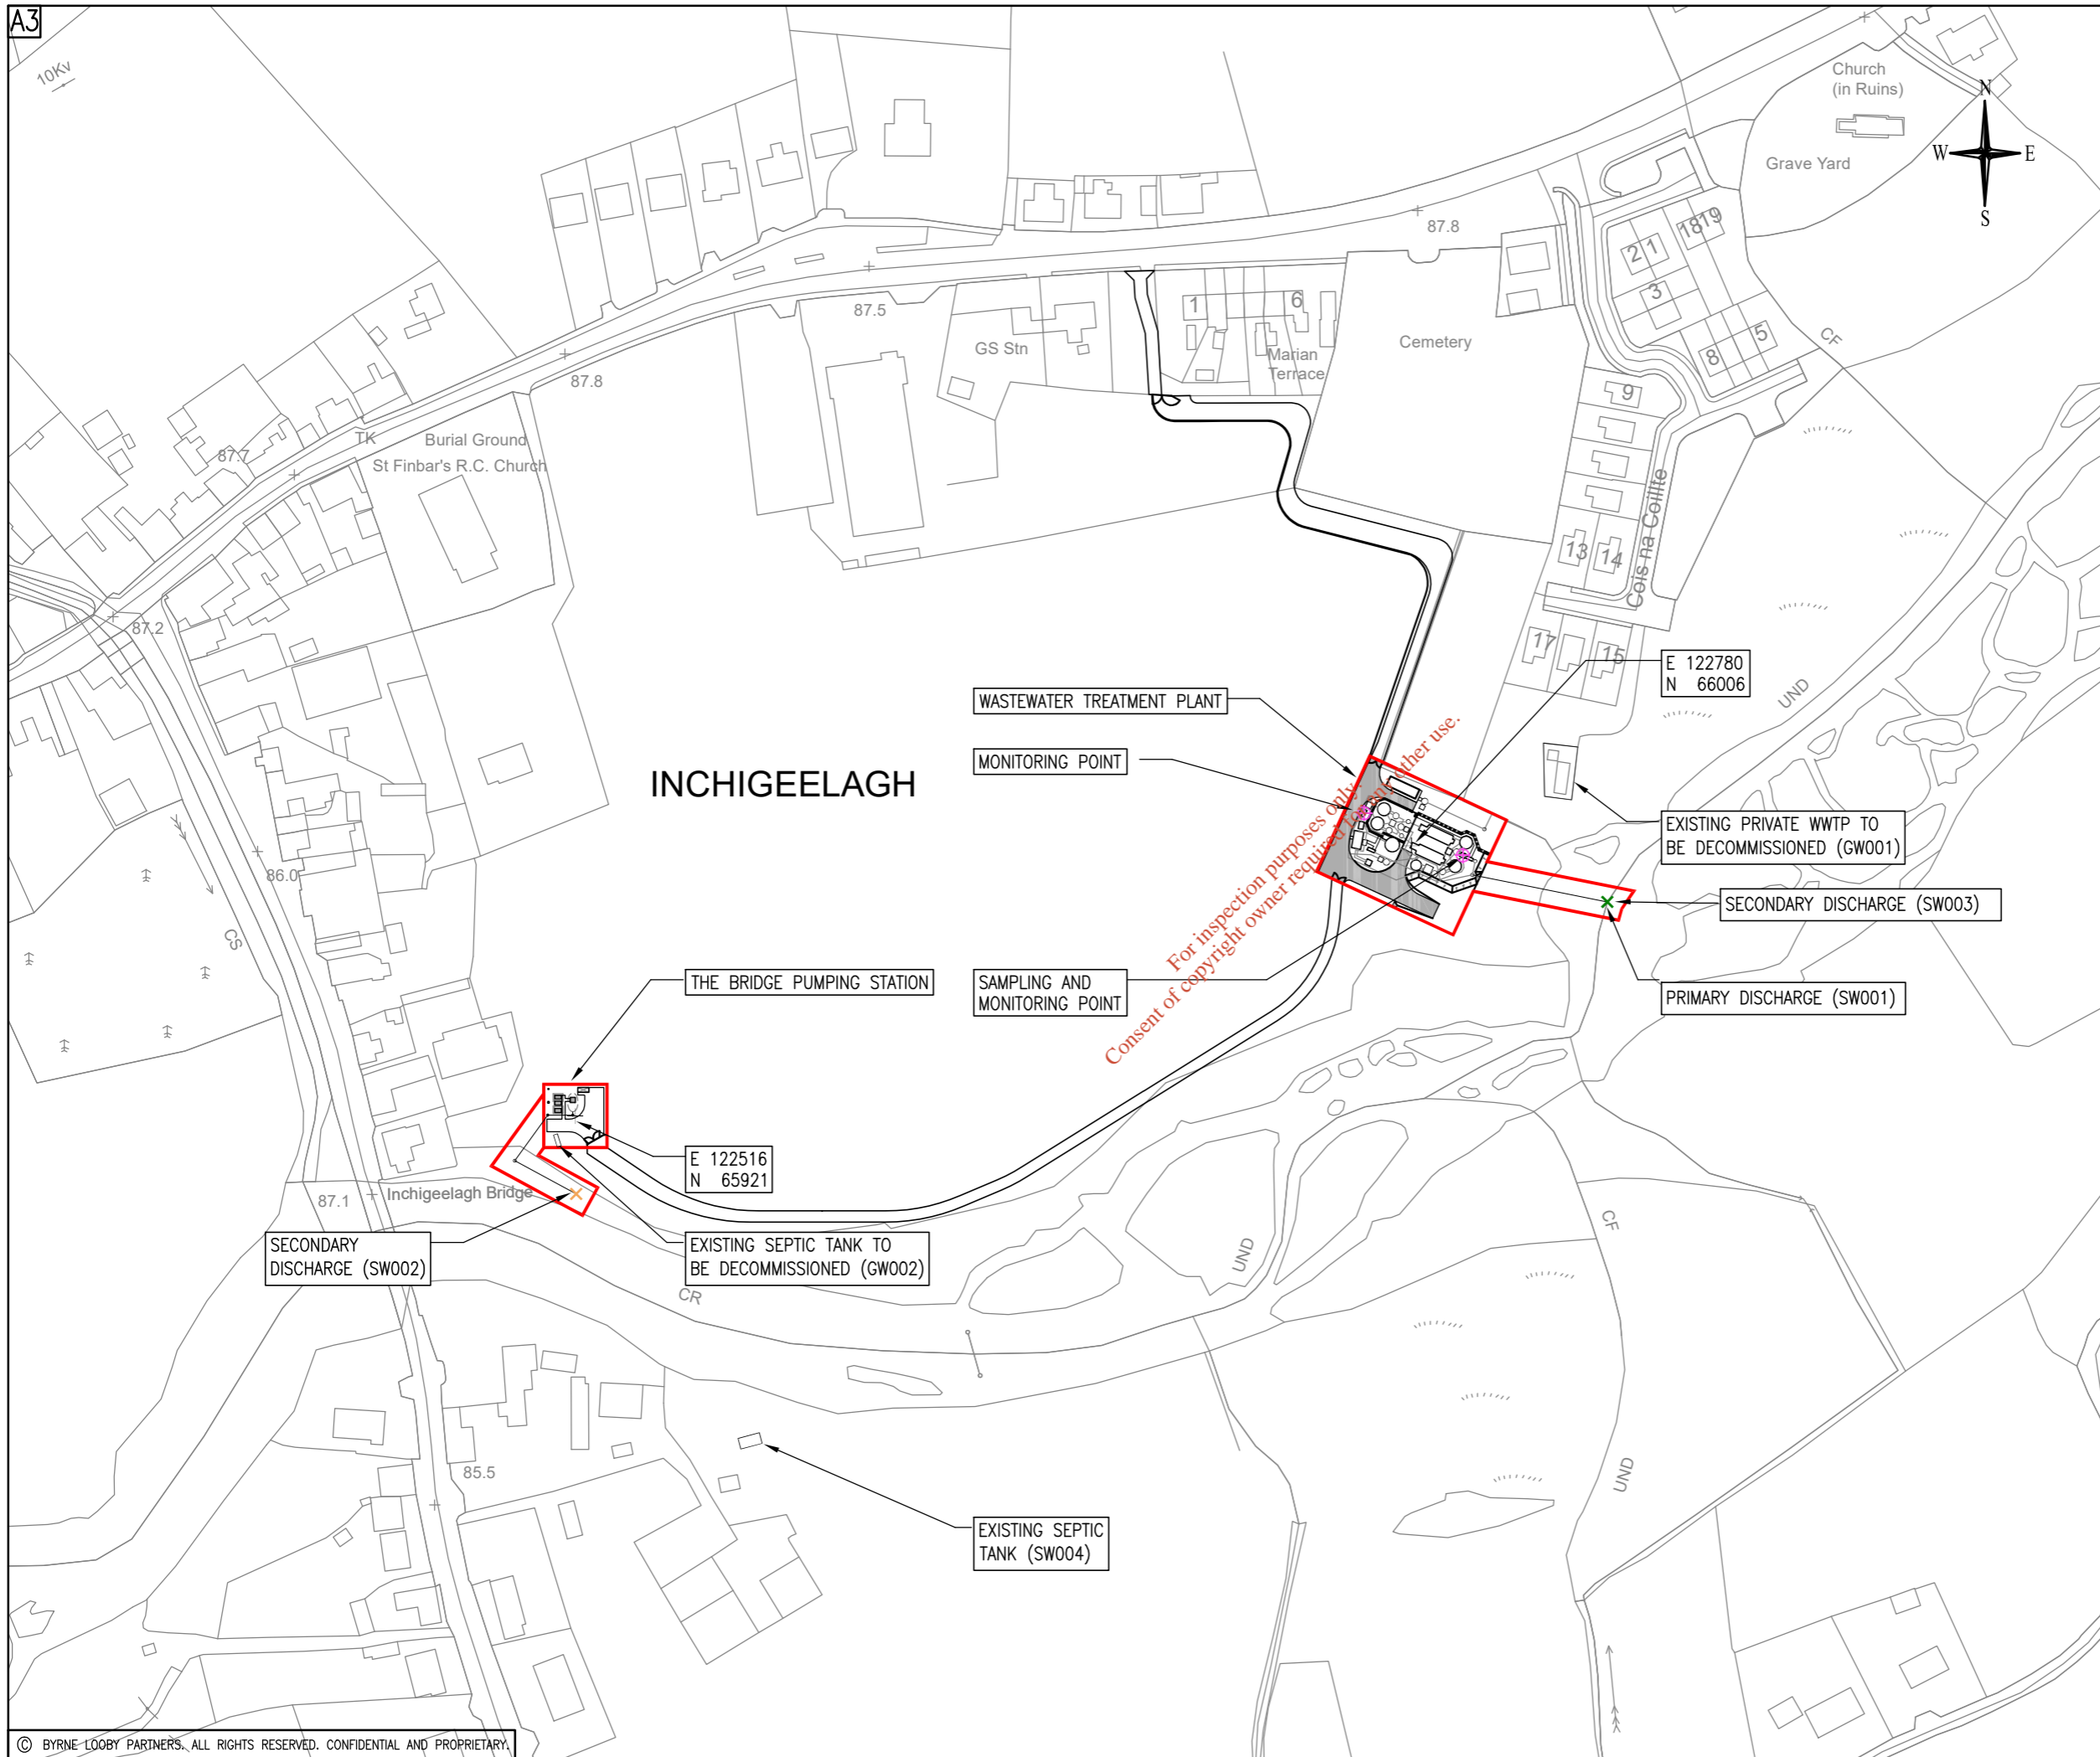

GENERAL NOTES

NOTES:

1. ORDNANCE SURVEY IRELAND LICENCE NUMBER EN 3-3-34.
2. THIS DRAWING TO BE READ IN CONJUNCTION WITH ALL OTHER RELEVANT DRAWINGS.

LEGEND:

- SITE BOUNDARY —
- PRIMARY DISCHARGE POINT AND SWO ✕
- SECONDARY DISCHARGE POINT ✕
- PRIMARY DISCHARGE SAMPLING, AND MONITORING POINT ⊕
- SECONDARY DISCHARGE MONITORING POINT ⊕

Rev	Date	Description	By	Chk	App
FO	06.05.21	ISSUED FOR INFORMATION	LT	OL	KT

BYRNE LOOBY

2100 Cork Airport Business Park, Kinsale Road, Cork
 tel: +353 (0) 21 2407988
 email: cork@ByrneLooby.com www.ByrneLooby.com

BAHRAIN • IRELAND • QATAR • SAUDI ARABIA • UAE • UK
 CIVIL STRUCTURAL WATER & GEOTECHNICAL SPECIALISTS

ARUP

Arup,
 One Albert Quay
 Cork
 Tel +353(0)21 422 3200
 www.arup.com

CLIENT

Obair i gcomhpháirtíocht
 Working in Partnership



PROJECT

**UTAS – CORK BUNDLE
 INCHIGEELAGH SEWERAGE SCHEME**

DRAWING TITLE


**DISCHARGE CERTIFICATE APPLICATION
 ATTACHMENT B.2
 WWTP & PS SITE BOUNDARY**

STATUS

FOR INFORMATION

Date: 06.05.21	Scale: 1:2000	Drawn: LT	Chk: OL	App: KT
Project No: 257589_00	Drg. No: IW-10015227-03-02-002	Rev:		FO

A3

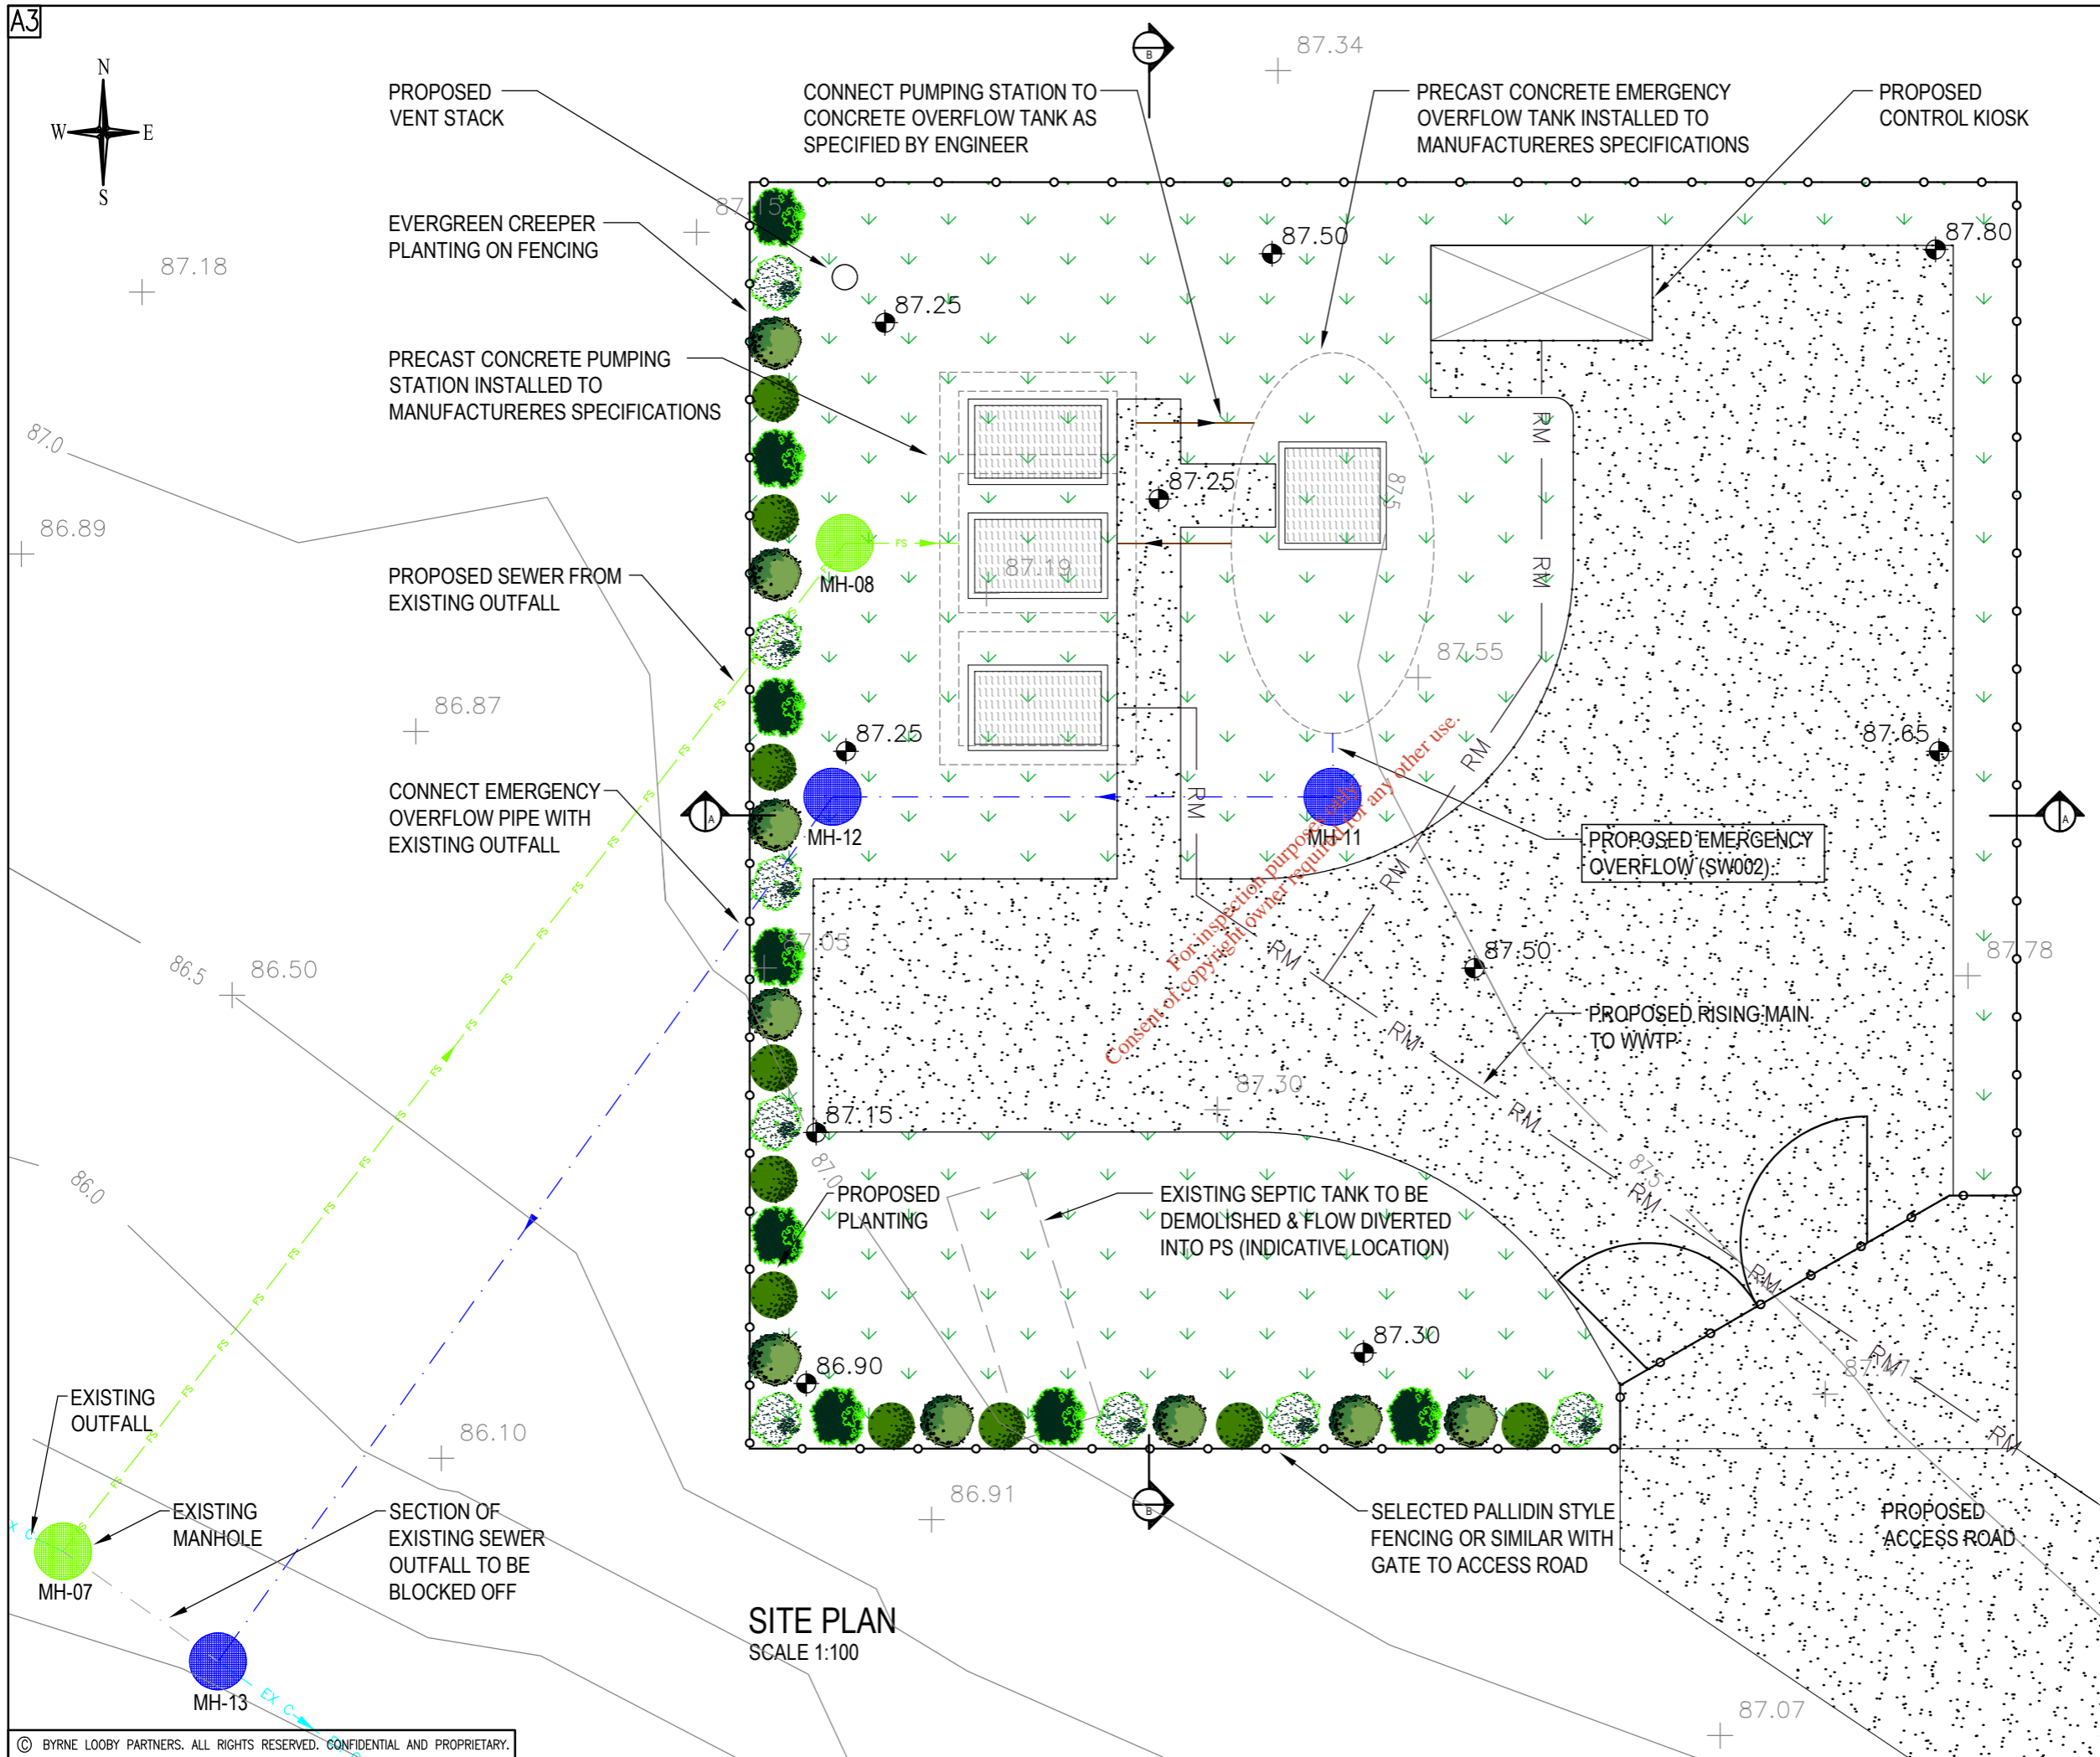

GENERAL NOTES

- NOTES:**
1. ORDNANCE SURVEY IRELAND LICENCE NUMBER EN 3-3-34.
 2. THIS DRAWING TO BE READ IN CONJUNCTION WITH ALL OTHER RELEVANT DRAWINGS.

LEGEND:

EXISTING SEWER	— EX C —
PROPOSED SEWER	— FS —
PROPOSED RISING MAIN	— RM —
PROPOSED OUTFALL	— OUF —
PROPOSED OVERFLOW PIPE	— OFP —
EXISTING GROUND LEVEL	+ xx.xx
PROPOSED GROUND LEVEL	● xx.xx

Rev	Date	Description	By	Chk	App
FO 18.01.21		ISSUED FOR INFORMATION	LT	OL	KT

BYRNE LOOBY

2100 Cork Airport Business Park, Kinsale Road, Cork
 tel: +353 (0) 21 2407988
 email: cork@ByrneLooby.com www.ByrneLooby.com

BAHRAIN • IRELAND • QATAR • SAUDI ARABIA • UAE • UK
 CIVIL STRUCTURAL WATER & GEOTECHNICAL SPECIALISTS

ARUP

Arup,
 One Albert Quay
 Cork
 Tel +353(0)21 422 3200
 www.arup.com

CLIENT

Obair i gcomhpháirtíocht
 Working in Partnership

PROJECT

**UTAS – CORK BUNDLE
 INCHIGEELAGH SEWERAGE SCHEME**

DRAWING TITLE

**DISCHARGE CERTIFICATE APPLICATION
 ATTACHMENT C.1
 THE BRIDGE PS SITE LAYOUT**

STATUS

FOR INFORMATION

Date: 18.01.21	Scale: AS SHOWN	Drawn: LT	Chk: OL	App: KT
Project No: 257589_00	Drg. No: IW-10015227-03-02-007	Rev:	FO	

A3



GENERAL NOTES

- NOTES:
1. ORDNANCE SURVEY IRELAND LICENCE NUMBER EN 3-3-34.
 2. THIS DRAWING TO BE READ IN CONJUNCTION WITH ALL OTHER RELEVANT DRAWINGS.

LEGEND

PROPOSED OUTFALL	---
PROPOSED PROCESS PIPEWORK	---
PROPOSED WASTEWATER SEWER	--- FS ---
PROPOSED RISING MAIN	--- RM ---
EXISTING LEVELS	+
PROPOSED LEVELS	⊙

Rev	Date	Description	By	Chk	App
FO	18.01.21	ISSUED FOR INFORMATION	LT	OL	KT

BYRNE LOOBY

2100 Cork Airport Business Park, Kinsale Road, Cork
 tel: +353 (0) 21 2407988
 email: cork@ByrneLooby.com www.ByrneLooby.com

BAHRAIN • IRELAND • QATAR • SAUDI ARABIA • UAE • UK
 CIVIL STRUCTURAL WATER & GEOTECHNICAL SPECIALISTS

ARUP

Arup,
 One Albert Quay
 Cork
 Tel +353(0)21 422 3200
 www.arup.com

CLIENT

Obair i gcomhpháirtíocht
 Working in Partnership

PROJECT

UTAS – CORK BUNDLE
 INCHIGEELAGH SEWERAGE SCHEME



DRAWING TITLE

DISCHARGE CERTIFICATE APPLICATION
 ATTACHMENT C.1
 WWTP SITE LAYOUT

STATUS

FOR INFORMATION

Date: 18.01.21	Scale: 1:200	Drawn: LT	Chk: OL	App: KT
Project No: 257589_00	Drg. No: IW-10015227-03-02-006	Rev:		FO

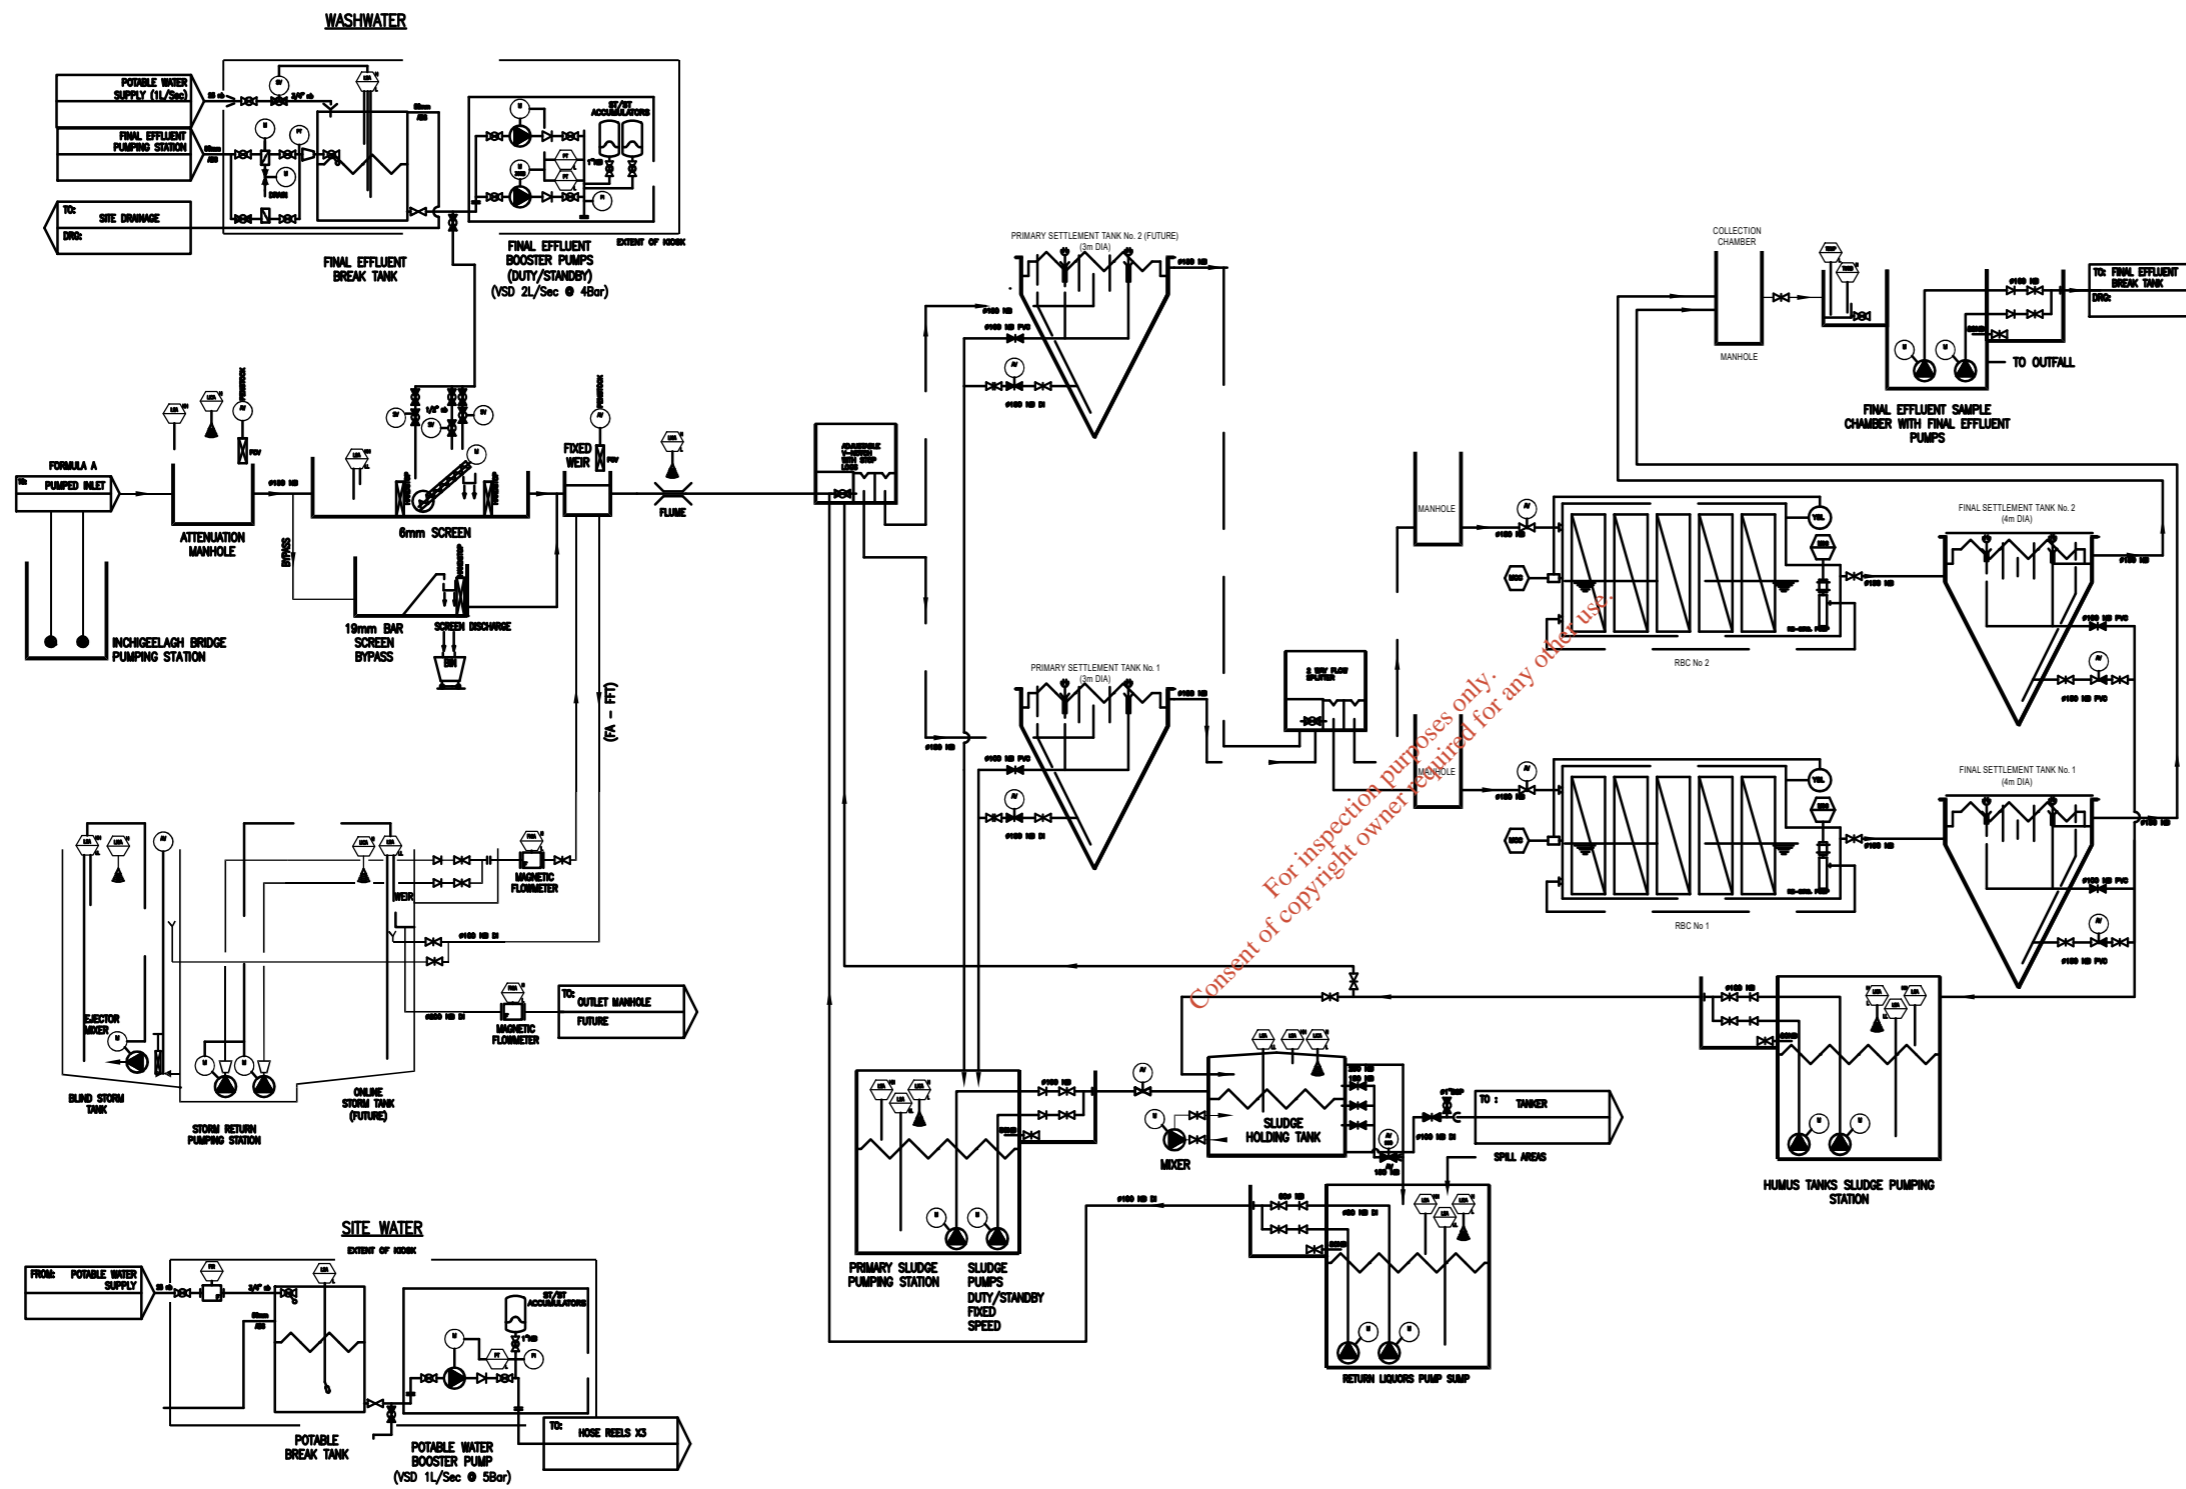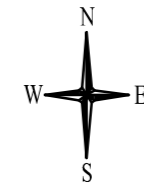

GENERAL NOTES

NOTES:

1. THIS DRAWING TO BE READ IN CONJUNCTION WITH ALL OTHER RELEVANT DRAWINGS.

Rev	Date	Description	By	Chk	App
FO	18.01.21	ISSUED FOR INFORMATION	LT	OL	KT

BYRNE LOOBY

2100 Cork Airport Business Park, Kinsale Road, Cork
 tel: +353 (0) 21 2407988
 email: cork@ByrneLooby.com www.ByrneLooby.com

BAHRAIN • IRELAND • QATAR • SAUDI ARABIA • UAE • UK
 CIVIL STRUCTURAL WATER & GEOTECHNICAL SPECIALISTS

ARUP

Arup,
 One Albert Quay
 Cork
 Tel +353(0)21 422 3200
 www.arup.com

CLIENT

Obair i gcomhpháirtíocht
 Working in Partnership



PROJECT

UTAS – CORK BUNDLE
 INCHIGEELAGH SEWERAGE SCHEME

DRAWING TITLE

DISCHARGE CERTIFICATE APPLICATION
 ATTACHMENT C.1
 PIPING AND INSTRUMENTATION DIAGRAM

STATUS

FOR INFORMATION

Date: 02.10.20	Scale: NTS	Drawn: LT	Chk: OL	App: KT
Project No: 257589_00	Drg. No: IW-10015227-03-02-008	Rev:		FO