



**B.2.2: Map 3 - WwTP Site Location Plan**

**B.2.2: Map 4 – Location of Primary Discharge Point**

**B.2.2: Map 5 – Location of Storm Water Overflows**

**B.2.2: Map 6 – Location of Ambient Monitoring Points**

*For inspection purposes only.  
Consent of copyright owner required for any other use.*



NOTES  
 Ordnance Survey Ireland Licence No. EN0083316  
 Copyright Ordnance Survey Ireland / Government of Ireland.

- LEGEND**
- ▭ WwTP SITE BOUNDARY
  - WASTE WATER PROCESS PIPELINES
  - OVERFLOW PIPELINE
  - OUTFALL PIPELINE
  - ✕ SW1 - PRIMARY DISCHARGE LOCATION
  - ⊕ SW1(s) - PRIMARY DISCHARGE SAMPLING LOCATION

POINT	EASTING	NORTHING
SW1	148611	074819
SW1(s)	148621	074823


SIGNED : \_\_\_\_\_

PRINT NAME : \_\_\_\_\_

POSITION : \_\_\_\_\_

DATE : \_\_\_\_\_

FOR IRISH WATER

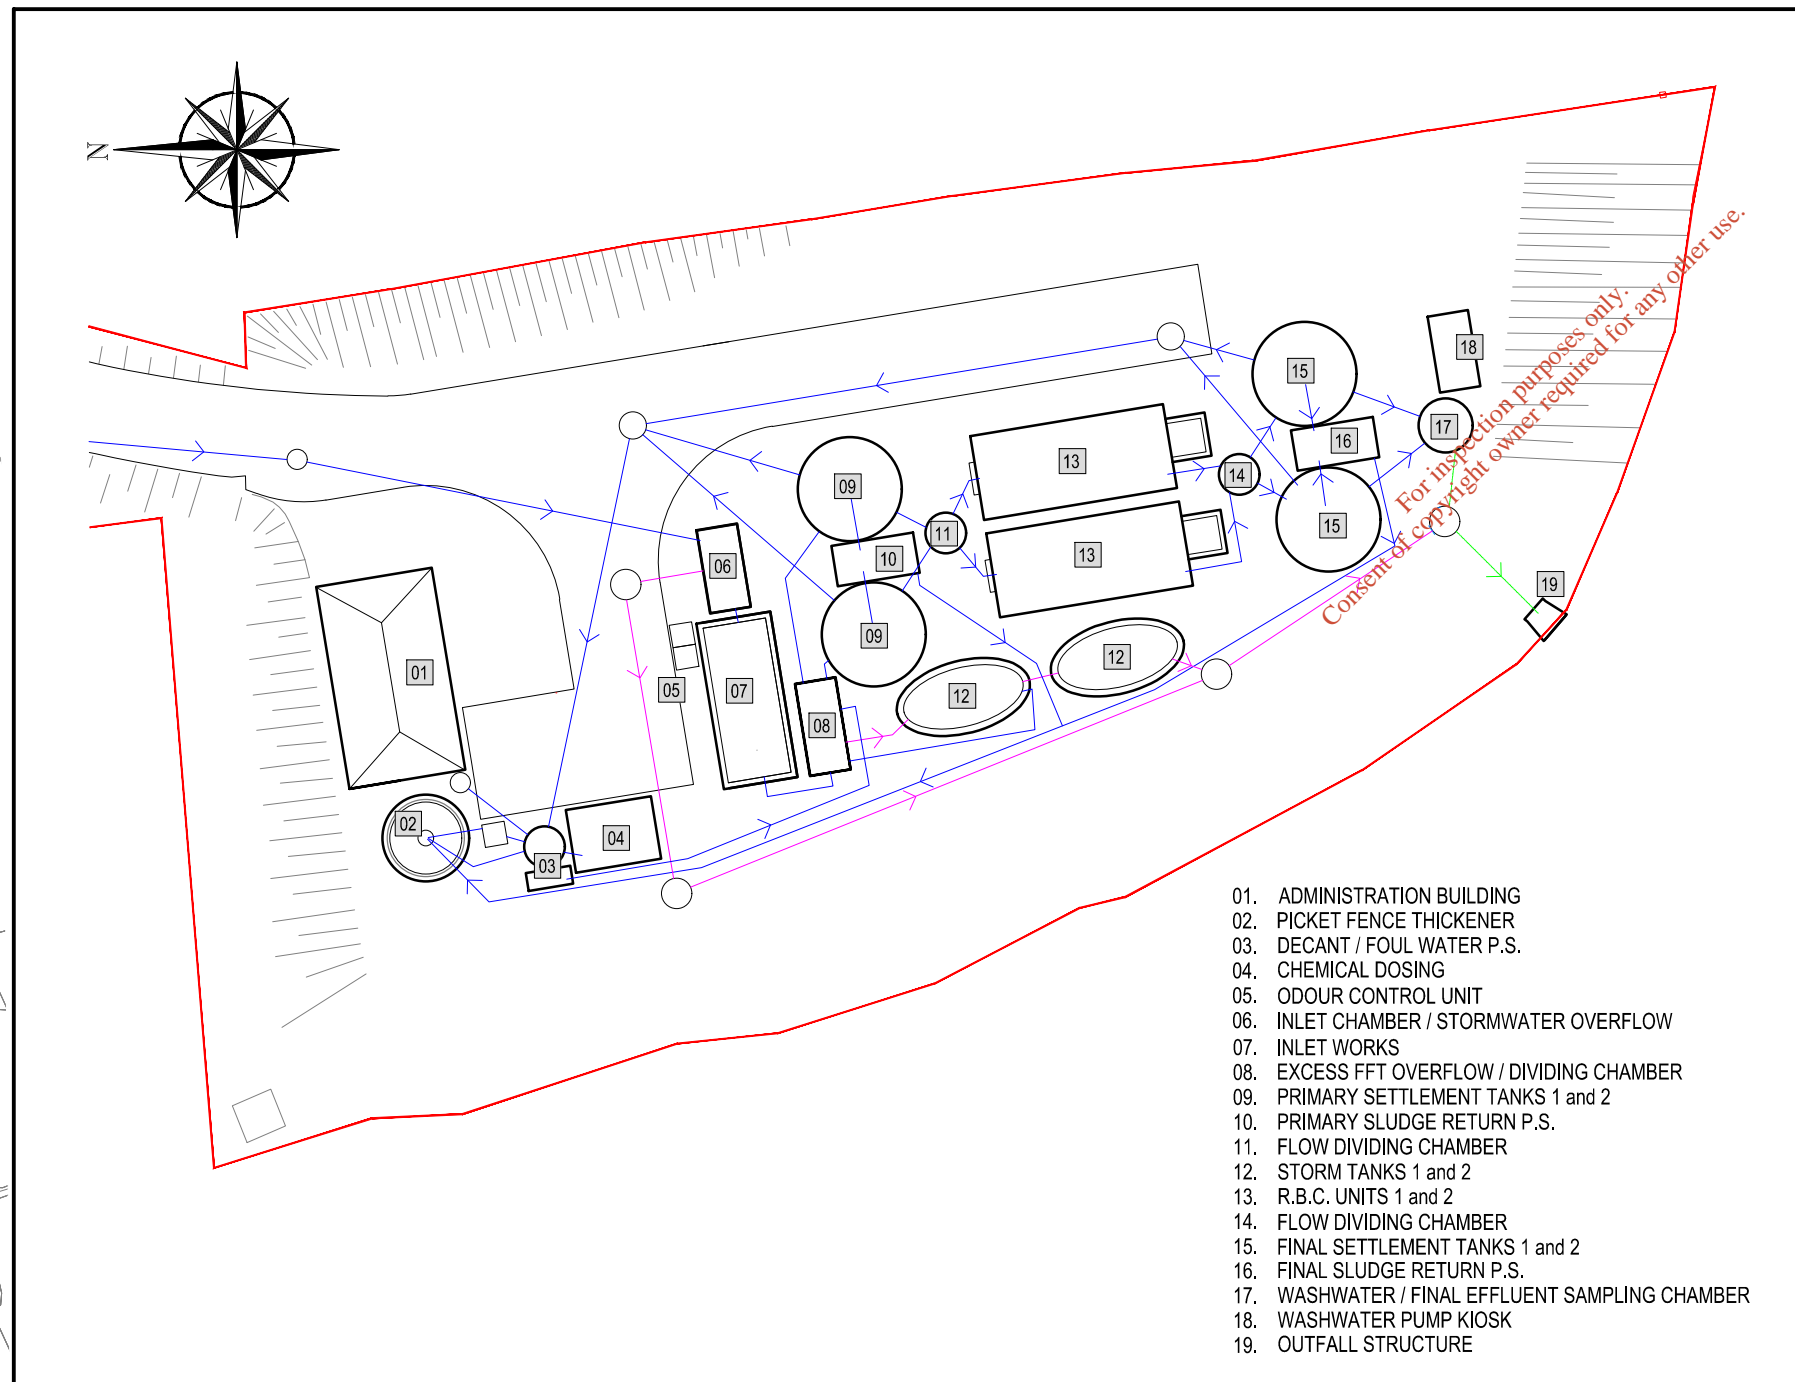

- 01. ADMINISTRATION BUILDING
- 02. PICKET FENCE THICKENER
- 03. DECANT / FOUL WATER P.S.
- 04. CHEMICAL DOSING
- 05. ODOUR CONTROL UNIT
- 06. INLET CHAMBER / STORMWATER OVERFLOW
- 07. INLET WORKS
- 08. EXCESS FFT OVERFLOW / DIVIDING CHAMBER
- 09. PRIMARY SETTLEMENT TANKS 1 and 2
- 10. PRIMARY SLUDGE RETURN P.S.
- 11. FLOW DIVIDING CHAMBER
- 12. STORM TANKS 1 and 2
- 13. R.B.C. UNITS 1 and 2
- 14. FLOW DIVIDING CHAMBER
- 15. FINAL SETTLEMENT TANKS 1 and 2
- 16. FINAL SLUDGE RETURN P.S.
- 17. WASHWATER / FINAL EFFLUENT SAMPLING CHAMBER
- 18. WASHWATER PUMP KIOSK
- 19. OUTFALL STRUCTURE

**WASTE WATER TREATMENT PLANT - SITE LAYOUT PLAN**  
 SCALE 1:333



REV	DATE	DESCRIPTION	D	C	A


**DISCHARGE LICENCE**

CLIENT  
**IRISH WATER**  
 Colvill House,  
 24-26 Talbot Street,  
 Dublin 1.  
 Tel. 1890 278 278 Web. www.water.ie



PROJECT  
**DRIPSEY**  
**WASTE WATER DISCHARGE**  
**LICENCE APPLICATION**

TITLE  
**MAP 3**  
**WwTP SITE LOCATION PLAN**

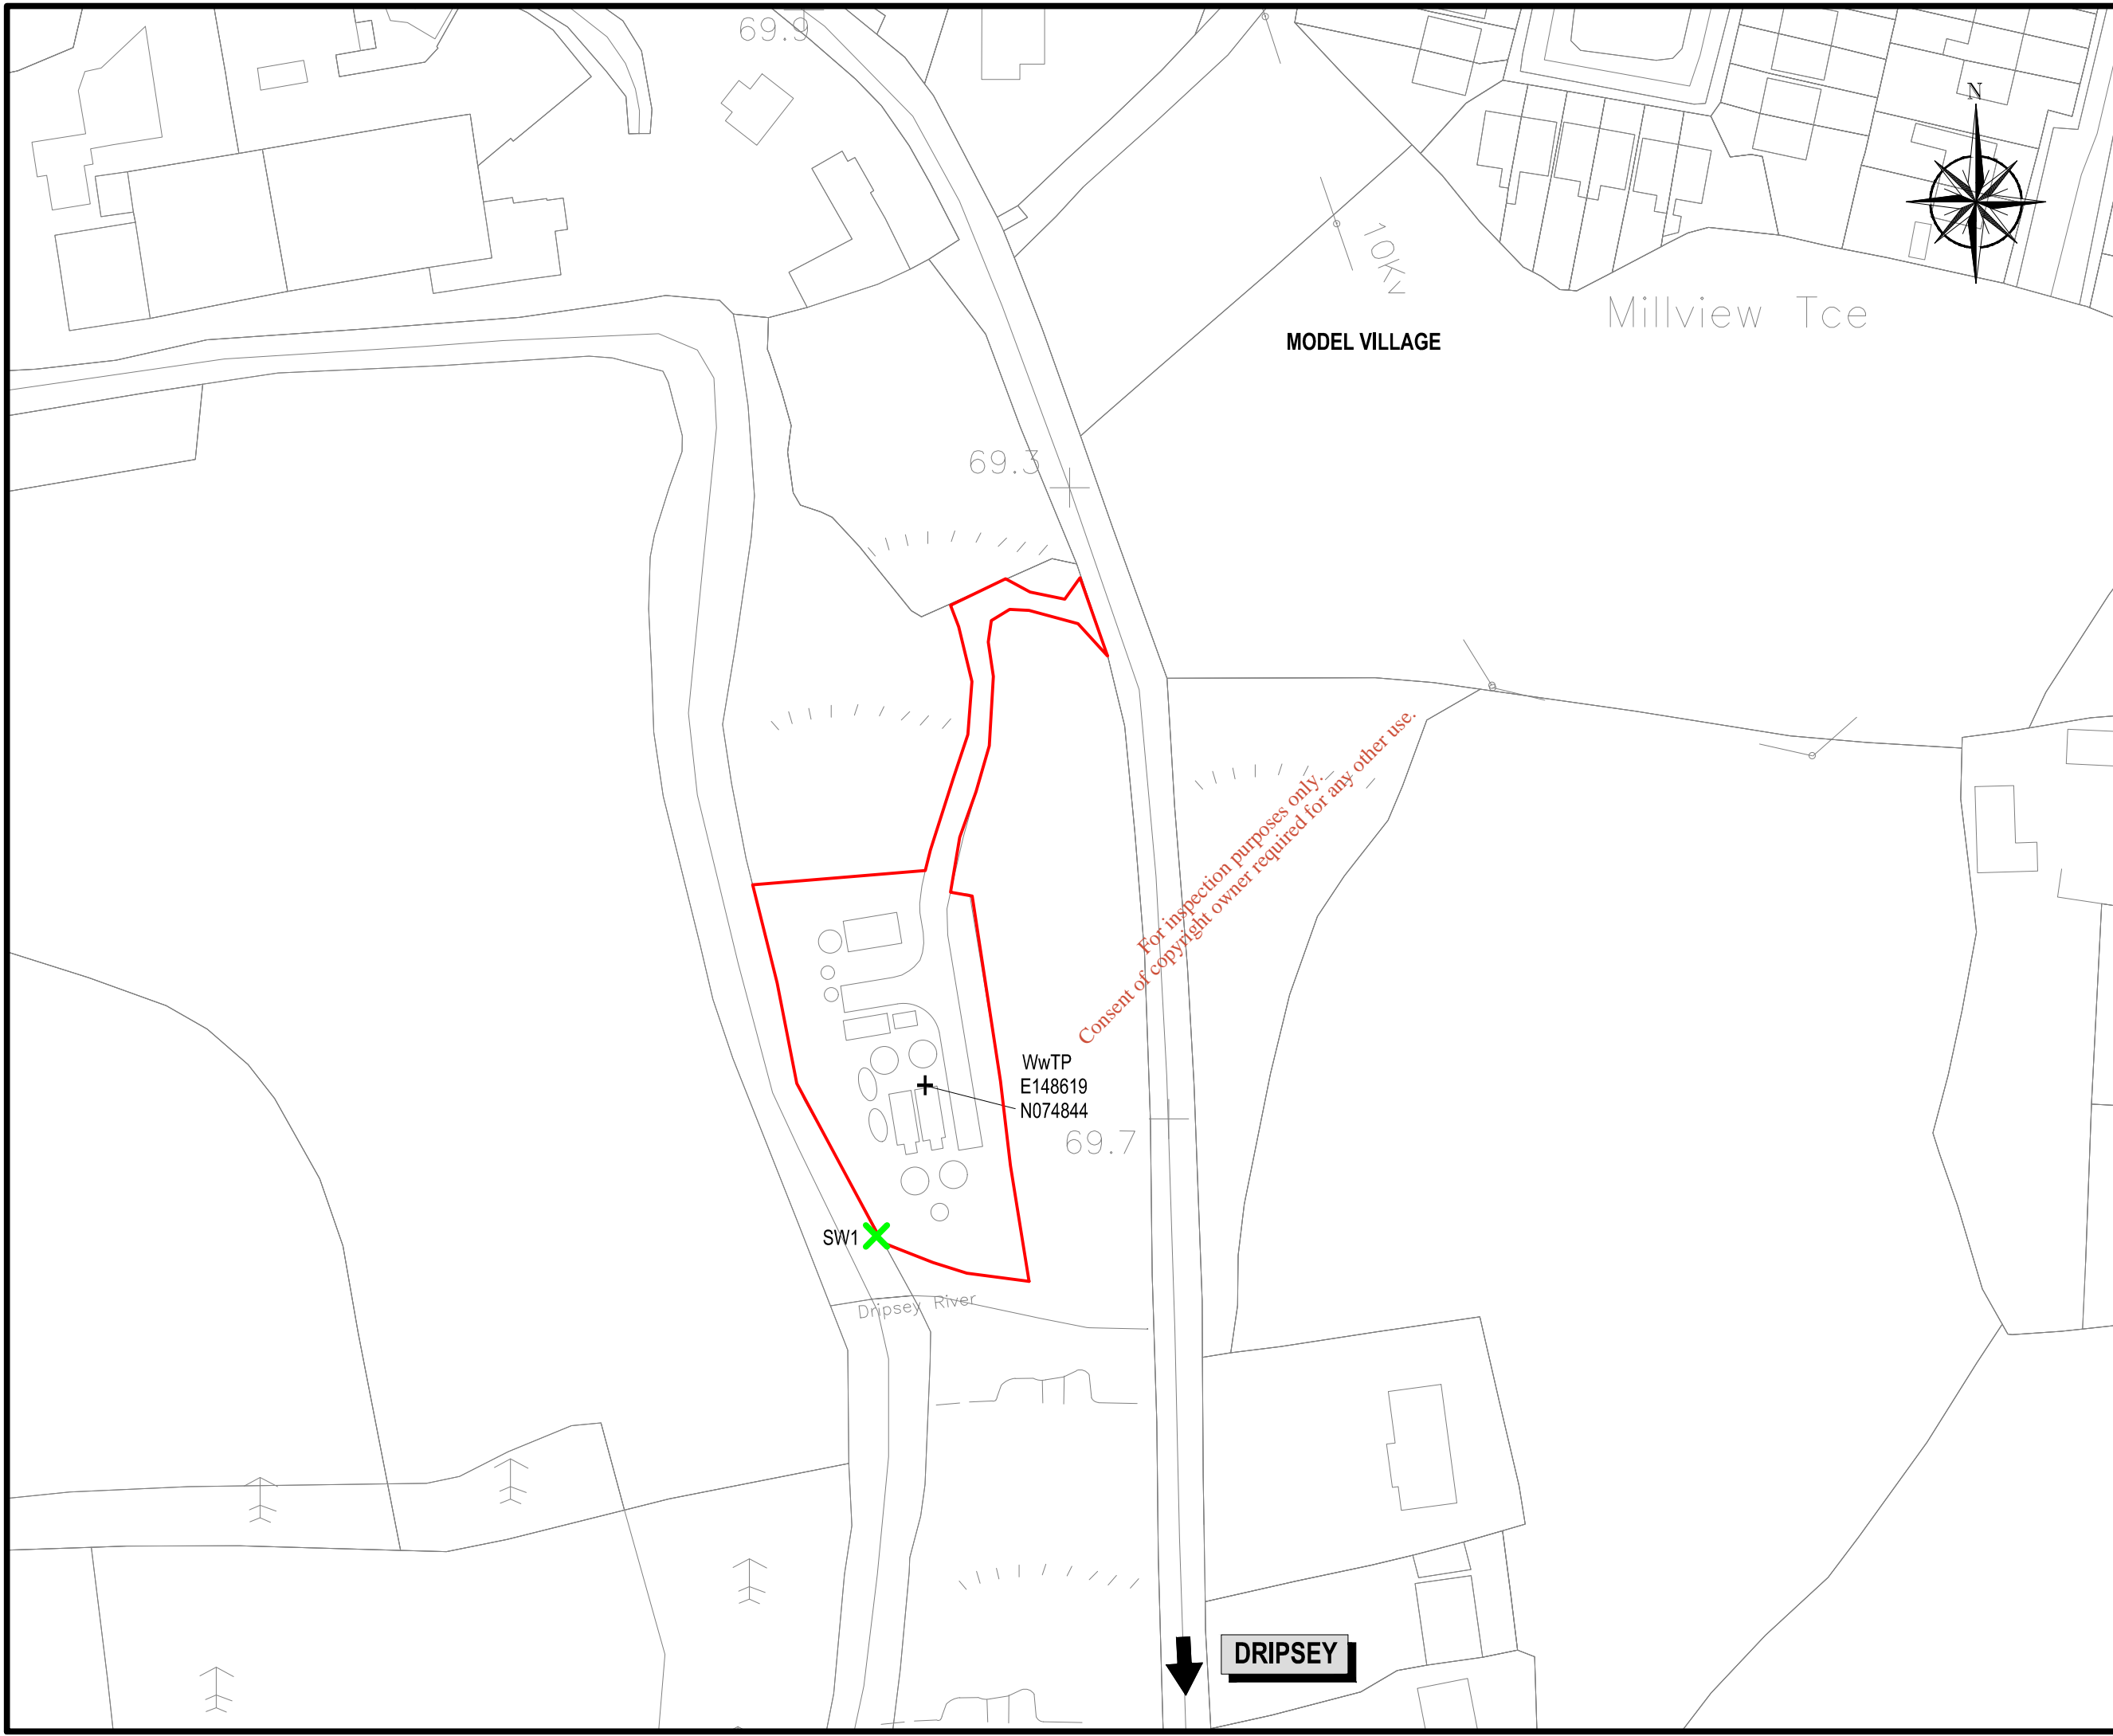SCALES 1:5,000 1:333	DRAWN D. Smithers DATE 02.12.2021	REV -
CAD REFERENCE 20893-NOD-WWDL-02	ATTACHMENT B.2.2	REV -



NOTES  
 Ordnance Survey Ireland Licence No. EN0083316  
 Copyright Ordnance Survey Ireland / Government of Ireland.

- LEGEND**
-  WWTP SITE BOUNDARY
  -  SW1 - PRIMARY DISCHARGE LOCATION

POINT	EASTING	NORTHING
SW1	148611	074819

SIGNED: \_\_\_\_\_

PRINT NAME: \_\_\_\_\_

POSITION: \_\_\_\_\_

DATE: \_\_\_\_\_

FOR IRISH WATER

REV	DATE	DESCRIPTION	D	C	A

**DISCHARGE LICENCE**


CLIENT  
 **IRISH WATER**  
 Colvill House,  
 24-26 Talbot Street,  
 Dublin 1.  
 Tel. 1890 278 278 Web. www.water.ie

PROJECT  
**DRIPSEY  
 WASTE WATER DISCHARGE  
 LICENCE APPLICATION**

TITLE  
**MAP 4  
 LOCATION OF  
 PRIMARY DISCHARGE POINT**

SCALES  
 1:1,000  
 DRAWN  
 D. Smithers  
 DATE  
 02.12.2021

CAD REFERENCE  
 20893-NOD-WWDL-02  
 ATTACHMENT  
**B.2.2**  
 REV  
 -

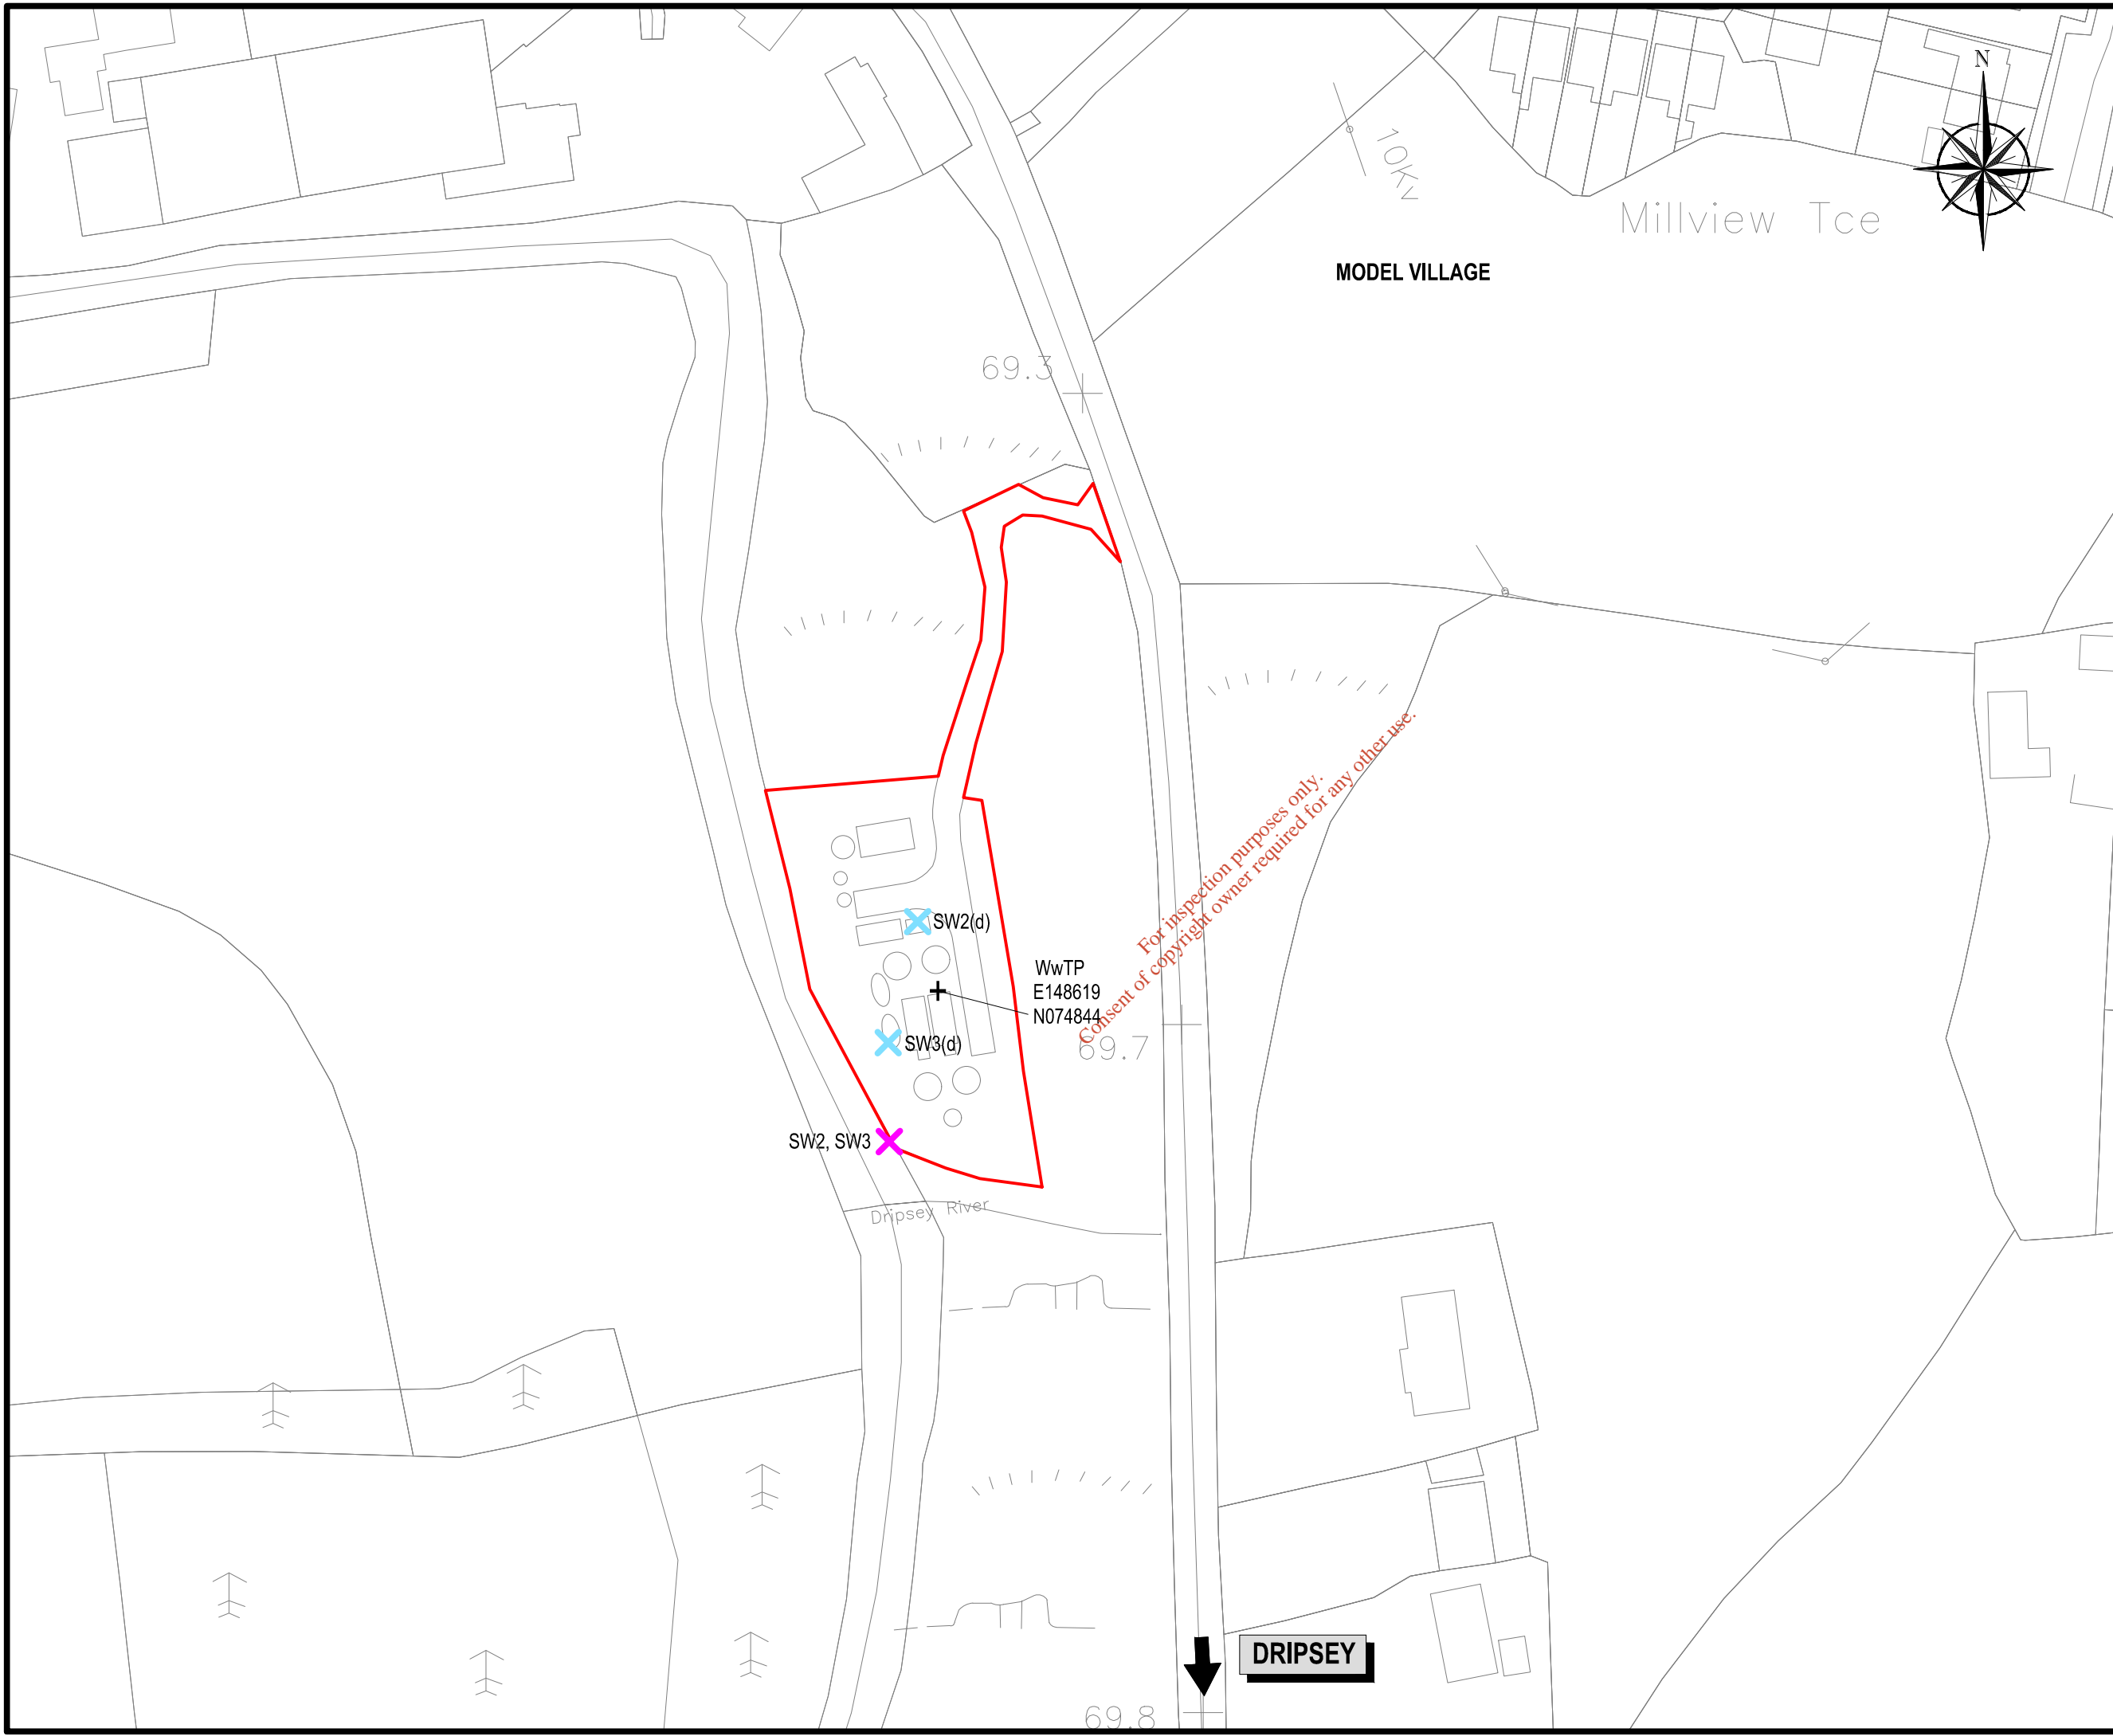

NOTES  
 Ordnance Survey Ireland Licence No. EN0083316  
 Copyright Ordnance Survey Ireland / Government of Ireland.

- LEGEND**
- WWTP SITE BOUNDARY
  - ✕ SWX, STORM WATER OVERFLOW
  - ✕ SWX(d), STORM WATER OVERFLOW DEVICE LOCATION

POINT	EASTING	NORTHING
SW2	148611	074819
SW2(d)	148616	074855
SW3	148611	074819
SW3(d)	148611	074835

SIGNED : \_\_\_\_\_

PRINT NAME : \_\_\_\_\_

POSITION : \_\_\_\_\_

DATE : \_\_\_\_\_

FOR IRISH WATER

REV	DATE	DESCRIPTION	D	C	A

**DISCHARGE LICENCE**

CLIENT  
**IRISH WATER**  
 Colvill House,  
 24-26 Talbot Street,  
 Dublin 1.  
 Tel. 1890 278 278 Web. www.water.ie

PROJECT  
**DRIPSEY  
 WASTE WATER DISCHARGE  
 LICENCE APPLICATION**

TITLE  
**MAP 5  
 LOCATION OF  
 STORM WATER OVERFLOWS**

SCALES  
 1:1,000

DRAWN  
 D. Smithers


DATE  
 02.12.2021

CAD REFERENCE  
 20893-NOD-WWDL-02

ATTACHMENT  
**B.2.2**



REV  
 -

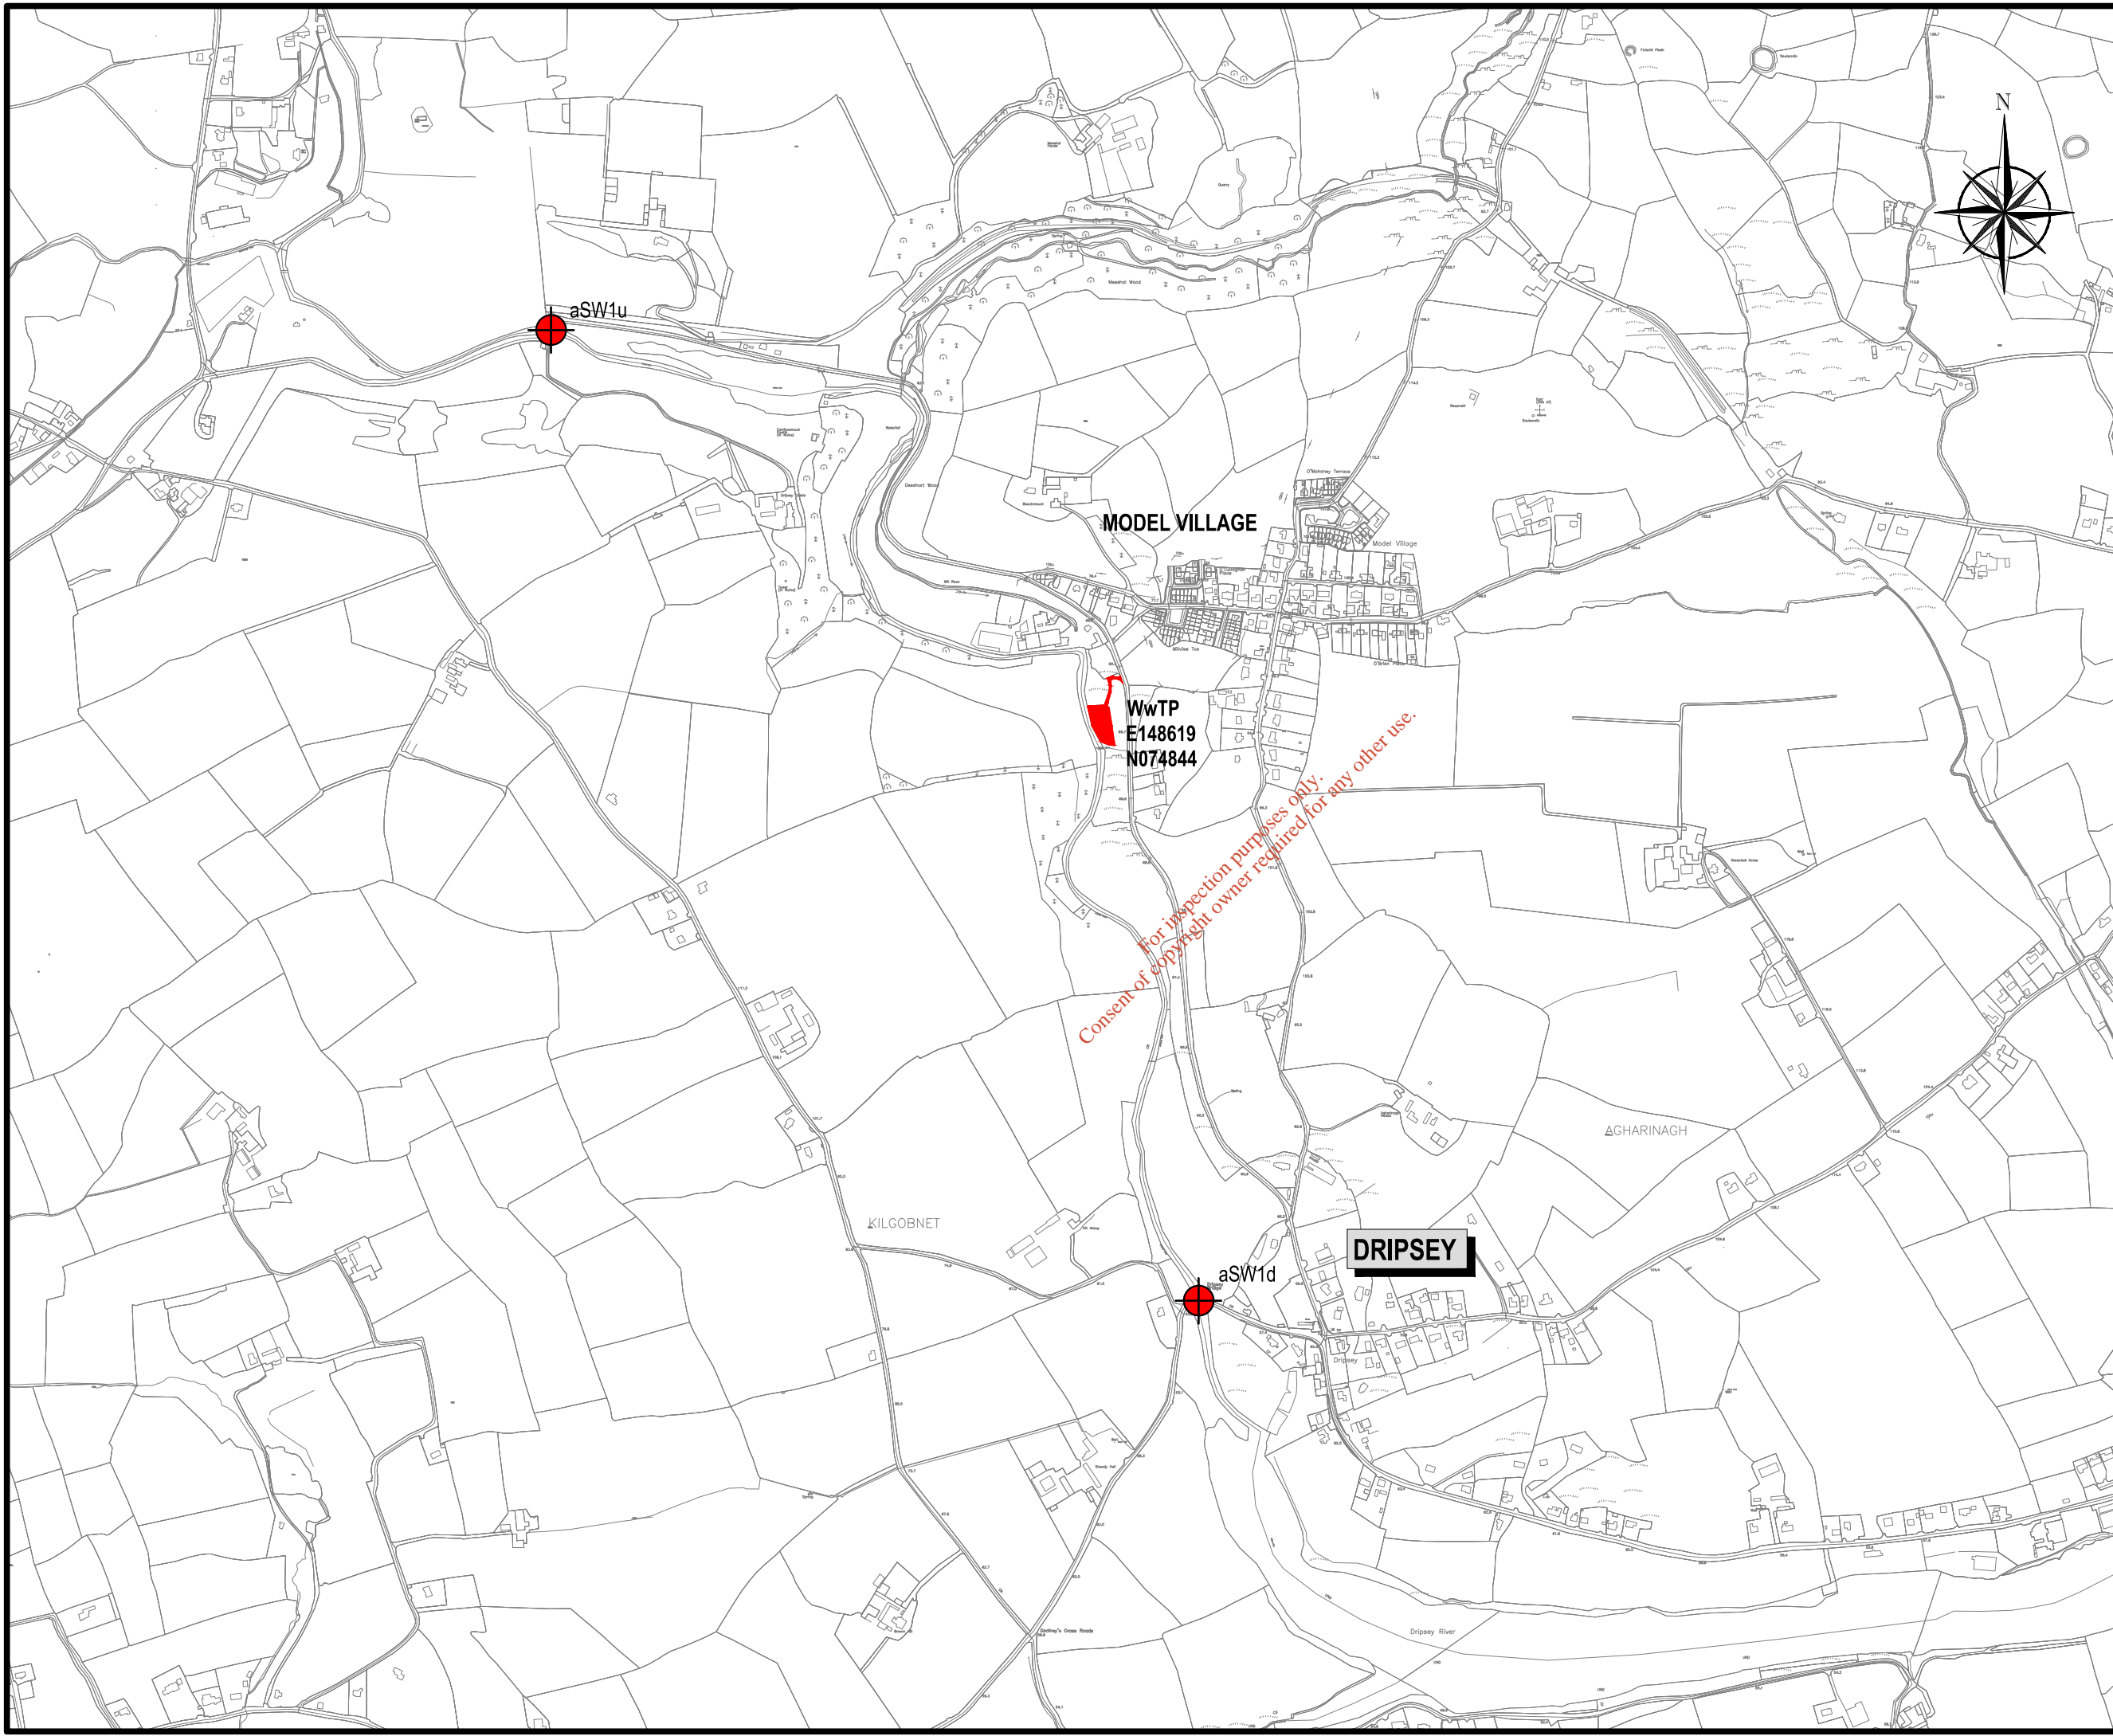



NOTES  
 Ordnance Survey Ireland Licence No. EN0083316  
 Copyright Ordnance Survey Ireland / Government of Ireland.

**LEGEND**

-  WwTP SITE LOCATION
-  aSW1x - AMBIENT MONITORING LOCATION

POINT	EASTING	NORTHING
aSW1u	147700	075502
aSW1d	148775	073890

SIGNED : \_\_\_\_\_

PRINT NAME : \_\_\_\_\_

POSITION : \_\_\_\_\_

DATE : \_\_\_\_\_

FOR IRISH WATER

REV	DATE	DESCRIPTION	D	C	A

**DISCHARGE LICENCE**


CLIENT  
 **IRISH WATER**  
 Colvill House,  
 24-26 Talbot Street,  
 Dublin 1.  
 Tel. 1890 278 278 Web. www.water.ie

PROJECT  
**DRIPSEY  
 WASTE WATER DISCHARGE  
 LICENCE APPLICATION**

TITLE  
**MAP 6  
 LOCATION OF  
 AMBIENT MONITORING POINTS**

SCALES  
 1:10,000  
 DRAWN  
 D. Smithers  
 DATE  
 02.12.2021

CAD REFERENCE  
 20893-NOD-WWDL-02  
 ATTACHMENT  
**B.2.2**  
 REV  
 -

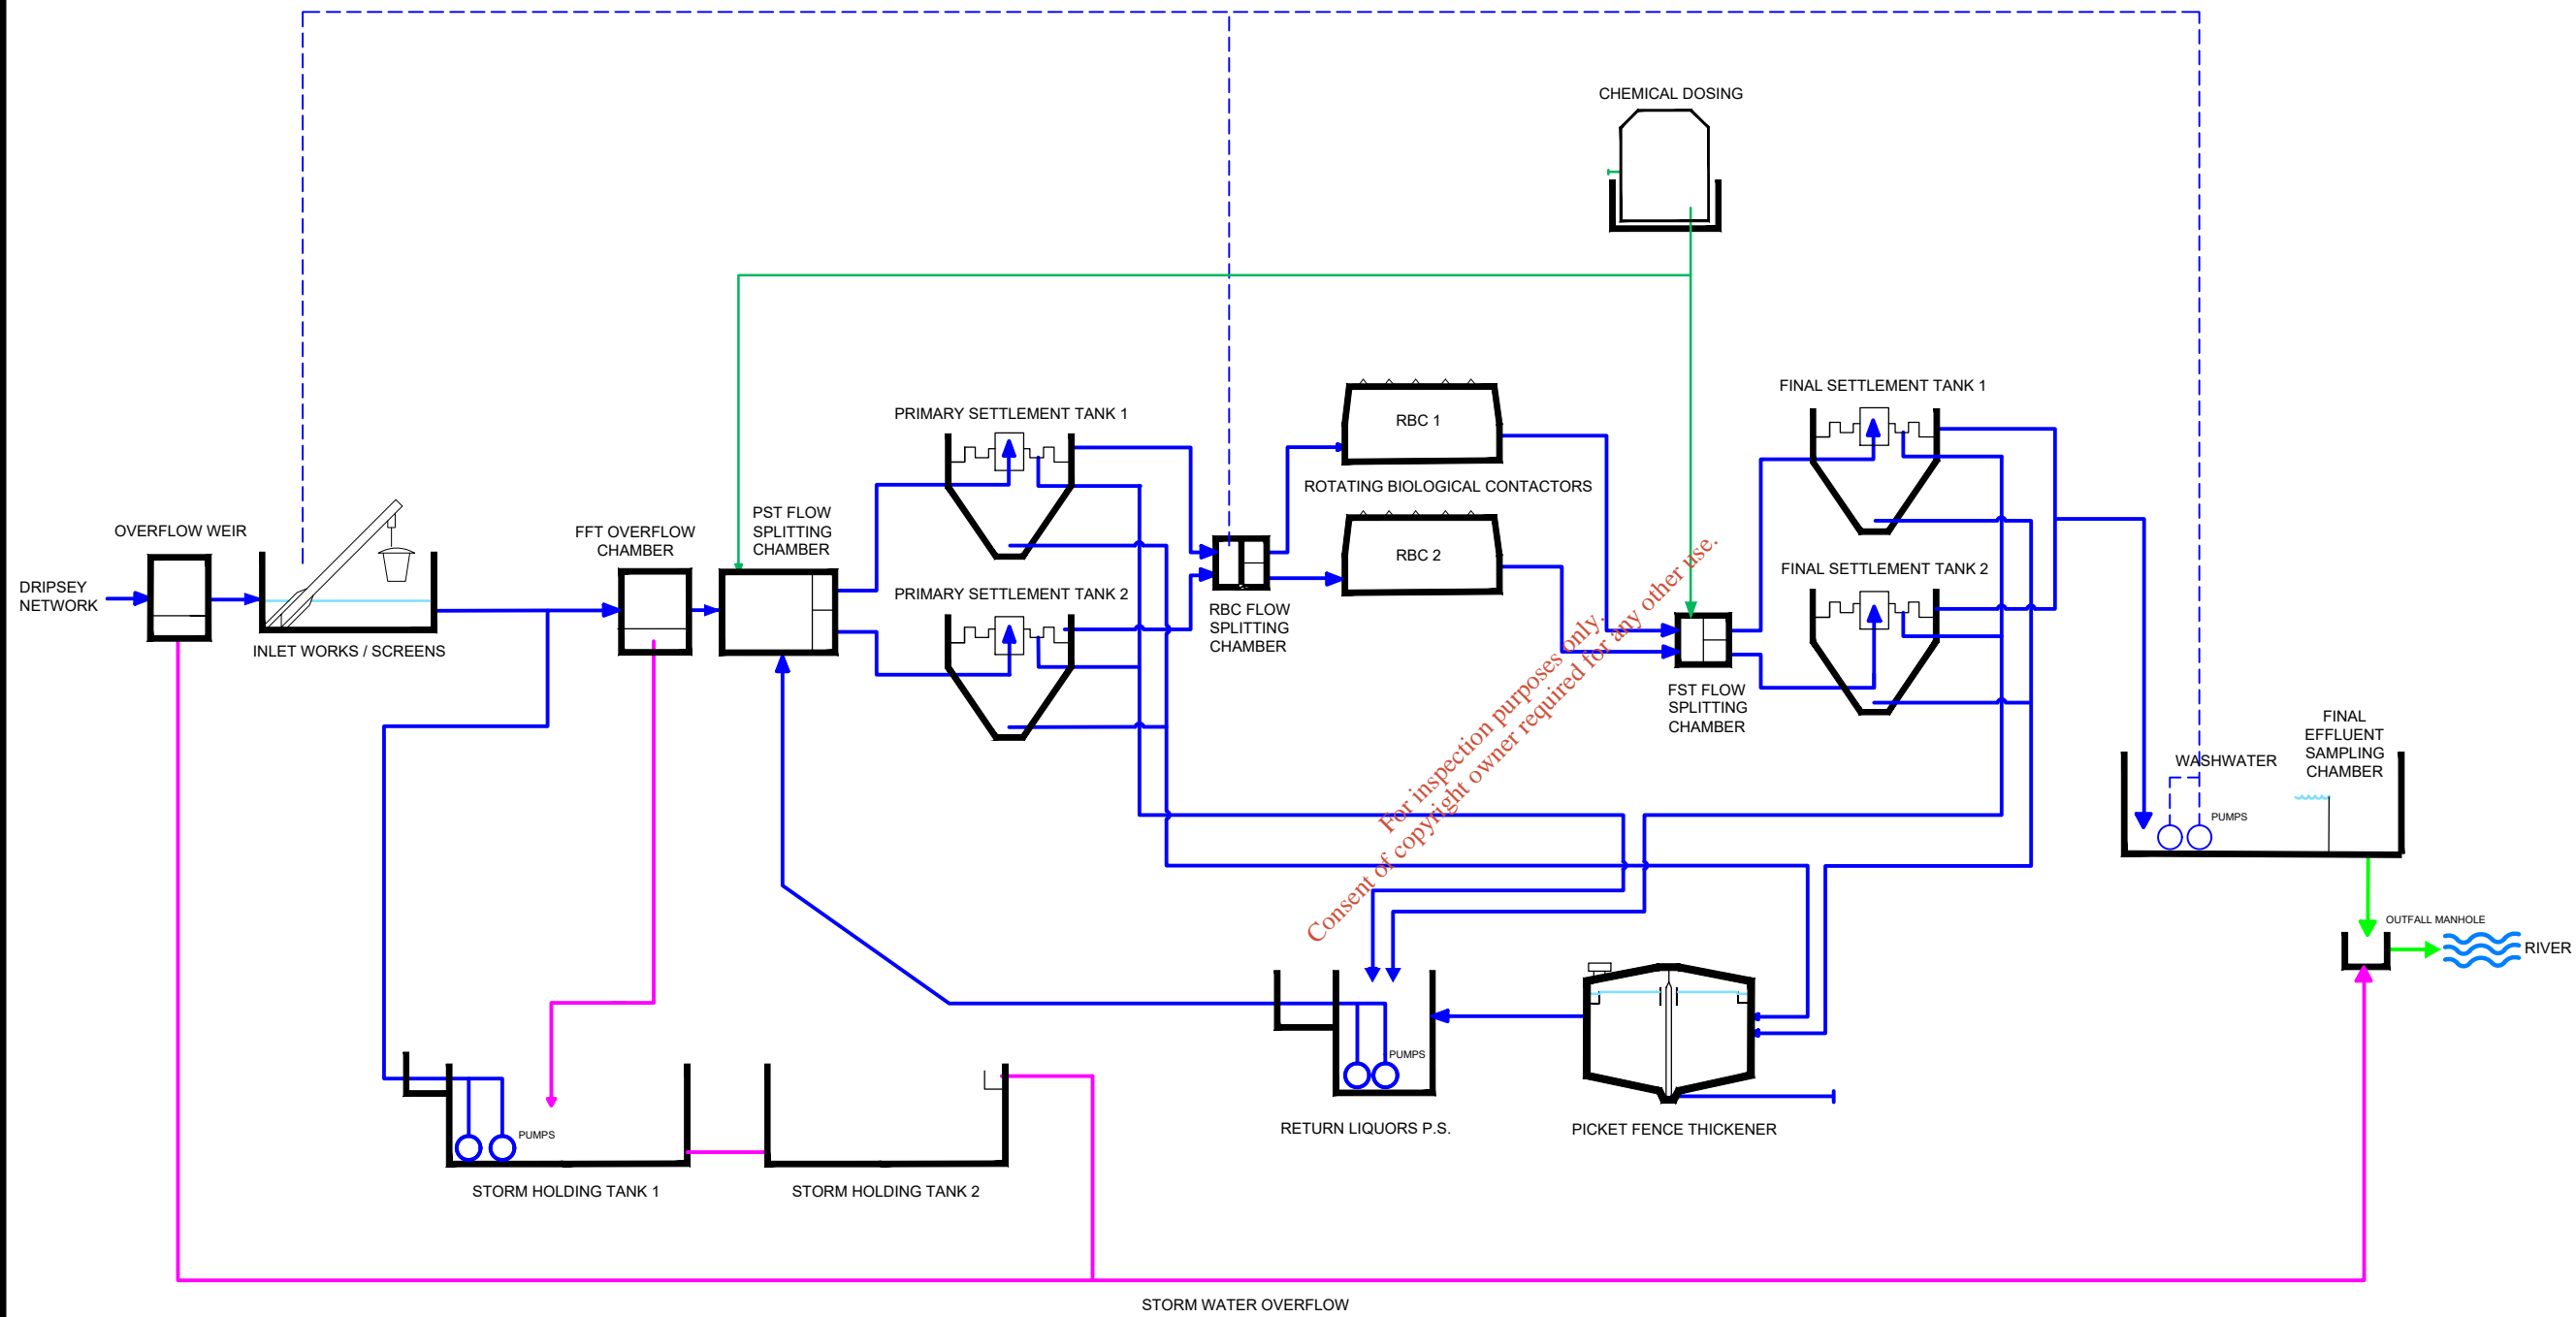

SIGNED: \_\_\_\_\_

PRINT NAME: \_\_\_\_\_

POSITION: \_\_\_\_\_

DATE: \_\_\_\_\_

FOR IRISH WATER

REV	DATE	DESCRIPTION	D	C	A

**DISCHARGE LICENCE**

CLIENT  
 **IRISH WATER**  
 Colvill House,  
 24-26 Talbot Street,  
 Dublin 1.  
 Tel. 1890 278 278 Web. www.water.ie

PROJECT  
**DRIPSEY  
 WASTEWATER DISCHARGE  
 LICENCE APPLICATION**

TITLE  
**WASTE WATER  
 PROCESS FLOW DIAGRAM**

SCALES  
 N.T.S.

DRAWN  
**D. Smithers**  
 DATE  
 02.12.2021

CAD REFERENCE  
 20893-NOD-WWDL-02

ATTACHMENT  
**B.2.3**

REV  
 -