


Key Plan

LEGEND:

- SITE BOUNDARY
- SECURITY FENCE
- 110 KV DARNDALE SUBSTATION
- ROAD SURFACE
- BUILDINGS

NOTES:
DRAWINGS ARE NOT TO BE SCALED.
DRAWINGS ARE FOR THE PURPOSE OF THE EPA LICENCE.
NOT FOR CONSTRUCTION

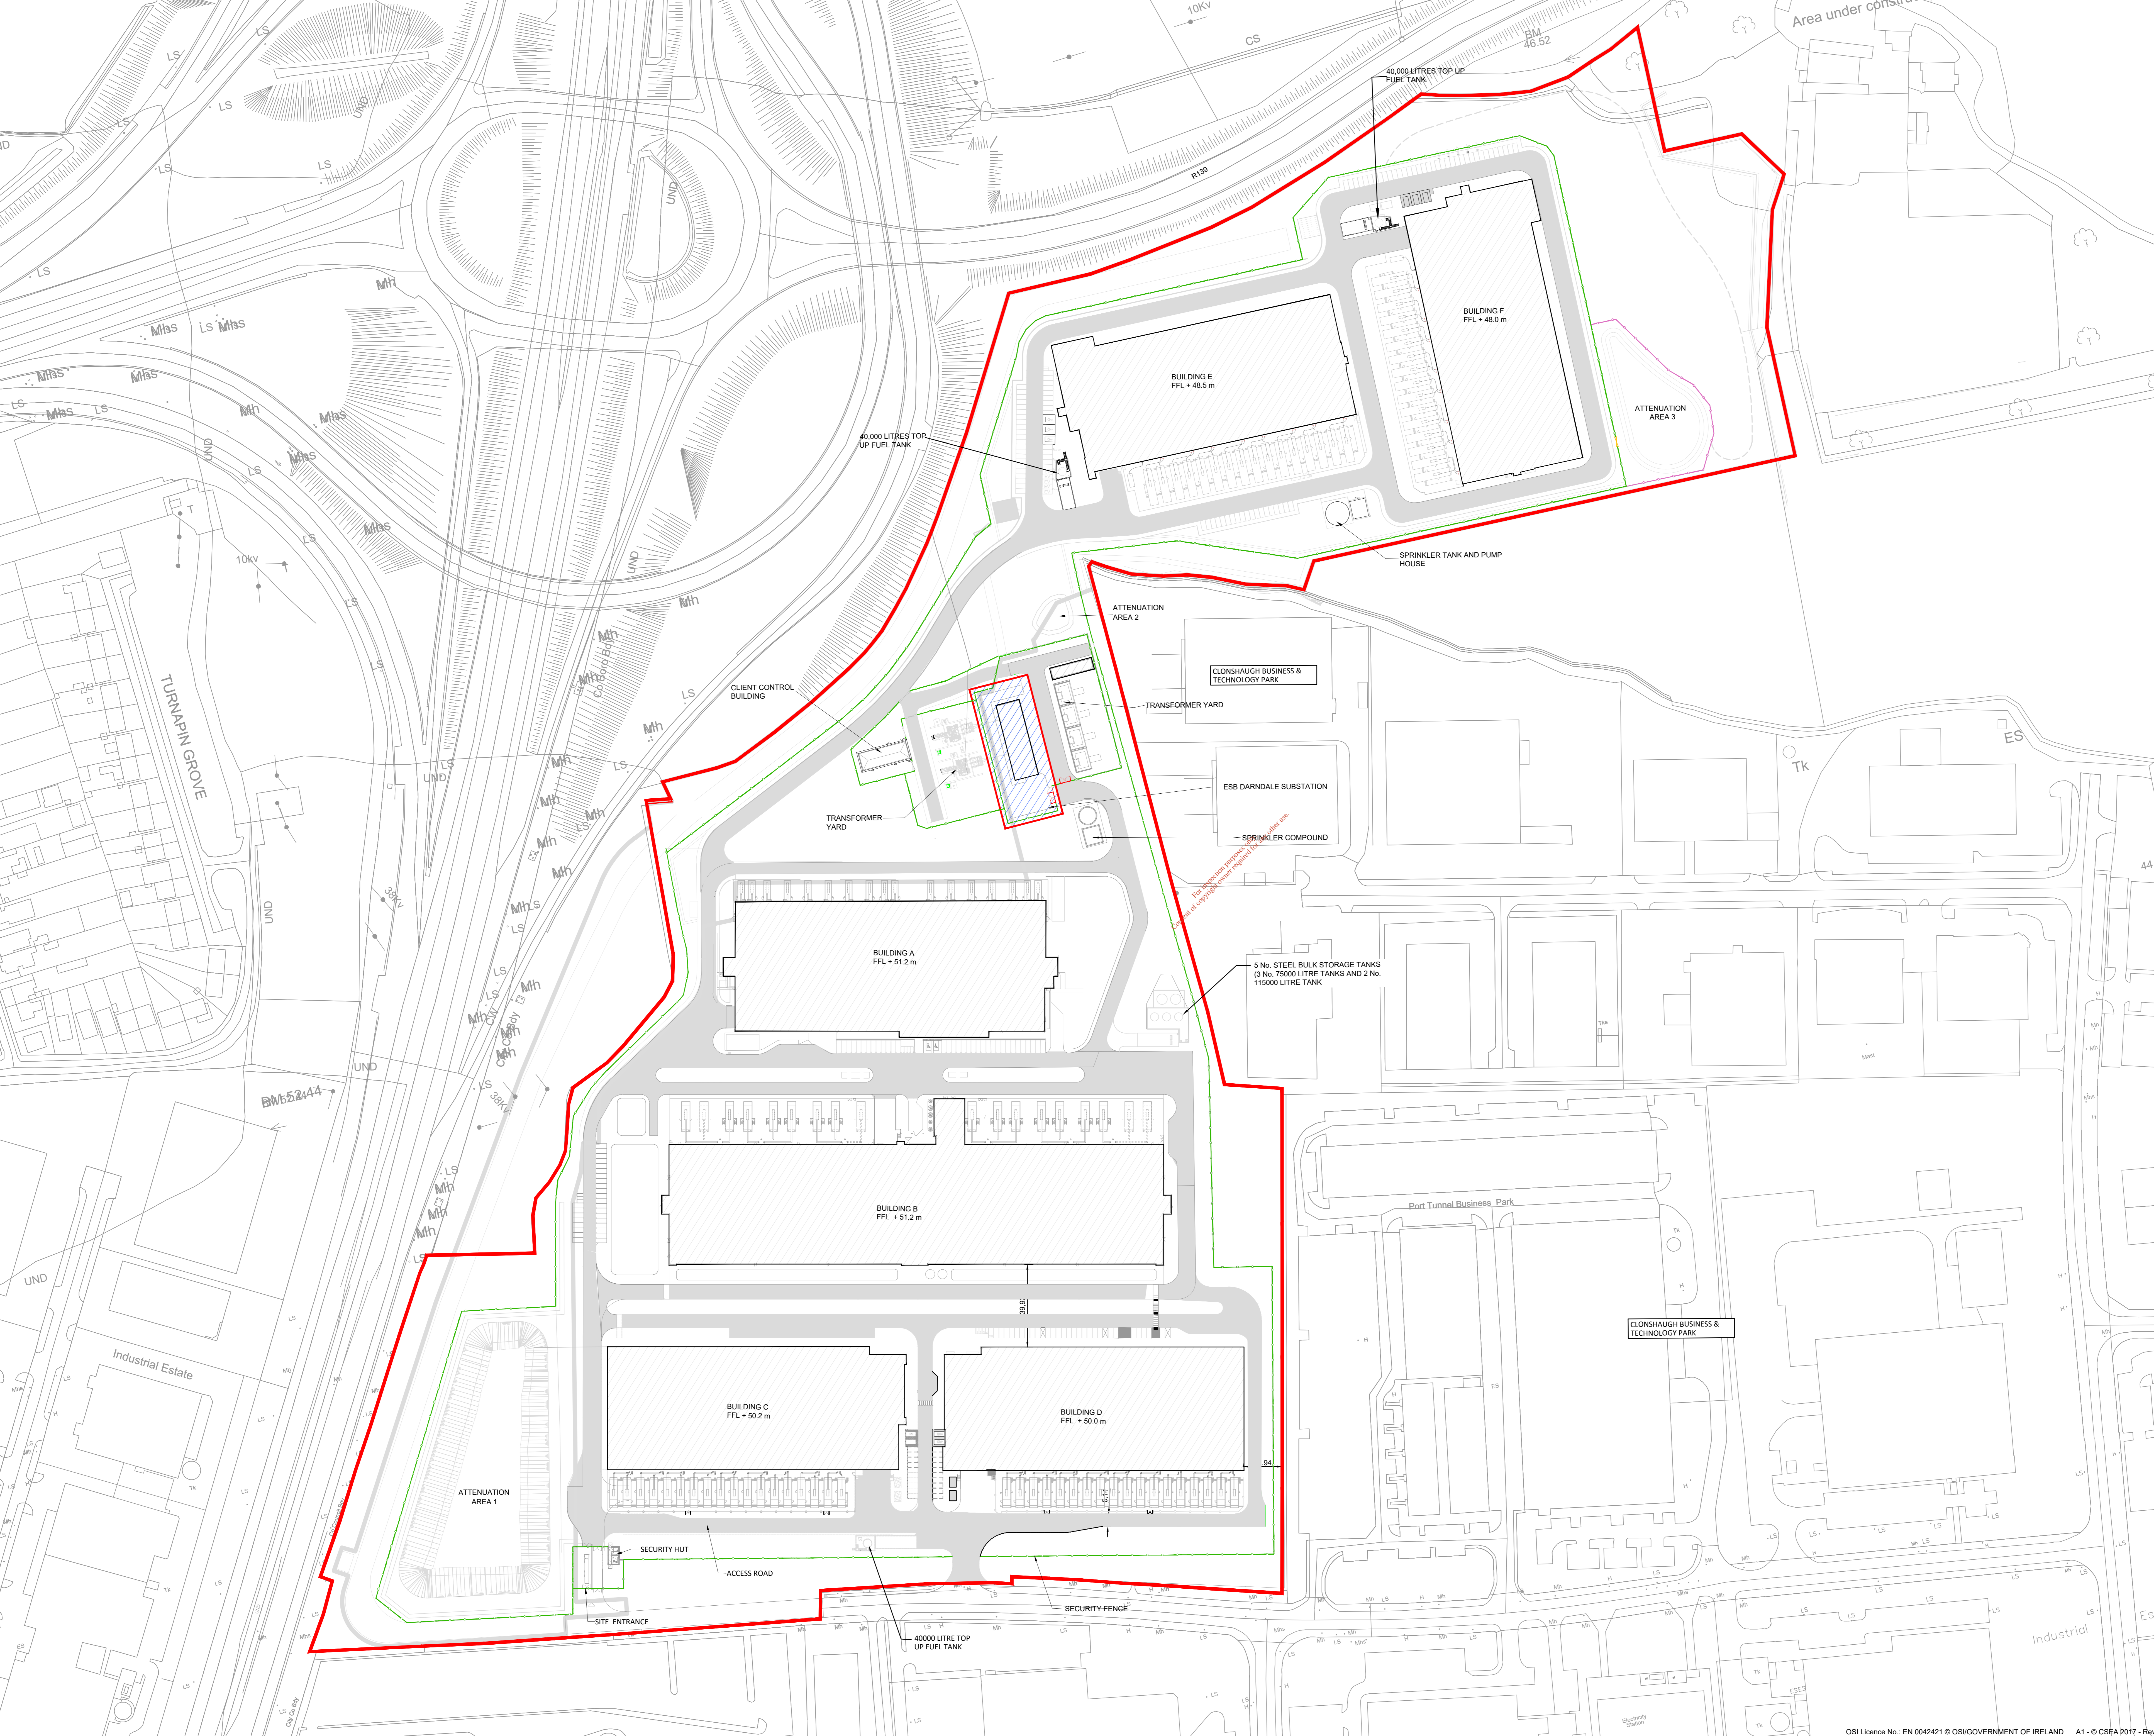

C01	EPA-ISSUE	DB	PM	17/12/2021
PL01	FOR DISCUSSION	DB	PM	22/10/2021
Revision	Description	Drawn	Chk'd	Date

Clifton Scannell Emerson Associates Limited
Consulting Engineers,
Seafor Lodge,
Castledown Avenue,
Blackrock, Co. Dublin,
Ireland.
T: +353 1 288 5006
F: +353 1 283 9464
E: info@csea.ie
W: www.csea.ie

Client: ADSIL
Project: Environmental license drawings Clonshaugh campus.
Dwg Title: Site Plan
Drawn By: DB Date: 22-10-2018
Checked by: PM Scale: 1:1000 @ A0
Project Code: 21_123 - CSE - 00 - XX - DR - C - 4004

Status Code	Suitability Description	18_141
C01	EPA-ISSUE	
Revision	Project Status	CSEA Job No.