


EXISTING FIRE ACCESS ROAD

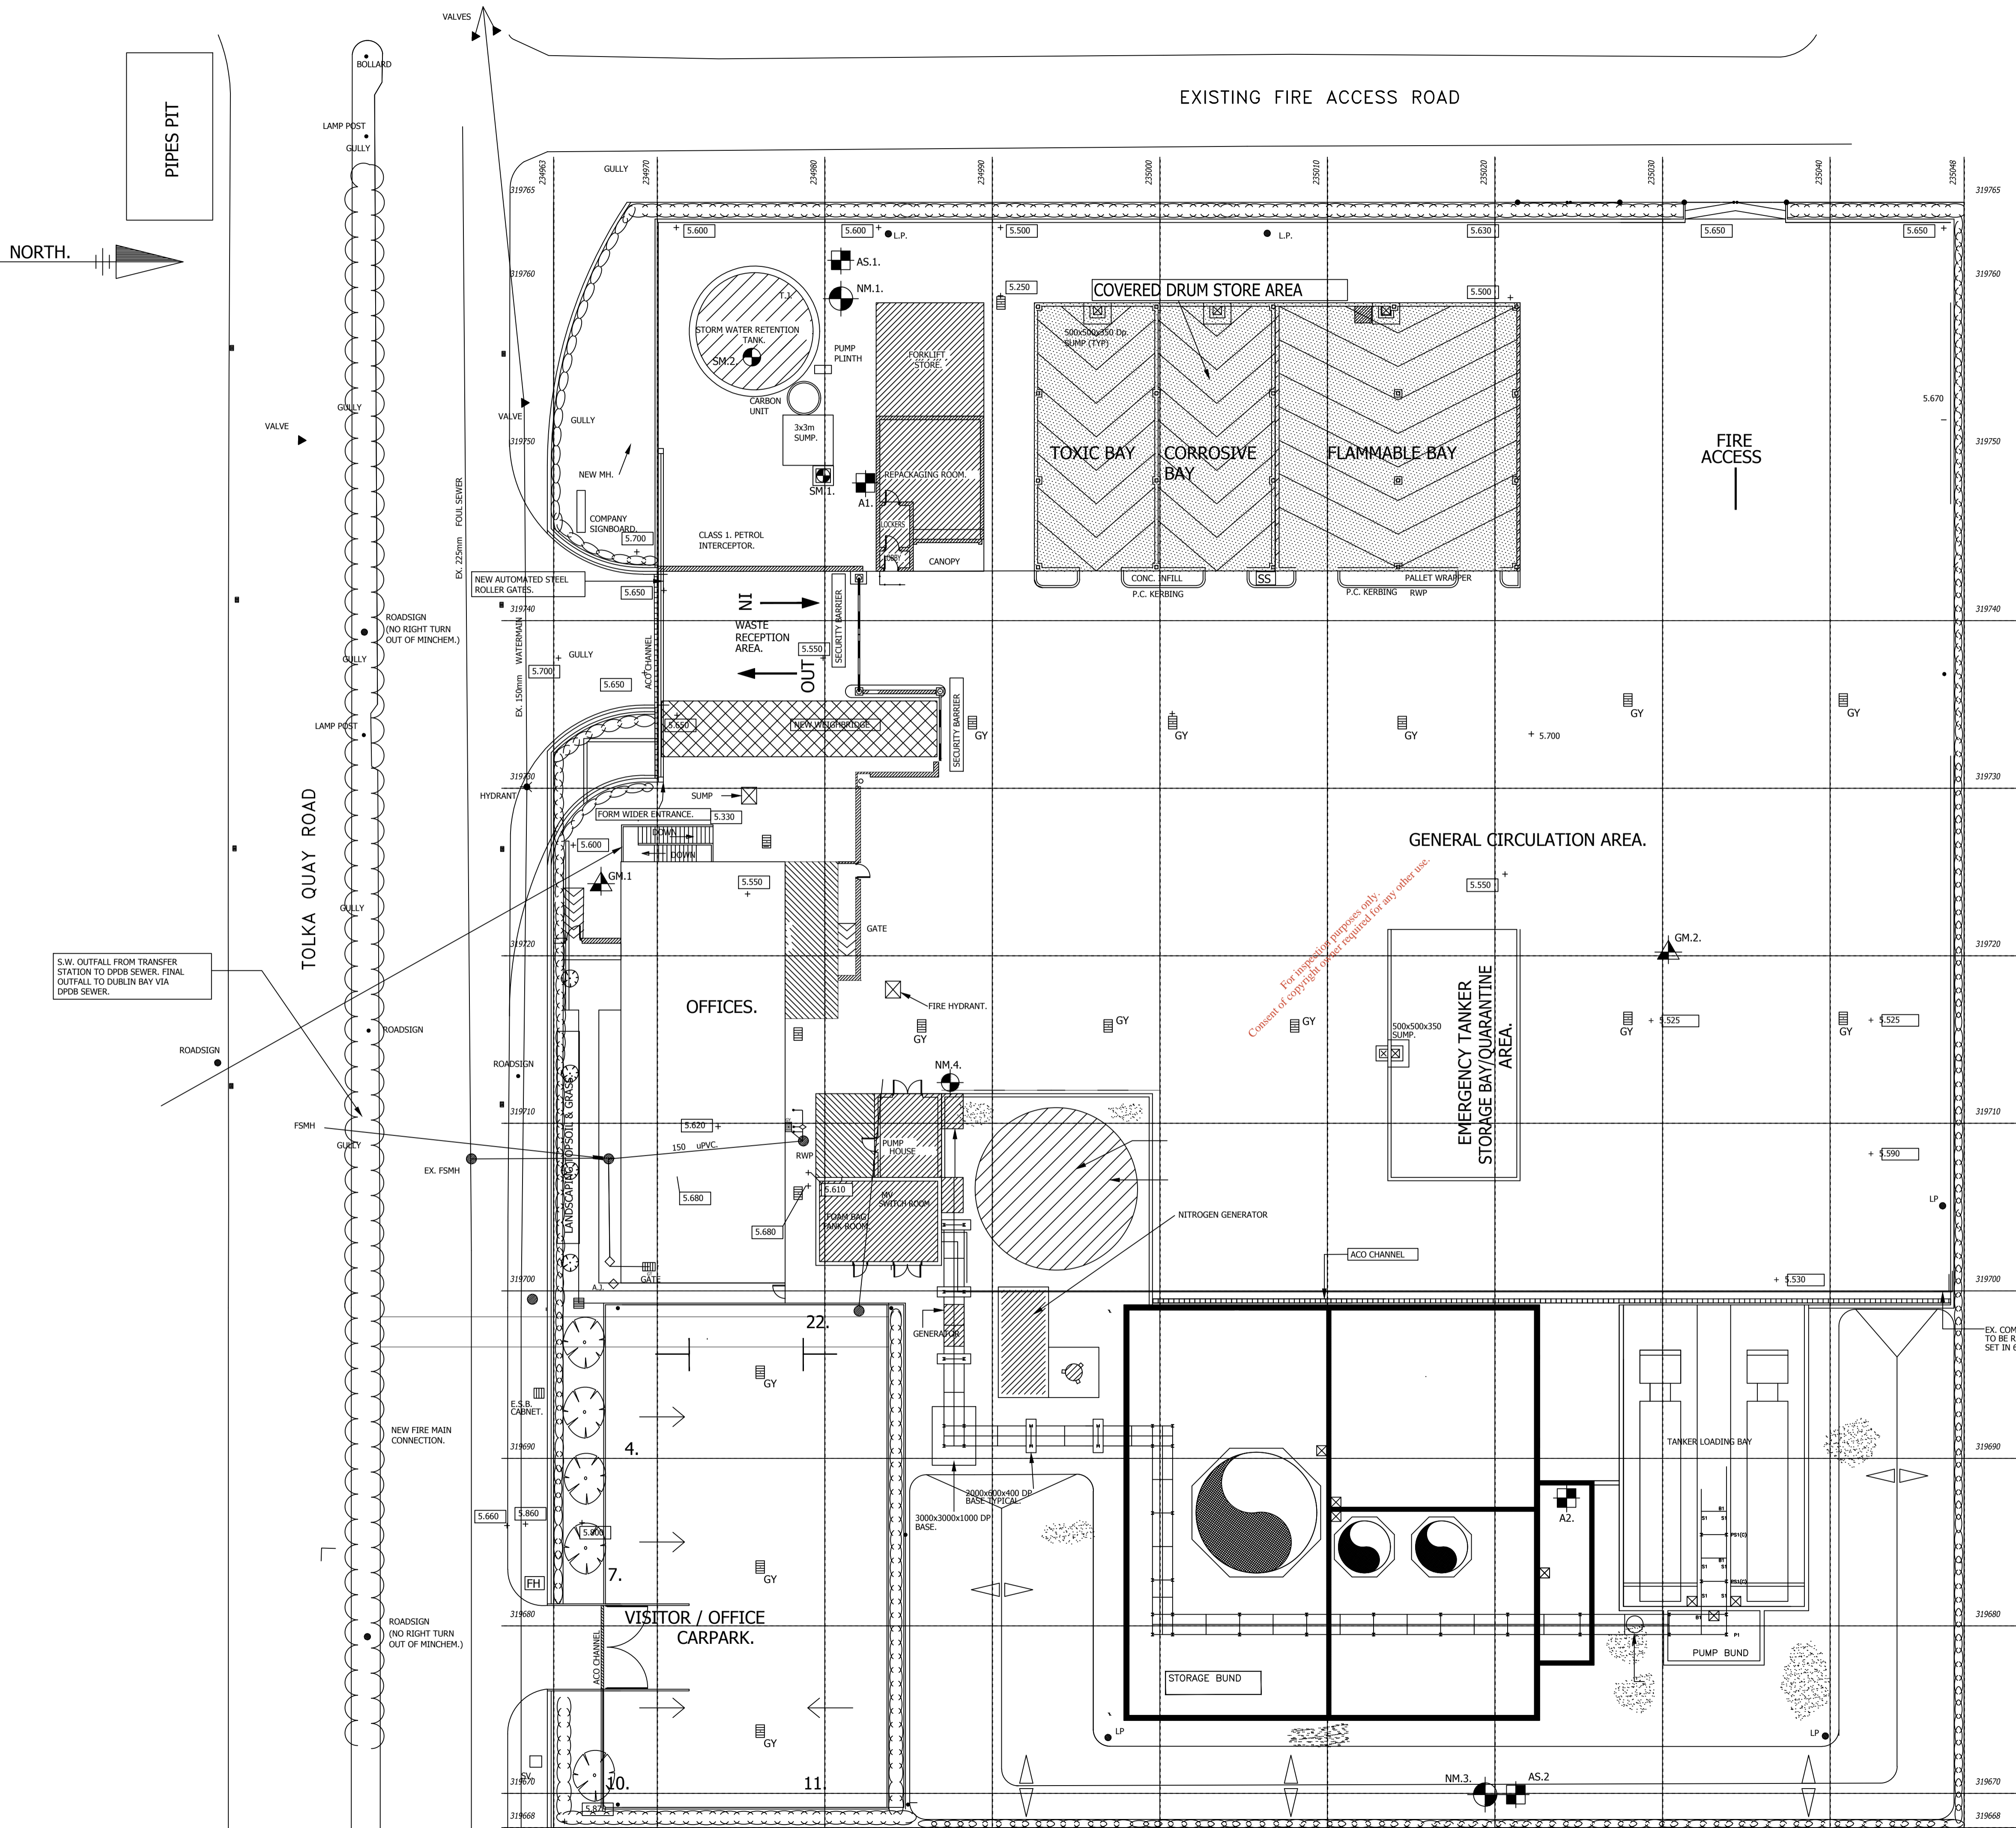

LEGEND.

- SURFACE WATER MONITORING POINTS.
- NOISE MONITORING POINTS.
- GROUND WATER MONITORING POINTS.
- AIR MONITORING POINTS.

For installation purposes only.
Consent of copyright owner required for any other use.

PROPOSED SITE PLAN. SCALE 1:200

IND-DPO-HSE-DWG-000-0120

D	GM1 REVISED LOCATION ISSUED TO EPA	C.J	PMG	JUL 06
C	GM1 REVISED DRAFT FOR COMMENT	C.J	PMG	JUL 06
F	MOD19	NCI		FEB 18
E	MOD17	NCI		FEB 18
REV.	DESCRIPTION.	BY.	APPR.	DATE.

CLIENT: **INDAVER IRELAND LIMITED**

PROJECT: **TRANSFER STATION AND FUEL BLENDING FACILITY**

TITLE: **MONITORING POINTS LAYOUT SITE PLAN**

McElroy Associates
Consulting Engineers

72 Haddington Road, Ballsbridge, D4.
Tel: 660 9000 Fax: 660 9099
E Mail: info@mea.ie

DESIGNED:	CHECKED:	APPRD:
DRAWN:	DATE: July 06	SCALE: AS SHOWN

IE-DPO-HSE-DWG-000-0120 REV. F