




ATTACHMENT B.2.3:

WASTE WATER PROCESS FLOW DIAGRAM

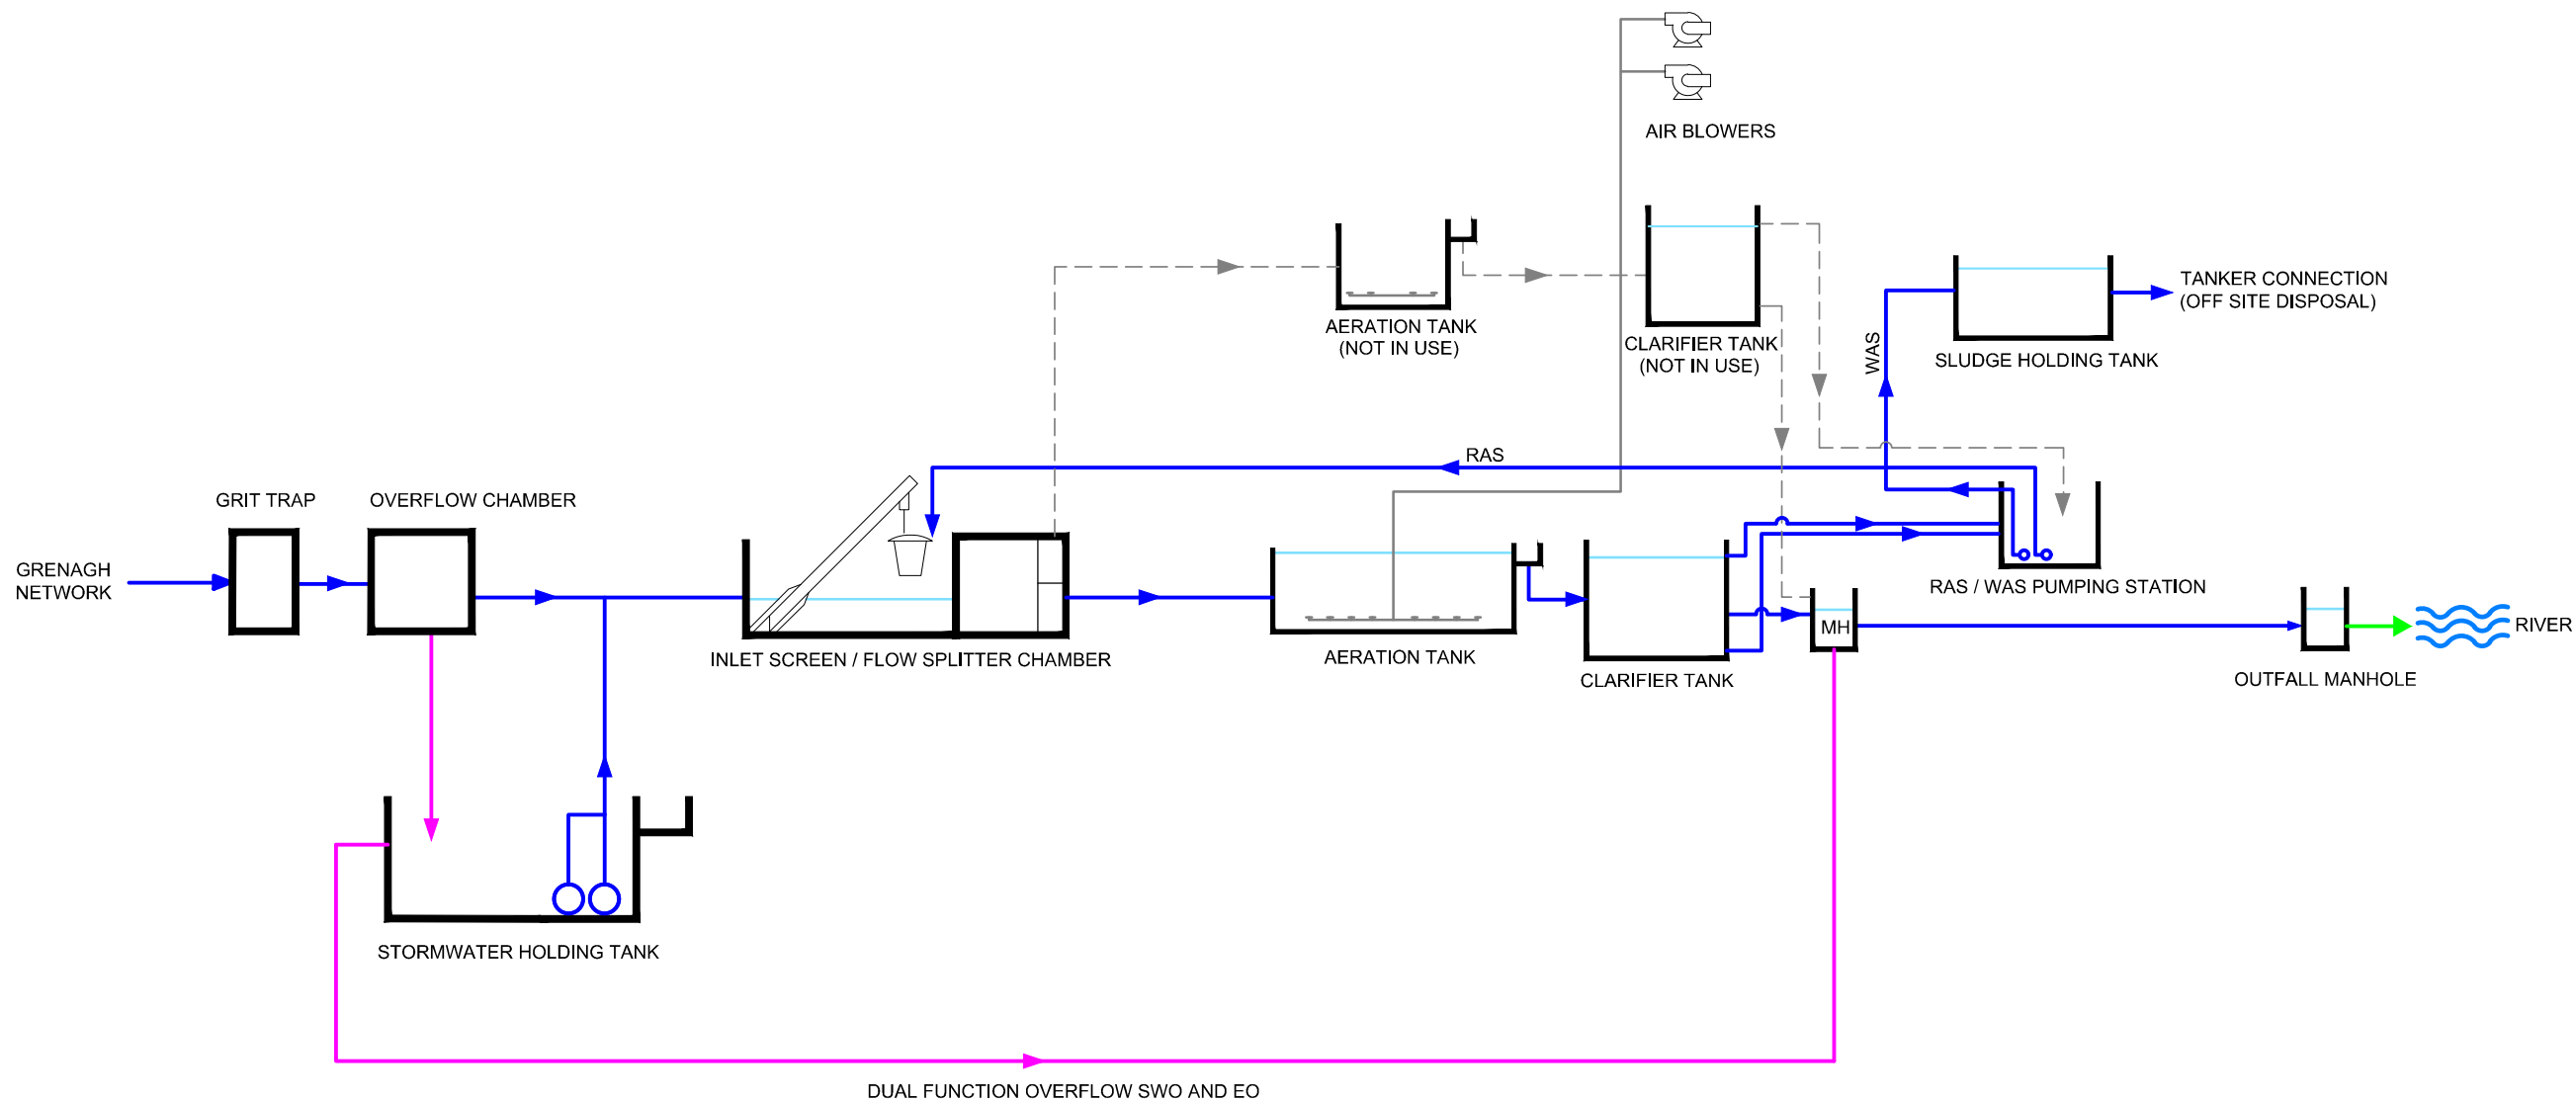

SIGNED : _____

PRINT NAME : _____

POSITION : _____

DATE : _____

FOR IRISH WATER

REV	DATE	DESCRIPTION	D	C	A

DISCHARGE LICENCE

CLIENT: **IRISH WATER**
 Colville House,
 24-26 Talbot Street,
 Dublin 1.
 Tel. 1890 278 278 Web. www.water.ie

PROJECT: **GRENAGH WASTEWATER DISCHARGE LICENCE APPLICATION**

TITLE: **WASTE WATER PROCESS FLOW DIAGRAM**

SCALES: N.T.S.	DRAWN: A. McIntyre
CAD REFERENCE: 20893-NOD-WWDL-09	DATE: 19.08.2022
ATTACHMENT: B.2.3	REV: -