


IF IN DOUBT ASK.

All dimensions to be checked on site by contractor prior to fabrication or agreed with ABP Development.

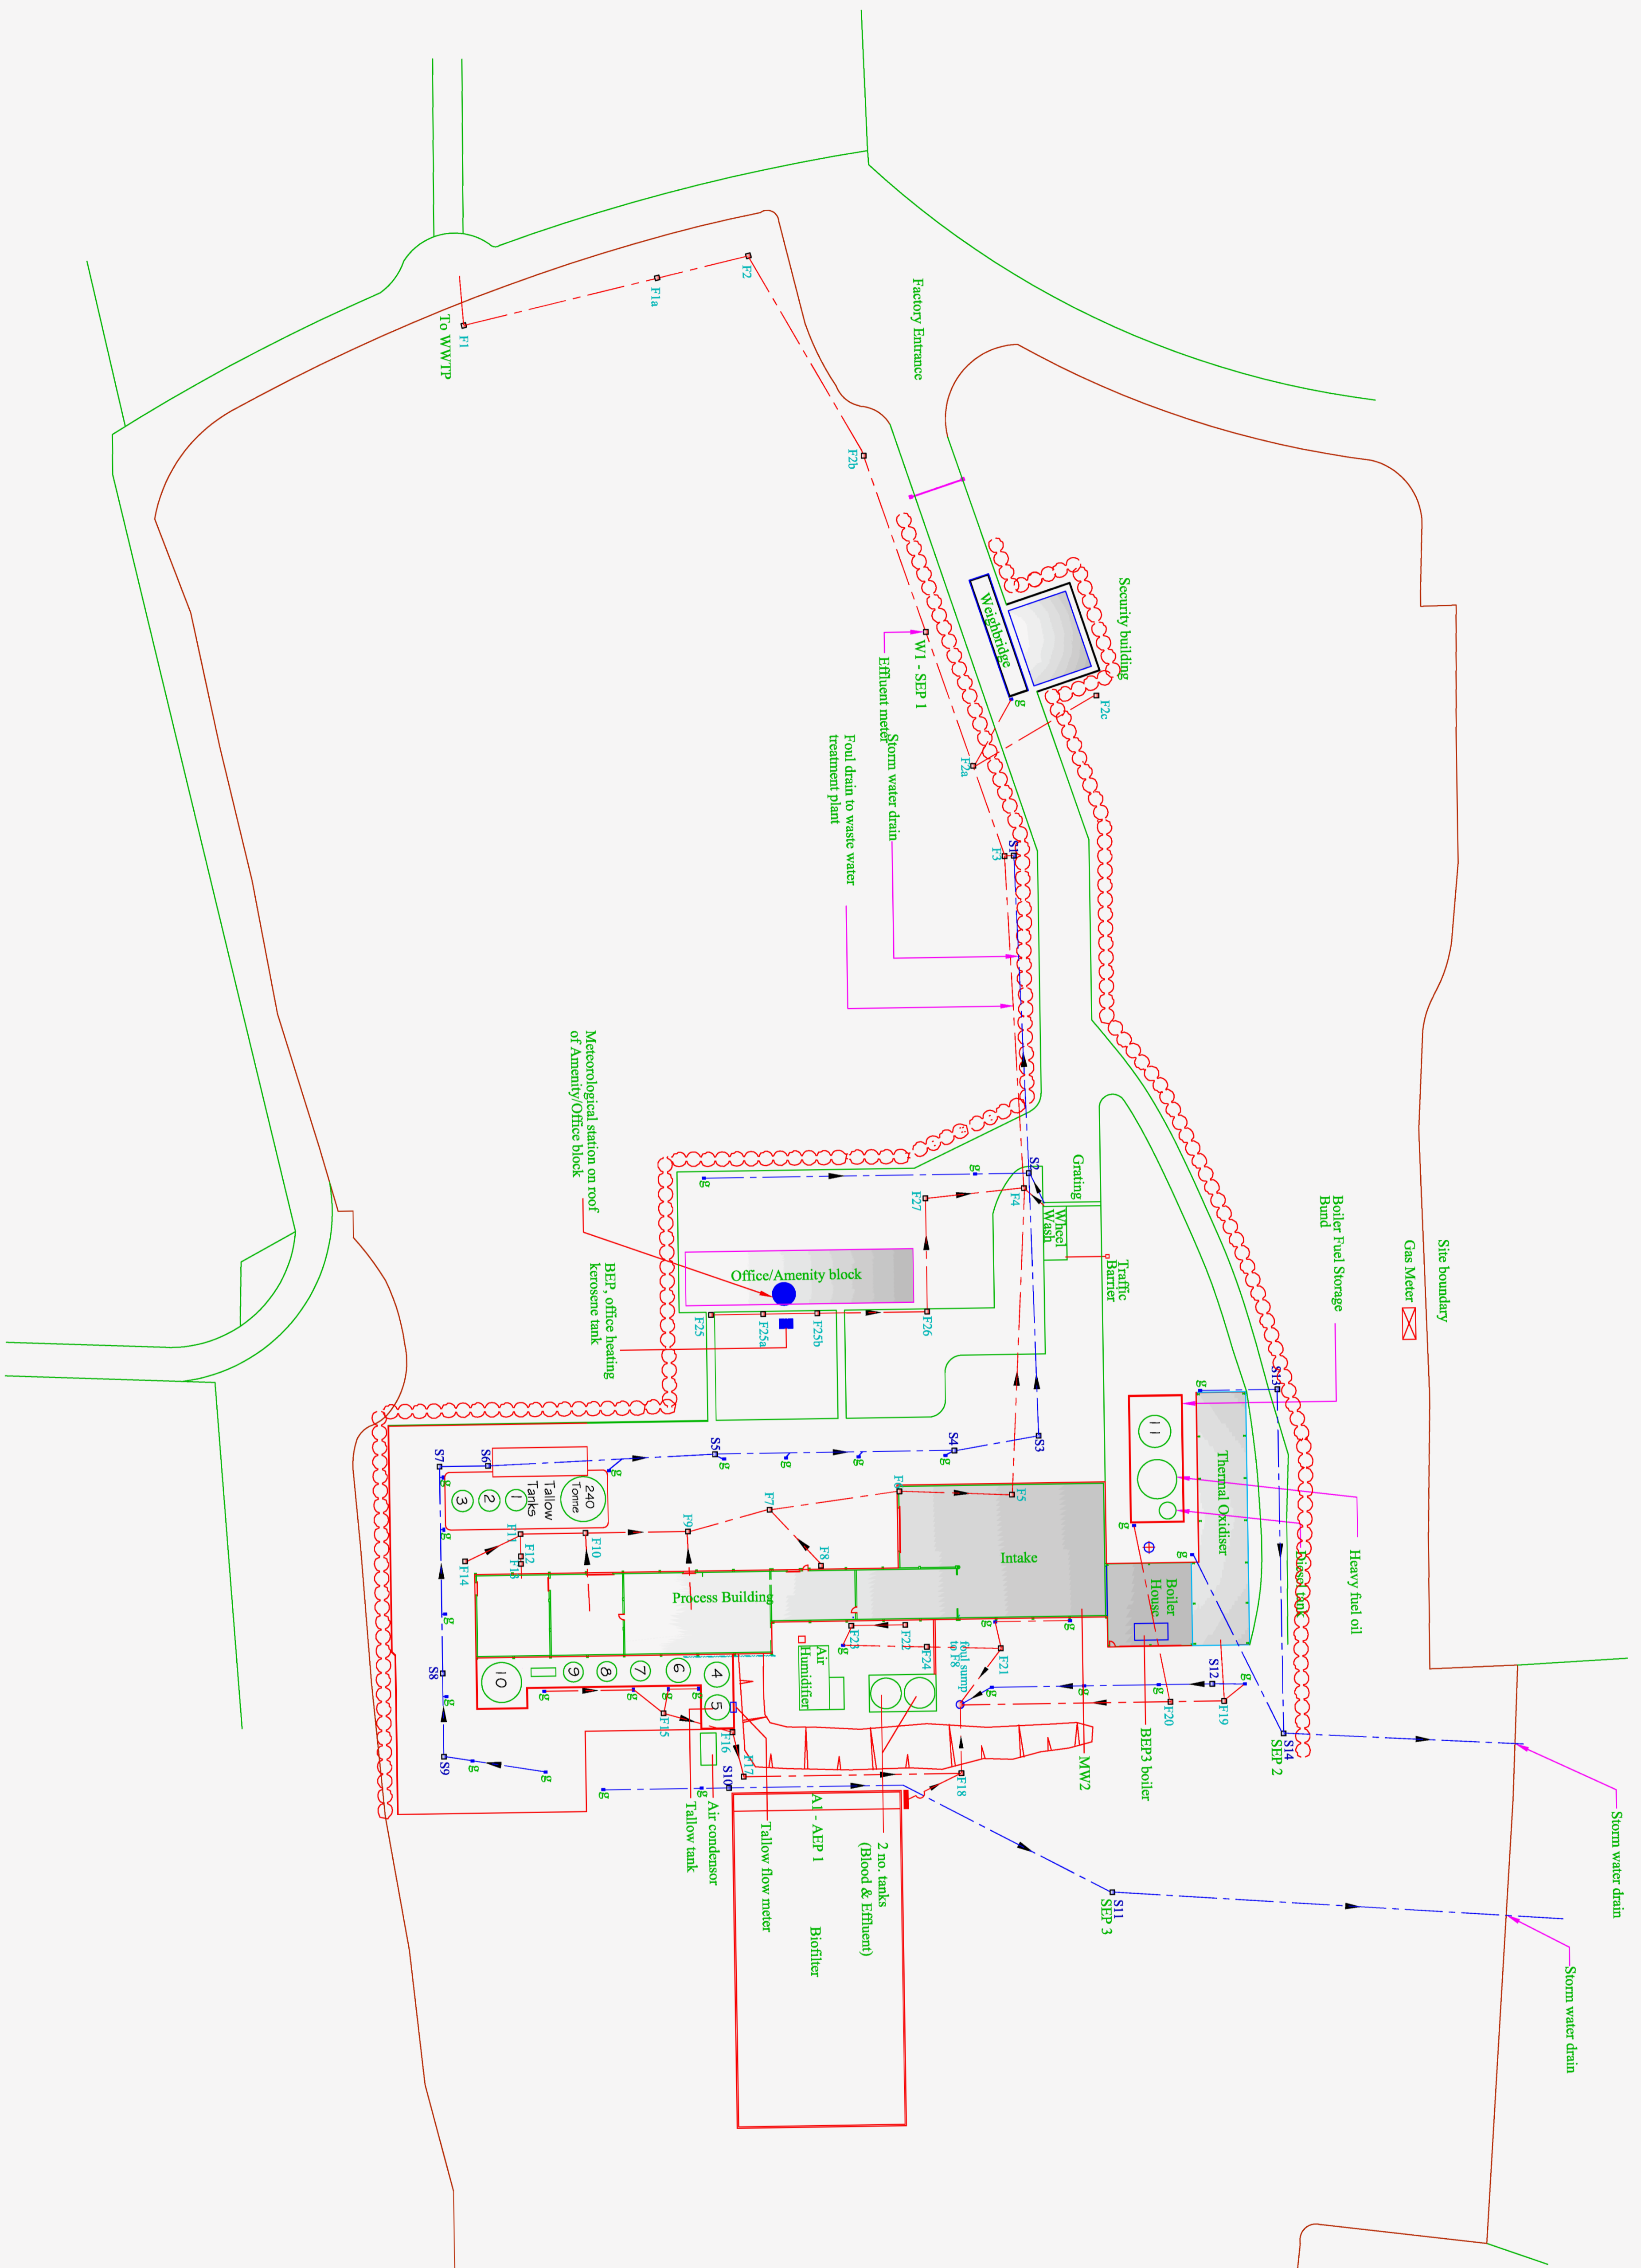

Rev.	Date	Description
A	Jan 10	Corrections to sewer lines
B	11/10/10	General revisions
C	13/9/12	General revisions
D	18/3/15	General revisions
E	29/6/15	Annotations revised
F	9/5/16	Added manholes 25g and 25b
G	7/2/17	Revised annotations

**ABP DEVELOPMENT**  
 John Sheel  
 Project Manager  
 2000  
 Waterford  
 Ireland.  
 Tel : 041-6856100  
 Fax : 041-6856136

Project: Waterford Proteins  
 Waterford

Title	
Updated Drainage Layout	
Scale : 1:500	Dwg no
Drawn : P.McQ.	WP/06/137
Date : Oct '06	Rev. F