


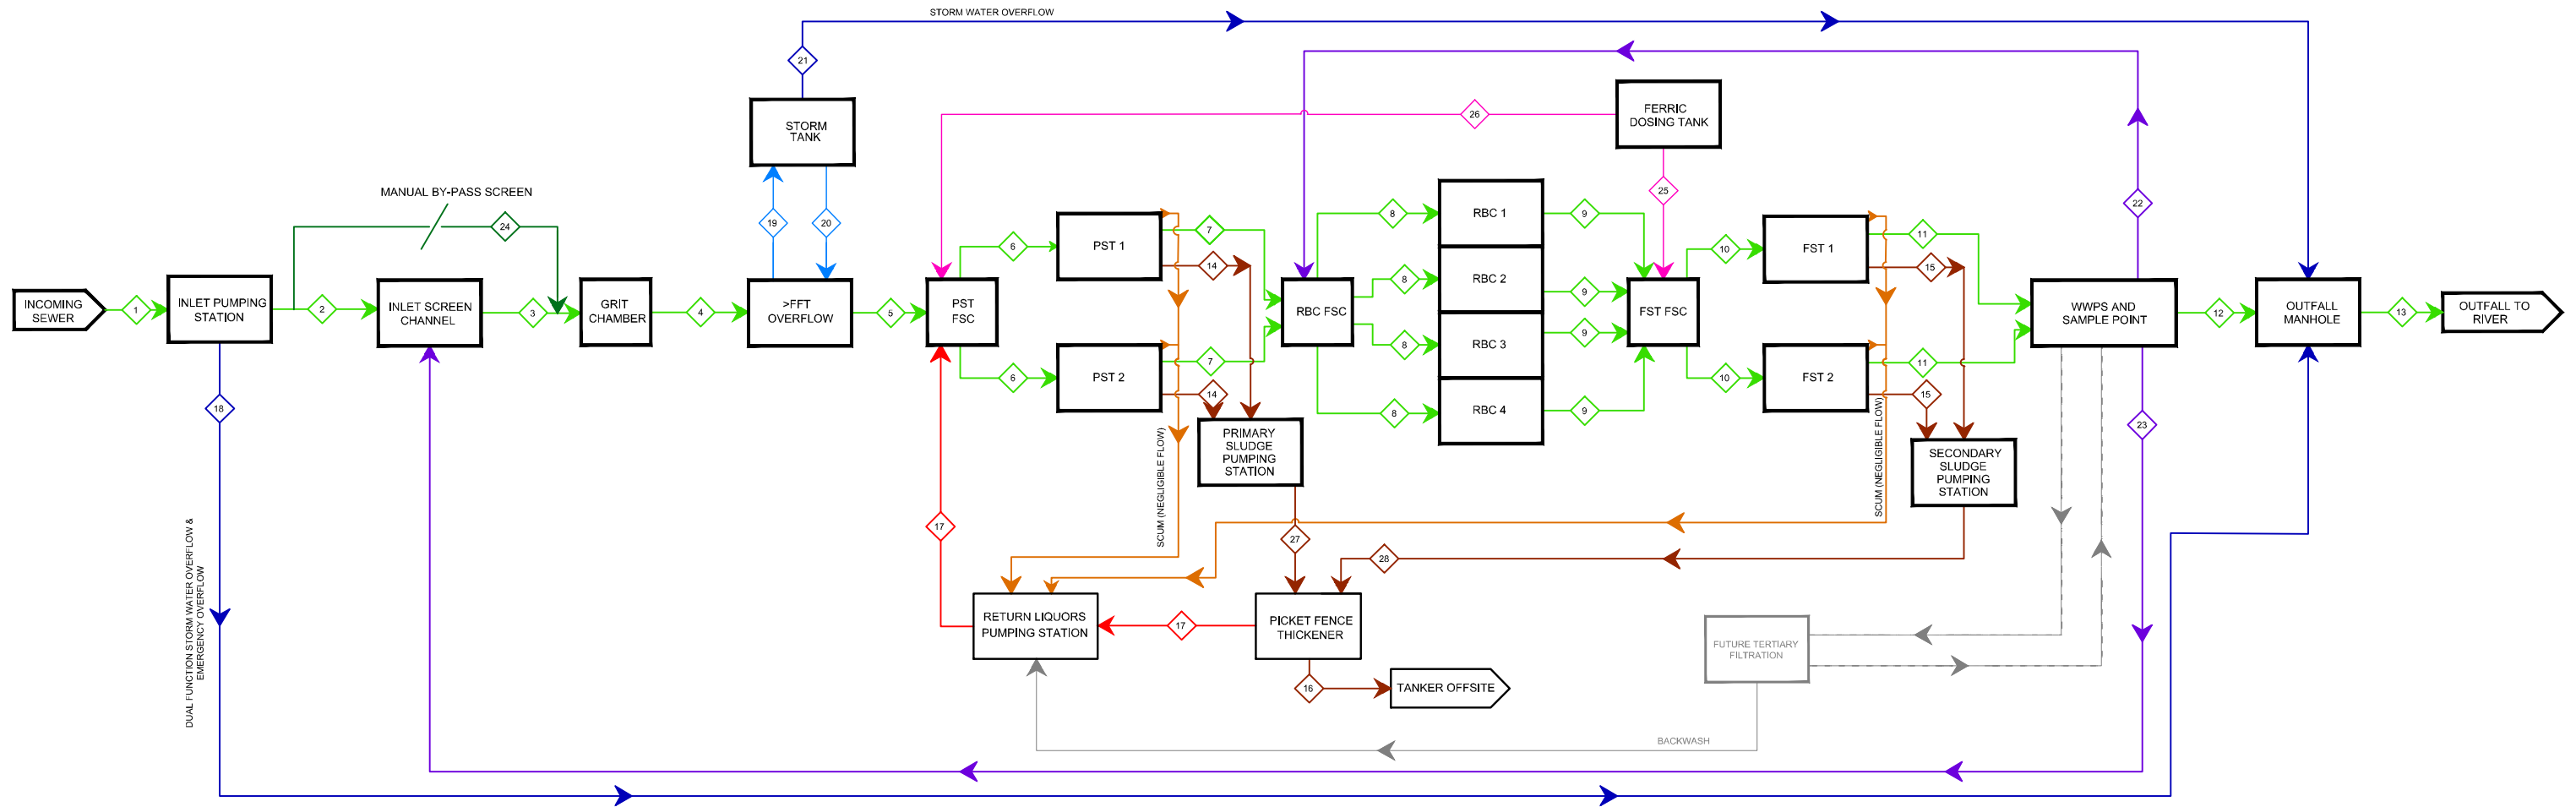

ATTACHMENT B.2.3:
WASTE WATER PROCESS FLOW DIAGRAM

LEGEND

- PROCESS STREAM
- BYPASS
- WASH WATER
- STORM
- EMERGENCY OVERFLOW
- SLUDGE
- SCUM
- WORKS LIQUORS
- CHEMICAL



REV.	DATE	DESCRIPTION	D	C	A

DISCHARGE LICENCE

CLIENT: **UISCE ÉIREANN**
 Cabhill House,
 24-26 Talbot Street,
 Dublin 1.
 Tel. 1890 278 278 Web. www.water.ie

PROJECT: **COACHFORD WASTE WATER DISCHARGE LICENCE APPLICATION**

TITLE: **WASTE WATER PROCESS FLOW DIAGRAM**

SCALES: NTS	DRAWN: D.Rimdzius
CAD REFERENCE: 20918-NOD-WWDL	DATE: 21/09.2022
ATTACHMENT: B.2.3	REV: -

SIGNED: _____

PRINT NAME: _____

POSITION: _____

DATE: _____

FOR UISCE ÉIREANN