


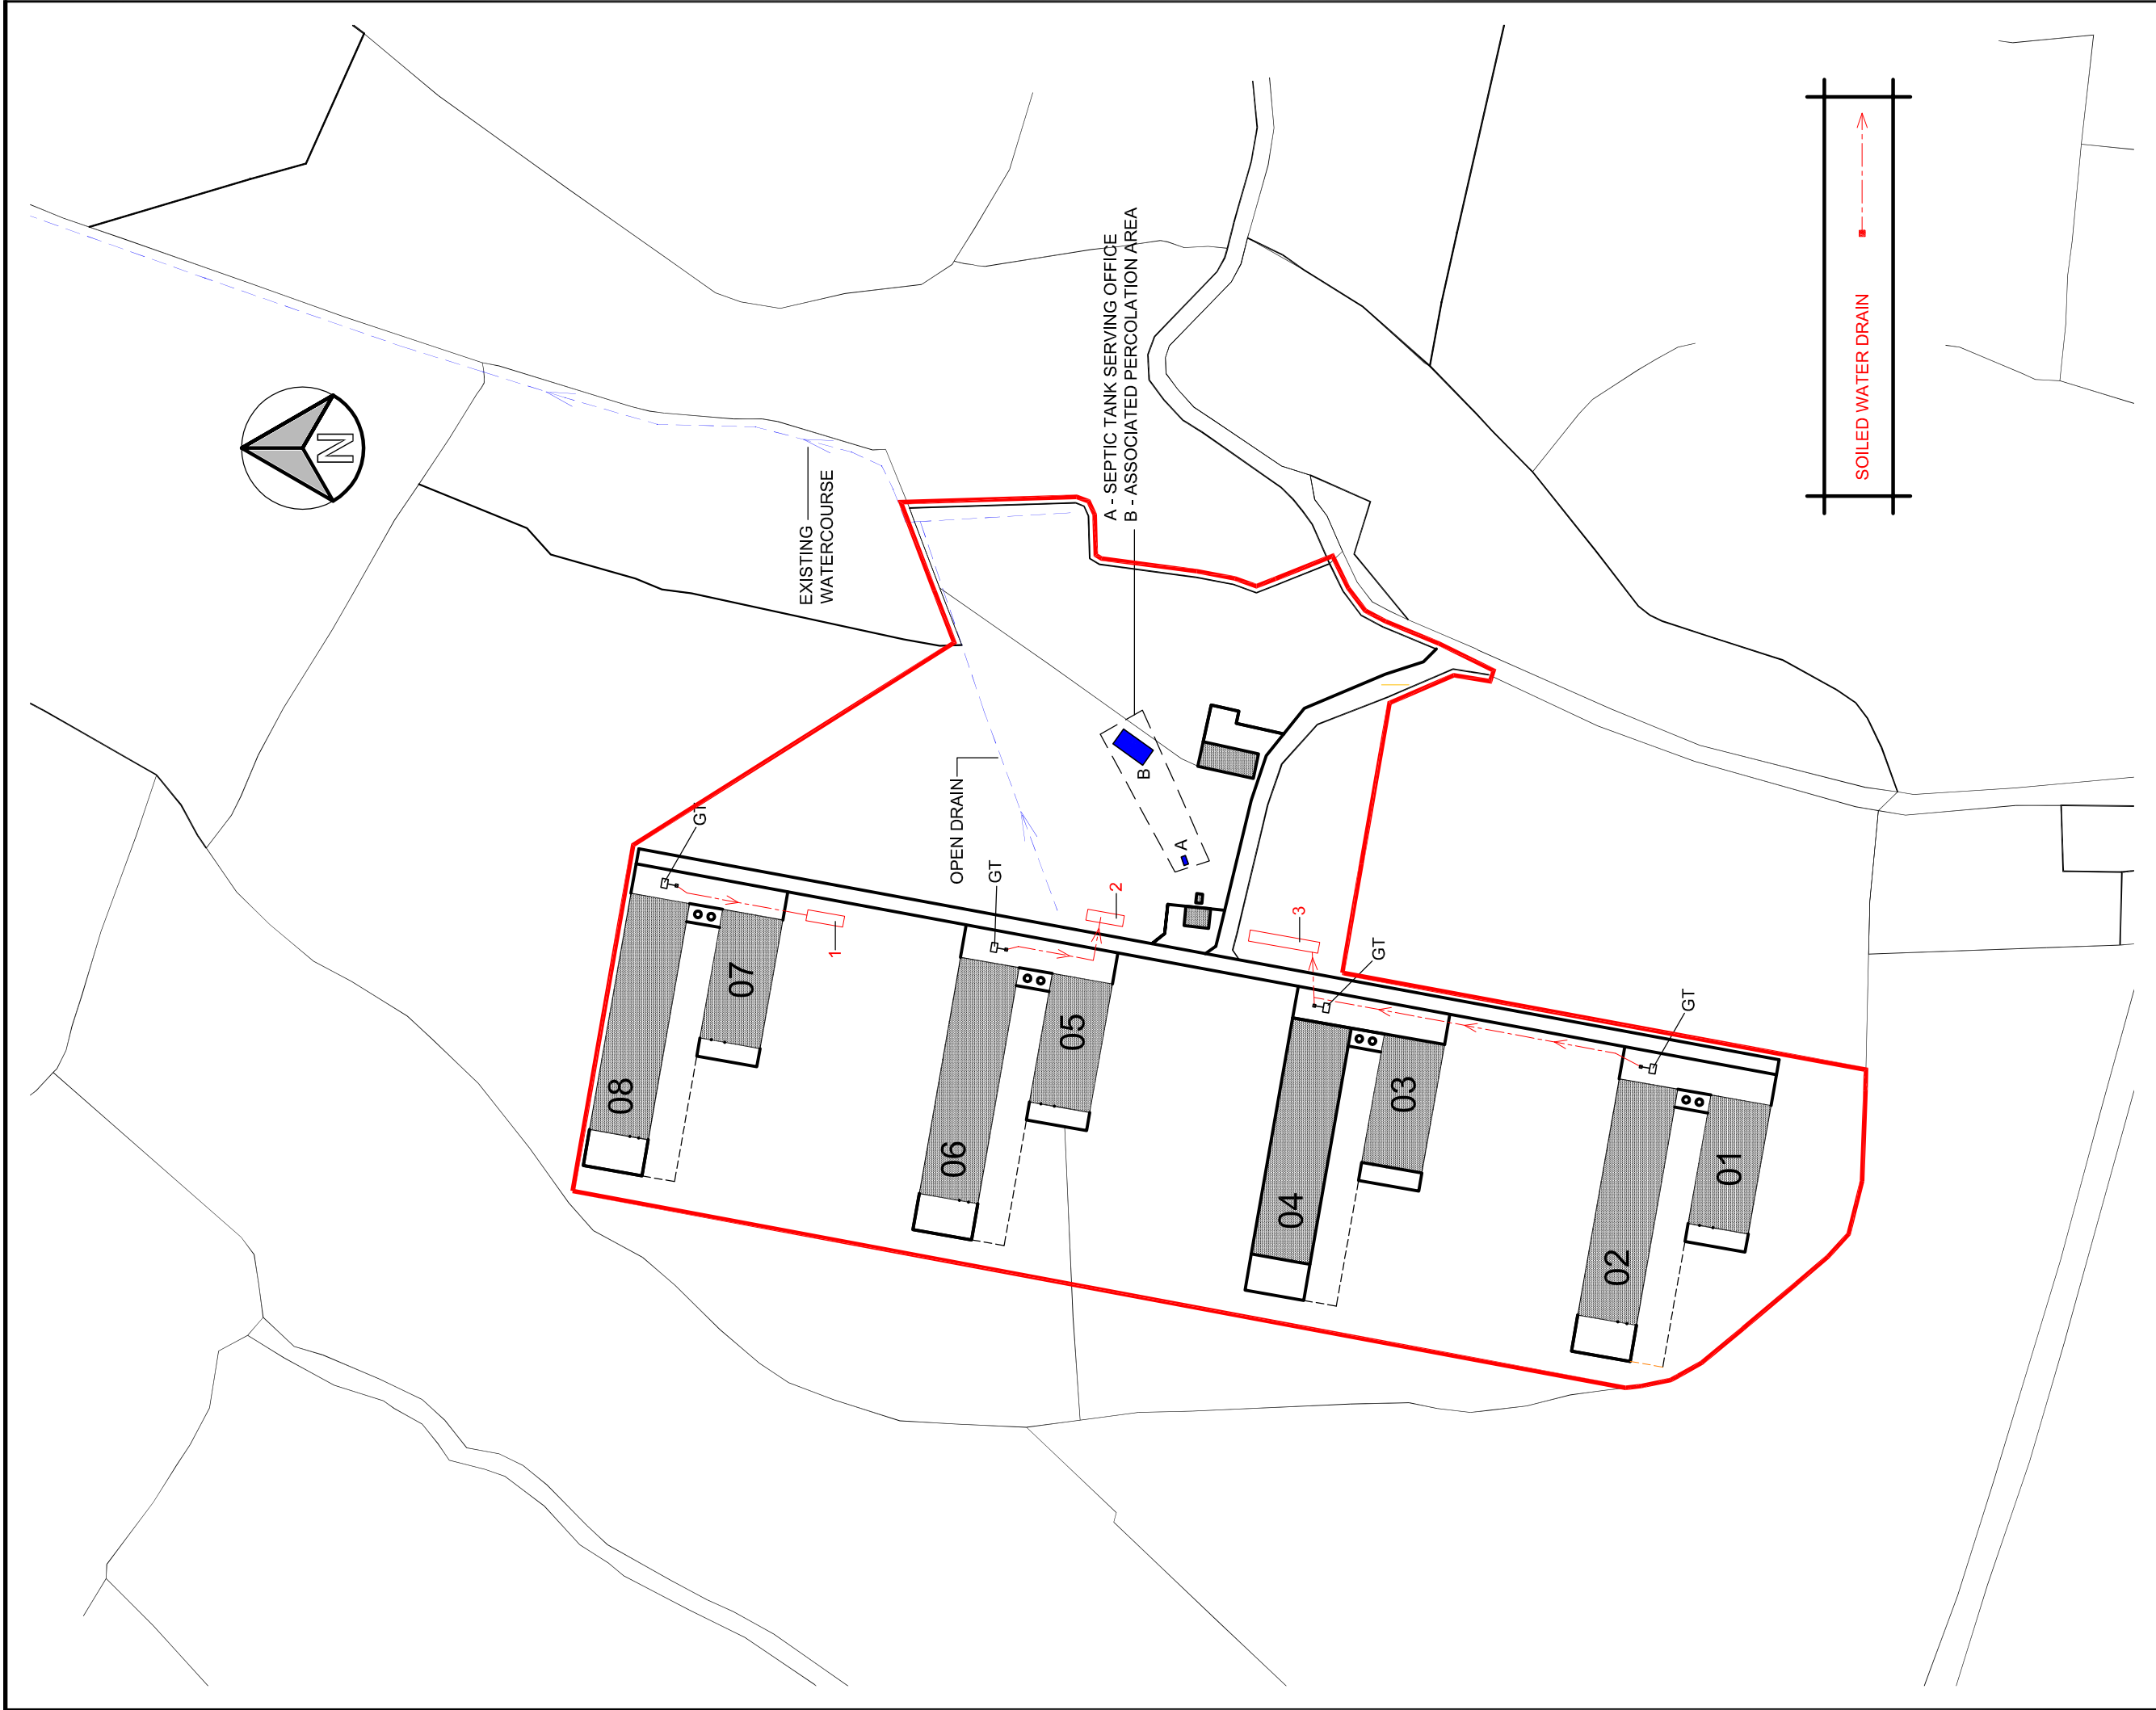

CERES CONSULTING Agricultural & Environmental Consultants Barleyfield, Kilbrittain, Co. Cork. Phone: 023 88 49000 email: info@ceres.ie		EPA IPPC licence Application		LICENCE APPLICATION	
Project:		Dwg title: SITE PLAN - SOILED WATER DRAINAGE		Date: MARCH 2024	Scale: 1:2000 @ A3
Client(s): ENFIELD BROILER BREEDERS LTD.		Drawn by: R.R.		Chkd by:	
Address: GORTEEN, BROADFORD, CO. LIMERICK, P56 VH76		Dwg No. BFIELD-2024-105		Rev: E	